


2 PARTIAL SECOND FLOOR PLAN - POWER
SCALE: 1/4"=1'-0"

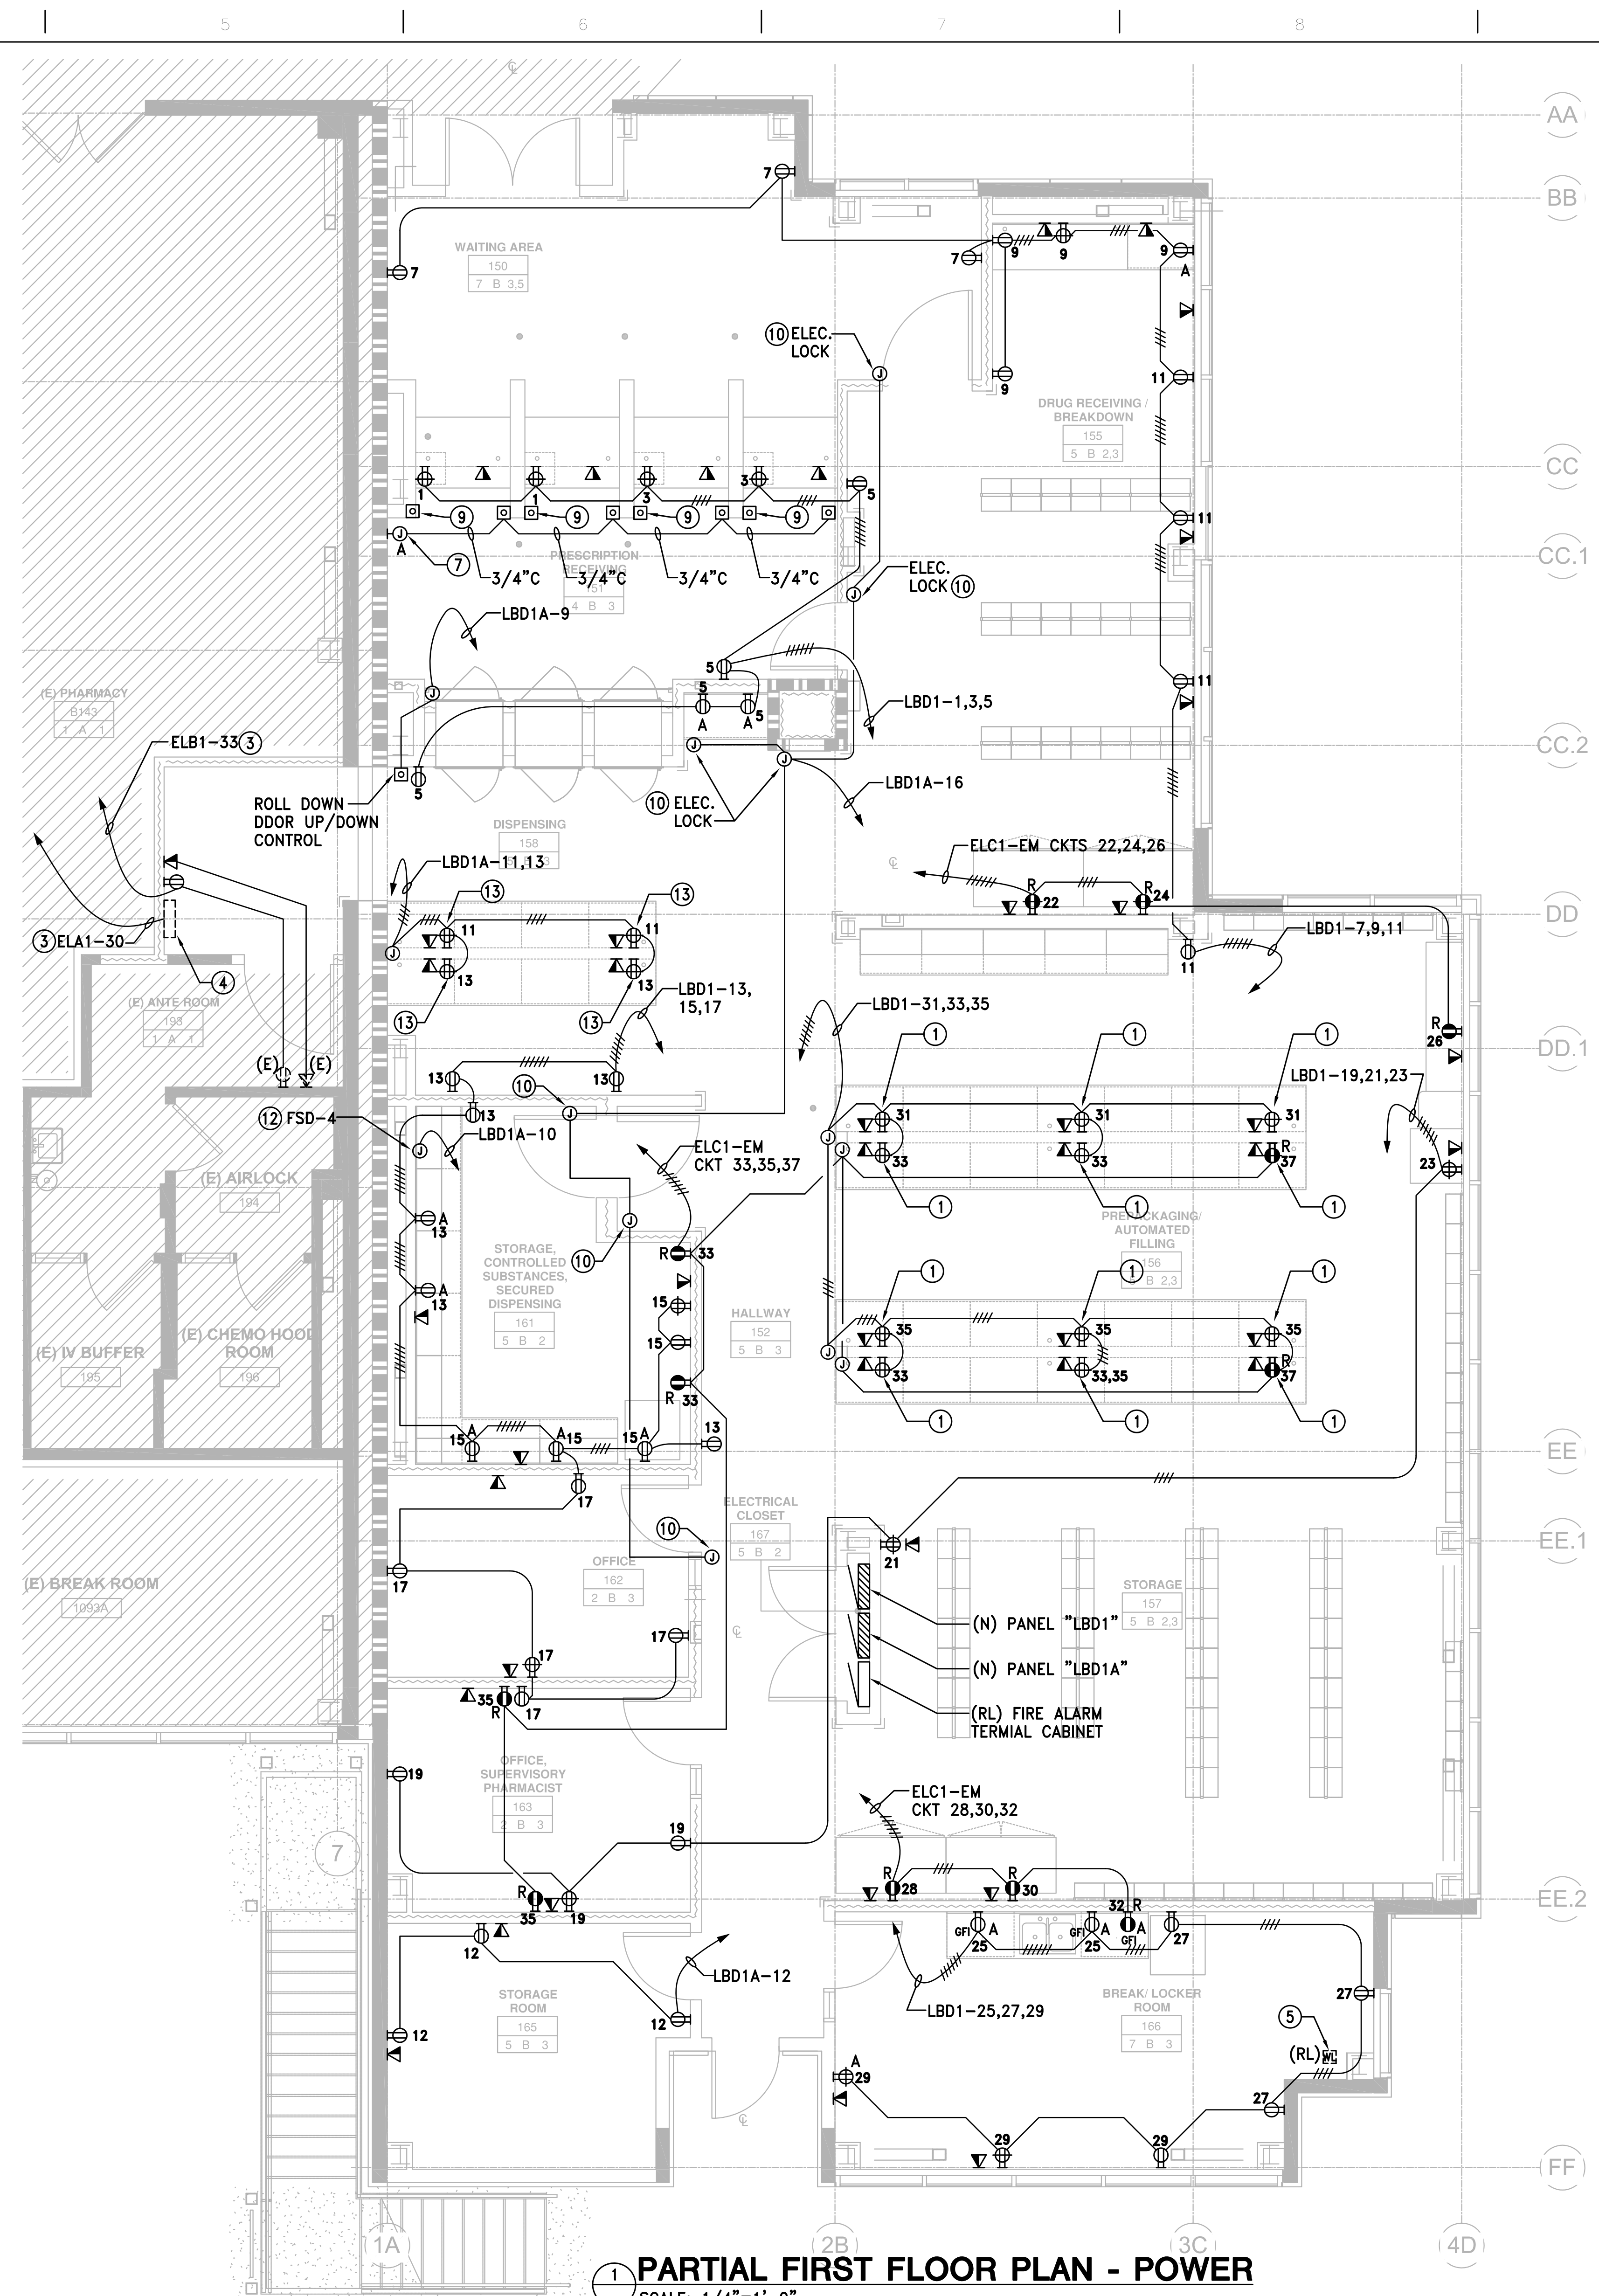

1 PARTIAL FIRST FLOOR PLAN - POWER
SCALE: 1/4"=1'-0"

- SHEET NOTES**
- PROVIDE (3) FOURLEX RECEPTACLES AND (3) TEL/DATA OUTLETS ON EACH SIDE OF THE COUNTER. COORDINATE WITH ARCHITECT FOR LOCATIONS.
 - FIELD VERIFY MOUNTING LOCATION.
 - RECONNECT EXISTING CIRCUIT TO NEW LOCATION OF EXISTING DEVICE OR NEW OUTLET.
 - RECONNECT POWER TO (E) DDC PANEL. FIELD VERIFY LOCATION.
 - CEILING MOUNT WIRELESS DEVICE. COORDINATE WITH VA COR FOR EXACT LOCATION AND REQUIREMENTS.
 - PROVIDE 1 1/4" C WITH PULL WIRE AND STUB-UP TO ACCESSIBLE CEILING SPACE FOR CCTV CAMERA.
 - PROVIDE 1 1/4" C WITH PULL WIRE AND STUB-UP TO ACCESSIBLE CEILING SPACE FOR BINGO DISPLAY SIGN.
 - AREA ALARM CONTROL PANEL. SEE MECHANICAL FOR LOCATION AND REQUIREMENTS.
 - REMOTE WIRELESS PANIC BUTTON. FIELD VERIFY LOCATION AND REQUIREMENTS WITH VA.
 - PROVIDE CONDUIT AND POWER AS REQUIRED. VERIFY ELEC LOCK LOCATION.
 - FIELD VERIFY NURSE CALL SYSTEM LOCATION. SEE DETAIL 9/ES7-1 AND SPEC SECTION 27 52 23 FOR REQUIREMENTS. PROVIDE 1 1/4" C FROM NURSE CALL JUNCTION BOX UP TO ACCESSIBLE CEILING SPACE.
 - CONNECT TO FIRE SMOKE DAMPER. COORDINATE WITH MECHANICAL FOR EXACT LOCATION AND REQUIREMENTS.
 - PROVIDE (2) FOURLEX RECEPTACLES AND (2) TEL/DATA OUTLETS ON EACH SIDE OF THE COUNTER. COORDINATE WITH ARCHITECT FOR LOCATIONS.
 - VERIFY NURSE CALL PULL STATION AND DOME LIGHT LOCATIONS. SEE ES7.1
 - FIELD VERIFY FLOOR OUTLET LOCATION.

CONSULTANTS: FW ASSOCIATES, INC. CONSULTING ENGINEERS 330 FRANKLIN, SUITE 400, OAKLAND, CA 94607 PHONE: (510) 763-7475 FAX: (510) 763-7033		KEY PLAN 		ARCHITECT/ENGINEERS: MEI ARCHITECTS 239 9TH STREET SAN FRANCISCO, CA 94103 T: 415.703.0328 F: 415.707.0328 www.meiarchitects.com		Drawing Title FIRST FLOOR & SECOND FLOOR PLANS - POWER		Project Title VA Martinez - Remodel Vacated Mental Health Space, Replace Exterior Panels, Building 19 OPC		Project Number 612-12-224FCA		Office of Facilities Management
Approved: Project Director		Location VANCHCS - Martinez, CA		Building Number 19		Drawing Number ES3-1		Date January 30, 2015		Checked Drawn		
Revisions:		Date		Dwg. -- of --		Dwg. -- of --		Dwg. -- of --		Dwg. -- of --		