

GENERAL SHEET NOTES

- COORDINATE EXACT LOCATIONS OF LIGHT FIXTURES WITH ARCHITECTURAL REFLECTED CEILING PLAN.

SHEET KEYNOTES

- SWITCHING FOR EXAM LIGHT FUNCTION OF MULTI-FUNCTION EXAM LIGHT.
- SWITCHING FOR CHART LIGHT FUNCTION OF MULTI-FUNCTION EXAM LIGHT.
- CORRIDOR AND COMMON AREA LIGHTING SHALL HAVE TWO LEVEL SWITCHING AND FIXTURES EQUIPPED WITH TWO BALLASTS OR 50% STEP DIMMING DRIVERS.
- EXISTING EXIT SIGN TO BE REMOVED, CLEANED, RELAMPED AND RE-INSTALLED.
- ALL CEILING MOUNTED OCCUPANCY SENSORS SHALL BE LOCATED 3'-0" AWAY FROM SUPPLY AIR DIFFUSERS.
- CONTRACTOR SHALL REMOVE, PROTECT, TIE-UP, AND REINSTALL ANY LIGHTING FIXTURES OR OTHER CEILING MOUNTED APPURTENANCES TO FACILITATE CONSTRUCTION OPERATIONS THIS AREA


COORDINATION DRAWINGS

SEE COVER SHEET FOR COORDINATION NOTES.

SYMBOLS LEGEND


- EXISTING WALL, DOOR, WINDOW, MILLWORK, FIXTURE OR OTHER FIXTURE OR ASSEMBLY TO BE REMOVED.
- EXISTING WALL, DOOR, WINDOW, MILLWORK, FIXTURE OR OTHER FIXTURE OR ASSEMBLY TO REMAIN.
- NEW WALL (TYPE C3 UON)
- 1-HOUR RATED FIRE BARRIER (TYPE C3R UON)
- SMOKE PARTITION (TYPE C3S UON)
- PROJECT LIMITS
- NO PIPING OR DUCTWORK SHALL BE ROUTED THROUGH ELECTRICAL AND/OR DATA ROOMS.
- EXISTING CONCRETE COLUMN

KEYPLAN

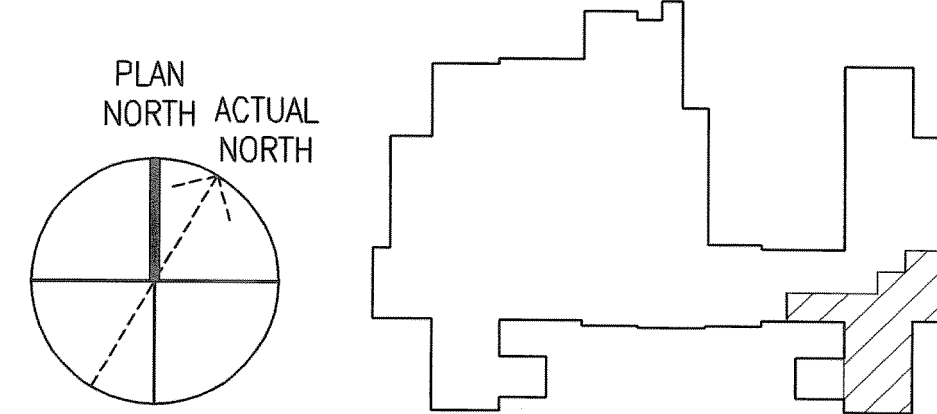

F3 THIRD FLOOR PLAN - LIGHTING

 
SCALE: 1/4" = 1'-0"



REVISION NO.	REVISION DESCRIPTION	By	Date
1			
2			
3			
4			
5			
6			
7			
8			
9			
10			



Department of Veterans Affairs
Veterans Healthcare System of the Ozarks
1100 North College Avenue
Fayetteville, AR 72703

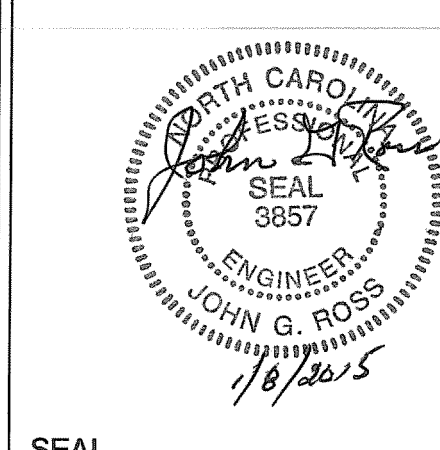

Architect/Engineer Address
HARRELL
DESIGN GROUP, P.C.
2816 TOWER POINT DRIVE
CHARLOTTE, NC 28227
P 704.814.1330
F 704.521.0833
WWW.HARRELLDC.COM
COPYRIGHT © 2014 HARRELL DESIGN GROUP, PC
HDC PROJECT # 14001

APPROVALS:	
CHEF OF ENGINEERING	

Drawing Title THIRD FLOOR PLAN - LIGHTING
FULLY SPRINKLERED
100% FINAL CONSTRUCTION DRAWINGS

Project Title		
RENOVATE 3B CLINIC FOR STEP-DOWN, B1		
Drawn MLT	Building Number 1	AutoCAD File Name
Checked	Reviewed	Const. Contract No.

Date 1/8/2015
Project Number 564-14-102
DRAWING No. EL101

