


100% CONSTRUCTION DOCUMENT SUBMITTAL

## NEW FLOOR PLAN

SCALE: 1/4" = 1'-0"

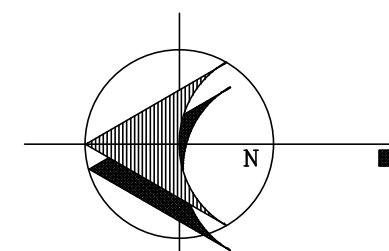






---


SHEET NOTES

- 1 ONE HOUR OCCUPANCY SEPARATION WALL

## LEGEND

- |   |  |
|---|--|
|  | FIRE EXTINGUISHER                                      |
|  | EXIT SIGNS WITH EMERGENCY LIGHTING<br>SEE SHEET AE-600 |
|  | FIRE ALARM   |
|  | 1 HOUR SEPARATION WALL                                 |
|  | PATH OF EGRESS   |

## KEY MAP

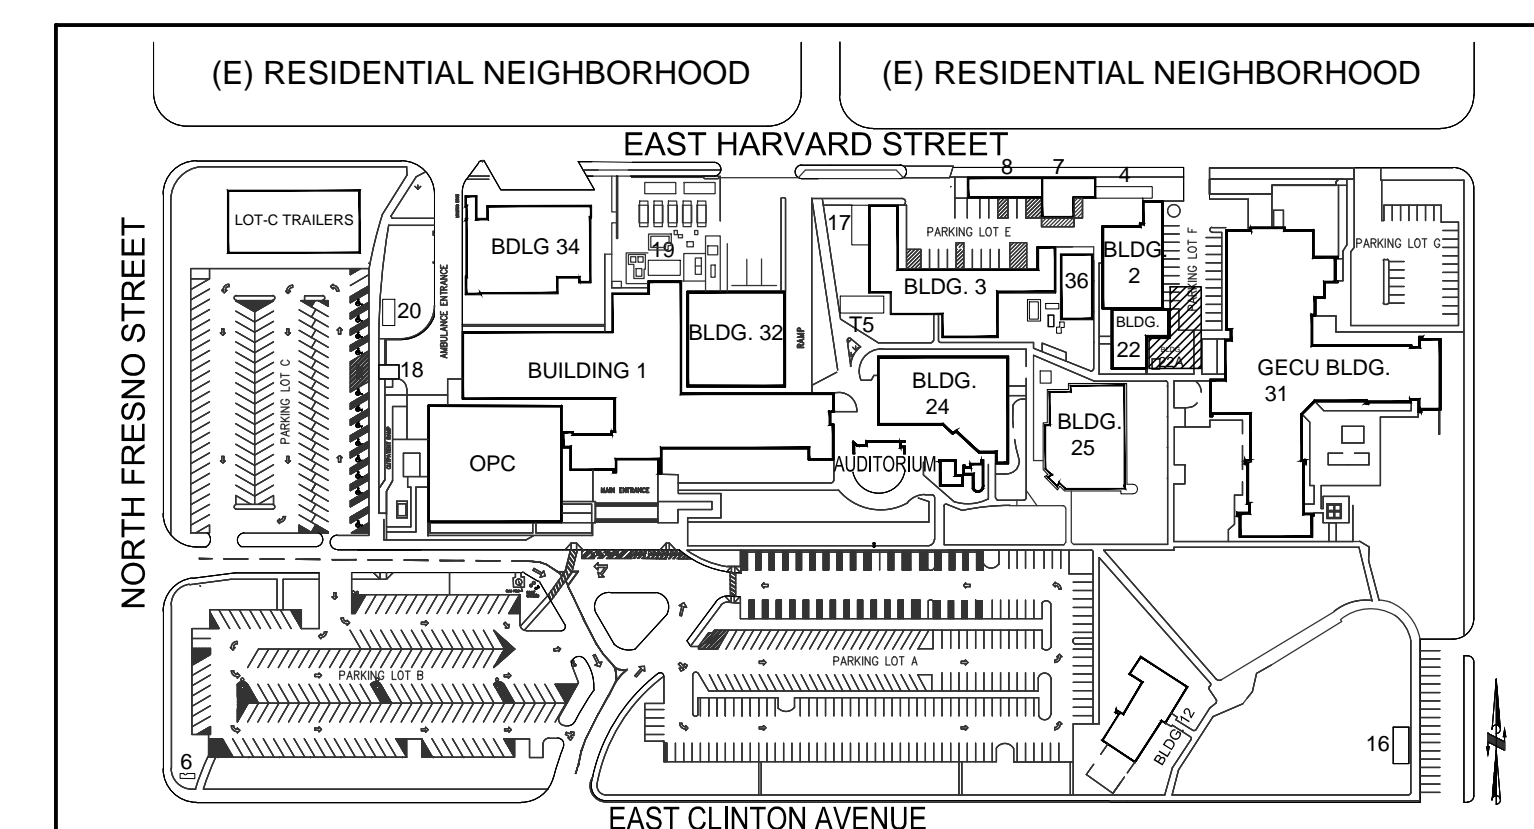[illegible]

## CONSULTANTS:

## ARCHITECT/ENGINEERS:



**hfp architects**  
745 distel drive  
los altos, ca 94022  
650 964 4514 fax: 650 967 5148



Drawing Title	FIRE LIFE SAFETY PLAN
---------------	-----------------------

Approved: Project Director

Project Title	VA CENTRAL CALIFORNIA HEALTH CARE SYSTEM NEW BUILDING 22A + CHILLER INFRASTRUCTURE
---------------	---

Location	FRESNO, CA.
----------	-------------

Date  
5/08/2015

Checked	N.V.
---------	------

Drawn  
T.S.

Project Number	570-13-300
Building Number	22A
Drawing Number	AE-602
Dwg. 33 of 8	

Office of  
Construction  
and Facilities  
Management

