


three inches = one foot
one and one half inches = one foot
one inch = one foot
three quarters inch = one foot
three eighths inch = one foot
one quarter inch = one foot
one eighth inch = one foot
one sixteenth inch = one foot

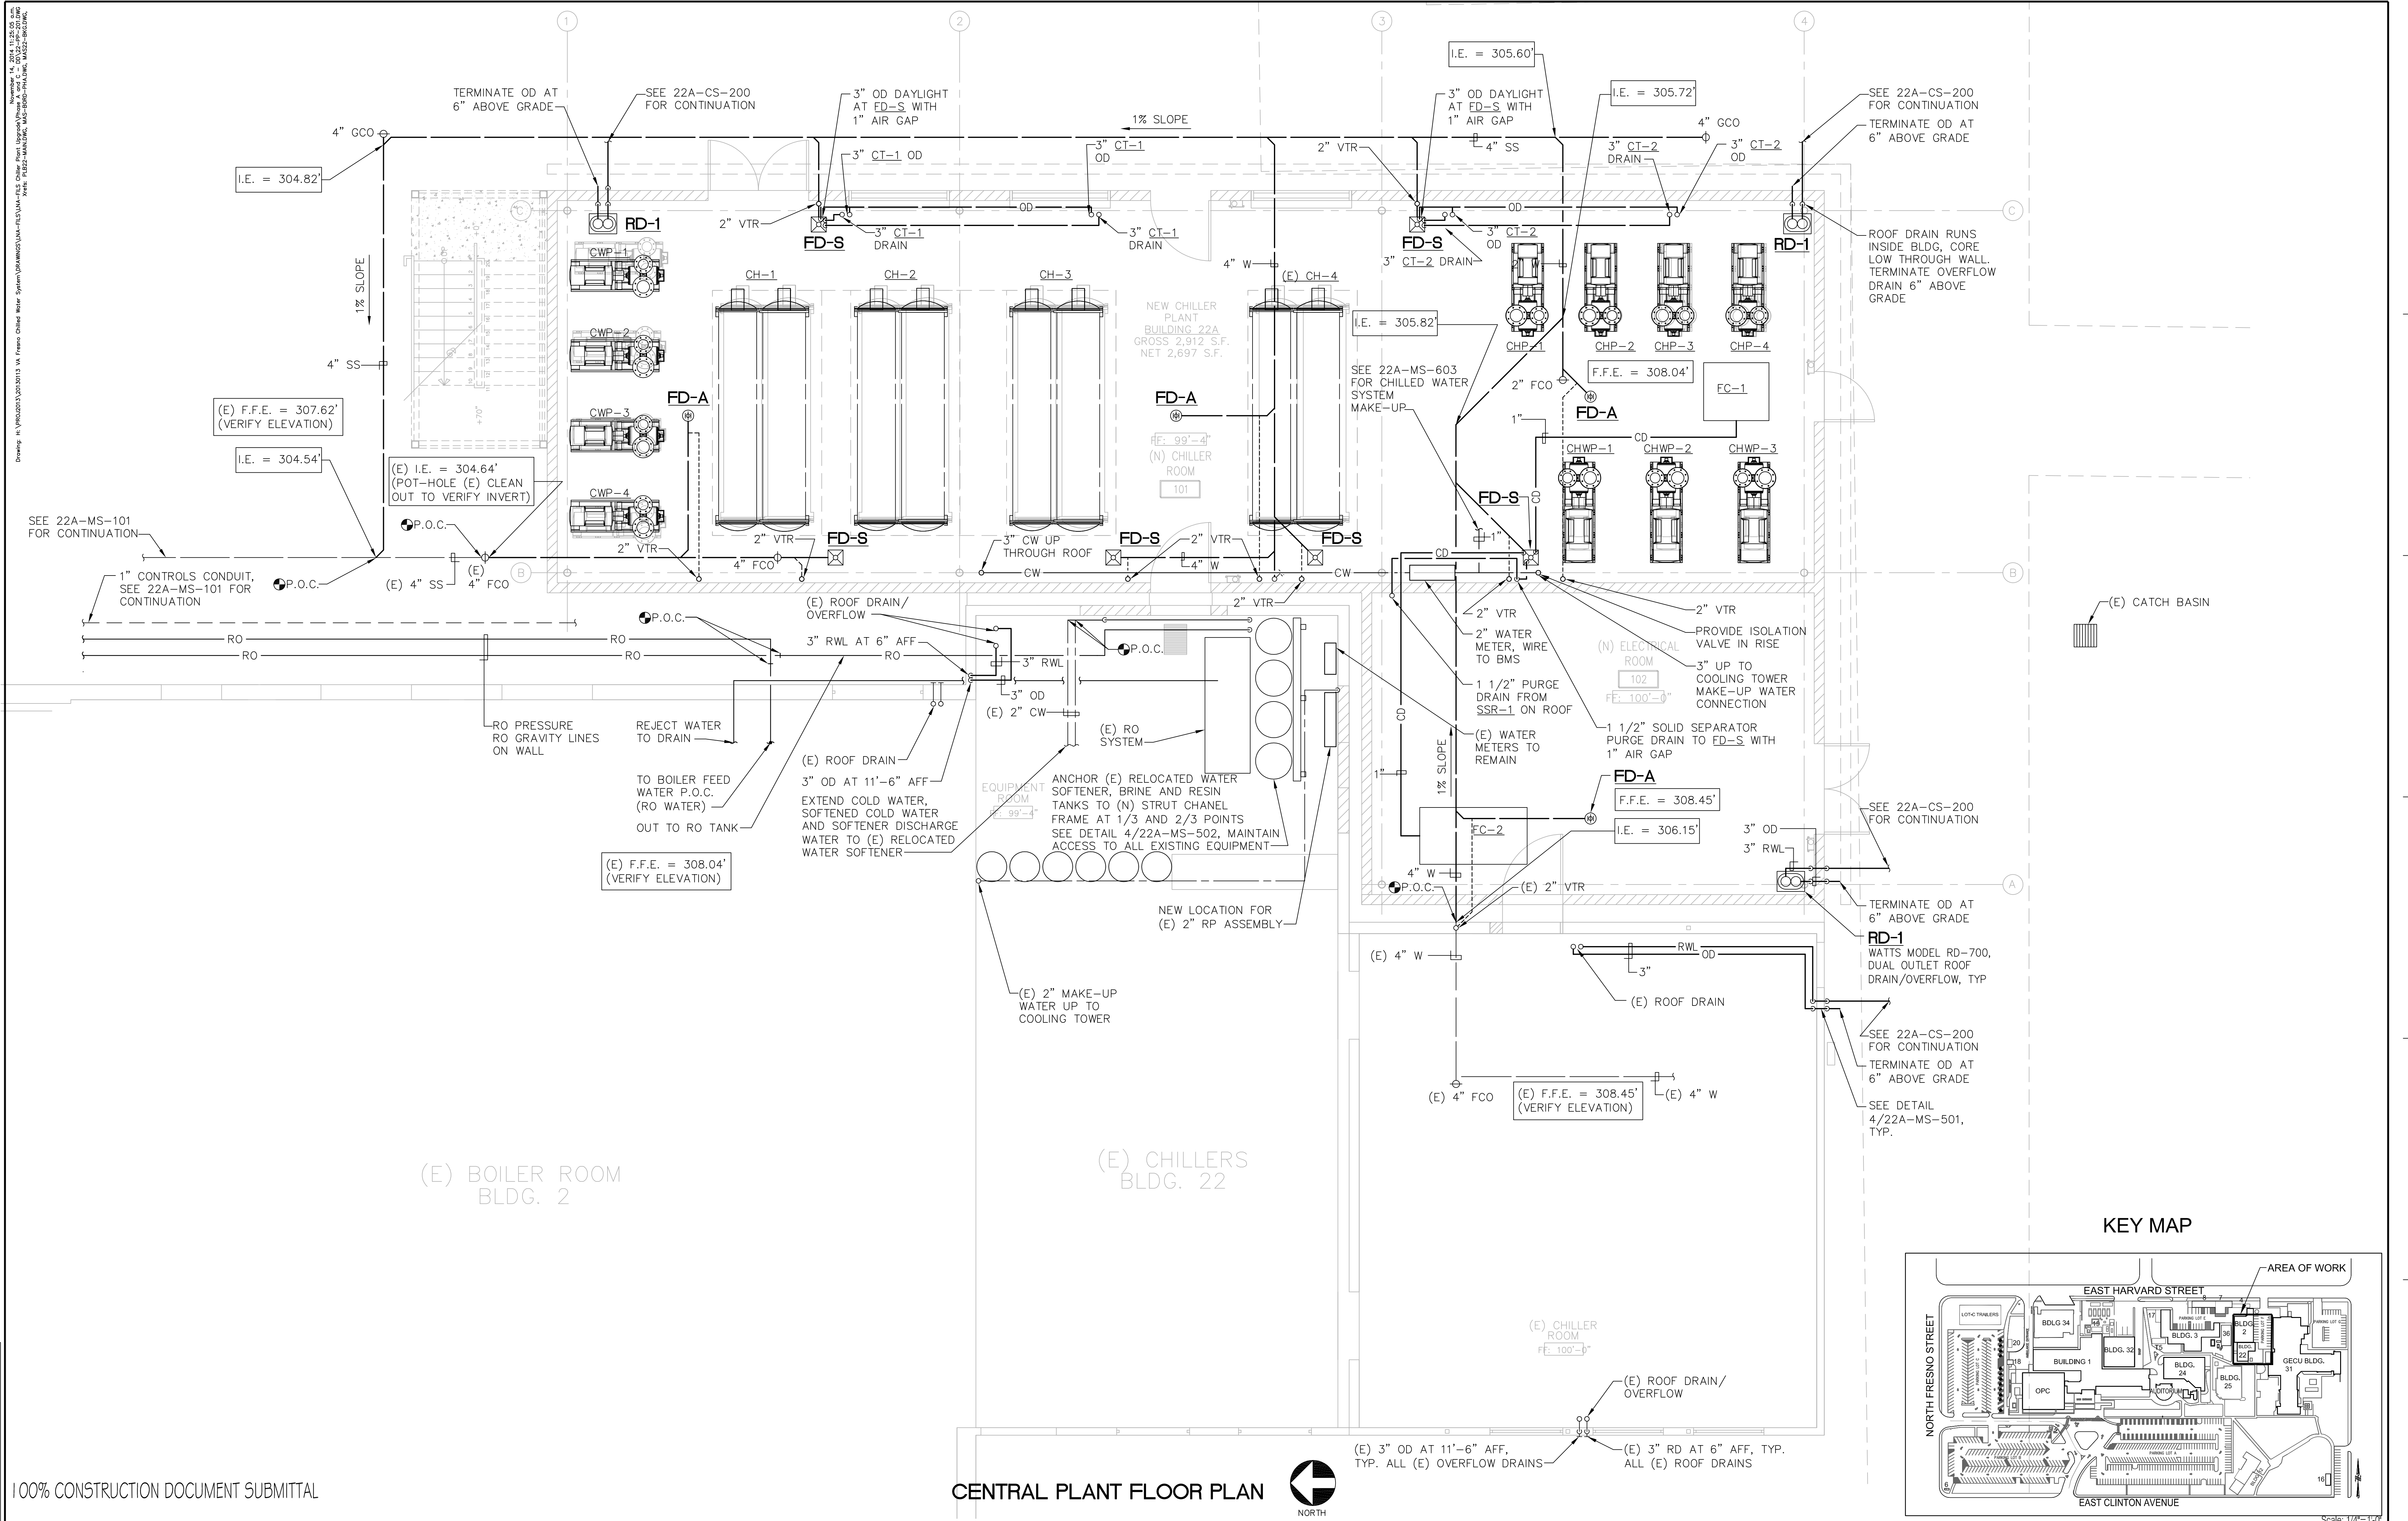

100% CONSTRUCTION DOCUMENT SUBMITTAL

CONSULTANTS: AXIOM ENGINEERS LEE & ASSOCIATES CONSULTING ENGINEERS 22 Lower Ridge Road, Suite A Monterey, California 93940-5768 Project # : 20130113		ARCHITECT/ENGINEERS: hfp architects 745 distel drive, suite a los altos, ca 94022 650 964 4514 fax: 650 967 5148		Drawing Title PRIMARY CHILLED WATER PIPING CENTRAL PLANT FLOOR PLAN PLUMBING Approved: Project Director		Project Title VA CENTRAL CALIFORNIA HEALTH CARE SYSTEM NEW BUILDING 22A + CHILLER INFRASTRUCTURE Location FRESNO, CA. Date 5/08/2015 Checked WME Drawn CADD		Project Number 570-13-300 Building Number 22A Drawing Number 22A-PS-102 Dwg. 68 of 86		Office of Construction and Facilities Management Department of Veterans Affairs	
---	--	---	--	--	--	---	--	--	--	---	--

