


## GENERAL NOTES AND SPECIFICATIONS

- [illegible]


## PLUMBING LEGEND

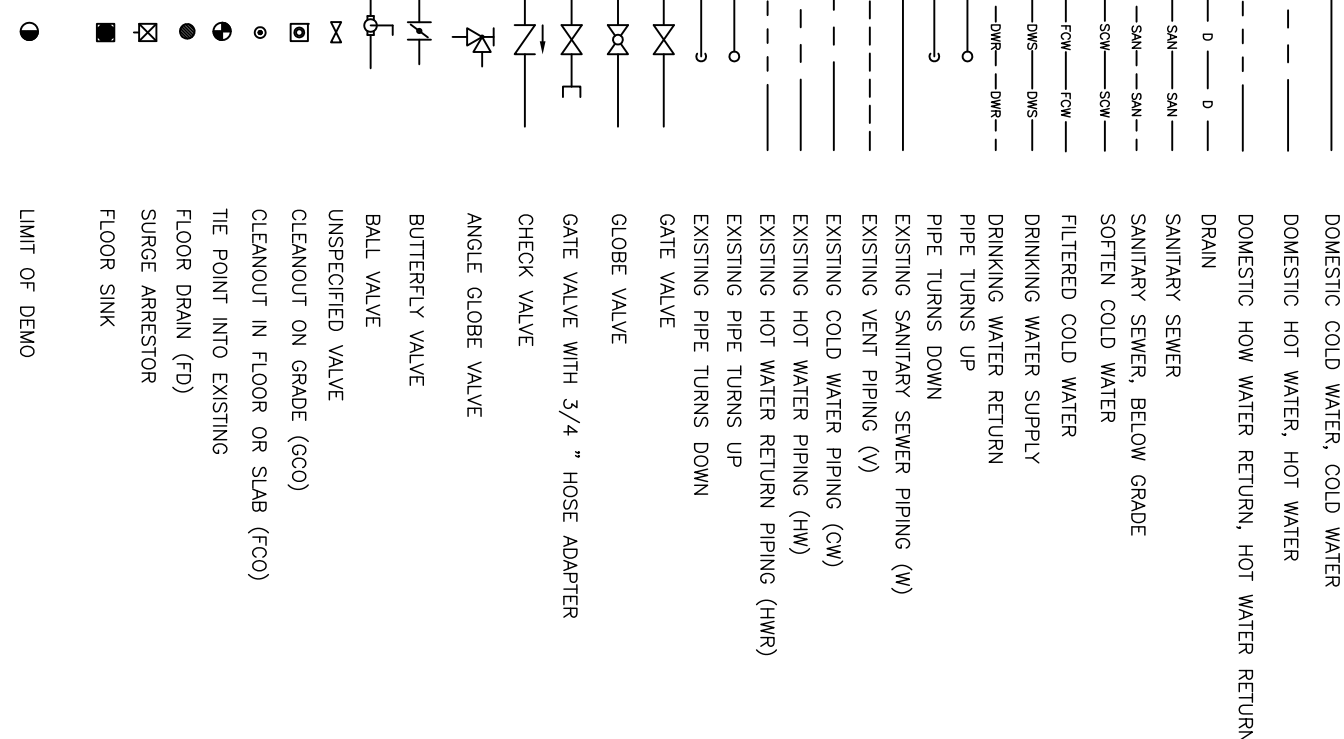


## PLUMBING ABBREVIATIONS

[illegible]


## DRAWING SYMBOLS

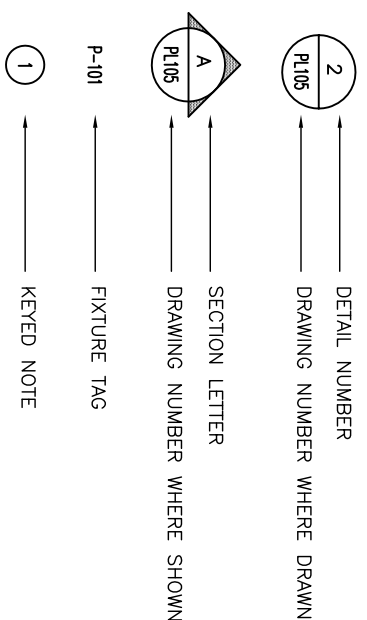

## REVERSE OSMOSIS PACKAGE DETAIL

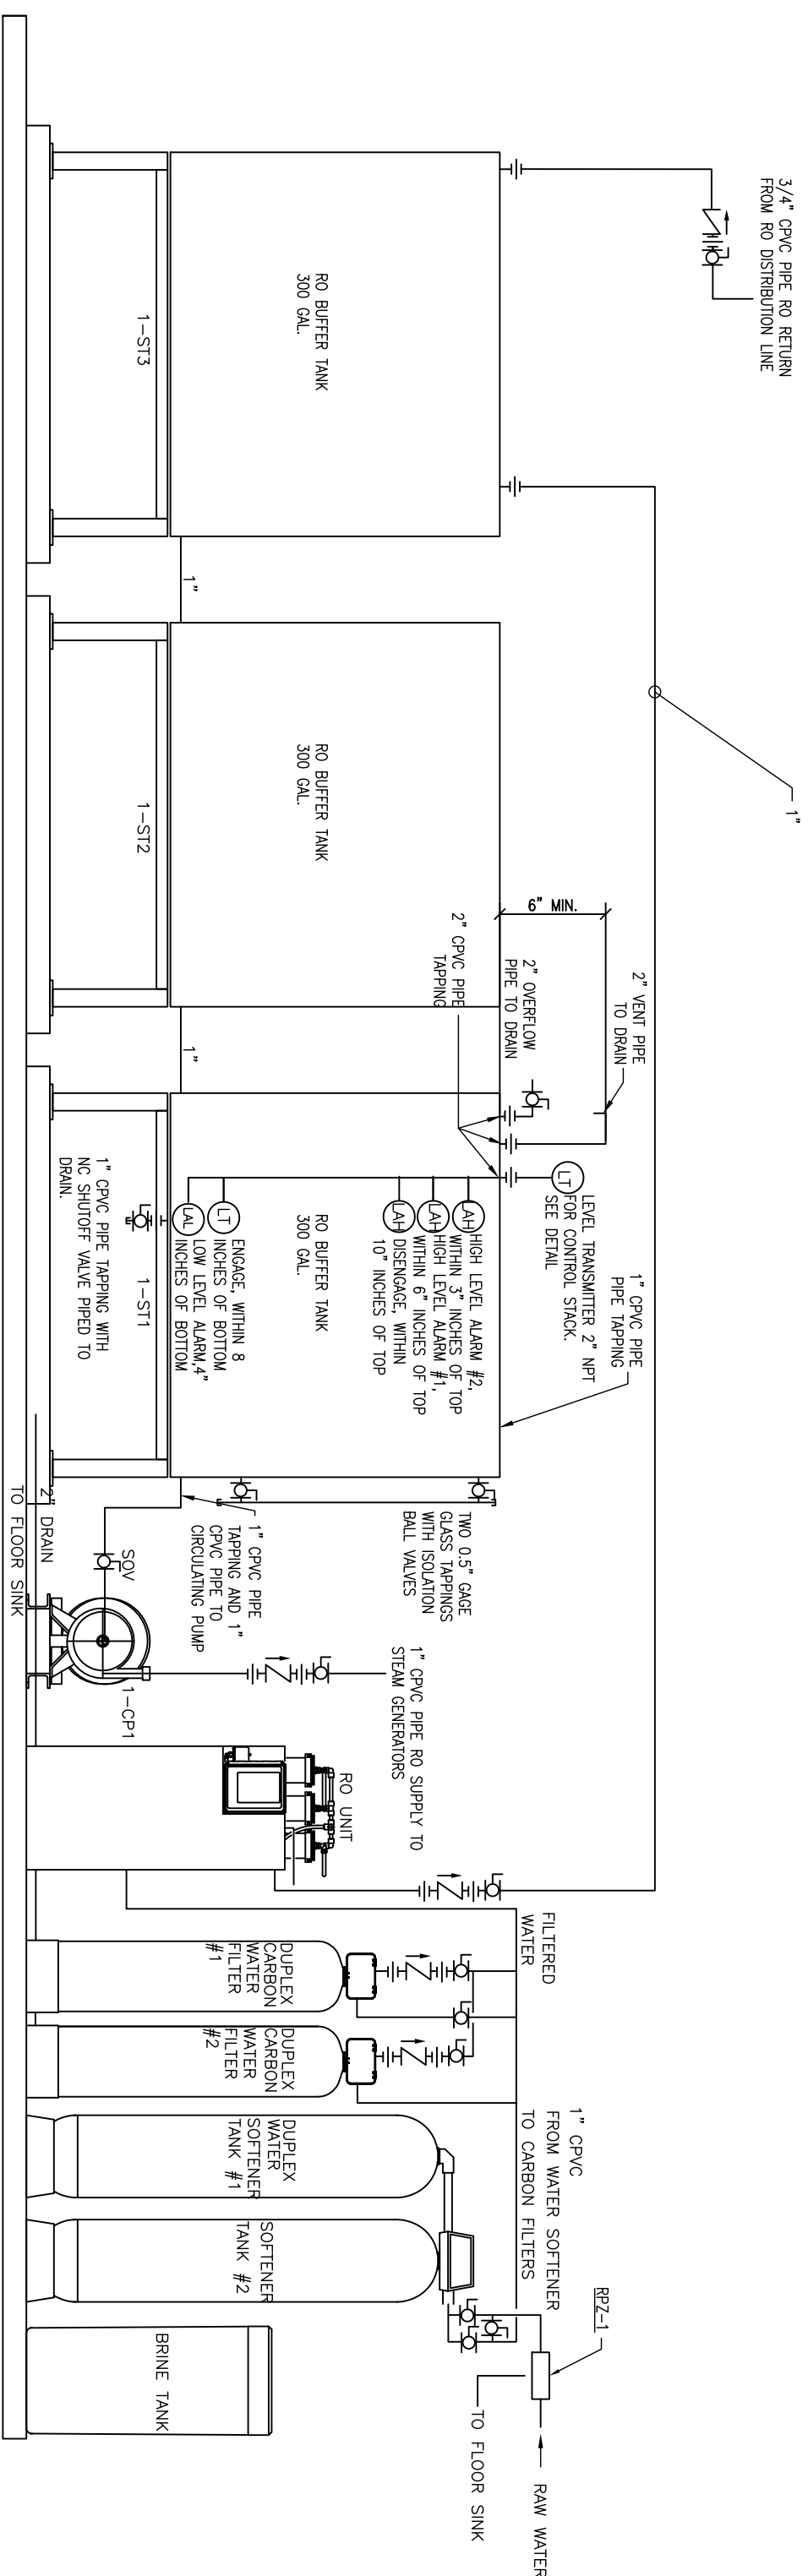

## HUMIDIFIER CONNECTION DETAIL

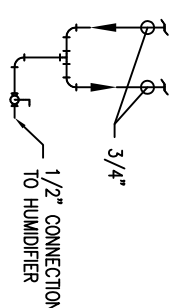

## CONSULTANTS:

[illegible]

## ARCHITECT/ENGINEERS

CONSULTANTS:	

PP320 (PHASE 3) Water Treatment General Notes

Approved Project Director

## WATER TREATMENT AND CHILLER

<b>Project Title</b>	<b>WATER TREATMENT AND CHILLER</b>			<b>Project Number</b>	
<b>Date</b>	04/14/2015	<b>Checked</b>		<b>Bidding Number</b>	<b>BUFFALO</b>
		<b>Drawing</b>		<b>Drawing Number</b>	
				<b>Dwg. of</b>	

Project Number	
Building Number BUFFALO	
Drawing Number	

Office of

Construction

and Facilities

Management

