


# Department of Veterans Affairs

# BLACK HILLS NATIONAL CEMETERY










STURGIS, SOUTH DAKOTA

**REPAIRS & IMPROVEMENTS,  
ADMINISTRATION BUILDING & COMMITTAL SHELTER**


SHEET INDEX:	
X-1	TITLE SHEET
D-1	DEMO PLAN, ADMIN BUILDING
A-1	FLOOR PLAN, ADMIN BUILDING
A-2	FLOOR AND ROOF PLANS, SHELTER
A-10	DOOR AND WINDOW DETAILS
E-1	ELECTRICAL PLAN & PANEL SCHEDULE, SHELTER

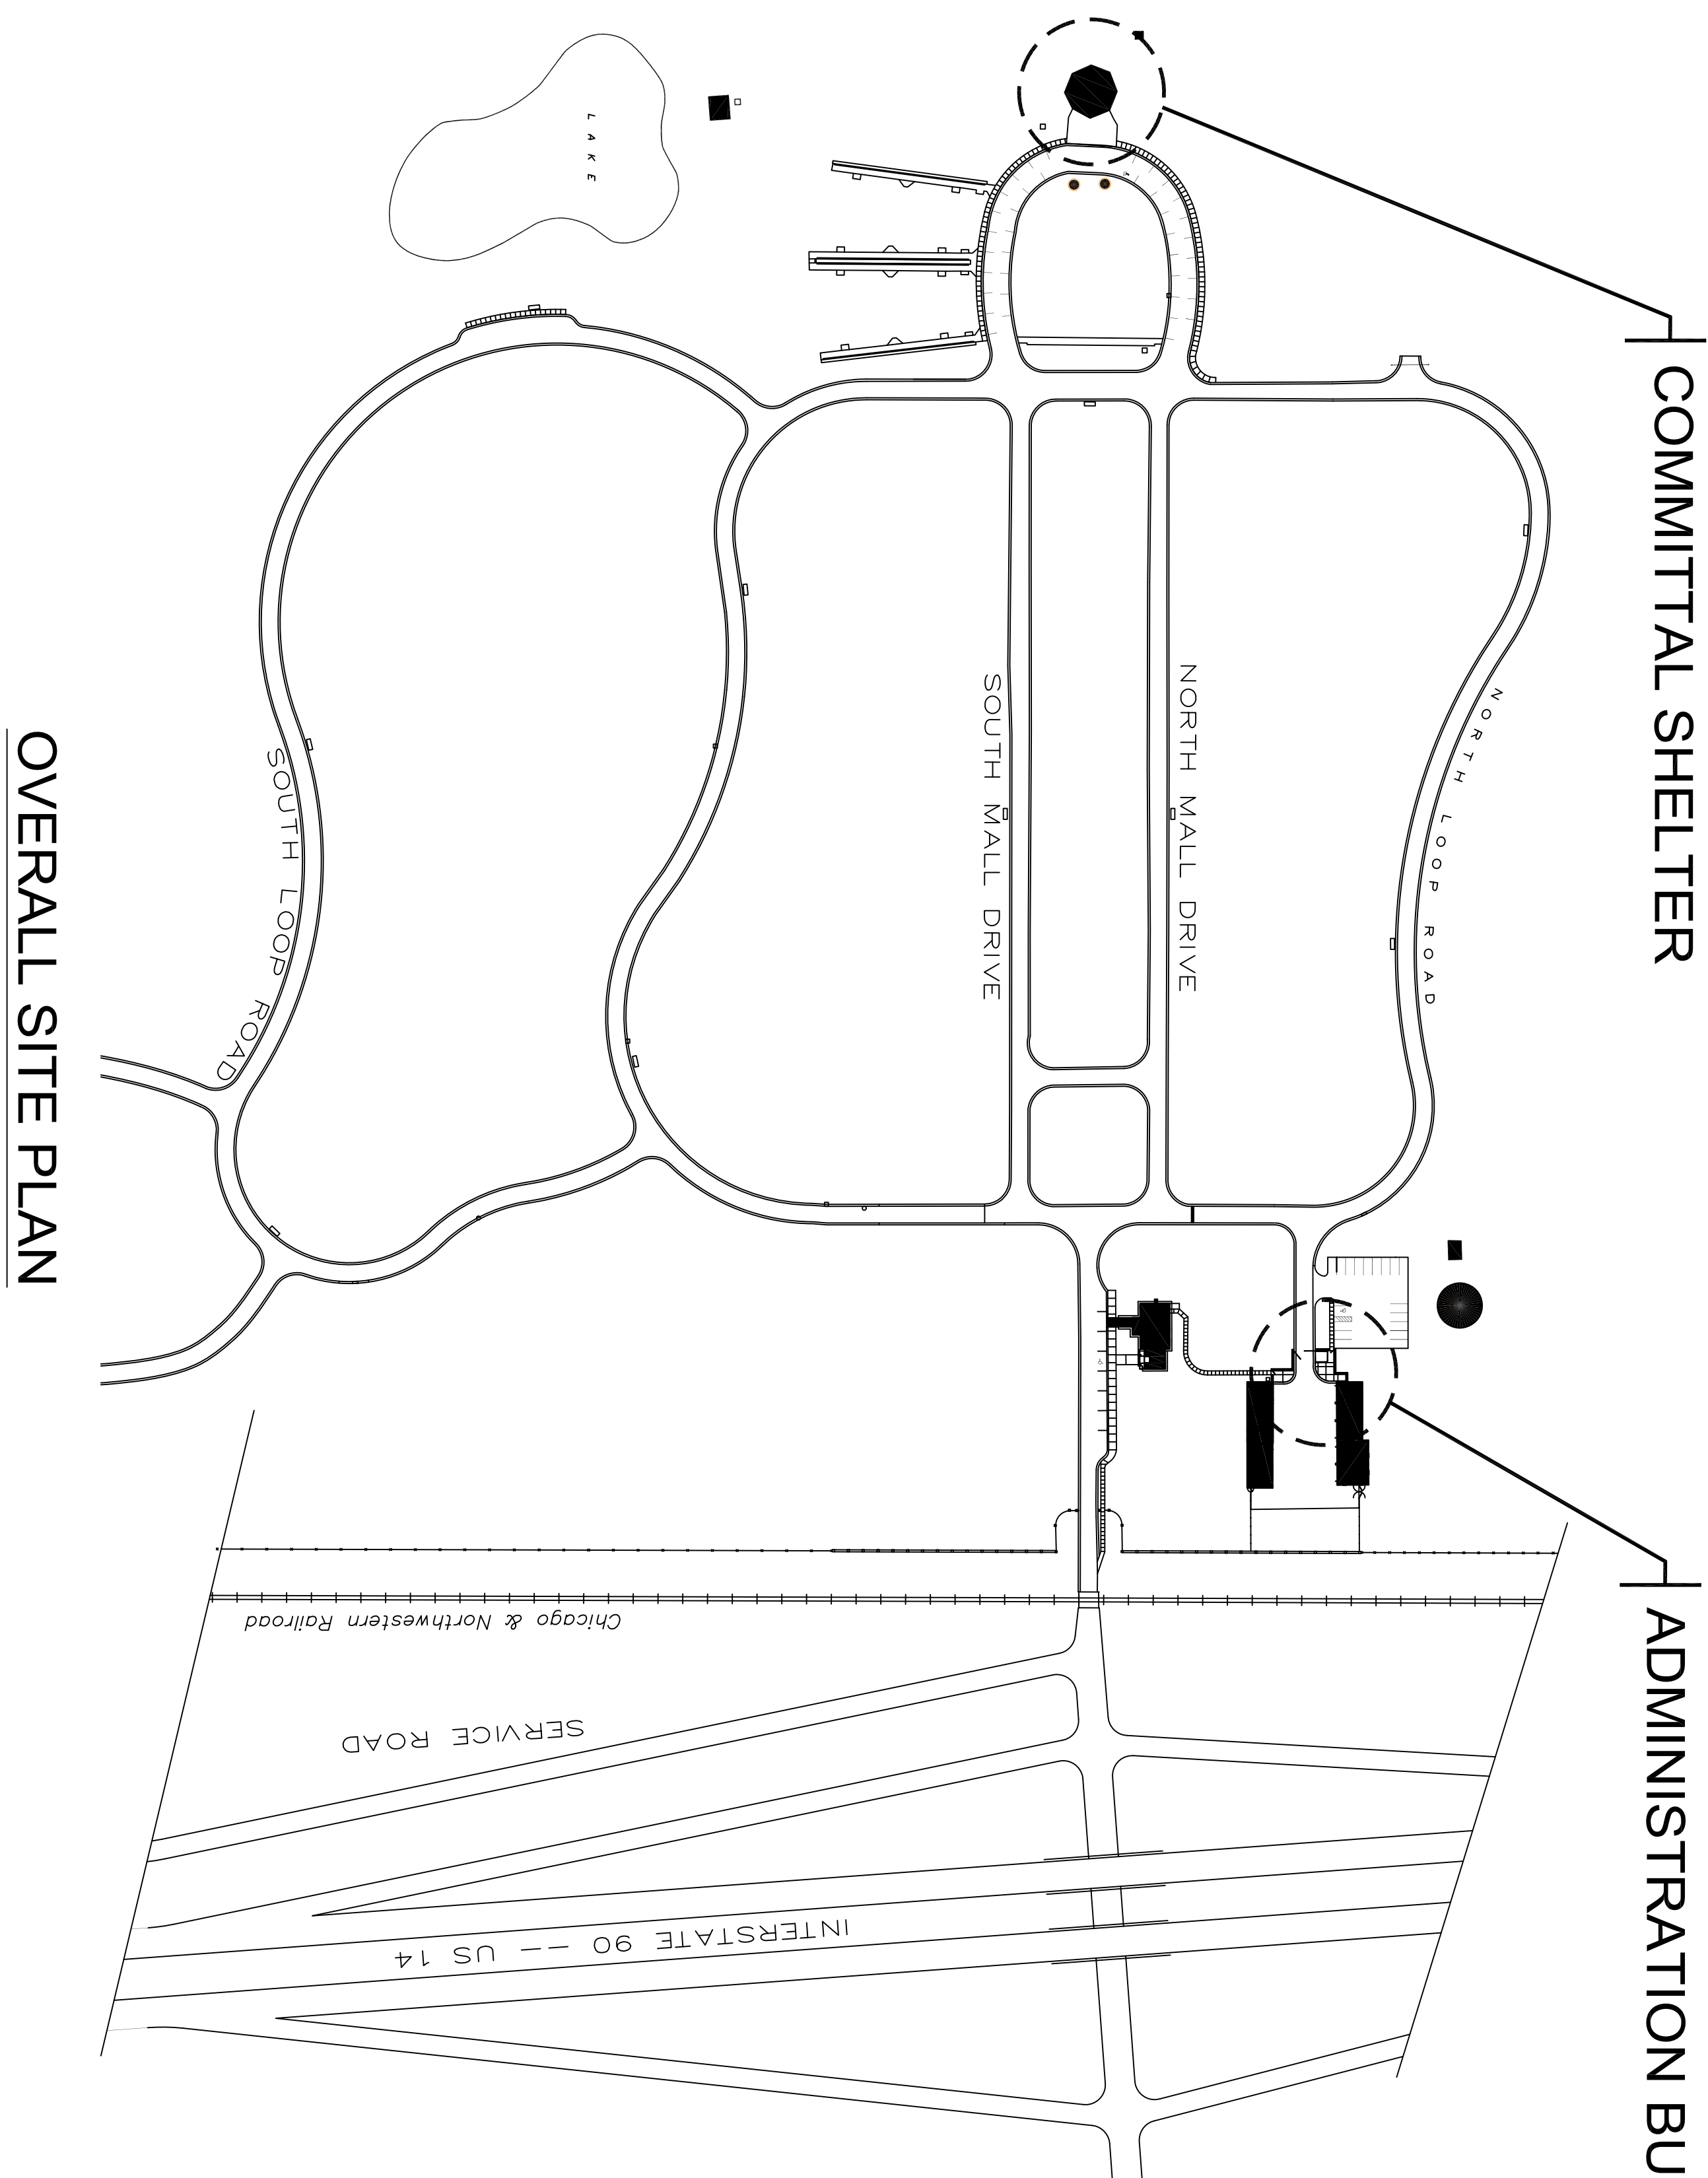

Drawing Title <b>COVER SHEET &amp; SHEET INDEX</b>		Project Title <b>REPAIRS &amp; IMPRV, ADMIN &amp; SHELTER</b>		Date <b>04/02/2015</b>
Project No. <b>884-15-201</b>		Building Number *****		Drawing NO. <b>X-1</b>
Approved: Division Chief		Checked	Drawn <b>CFC</b>	Dwg. 1 of 6
Approved: Service Director		Location <b>BLACK HILLS NATIONAL CEMETERY</b>		

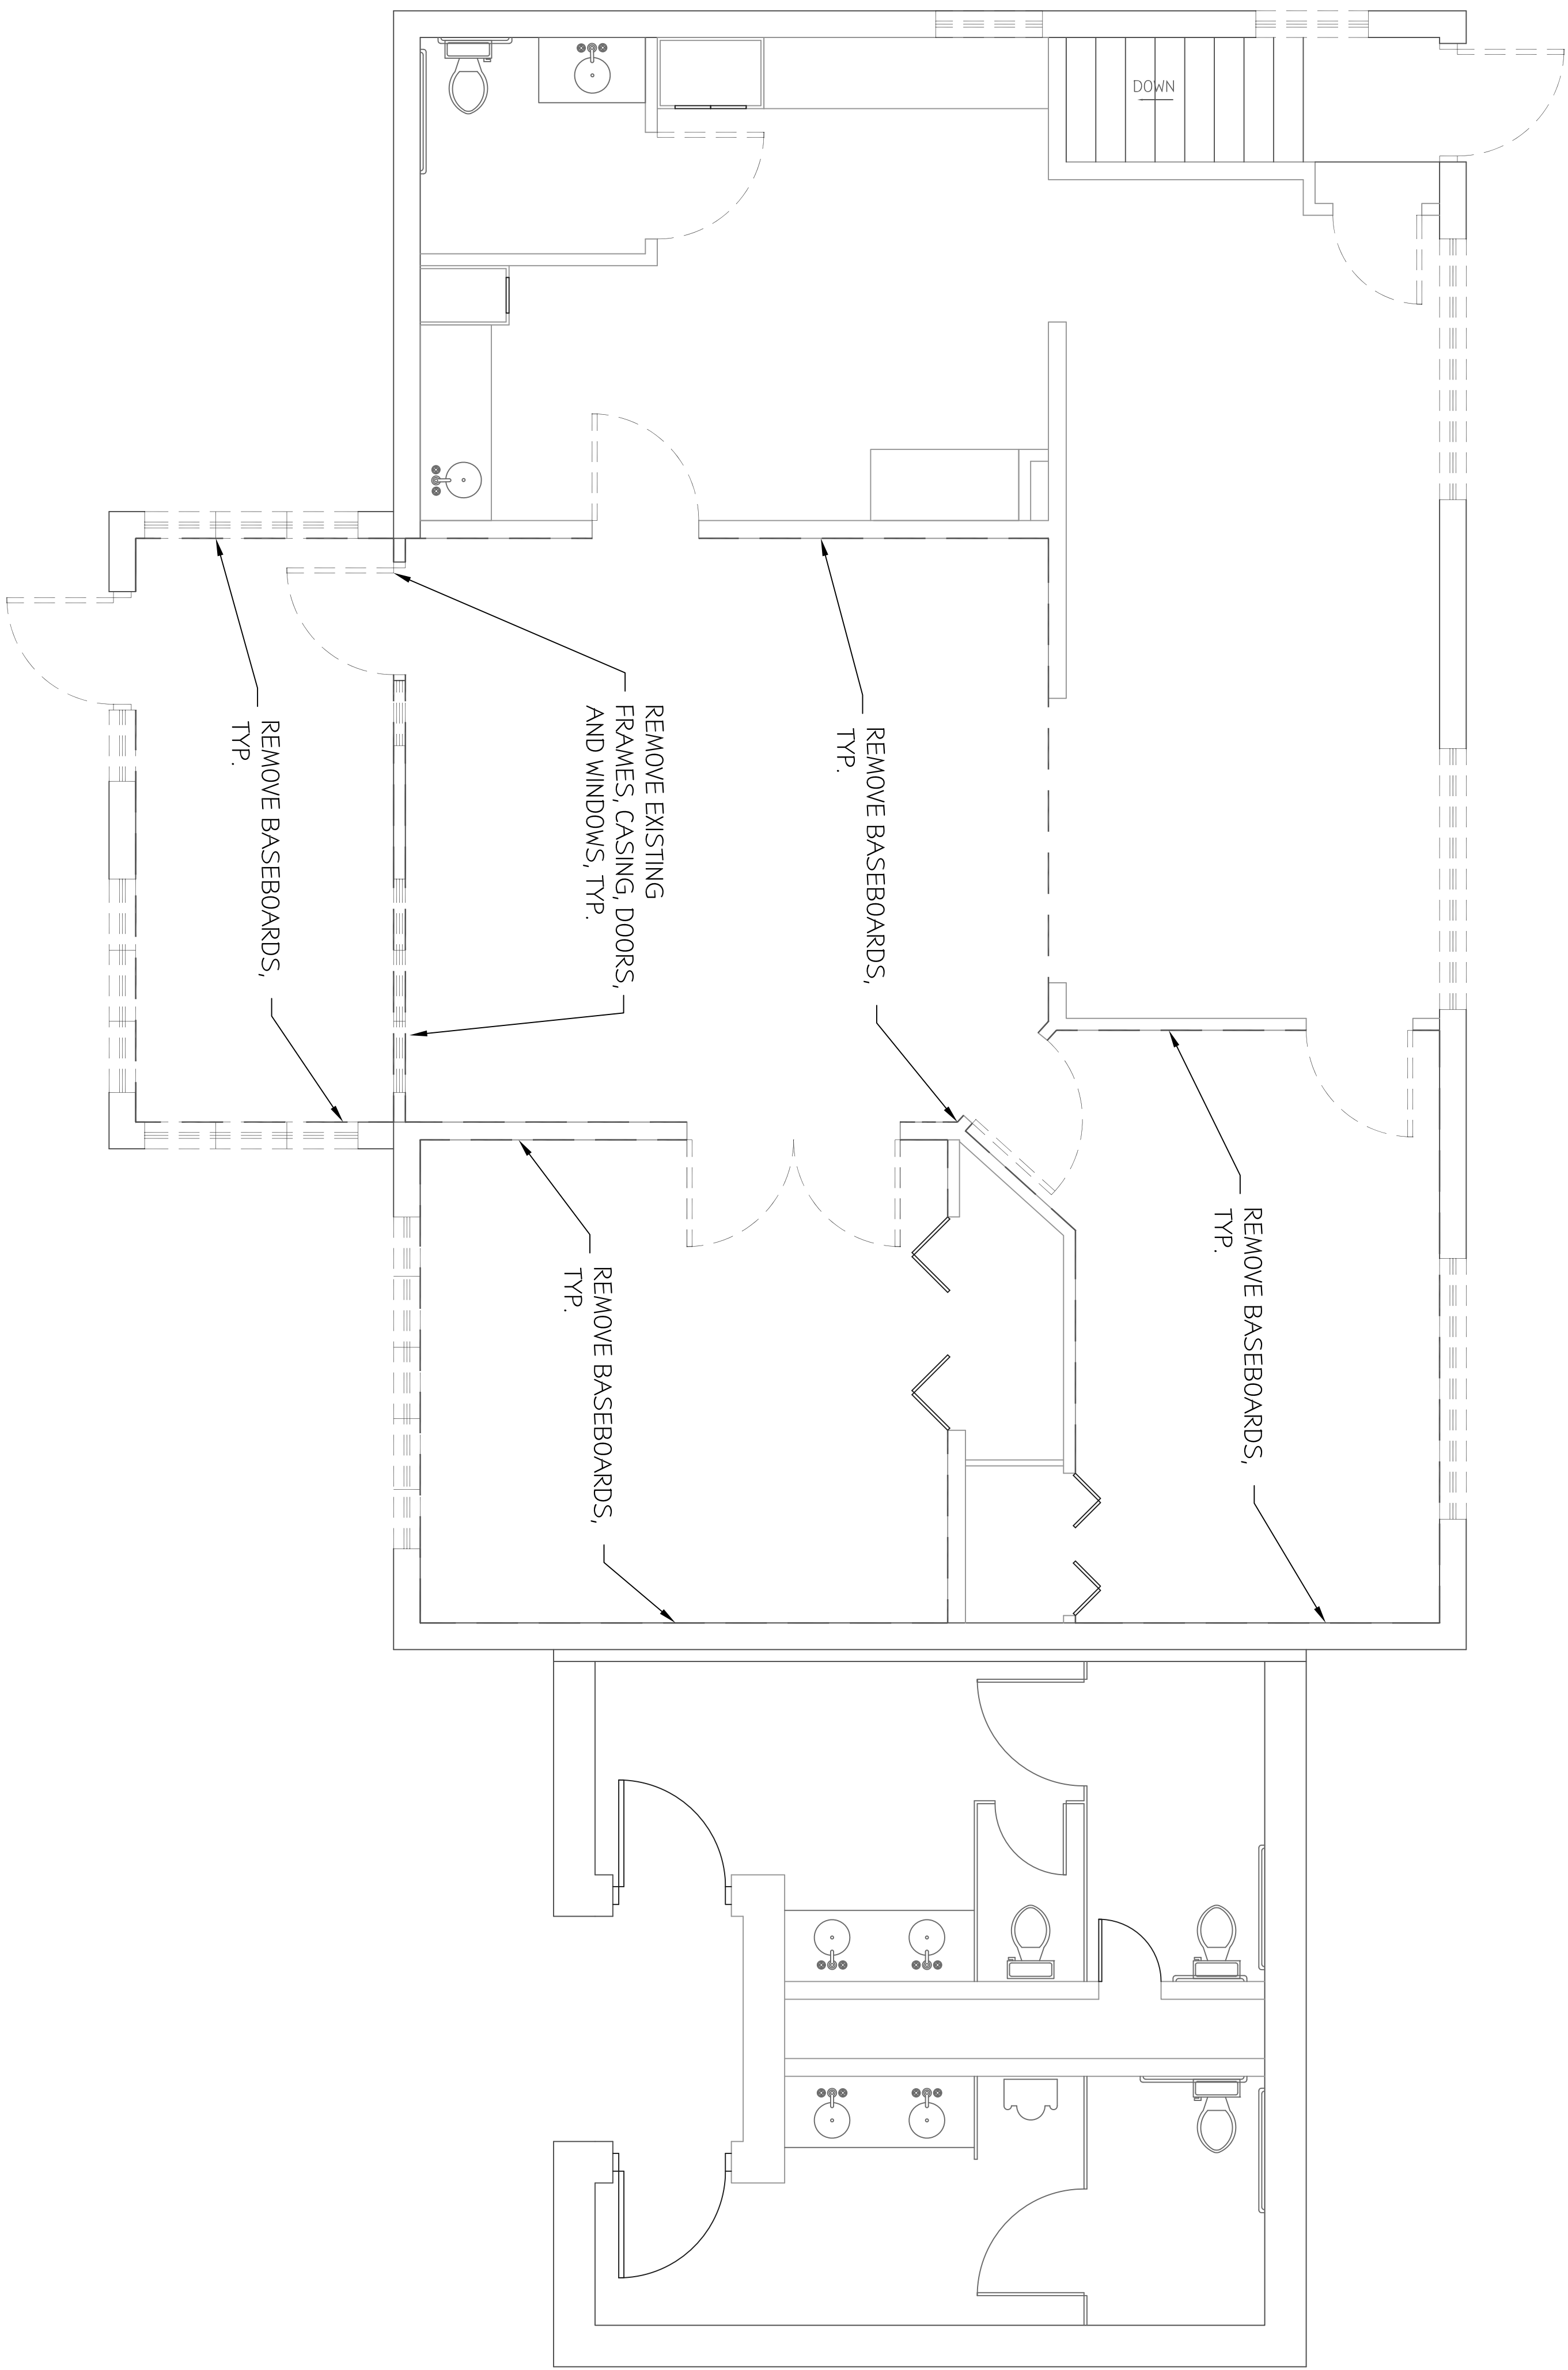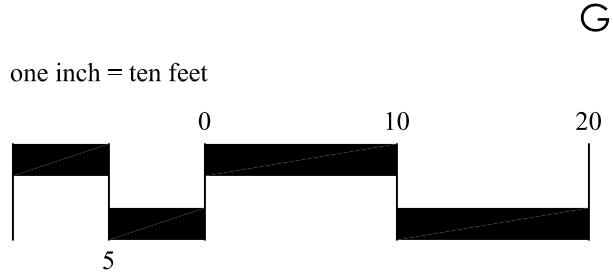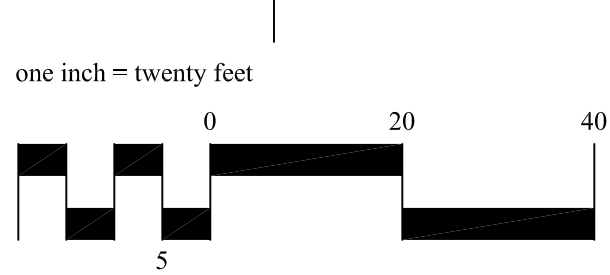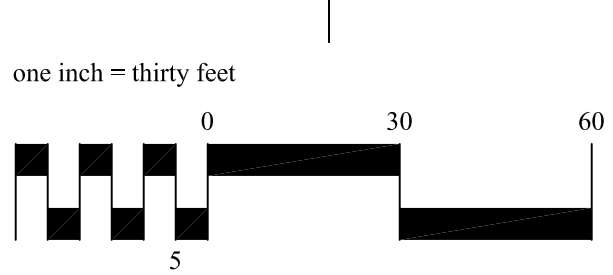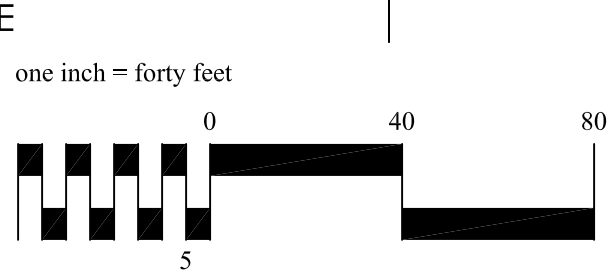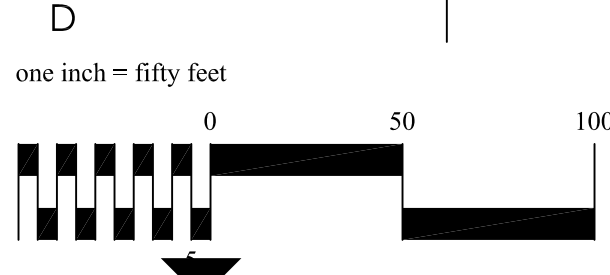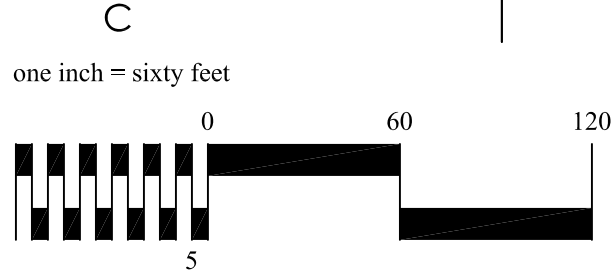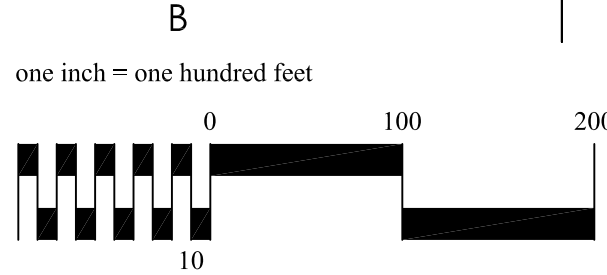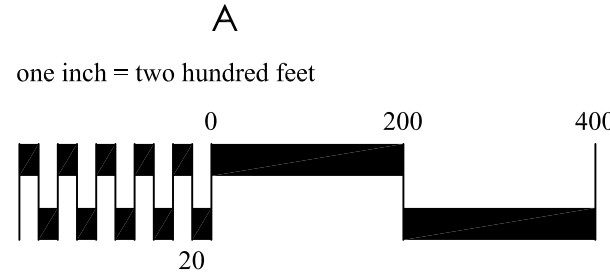

FIRST FLOOR

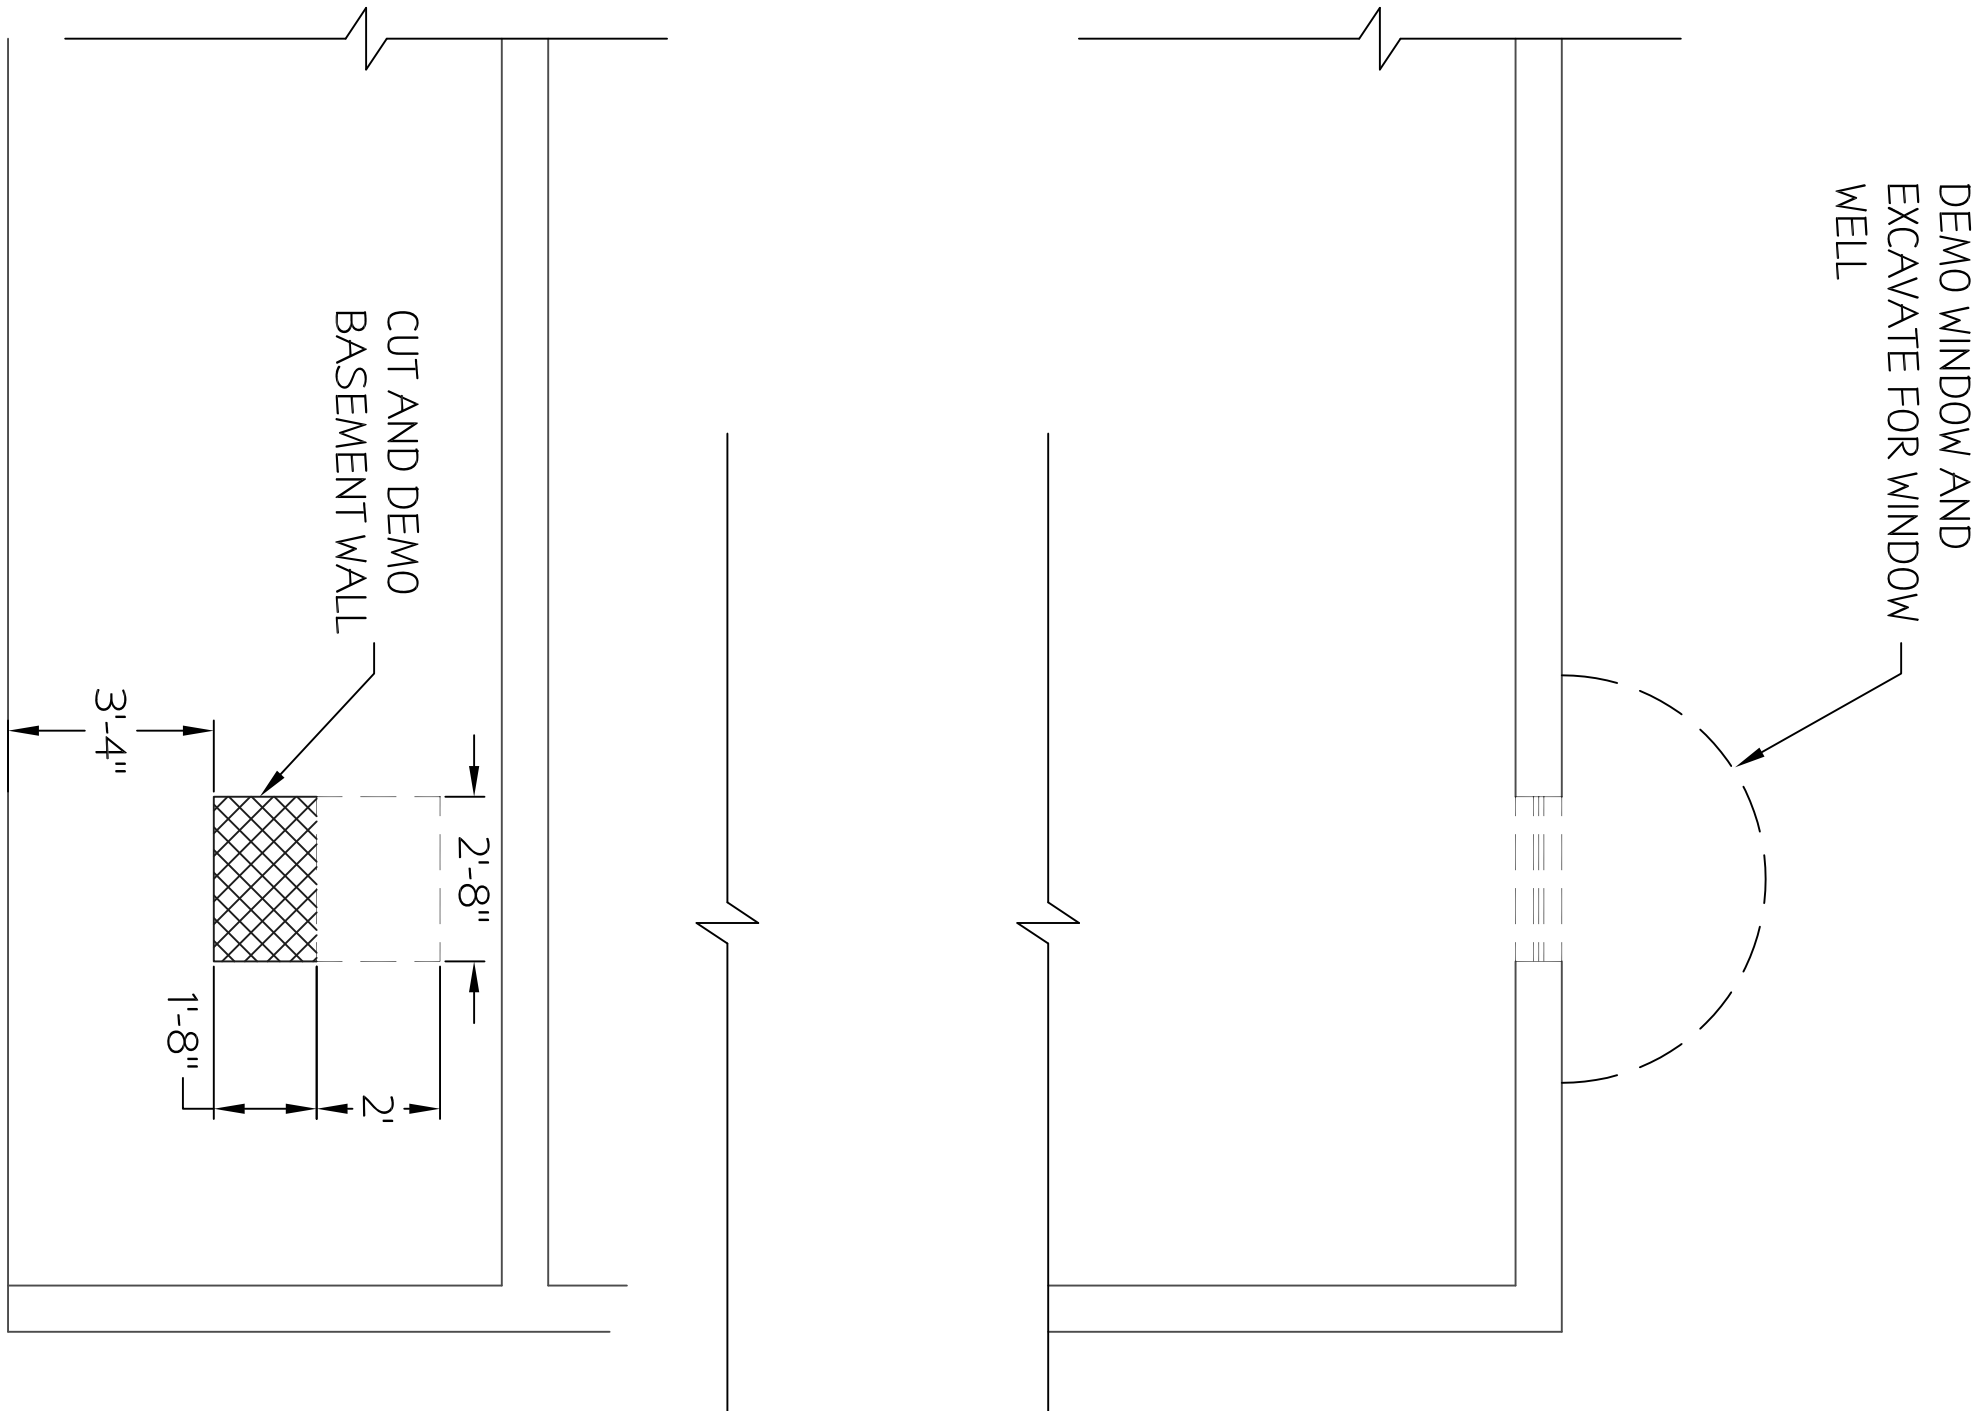

BASEMENT

REVISIONS	Date

--





NATIONAL  
CEMETERY  
ADMINISTRATION

Drawing Title	Project Title
DEMO PLAN, ADMIN BLDG	REPAIR & IMPRV, ADMIN & SHELTER
Approved: Division Chief	Building Number
Approved: Service Director	Location

Location	BLACK HILLS NATIONAL CEMETERY
----------	-------------------------------

Date	04/02/2015
Project No	884-15-201
DRAWING NO.	D-1
Dwg. 2	Of 6

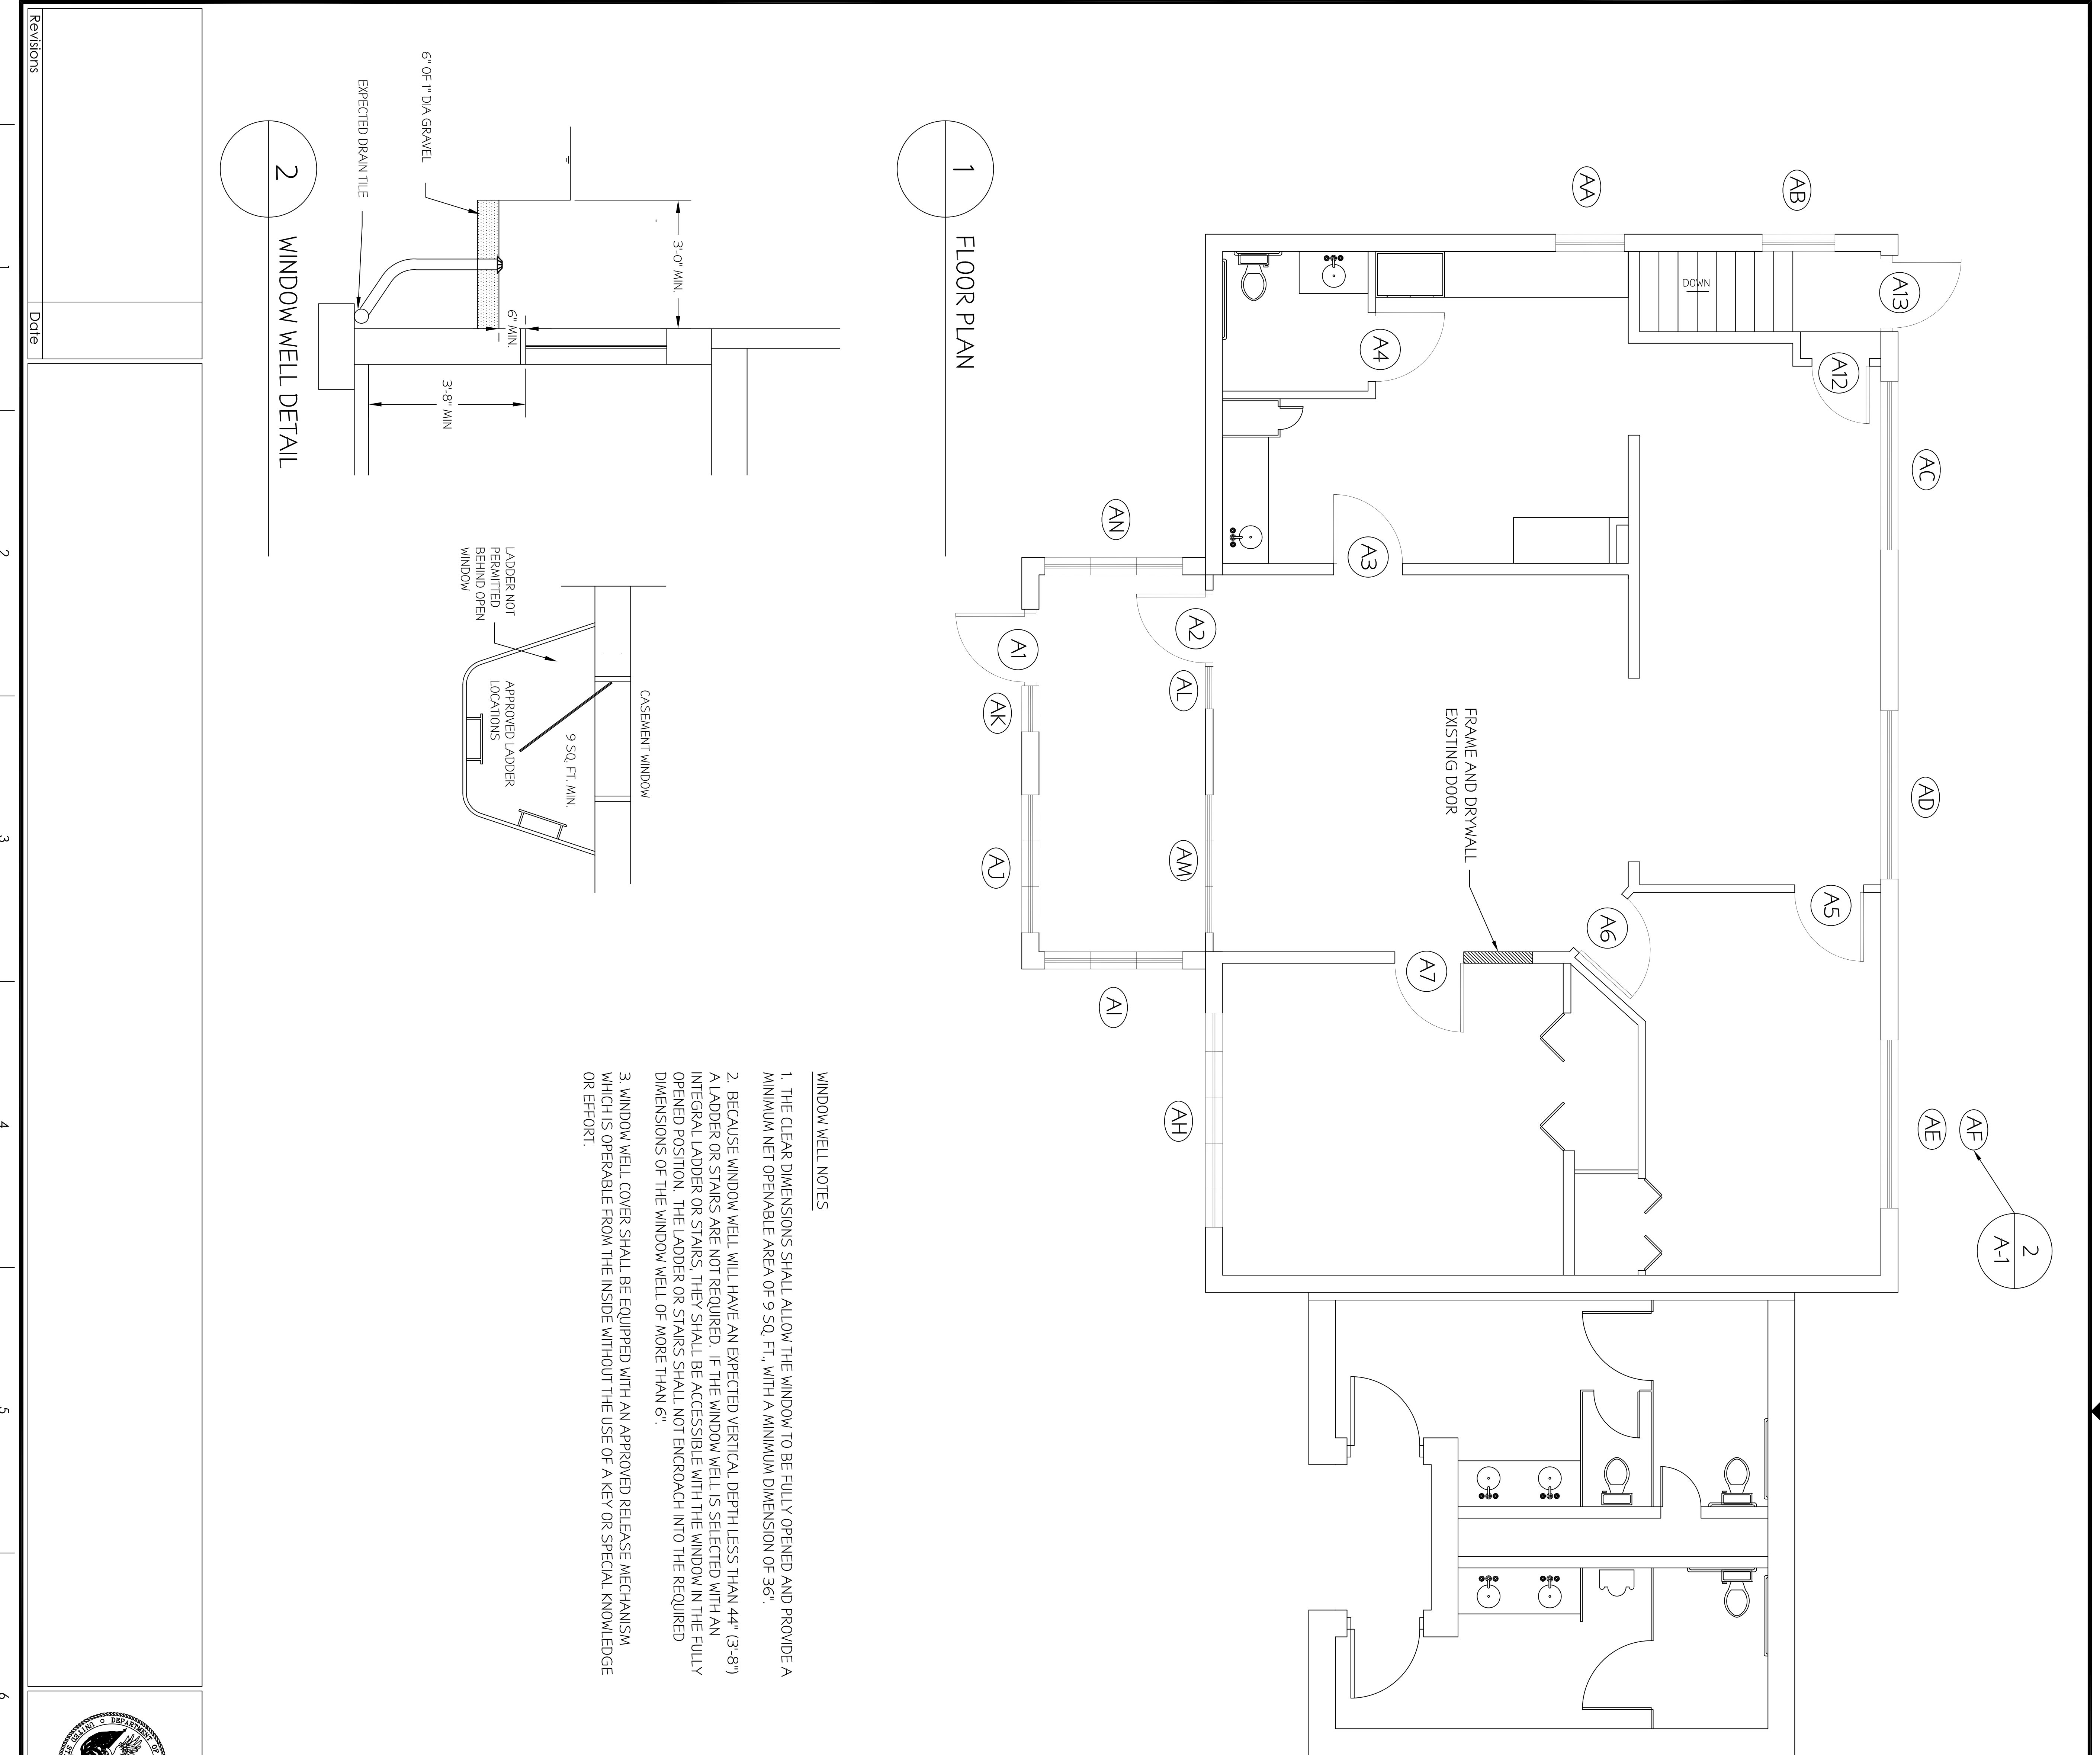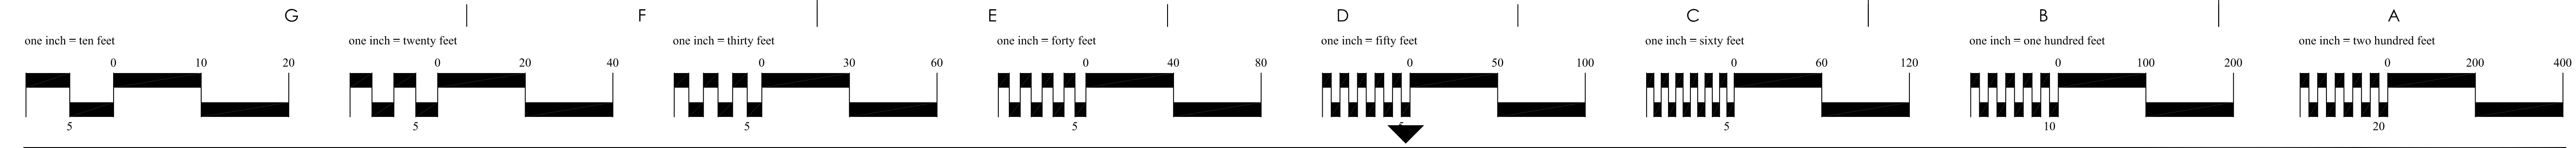


DOOR SCHEDULE - ADMINISTRATION BUILDING											
MARK LABEL	U.L.	DOORS			FRAMES			GLAZING	HDBR	REMARKS	
		LEAF SIZE	SGL. DBL.	TYPE	MAT'L	TYPE	DETAIL				MAT'L
A1		3'-0x6'-8"	5	A	WDV	1	AD	CD	G-36	1	
A2		3'-0x6'-8"	5	B	WD	1	AD	WD	G-4	2	
A3		3'-0x6'-8"	5	C	WD	2	AD	WD		6	
A4		3'-0x6'-8"	5	C	WD	2	AD	WD		4	
A5		3'-0x6'-8"	5	C	WD	2	AD	WD		3	
A6		3'-0x6'-8"	5	C	WD	2	AD	WD		3	
A7		3'-0x6'-8"	5	C	WD	2	AD	WD		5	

A12		3'-0"x6'-8"	5	C	WD	2	WD		9	
A13		3'-0"x6'-8"	5	G	HM	4	CD	G-36	1	

### WINDOW SCHEDULE – ADMIN. BLDG.

MARK	ROUGH OPENING SIZE	TYPE	REMARKS
AA	3'-4 <sup>3</sup> / <sub>4</sub> "x2'-0"	CLAD/WOOD CASEMENT	SINGLE/1) WDW
AB	3'-4 <sup>3</sup> / <sub>4</sub> "x2'-0"	CLAD/WOOD CASEMENT	SINGLE/1) WDW
AC	6'-5 <sup>3</sup> / <sub>8</sub> "x4'-2 <sup>1</sup> / <sub>2</sub> "	CLAD/WOOD CASEMENT	TRIPLE/3) WDW, CENTER FIXED
AD	6'-5 <sup>3</sup> / <sub>8</sub> "x4'-2 <sup>1</sup> / <sub>2</sub> "	CLAD/WOOD CASEMENT	TRIPLE/3) WDW, CENTER FIXED
AE	6'-5 <sup>3</sup> / <sub>8</sub> "x4'-2 <sup>1</sup> / <sub>2</sub> "	CLAD/WOOD CASEMENT	TRIPLE/3) WDW, CENTER FIXED
AF	2'-0"x3'-8"	CLAD/WOOD CASEMENT	BASEMENT/MODIFY
AH	9'-7 <sup>3</sup> / <sub>8</sub> "x6'-0"	CLAD/WOOD CASEMENT	QUINTUPLE/5) WDW, CENTER 3 FIXED
AI	6'-0"x6'-0"	CLAD/WOOD CASEMENT	TRIPLE/3) WDW, CENTER FIXED
AJ	6'-0"x6'-0"	CLAD/WOOD CASEMENT	TRIPLE/3) WDW, CENTER FIXED
AK	2'-0"x6'-9"	WOOD FIXED GLASS	SIDELITE/INSULATED TEMPERED GLASS
AL	2'-0"x6'-9"	WOOD FIXED GLASS	SIDELITE/ TEMPERED GLASS
AM	6'-7 <sup>3</sup> / <sub>8</sub> "x5'-1 <sup>1</sup> / <sub>4</sub> "	CLAD/WOOD CASEMENT	TRIPLE/3) WDW, CENTER FIXED
AN	6'-0"x6'-0"	CLAD/WOOD CASEMENT	TRIPLE/3) WDW, CENTER FIXED

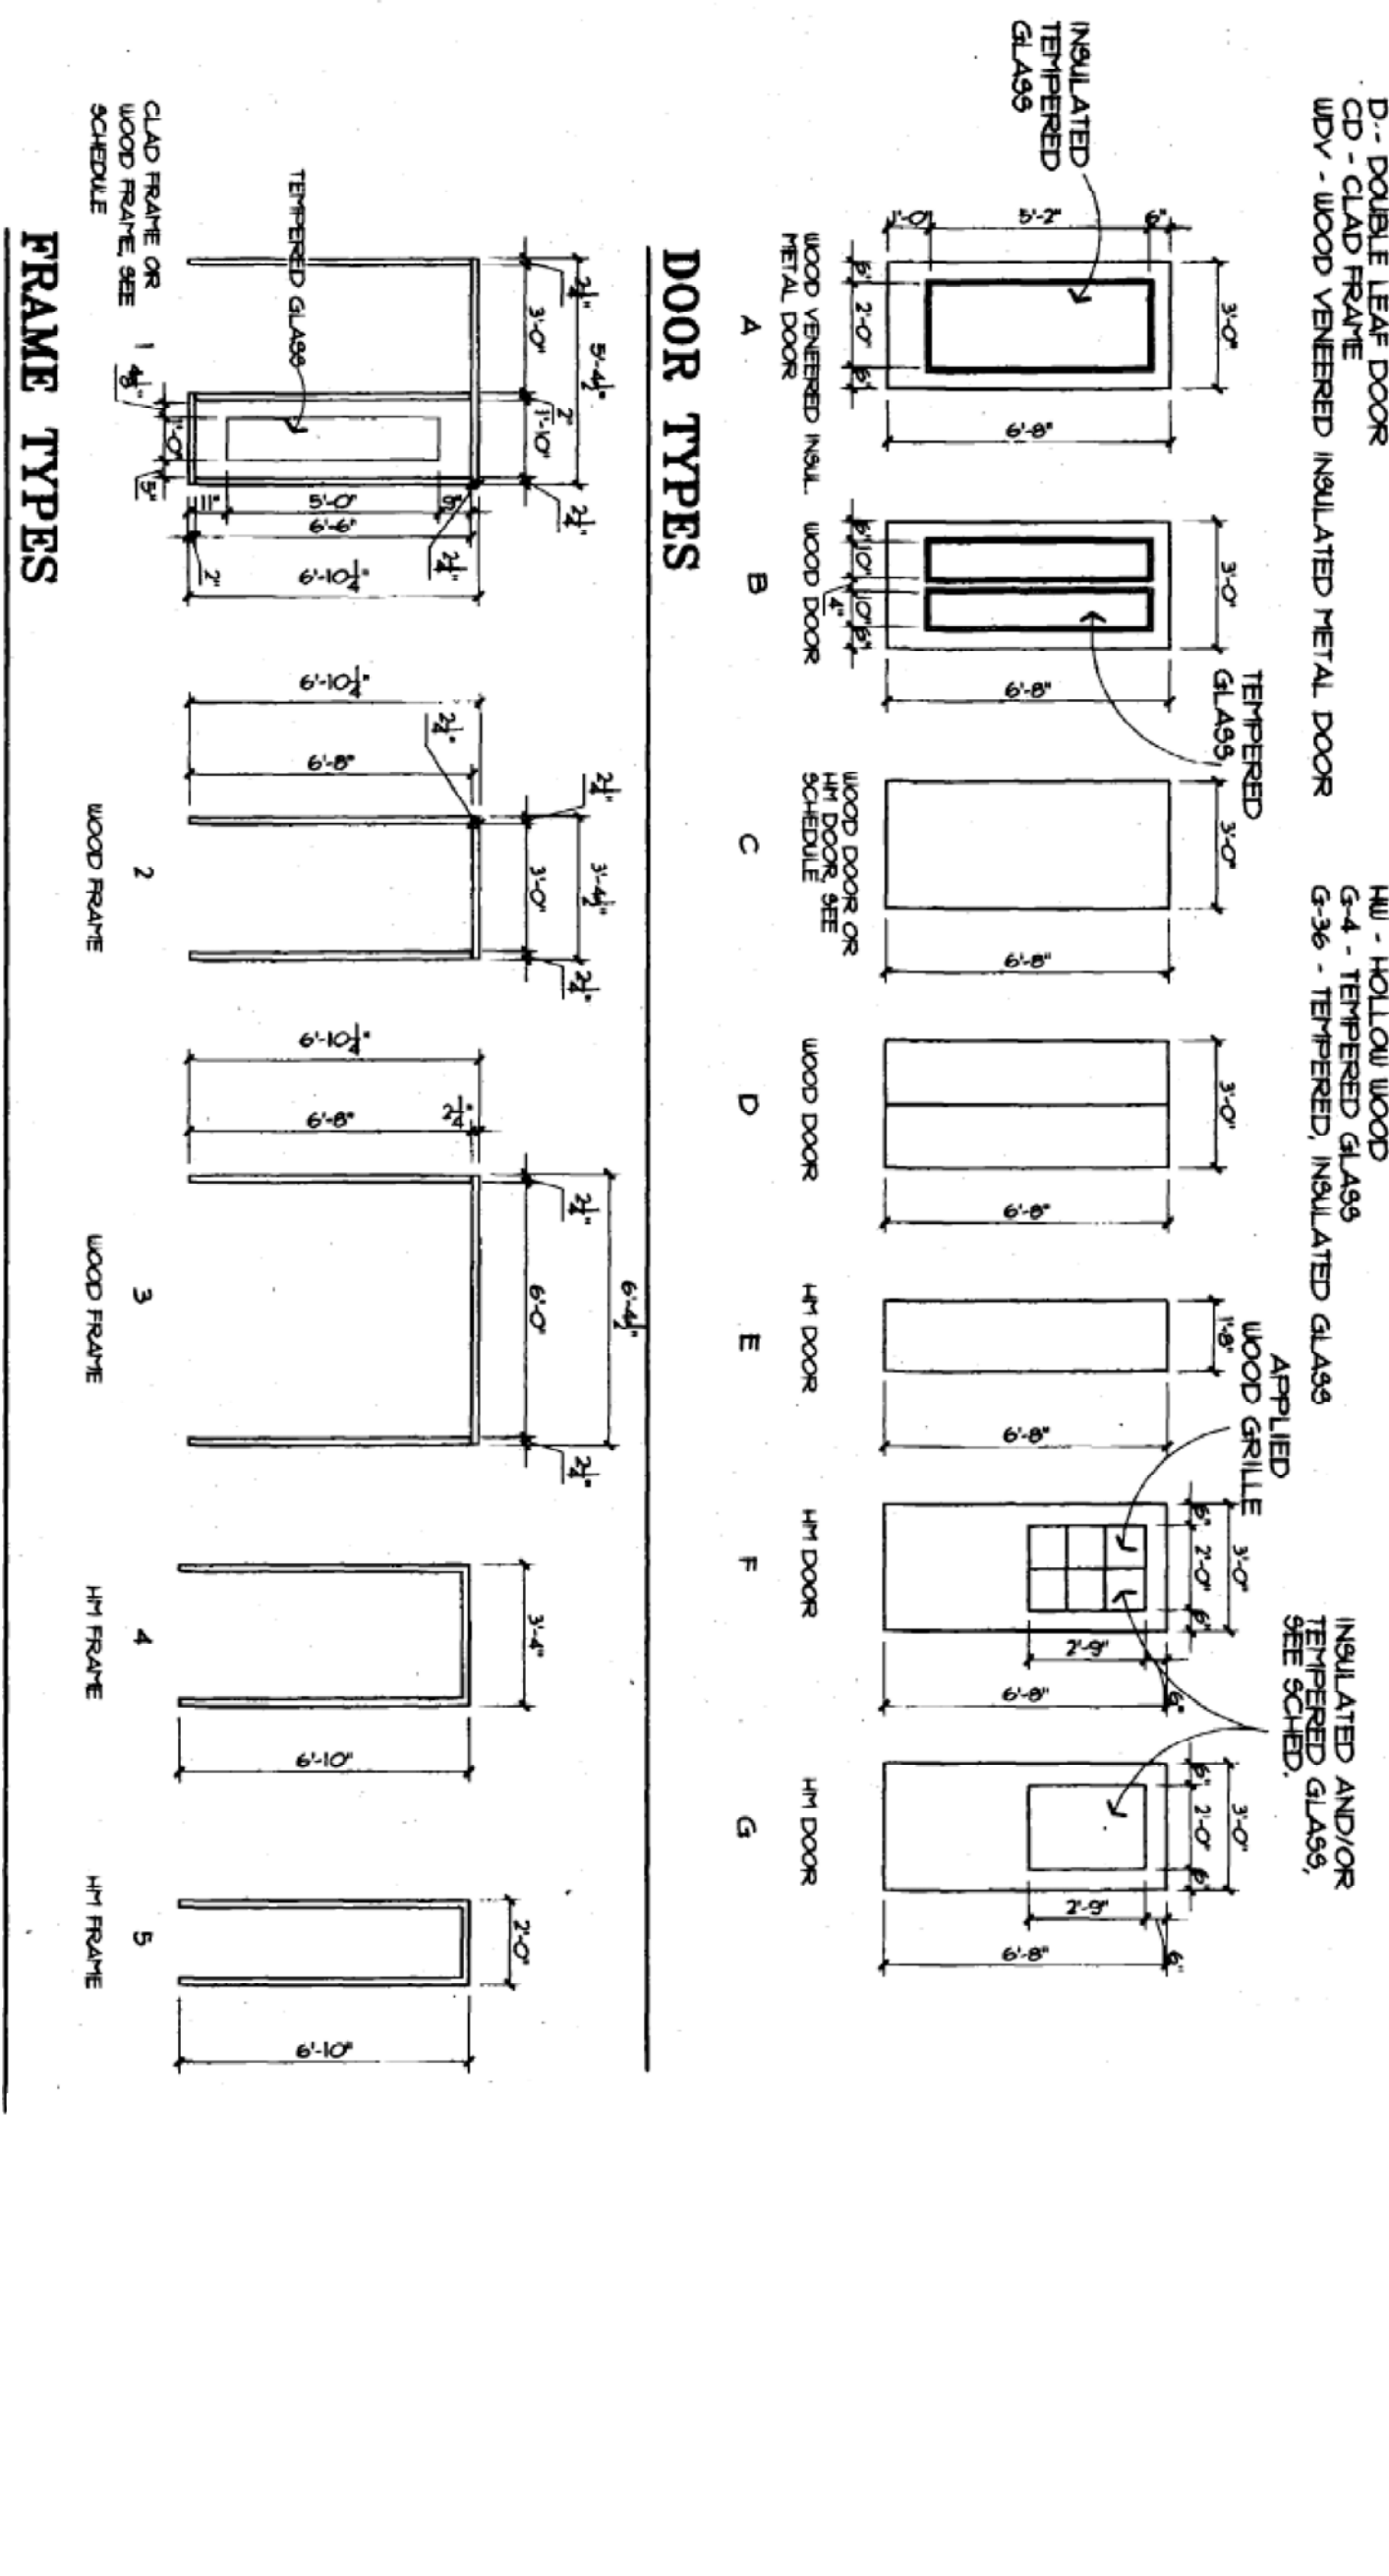

NATIONAL C EMETERY ADMINISTRATION

Drawing Title

**FOOR PLAN, ADMIN BLDG**

Project Title

**REPAIR & IMPRV, ADMIN & SHELTER**

Approved: Division Chief

Building Number

\*\*\*\*

Checked

CFC

Approved: Service Director

Location

BLACK HILLS NATIONAL CEMETERY

Date

04/02/2015

Project No










884-15-201

DRAWING NO.


**A-1**

Dwg. 3 OF 6



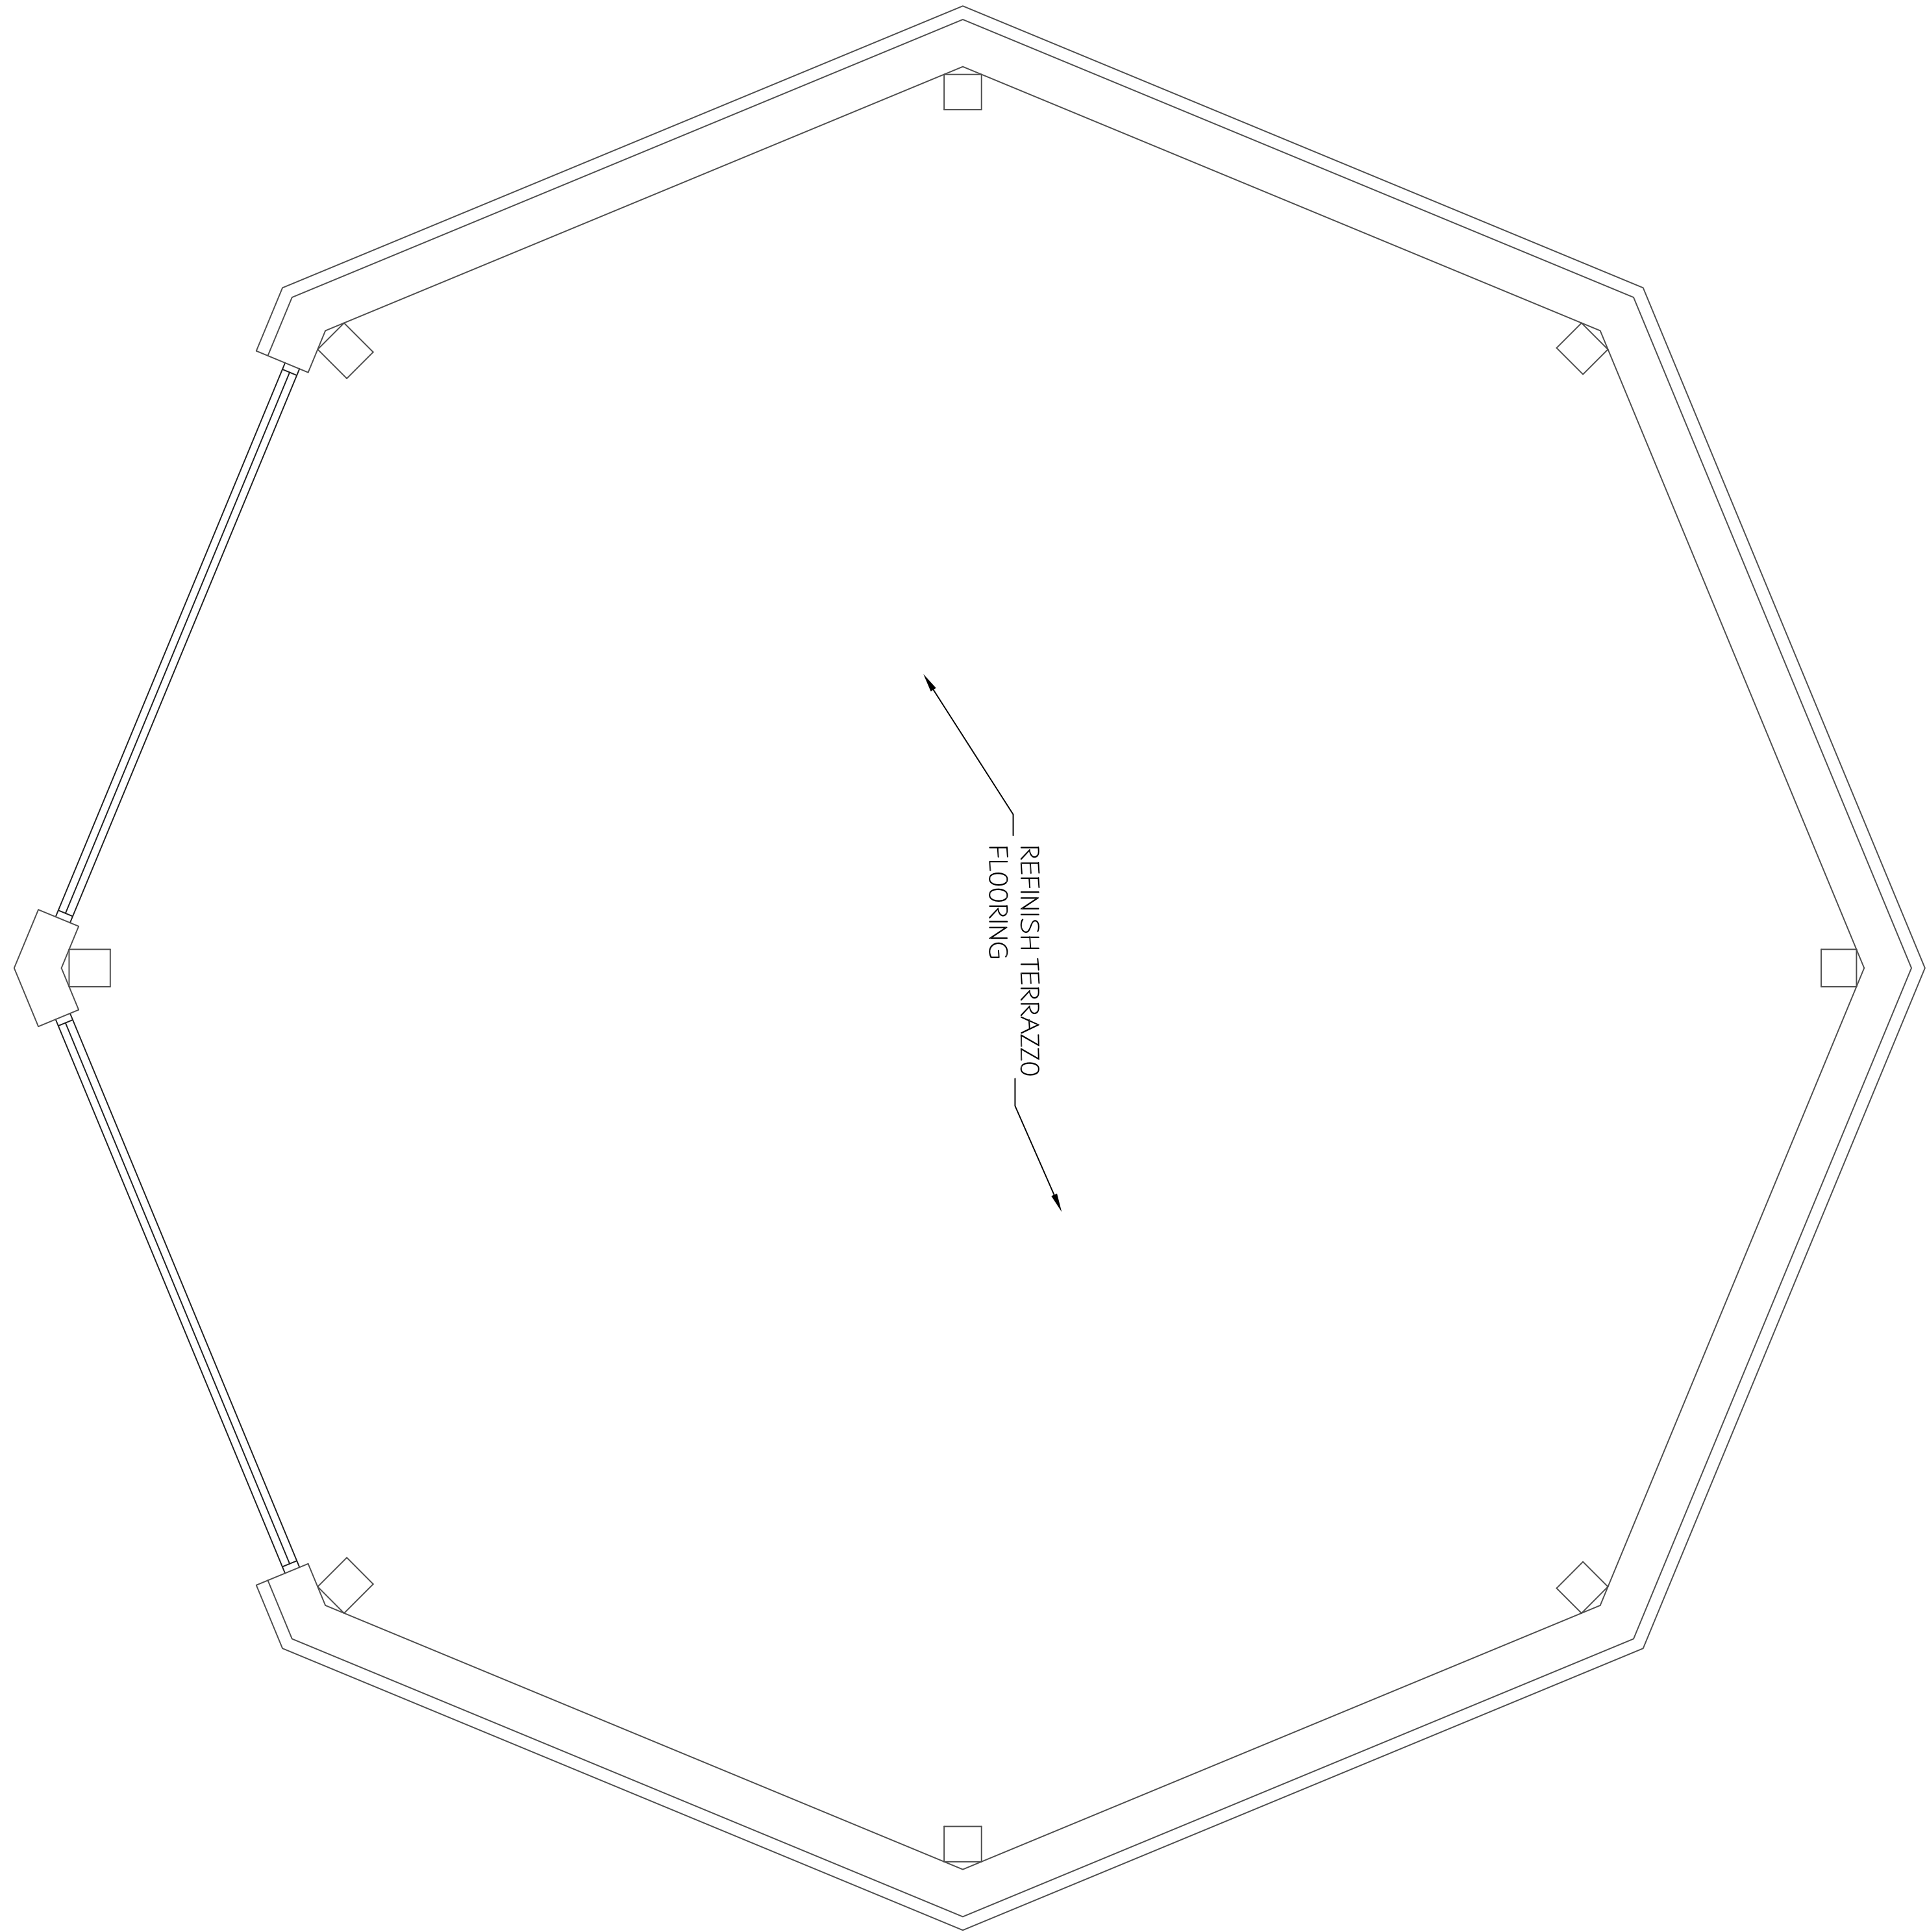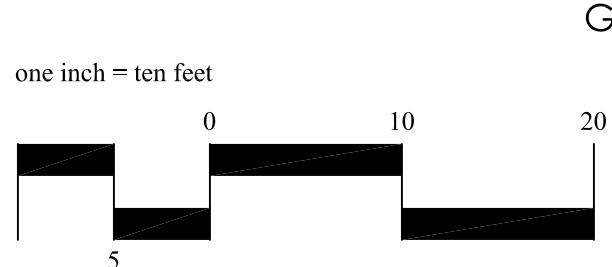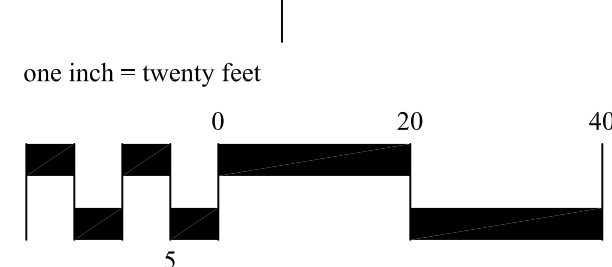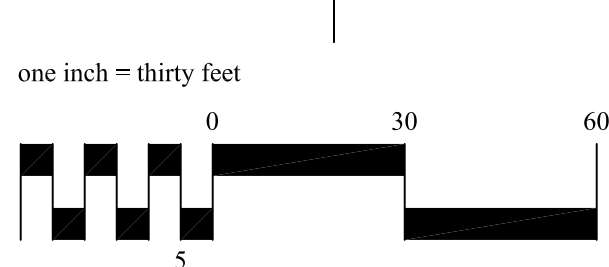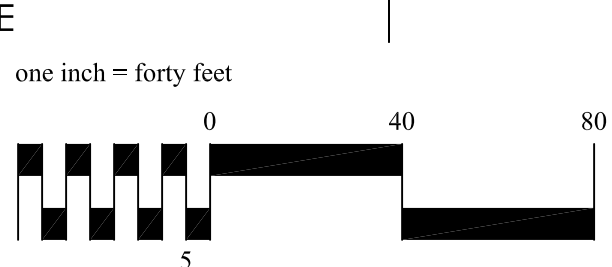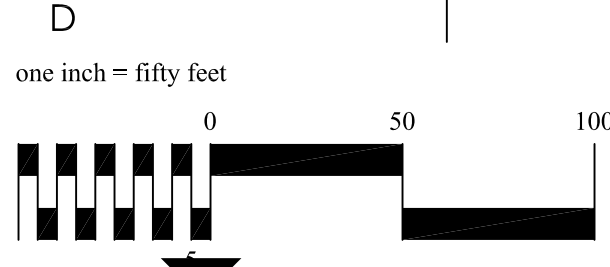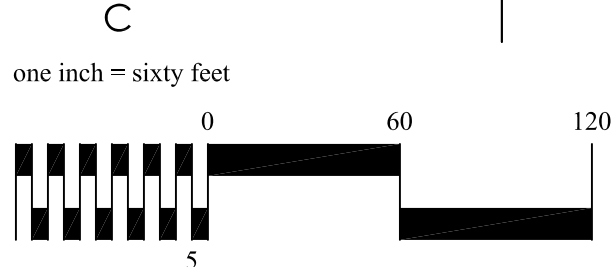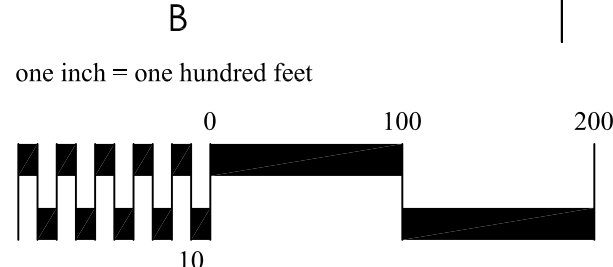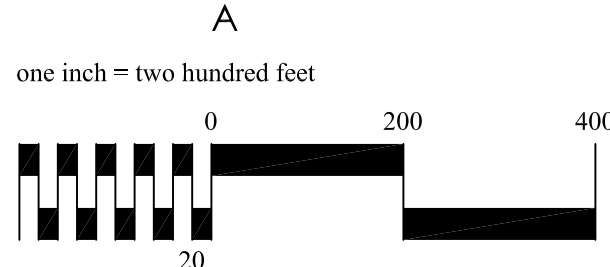

1 FLOOR PLAN

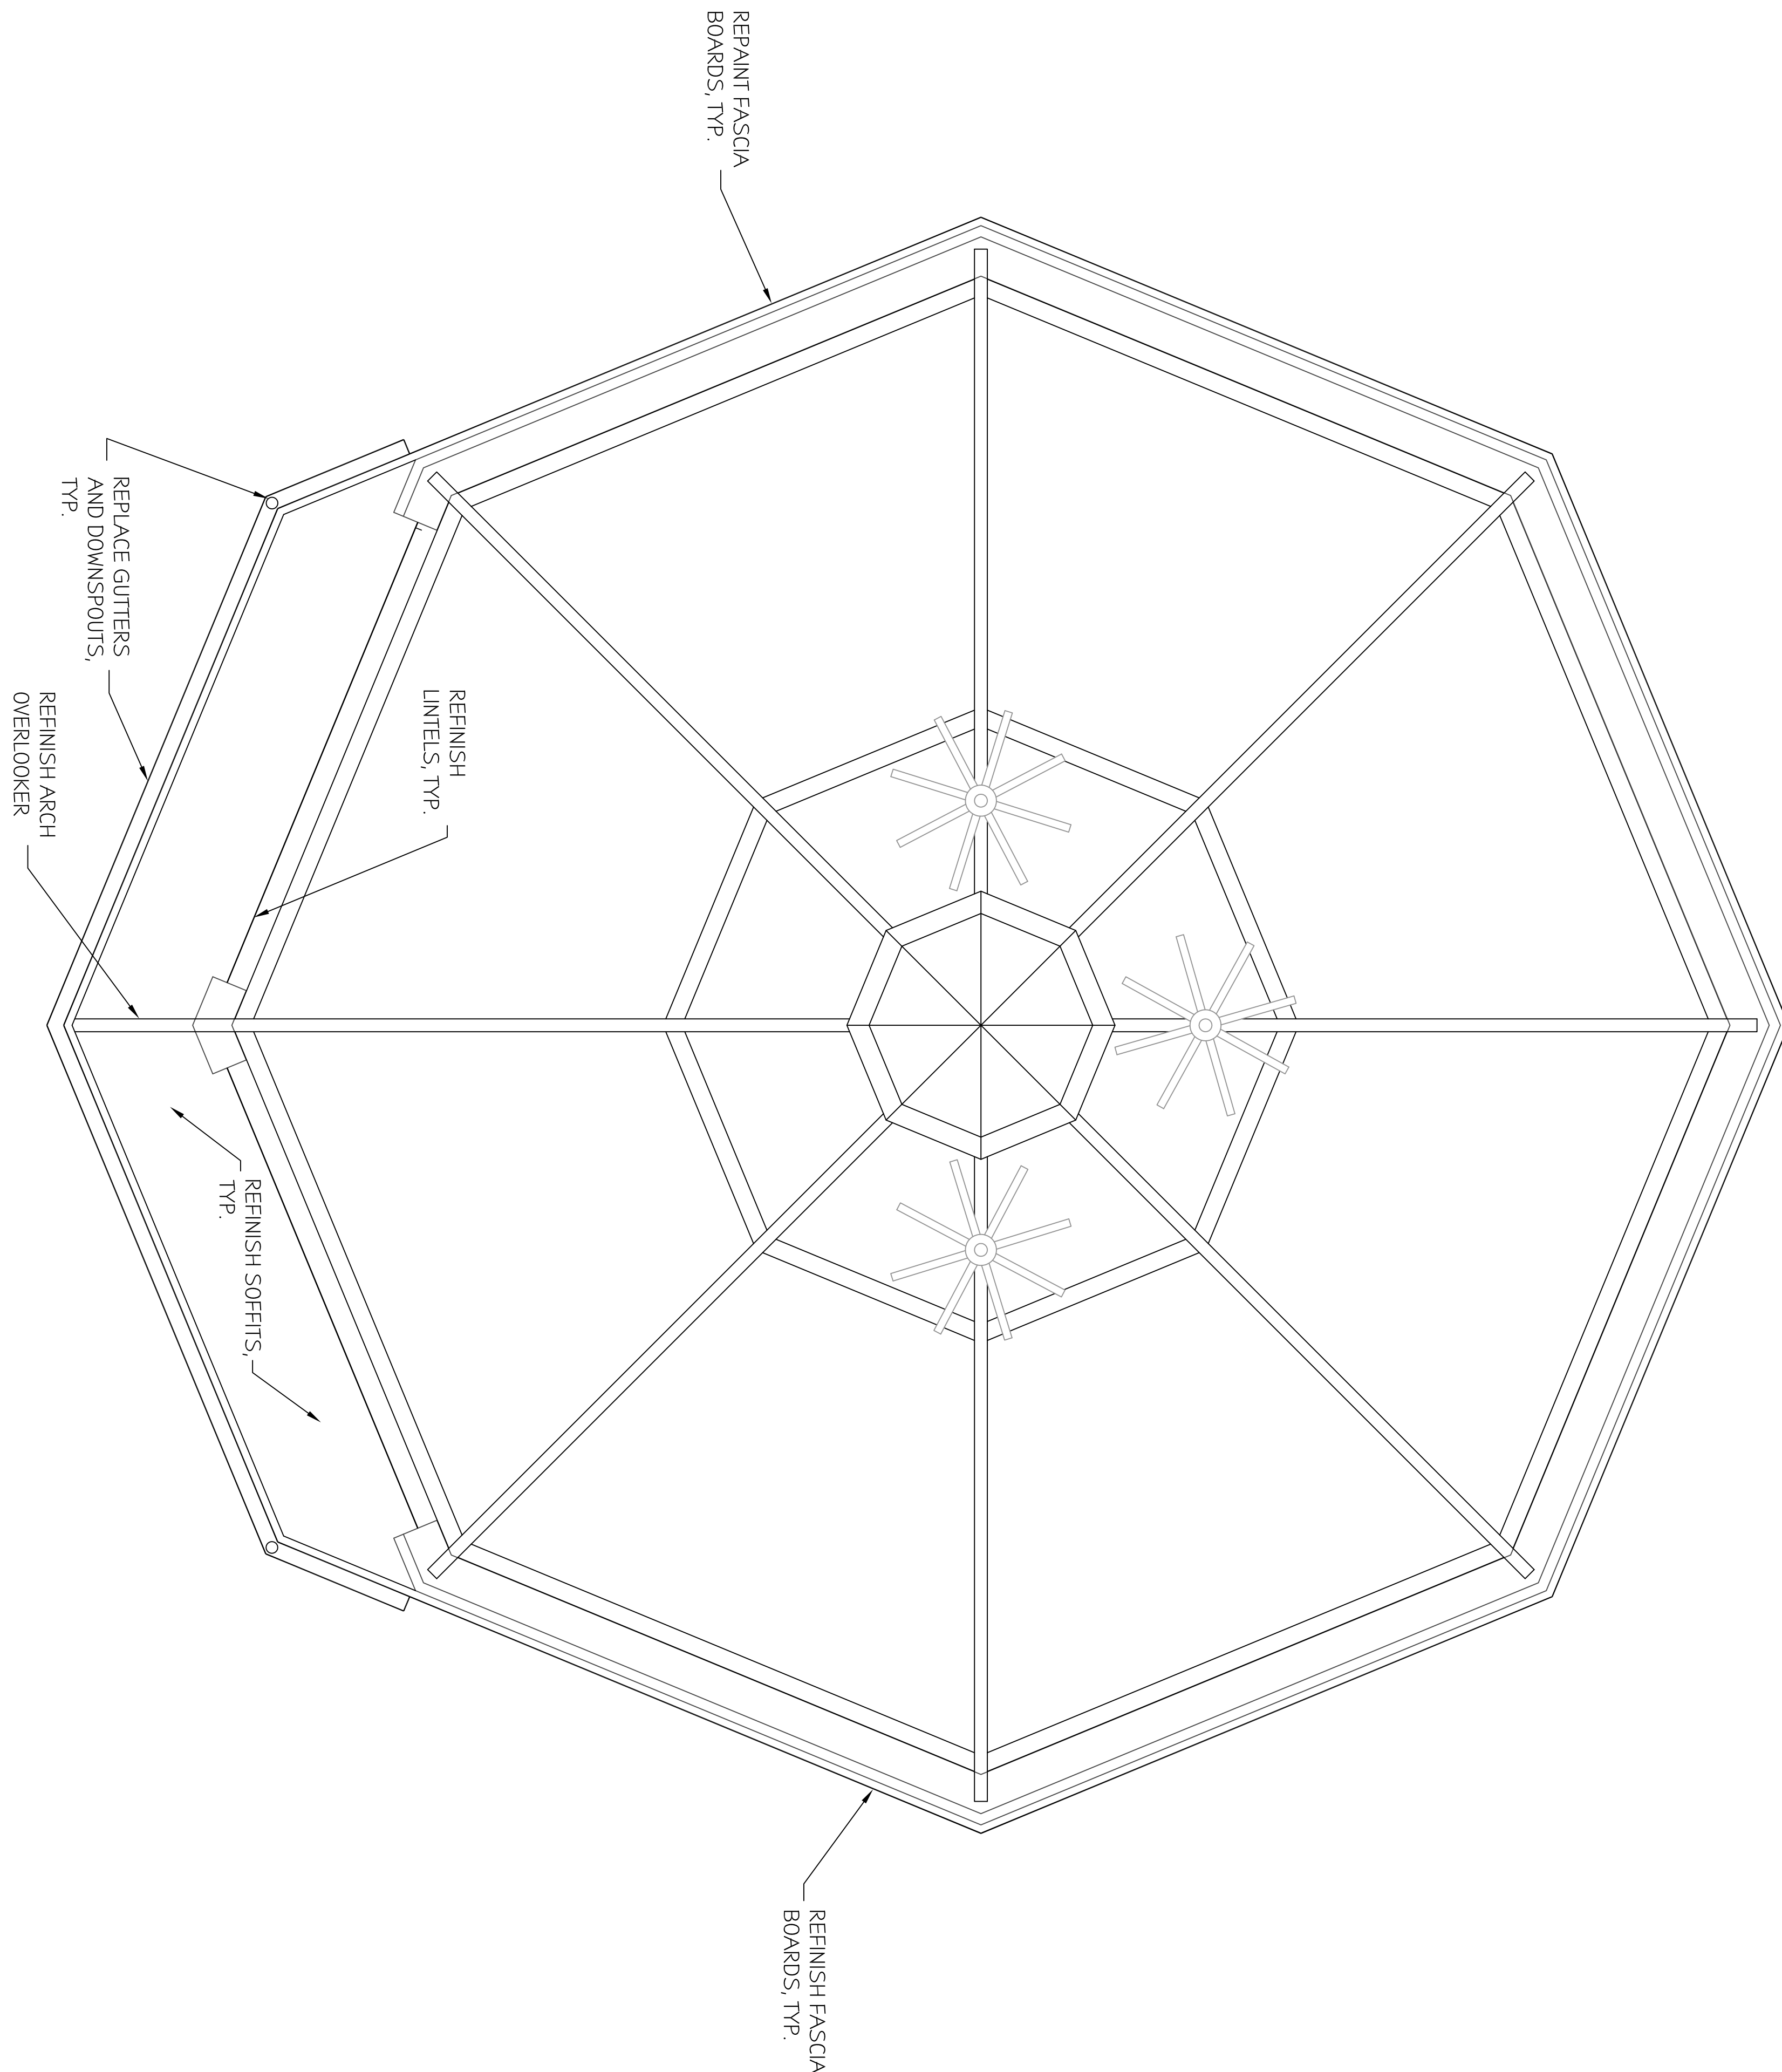

2 ROOF PLAN & REFLECTED CEILING

Revisions		Date	










Project Title		Project Title	
FLOOR AND ROOF PLANS, SHELTER		REPAIR & IMPRV, ADMIN & SHELTER	
Approved: Division Chief		Building Number	
Approved: Service Director		Checked	
		Drawn	
		CFC	
Location		DRAWING NO.	
BLACK HILLS NATIONAL CEMETERY		A-2	
		Dwg. 4 Of 6	

Date	
04/02/2015	
Project No	
884-15-201	




NATIONAL  
C EMETERY  
ADMINISTRATION



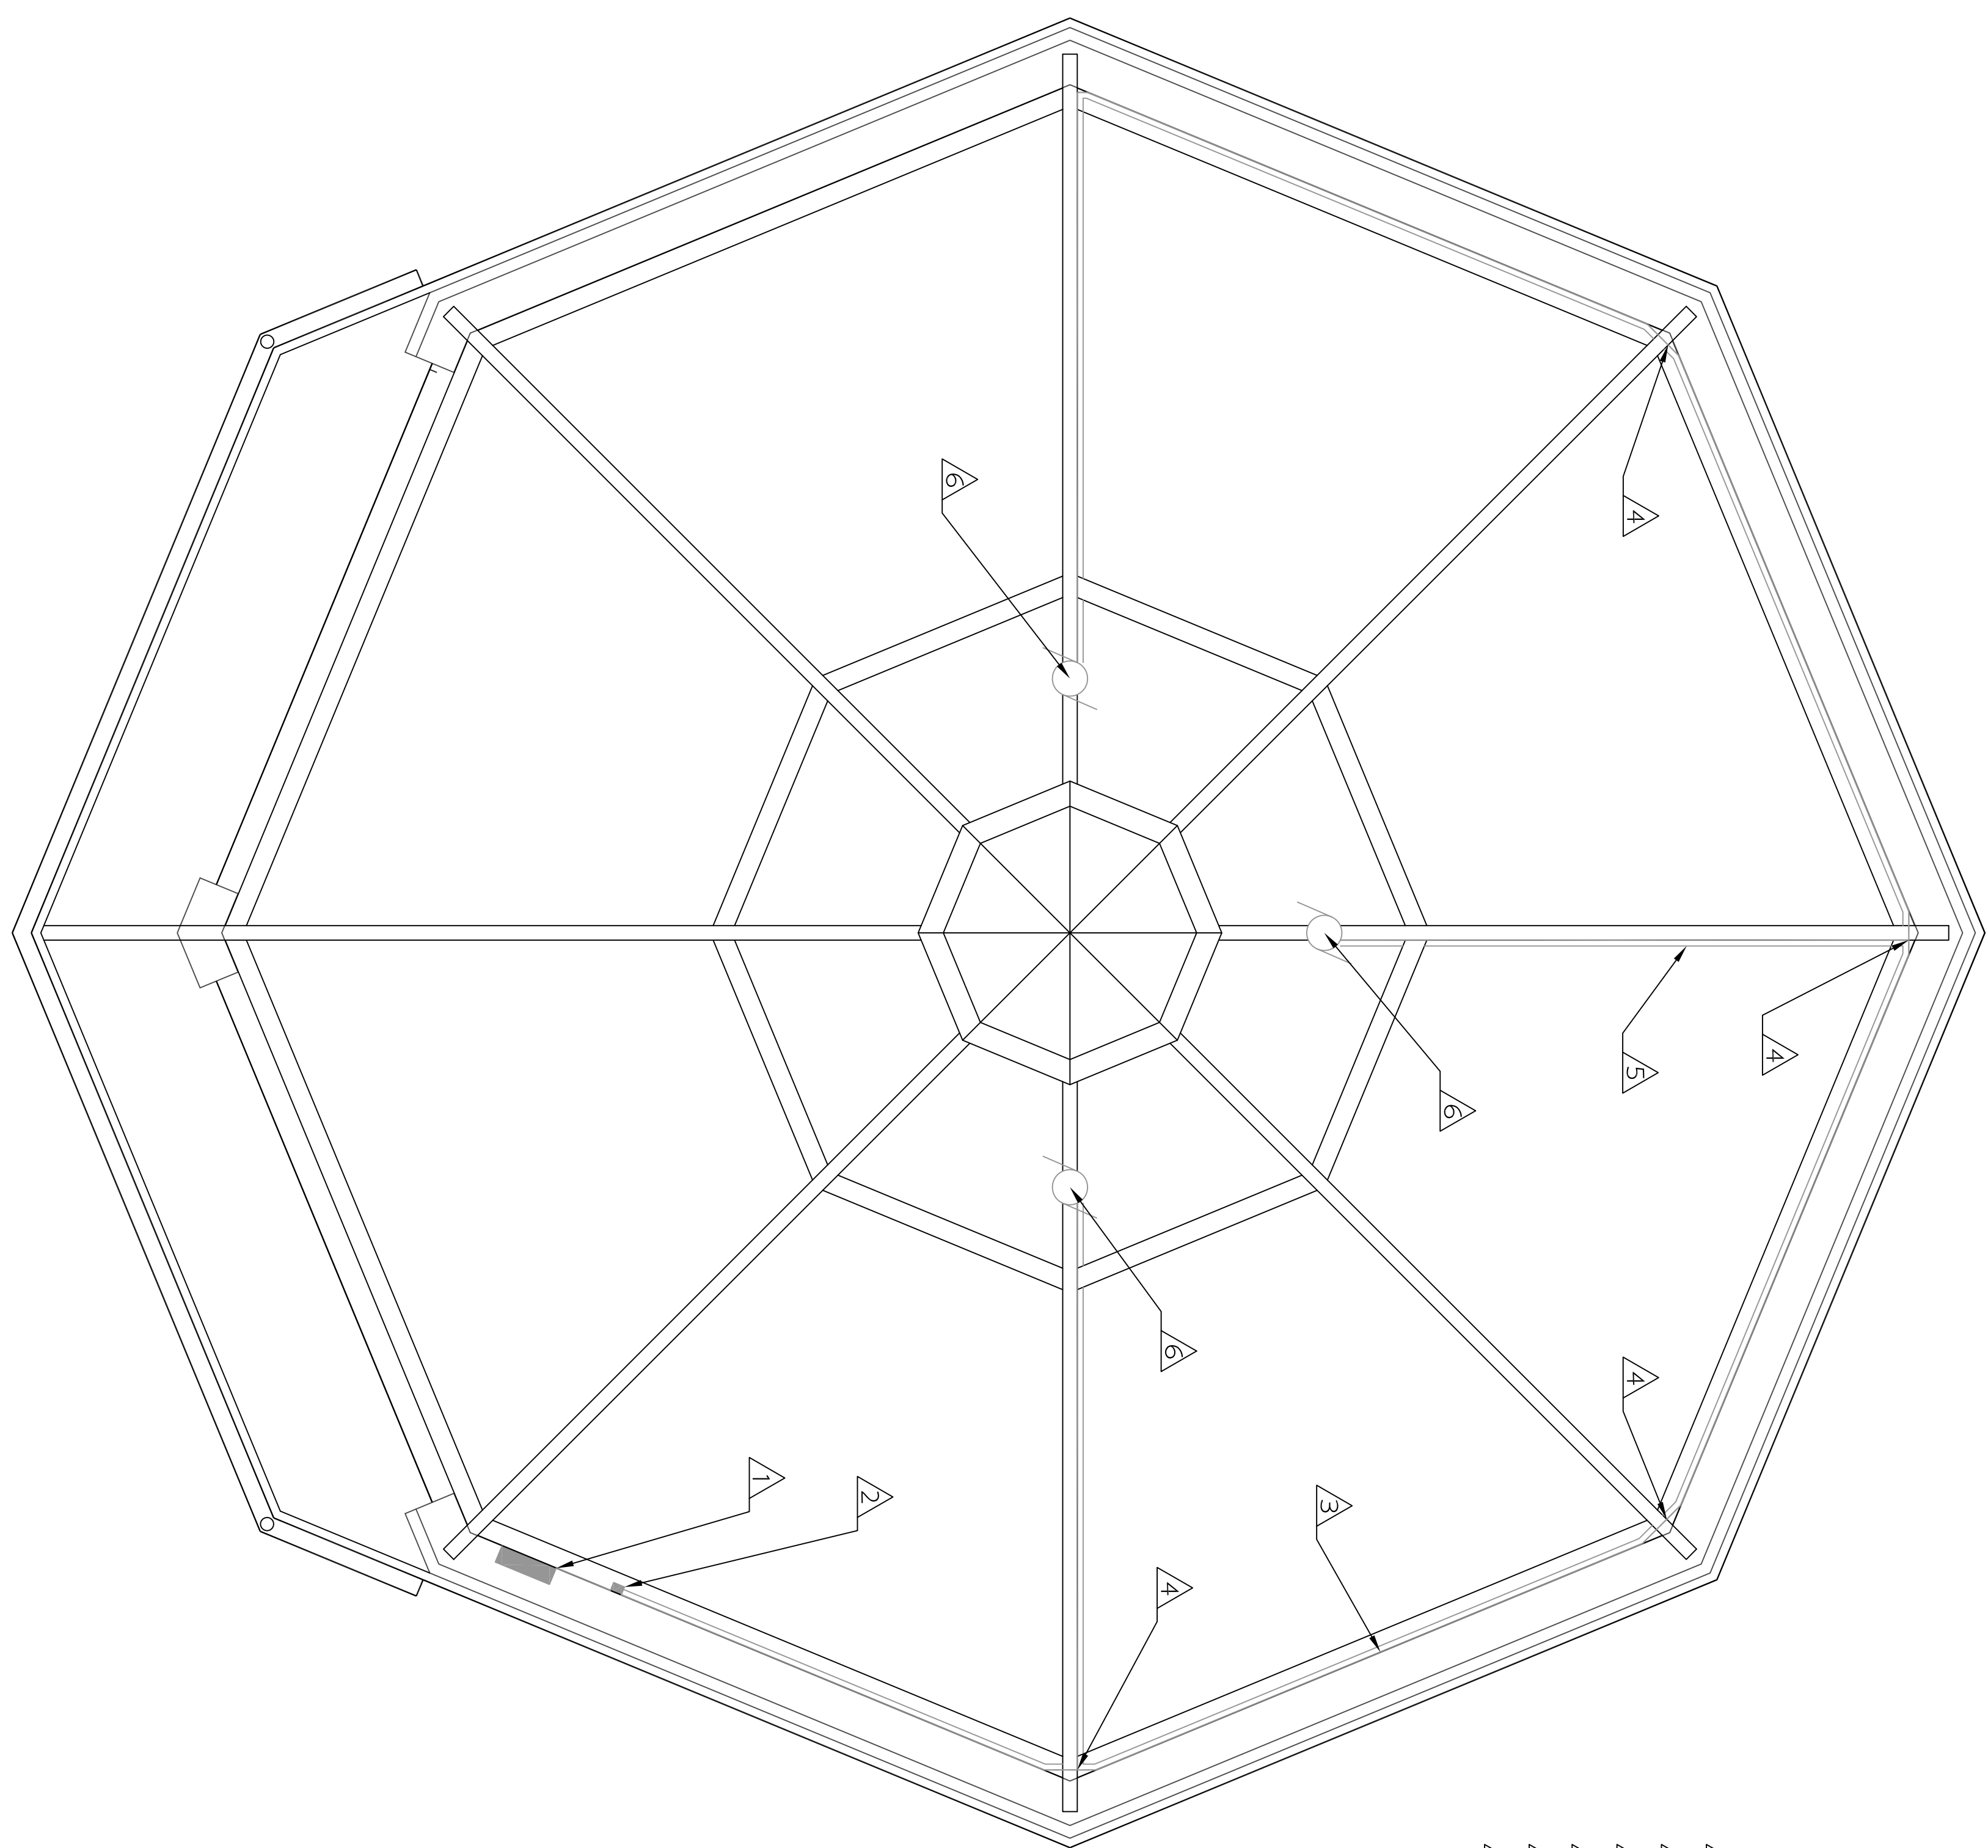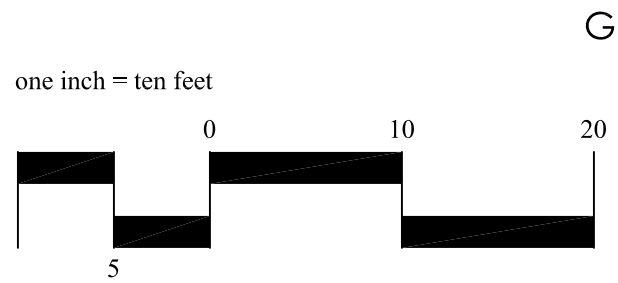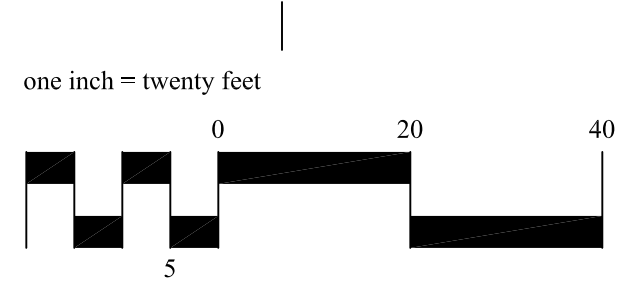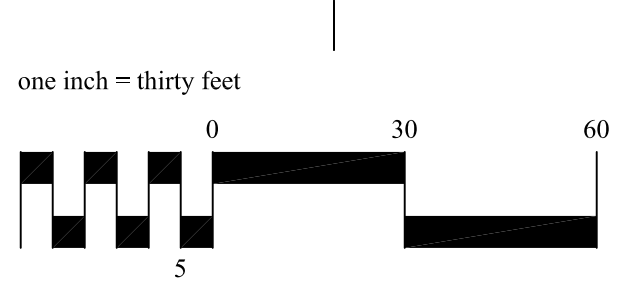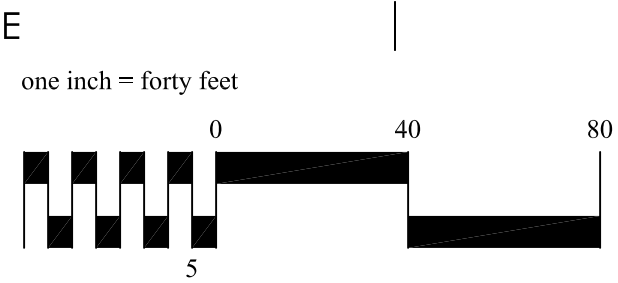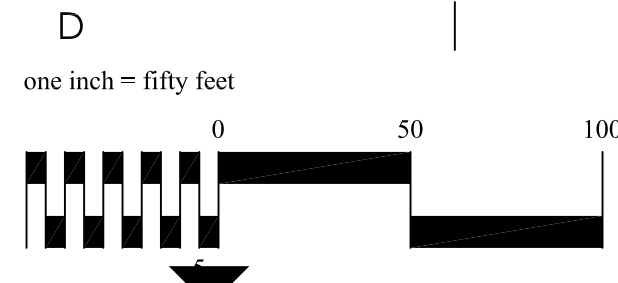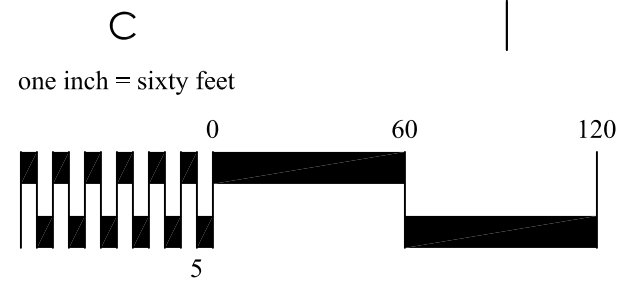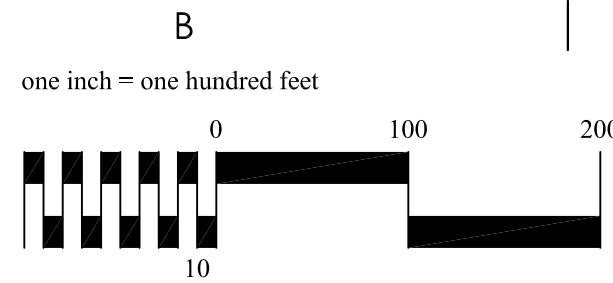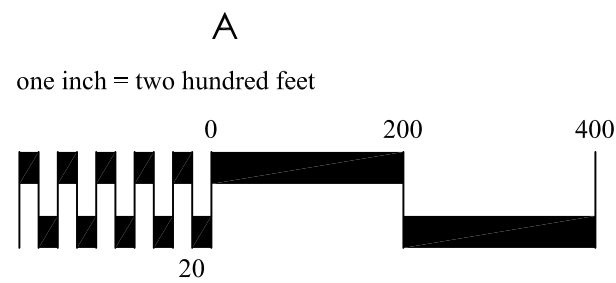

- KEYED NOTES:**
- 1 ELECTRICAL PANEL ENCLOSURE
  - 2 THERMOSTAT
  - 3 NON-METAL CHASE (NYP)
  - 4 RUN CONDUCTOR THROUGH BEAM
  - 5 ENGAGE CHASE IN STAINED WOOD Moulding (NYP)
  - 6 NEW JUNCTION BOX ON FACE OF ARCH

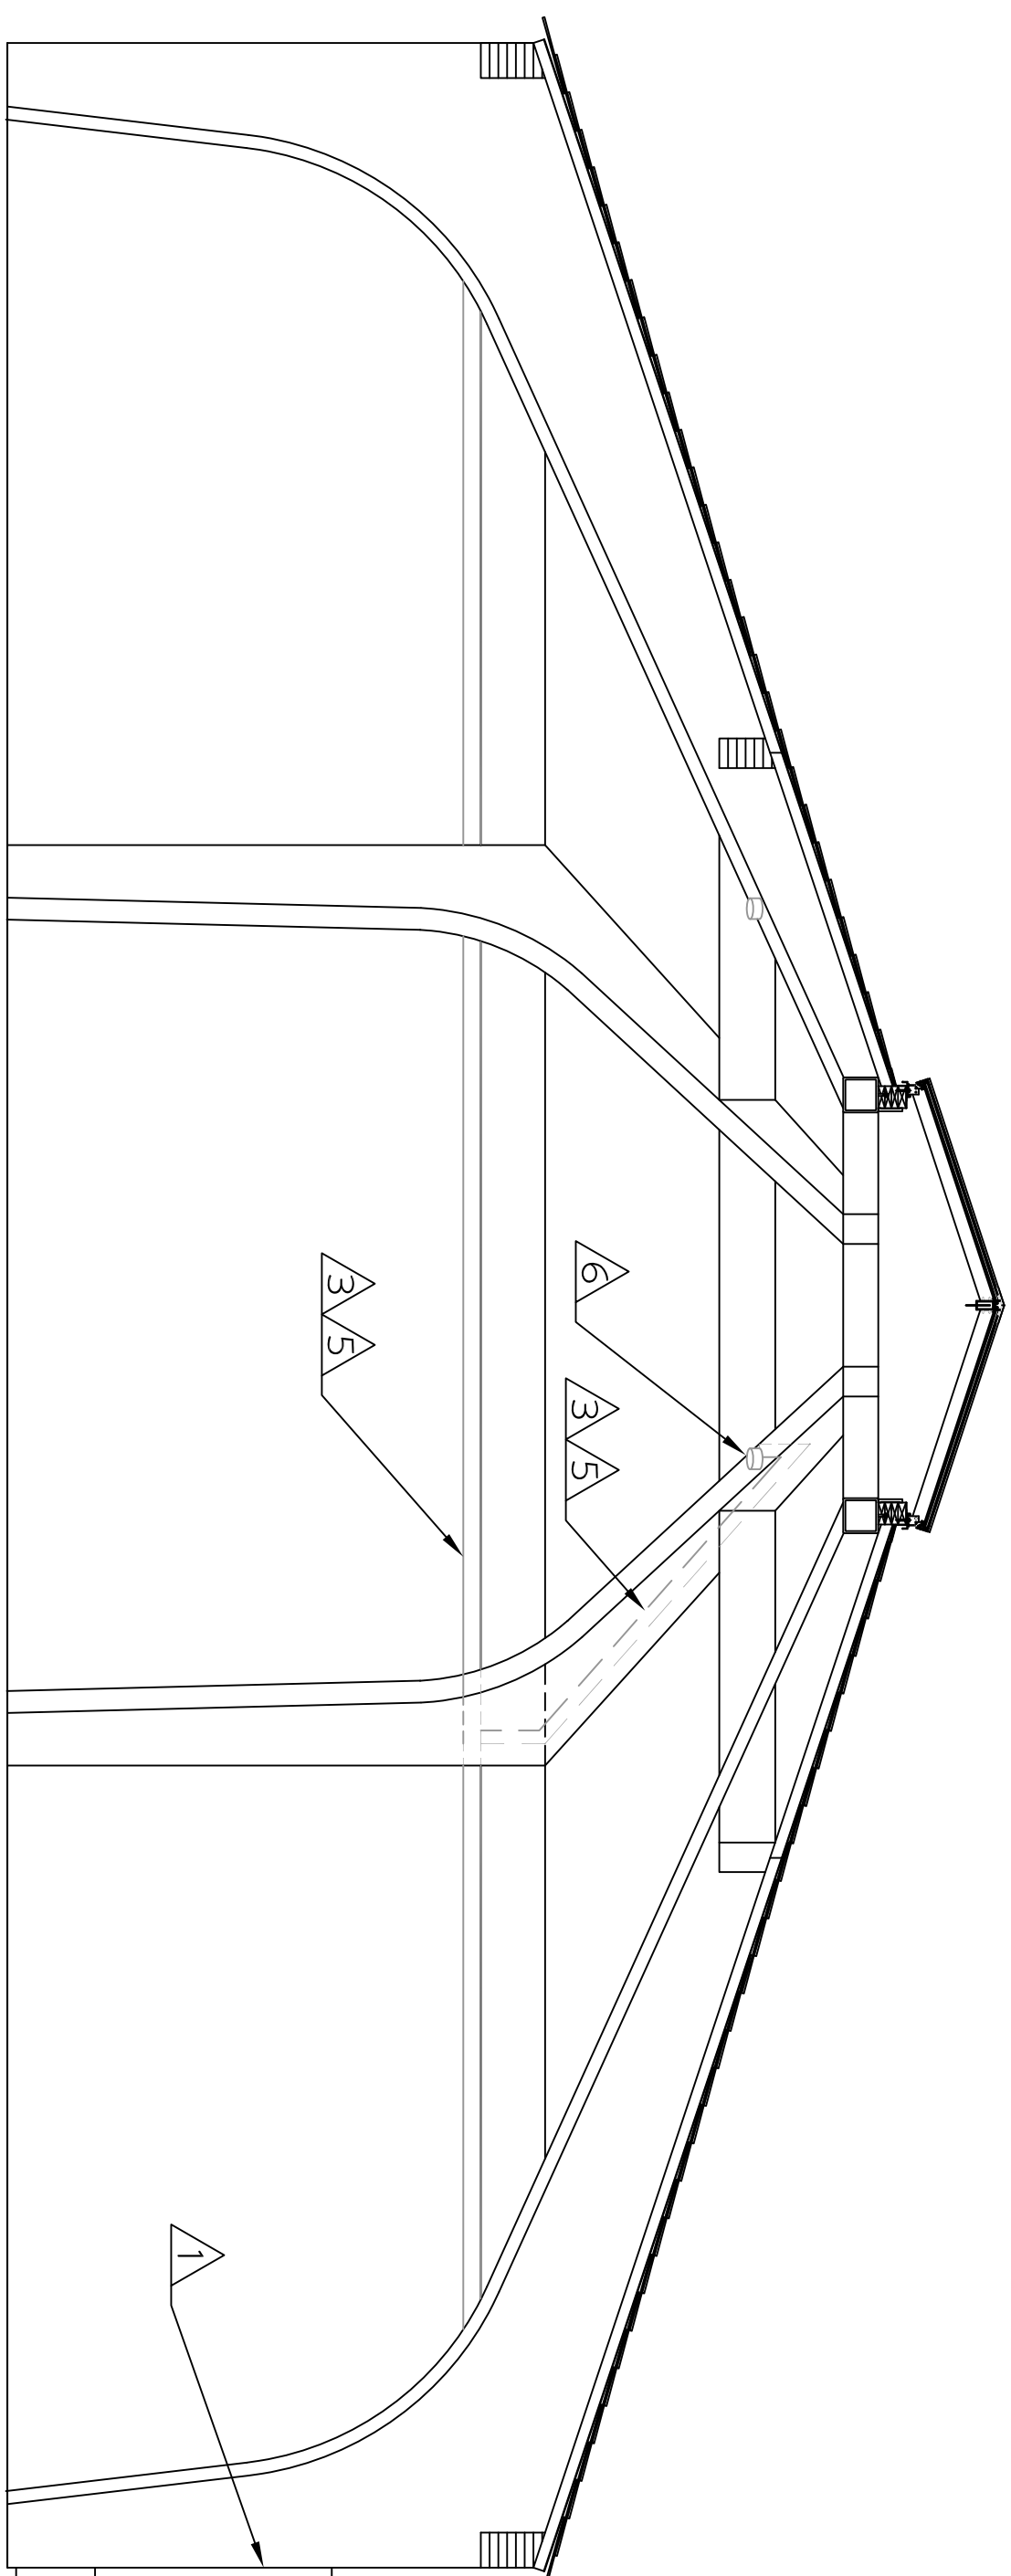

Revisions	Date		 NATIONAL CEMETERY ADMINISTRATION	Drawing Title <b>SHELTER          ELECTRICAL PLAN</b>	Date <b>04/02/2015</b>
				Project No. <b>884-15-201</b>	Project Title <b>REPAIR &amp; IMPRV.          ADMIN &amp; SHELTER</b>
				Approved: Division Chief  Approved: Service Director	Building Number *****
					Checked  Drawn <b>CFC</b>
					Location <b>BLACK HILLS NATIONAL CEMETERY</b>
					Drawing NO. <b>E-1</b>
					Dwg. 6 of 6