 
 


 
 
 





| Luminaire Schedule | | | | | | | | | | | |
|---|-------|----------|--------------|--|--|---|--------------|-------------------------------|-------------------|---------|-----------------|
| Symbol | Label | Quantity | Manufacturer | Catalog Number | Description | Lamp | Number Lamps | Filename | Light Loss Factor | Wattage | Lumens Per Lamp |
|  | F1 | 2 | | FMA1-22-22-18TSHO-2C-120-S-G-WH-T8 ONLY | APOLLO 1-2x2 RECESSED PATIENT BED LIGHT WITH EXAM FUNCTION. STEEL HOUSING. CONSTRUCTION. REFLECTORS FINISHED IN MATTE SATIN WHITE. POWDER COAT. ELECTRIC BALLAST. POLYESTER POWDER COAT FINISH (ONLY T8 LAMP ON) | ONE 17 WATT T8, G13 BASE & ONE 24 WATT T8HO G5 BASE T8HO LAMP OFF | 2 | FMA122T8-IE.S | 0.85 | 32 | 1400 |
| | | 4 | | FMA1-22-22-18TSHO-2C-120-S-G-WH-BOTH ON | APOLLO 1-2x2 STEEL CONSTRUCTION HOUSING. STEEL SIDE REFLECTORS FINISHED IN MATTE SATIN WHITE. POWDER COAT. ELECTRIC BALLAST. POLYESTER POWDER COAT FINISH. BOTH LAMPS ON | TWO 24 WATT T8HO, G5 BASE & TWO 17 WATT T8, G13 BASE | 1 | FMA122T8T5-HO-IE.S | 0.85 | 85 | 6800 |
|  | F2/F3 | 12 | | CJ24-2T8 | Converj 2x4. Highly Reflective White Reflectors | 2 - 32W T8 | 2 | CJ24-2T8.ies | 0.85 | 59 | 2900 |
| | | 8 | | CJ22-2T8 | Converj 2x2. Highly Reflective White Reflectors | 2 - 17W T8 | 2 | CJ22-2T8.ies | 0.85 | 32 | 1350 |
|  | F6 | 13 | | 2SPB 3 32 A12125 GB101S | SPB SPECIFICATION PREMIUM T8 TROFFER 2'X 4' 3 LP T8 #A12125 LENS ELEC | TWO 32-WATT T8 LINEAR FLUORESCENT. | 2 | 2SPB_3_32_A12125_GEB 101S.ies | 0.85 | 58 | 2850 |
| | | 7 | | 2SPB 3 32 A12125 1/3 ADDE | SPB SPECIFICATION PREMIUM T8 TROFFER 2'X 4' 3 LP T8 #A12125 1/3 LENS 1/3 ELEC | THREE 32-WATT T8 LINEAR FLUORESCENT. | 3 | 2SPB_3_32_A12125_1_3_ADDE.ies | 0.85 | 88 | 2850 |
|  | F8 | 0 | | 2SPB G 2 17 A12 120 TUBI | SPECIFICATION PREMIUM TROFFER 2' X 2' 2 LAMP T8(17W) REVERSE APEX PATTERN #12 | 101741K RATED 1350 LUMENS/LAMP | 2 | 2SPB_G_2_1_7_A12_120_TUBI.ies | 0.85 | 33 | 1350 |
|  | F9 | 1 | | W 217 MVOLT GB101S | INDIRECT/DIRECT LUMINAIRE | TWO 17-WATT LINEAR FLUORESCENT. HORIZONTAL POS. | 2 | W_217_MVO LT_GB101S.ies | 0.85 | 29 | 1400 |
| | | 6 | | CJ24-3T8 | Converj 2x4. Highly Reflective White Reflectors | 3 - 32W T8 | 3 | CJ24-3T8.ies | 0.85 | 87 | 2900 |
|  | L1 | 4 | | FL6D-11LED-L30-120-RD-T L6-RD-ON-CD | PHILIPS FORTIMO 1100 LUMEN 3000K LED MODULE 6" DIA RECESSED LUMINAIRE w/SPRIN ALUM PARABOLIC REF CONE ADVANCE XITANIUM #9137 012 13402 ELEC 120V 100W 19.9W | | 1 | FL6D11LED L30-IES | 0.9 | 20 | 948.1703 |
| | | 12 | | FL6D-13LED-L30-120-RD-T L6-RD-ON-CD | PHILIPS FORTIMO 1300 LUMEN 3000K LED MODULE 6" DIA RECESSED LUMINAIRE w/SPRIN ALUM PARABOLIC REF CONE ADVANCE XITANIUM #9137 012 13402 ELEC 120V 200W 23.7W | | 1 | FL6D13LED L30-IES | 0.9 | 24 | 1113.069 |
|  | L3 | 23 | | FL6D-20LED-L30-120-RD-T L6-RD-ON-CD-NP (OTS0108S REV X2) | FORMED STEEL HOUSING. CAST ALUMINUM HEATSINK. SPRIN SEMI-SPECULAR ALUMINUM REFLECTOR. NO ENCLOSURE. | ONE WHITE LED | 1 | FL6D20LED L30-IES | 0.9 | 37.7 | 1684.342 |

Plan View
Scale - 3/16" = 1'

| Statistics | | | | | | | |
|----------------------------------|--------|---------|---------|---------|---------|---------|---------|
| Description | Symbol | Avg | Max | Min | Max/Min | Avg/Min | Avg/Max |
| ANTE 2C108 | + | 19.5 fc | 20.6 fc | 18.2 fc | 1.1:1 | 1.1:1 | 0.9:1 |
| BG/RT OFFICE 2C134 | + | 46.6 fc | 56.0 fc | 37.2 fc | 1.5:1 | 1.3:1 | 0.8:1 |
| BG/RT STORAGE | + | 30.3 fc | 39.7 fc | 21.3 fc | 1.9:1 | 1.4:1 | 0.8:1 |
| CLEAN UTILITY 2C123E | + | 31.8 fc | 41.3 fc | 22.6 fc | 1.8:1 | 1.4:1 | 0.8:1 |
| CONSULTATION 2C133 | + | 31.2 fc | 41.9 fc | 18.3 fc | 2.3:1 | 1.7:1 | 0.7:1 |
| FAMILY LOUNGE/PANTRY 2C113 | + | 36.1 fc | 59.2 fc | 13.5 fc | 4.4:1 | 2.7:1 | 0.6:1 |
| HAC/EMS 2C140 | + | 35.6 fc | 39.5 fc | 31.8 fc | 1.2:1 | 1.1:1 | 0.9:1 |
| LINEN 2C118 | + | 61.6 fc | 69.2 fc | 54.5 fc | 1.3:1 | 1.1:1 | 0.9:1 |
| LOCKER 2C126 | + | 35.0 fc | 44.6 fc | 21.5 fc | 2.1:1 | 1.6:1 | 0.8:1 |
| MEDS 2C117 | + | 58.9 fc | 67.0 fc | 50.6 fc | 1.3:1 | 1.2:1 | 0.9:1 |
| NOURISHMENT 2C116 | + | 42.6 fc | 48.8 fc | 34.8 fc | 1.4:1 | 1.2:1 | 0.9:1 |
| OFFICE 2C122A | + | 40.5 fc | 52.5 fc | 26.4 fc | 2.0:1 | 1.5:1 | 0.8:1 |
| OFFICE MANAGER 2C122 | + | 38.3 fc | 52.3 fc | 24.7 fc | 2.1:1 | 1.6:1 | 0.7:1 |
| PATIENT 2C107 | + | 37.8 fc | 52.9 fc | 21.2 fc | 2.5:1 | 1.8:1 | 0.7:1 |
| PATIENT 2C107 (Only T8 Lamps On) | + | 31.8 fc | 43.1 fc | 18.6 fc | 2.3:1 | 1.7:1 | 0.7:1 |
| PATIENT 3 ISO 2C108A | + | 35.9 fc | 48.1 fc | 15.7 fc | 3.1:1 | 2.3:1 | 0.7:1 |
| RT WORKROOM 2C110A | + | 49.7 fc | 63.2 fc | 37.4 fc | 1.7:1 | 1.3:1 | 0.8:1 |
| SOILED UTILITY 2C111 | + | 45.3 fc | 54.5 fc | 34.8 fc | 1.6:1 | 1.3:1 | 0.8:1 |
| STAFF LOUNGE 2C126C | + | 26.2 fc | 36.2 fc | 16.5 fc | 2.2:1 | 1.6:1 | 0.7:1 |
| STORAGE 2C112 | + | 32.0 fc | 37.7 fc | 25.3 fc | 1.5:1 | 1.3:1 | 0.8:1 |
| STORAGE 2C122B | + | 22.8 fc | 27.6 fc | 16.3 fc | 1.7:1 | 1.4:1 | 0.8:1 |
| TEAM WORKROOM 2C130 | + | 46.0 fc | 62.4 fc | 31.7 fc | 2.0:1 | 1.5:1 | 0.7:1 |
| TOILET 2 2C107A | + | 15.9 fc | 18.1 fc | 13.7 fc | 1.3:1 | 1.2:1 | 0.9:1 |
| WARD CLERK (2) 2C141 | + | 25.9 fc | 38.6 fc | 12.8 fc | 3.0:1 | 2.0:1 | 0.7:1 |
| WOMENS 2C126B | + | 0.0 fc | 0.0 fc | 0.0 fc | N/A | N/A | N/A |

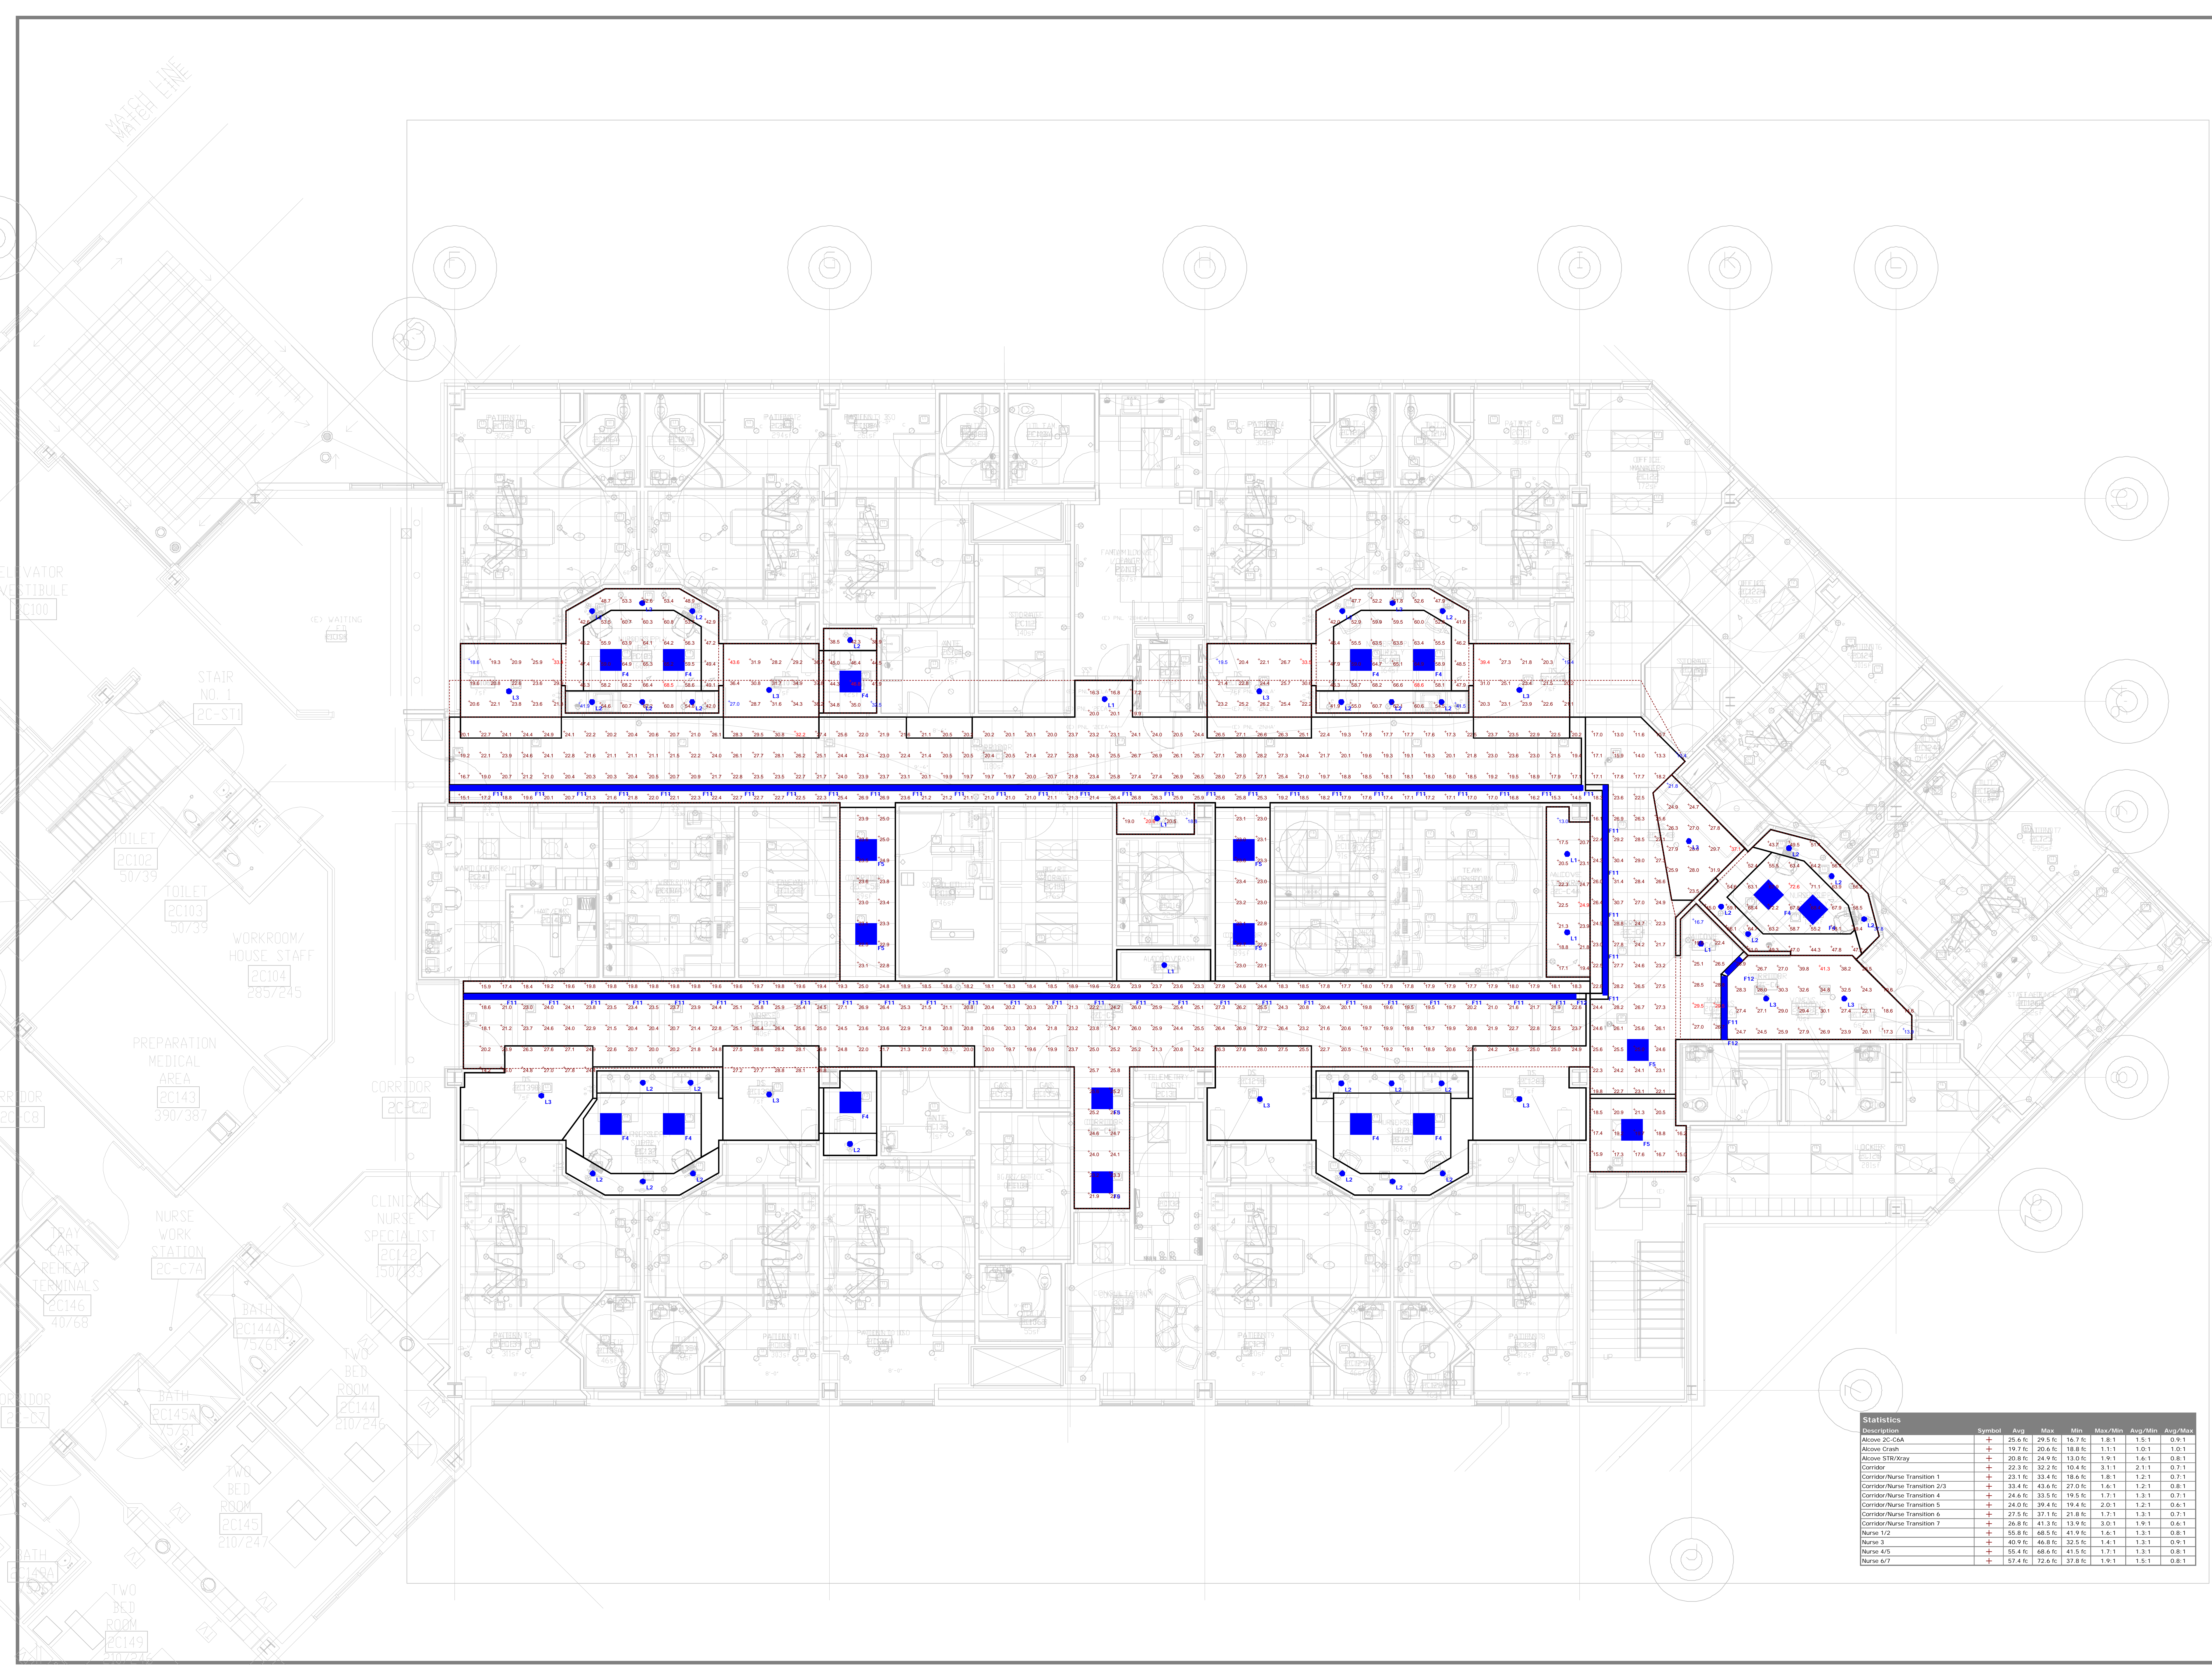

| Statistics | | | | | | |
|-------------------------------|--------|-----------|-----------|-----------|---------|---------|
| Description | Symbol | Avg | Max | Min | Max/Min | Avg/Min |
| Alcove 2C-C6A | + | 25.6 f.c. | 29.5 f.c. | 16.7 f.c. | 1.8:1 | 1.5:1 |
| Alcove Crath | + | 19.7 f.c. | 20.6 f.c. | 18.8 f.c. | 1.1:1 | 1.0:1 |
| Alcove STR/Way | + | 20.8 f.c. | 24.9 f.c. | 13.0 f.c. | 1.9:1 | 1.6:1 |
| Corridor | + | 22.3 f.c. | 32.2 f.c. | 10.4 f.c. | 3.1:1 | 2.1:1 |
| Corridor/Nurse Transition 1 | + | 23.1 f.c. | 33.4 f.c. | 18.6 f.c. | 1.8:1 | 1.2:1 |
| Corridor/Nurse Transition 2/3 | + | 33.4 f.c. | 43.6 f.c. | 27.0 f.c. | 1.6:1 | 1.2:1 |
| Corridor/Nurse Transition 4 | + | 24.6 f.c. | 33.5 f.c. | 19.5 f.c. | 1.7:1 | 1.3:1 |
| Corridor/Nurse Transition 5 | + | 24.0 f.c. | 39.4 f.c. | 19.4 f.c. | 2.0:1 | 1.2:1 |
| Corridor/Nurse Transition 6 | + | 27.5 f.c. | 37.1 f.c. | 21.8 f.c. | 1.7:1 | 1.3:1 |
| Corridor/Nurse Transition 7 | + | 26.8 f.c. | 41.3 f.c. | 13.9 f.c. | 3.0:1 | 1.9:1 |
| Nurse 1/2 | + | 55.8 f.c. | 68.5 f.c. | 41.9 f.c. | 1.6:1 | 1.3:1 |
| Nurse 3 | + | 40.9 f.c. | 46.0 f.c. | 32.5 f.c. | 1.4:1 | 1.3:1 |
| Nurse 4/5 | + | 55.4 f.c. | 68.6 f.c. | 41.5 f.c. | 1.7:1 | 1.3:1 |
| Nurse 6/7 | + | 57.4 f.c. | 72.6 f.c. | 37.8 f.c. | 1.9:1 | 1.5:1 |