


PROJECT: Upgrade Canteen  
 Refrigeration and Dishwashing  
 PROJECT NO: 623-15-102  
 Jack C. Montgomery VA Medical Center  
 Muskogee, Oklahoma




INDEX OF DRAWINGS

- TS-1 Title Sheet
- S-1 General Notes
- S-2 Reefer Structural Details
- A-1 Reefer Architectural Details
- AM-1 Dishwasher Room Architectural and Mechanical Details
- E-1 Electrical Basement Floor
- E-2 Electrical First Floor
- E-3 Electrical Sub-Basement/Ground Floor

DEPARTMENT OF

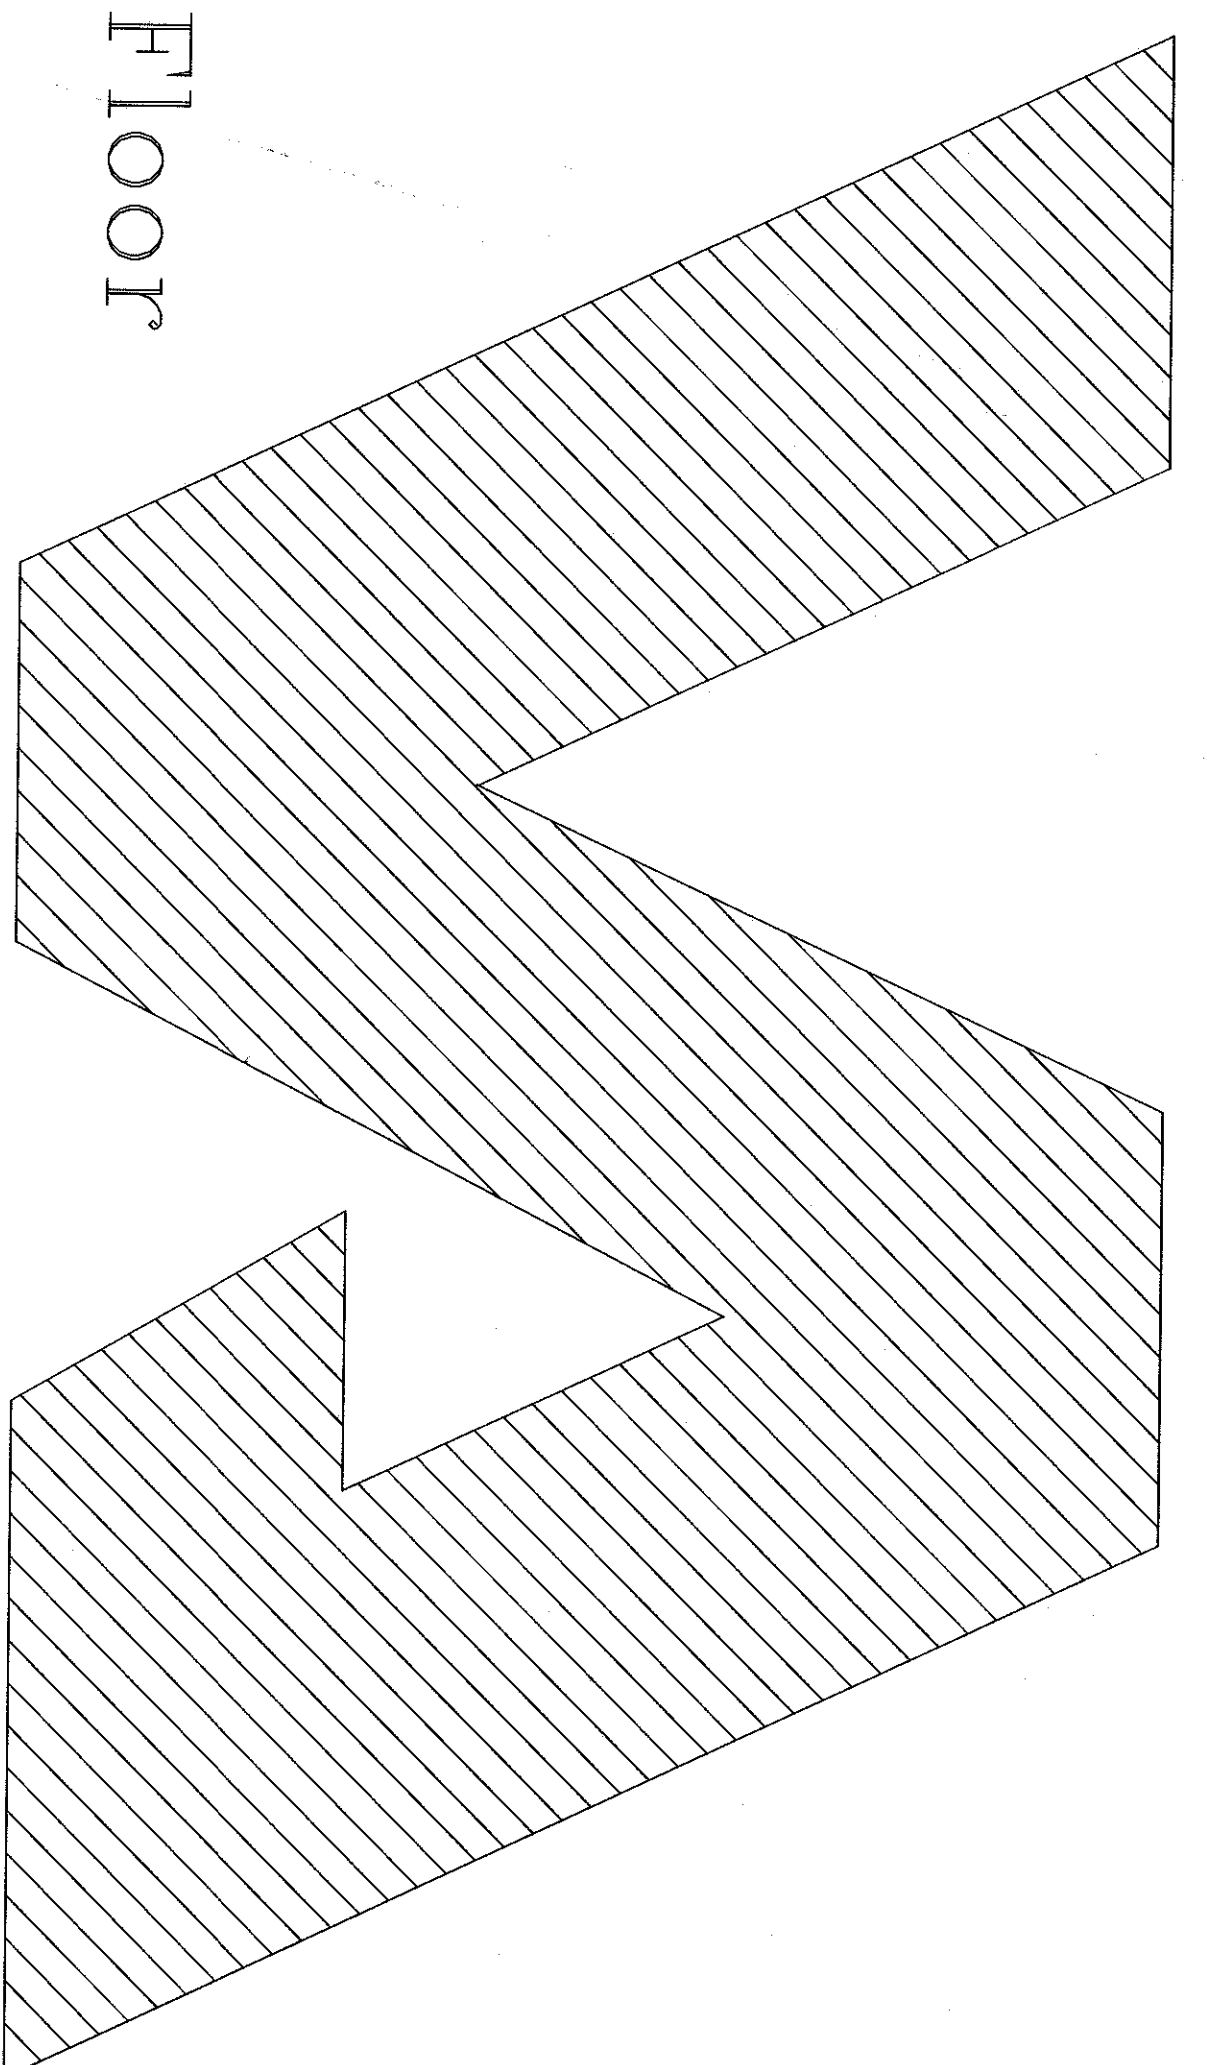

VETERANS AFFAIRS

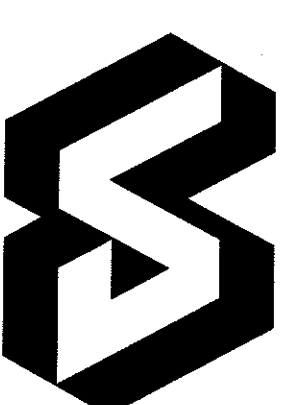 <p>Dept. of Veterans Affairs          Medical Center          1011 Honor Heights Drive          Muskogee, OK 74401</p>		<p>APPROVED: <i>[Signature]</i>          Medical Center Director</p>		<p>APPROVED: <i>[Signature]</i>          Project Manager</p>		<p>APPROVED: <i>[Signature]</i>          Contract Administrator</p>		<p>APPROVED: <i>[Signature]</i>          Building No. 24</p>		<p>DATE: 09JUN2014          SCALE: NTS          DRAWING NO: TS-1          DWG. 1 OF 8</p>	
<p>PROJECT TITLE: Upgrade Canteen Refrigeration &amp; Dishwashing</p>		<p>PROJECT NO: 623-15-102</p>		<p>CONTRACT NO: 62315102</p>		<p>ISSUED BY: B. Short</p>		<p>REVISION BY:</p>		<p>LOCATION: V.A.M.C MUSKOGEE, OK</p>	
<p>DRAWING TITLE: Title Sheet</p>		<p>PROJECT NO: 623-15-102</p>		<p>CONTRACT NO: 62315102</p>		<p>ISSUED BY: B. Short</p>		<p>REVISION BY:</p>		<p>LOCATION: V.A.M.C MUSKOGEE, OK</p>	