
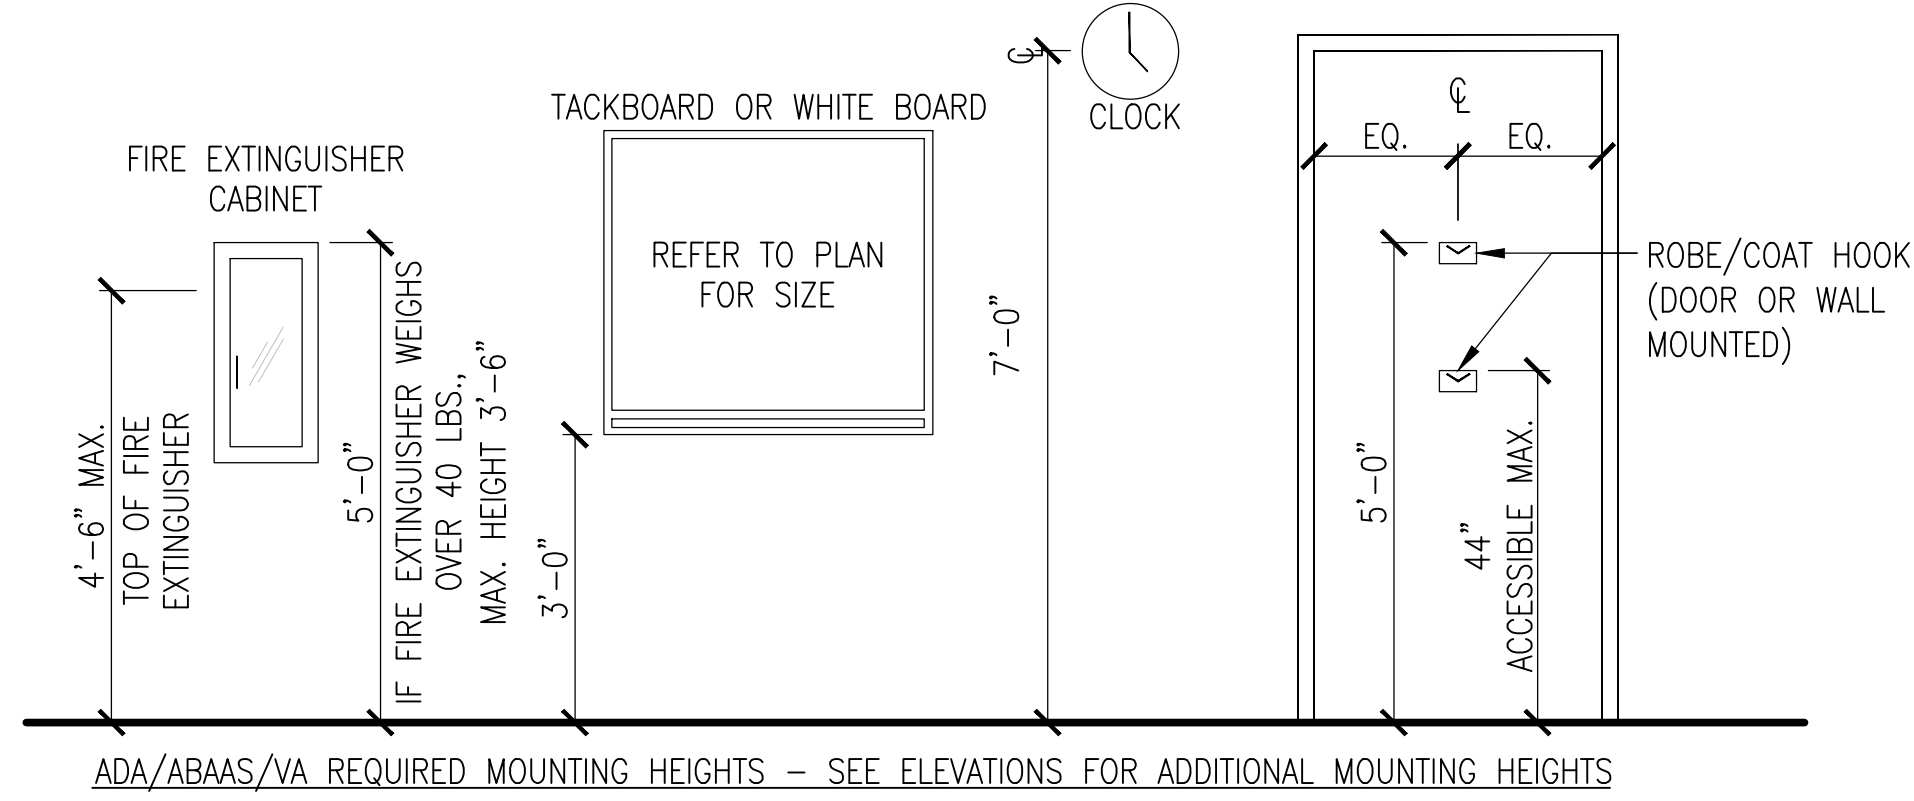


three inches = one foot
one and one half inches = one foot
one inch = one foot
three quarters inch = one foot
one half inch = one foot
three eighths inch = one foot
one quarter inch = one foot
one eighth inch = one foot

VA Fayetteville V-E DD June 2013 Task Orders Renovate B-Wing 5th Floor for Mental Health 08-34220 AM CAD 6-10-15 08-34220 AM CAD

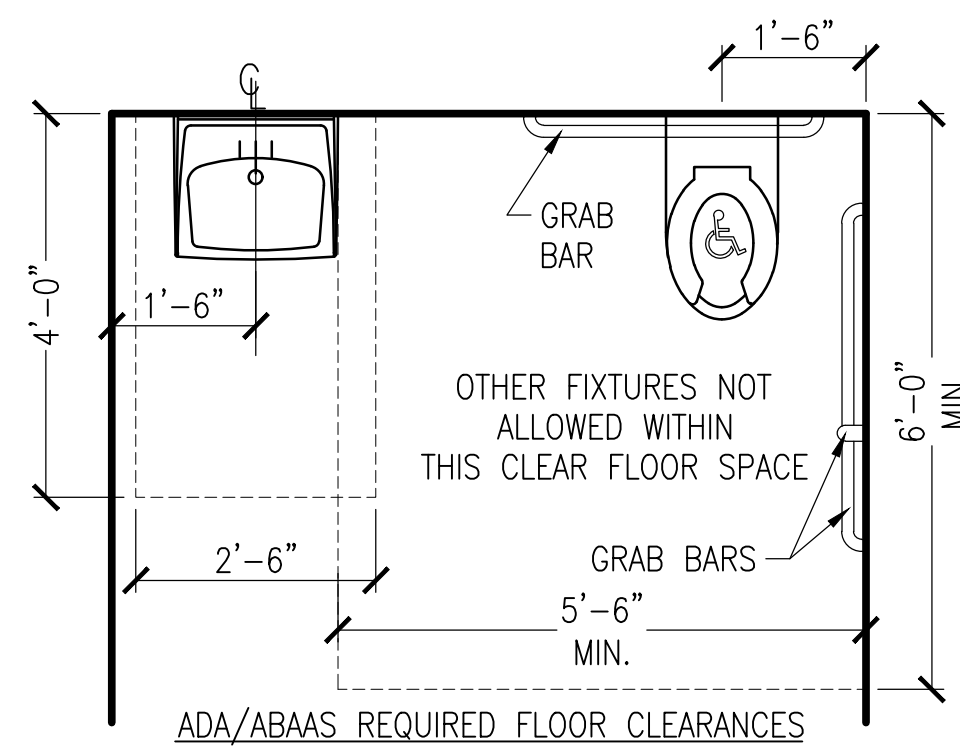


PROJECTED OBJECTS

SPACING. THE SPACE BETWEEN THE WALL AND THE GRAB BAR SHALL BE 1 1/2 INCHES (38 MM). THE SPACE BETWEEN THE GRAB BAR AND PROJECTING OBJECTS BELOW AND AT THE ENDS SHALL BE 1 1/2 INCHES (38 MM) MINIMUM. THE SPACE BETWEEN THE GRAB BAR AND PROJECTING OBJECTS ABOVE SHALL BE 12 INCHES (305 MM) MINIMUM.

RECESSED OBJECTS


1 TYP. MOUNTING HGTS & DETAILS

SCALE: 1/2" = 1'-0"
SCALE: 1/2" = 1'-0"

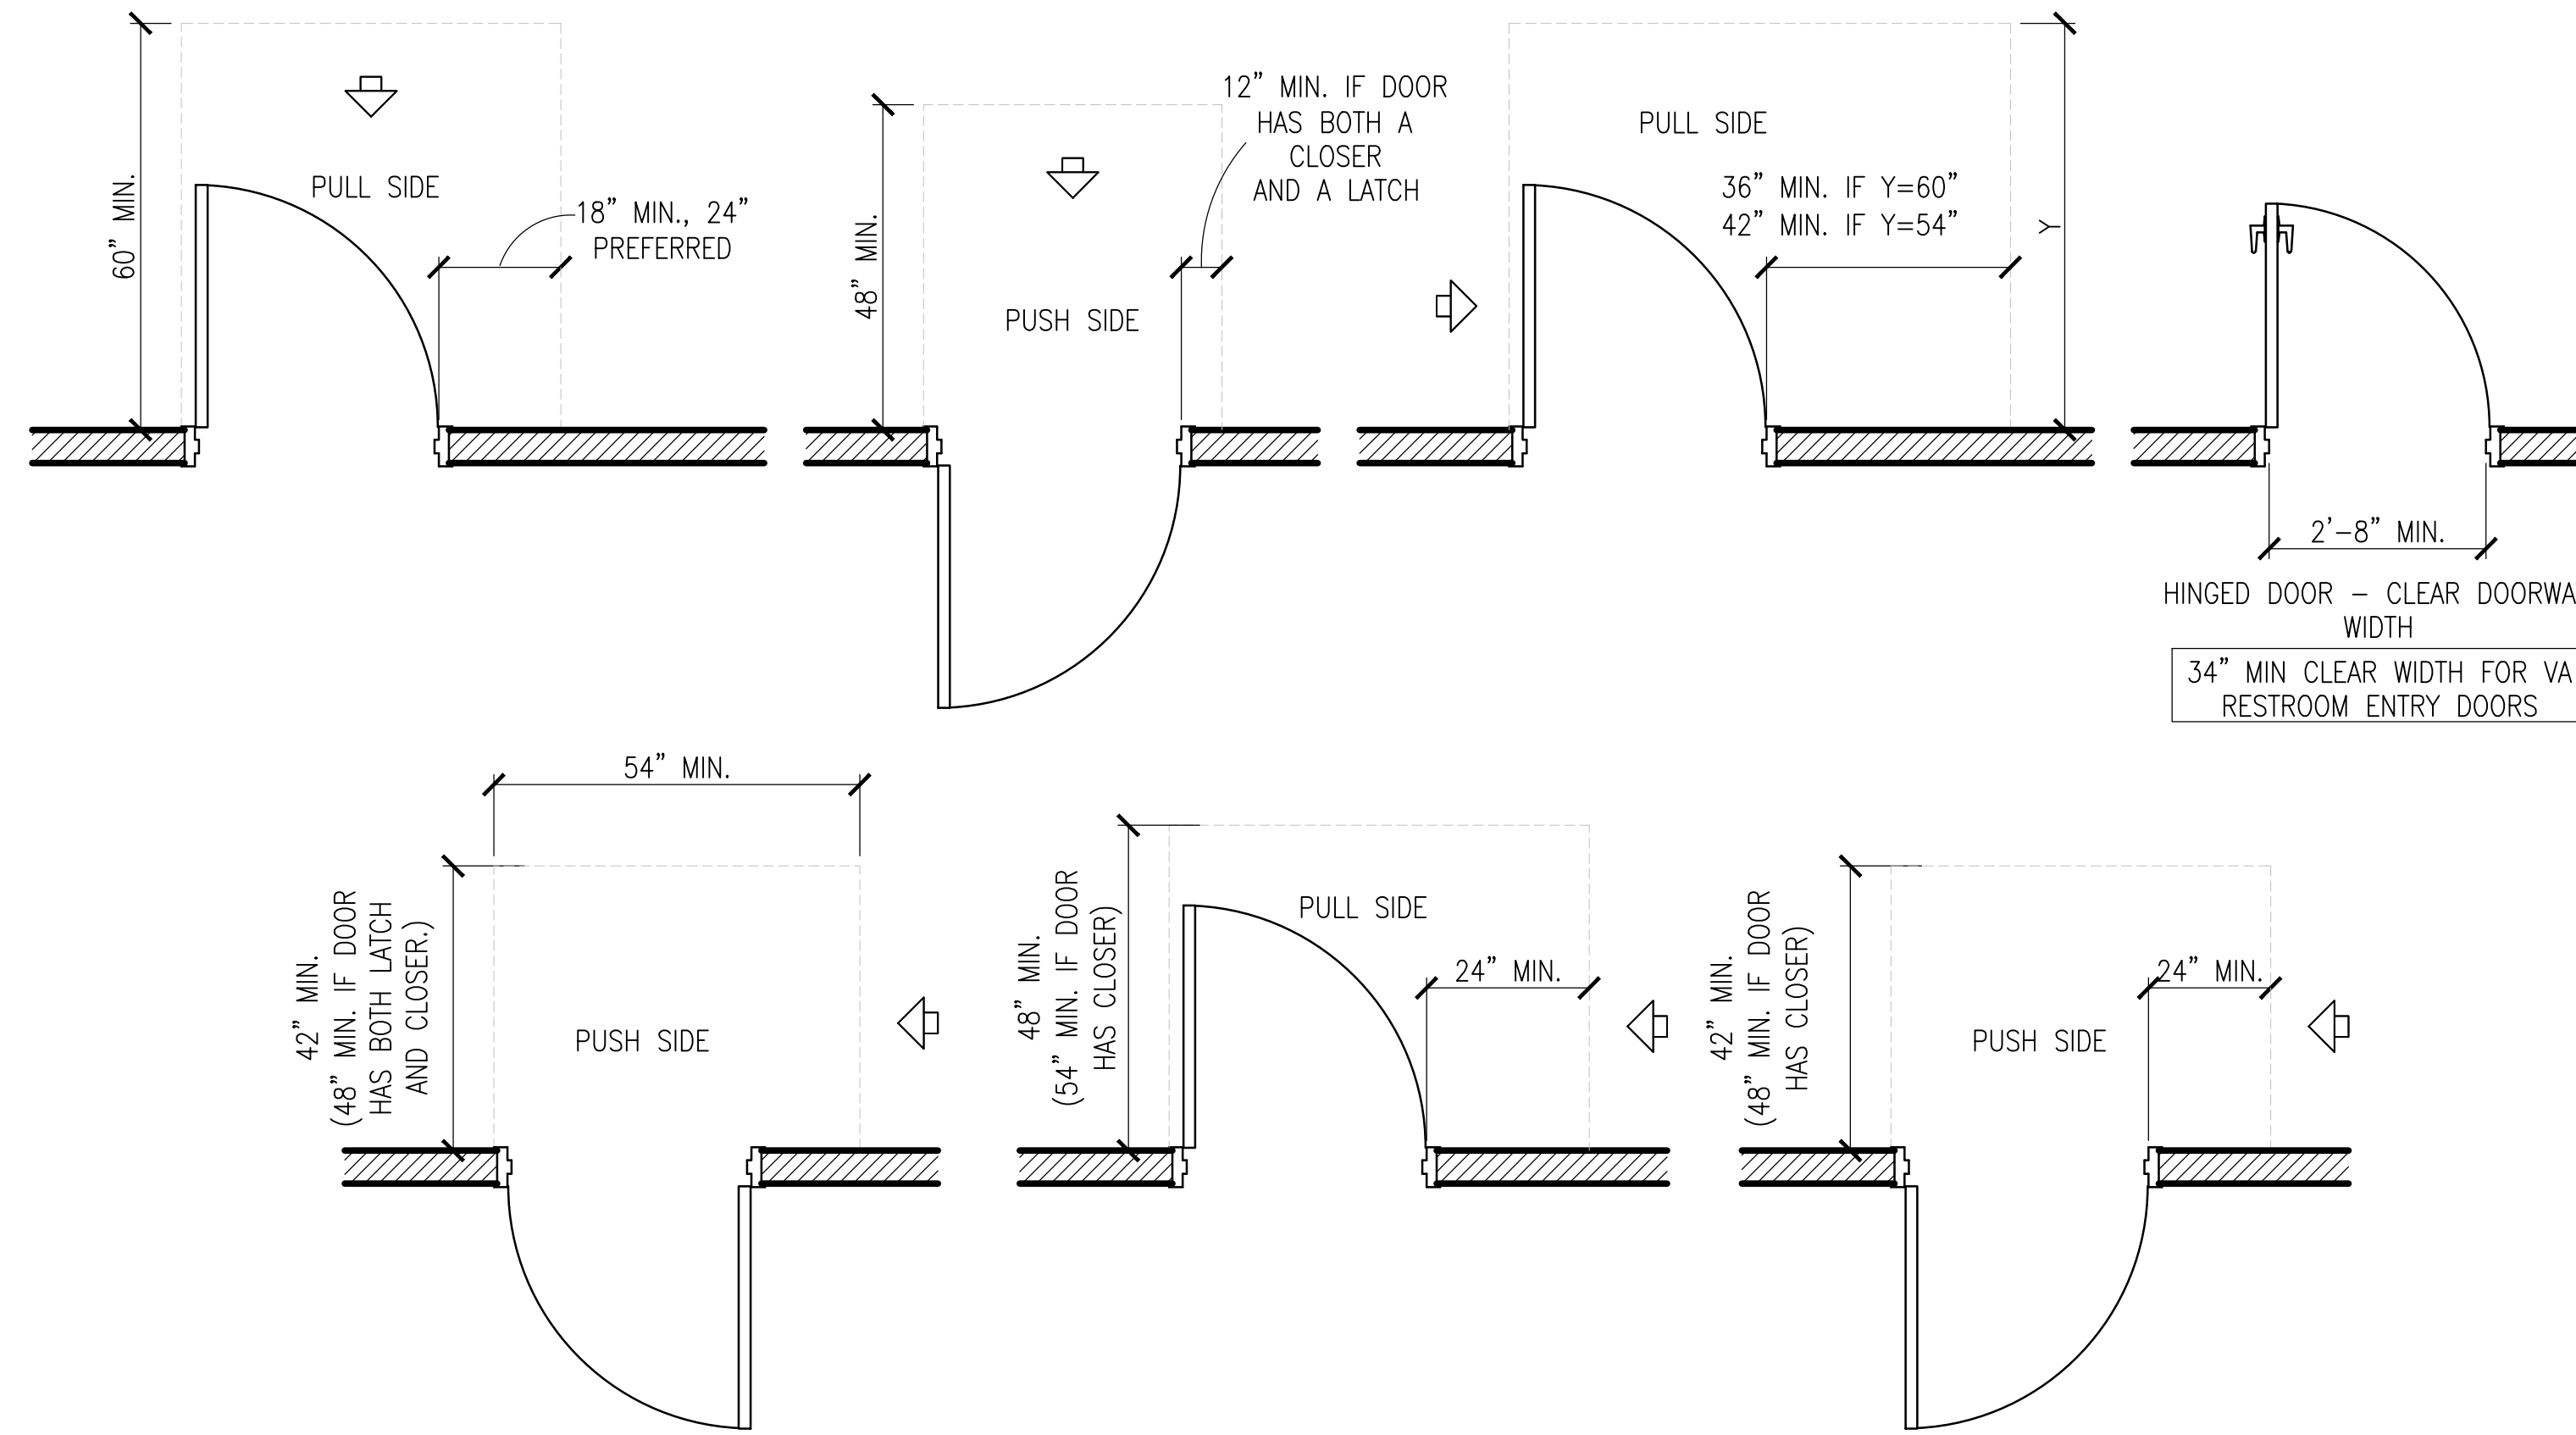


2 REQUIRED DOOR CLEARANCES

SCALE: 1/2" = 1'-0"
SCALE: 1/2" = 1'-0"

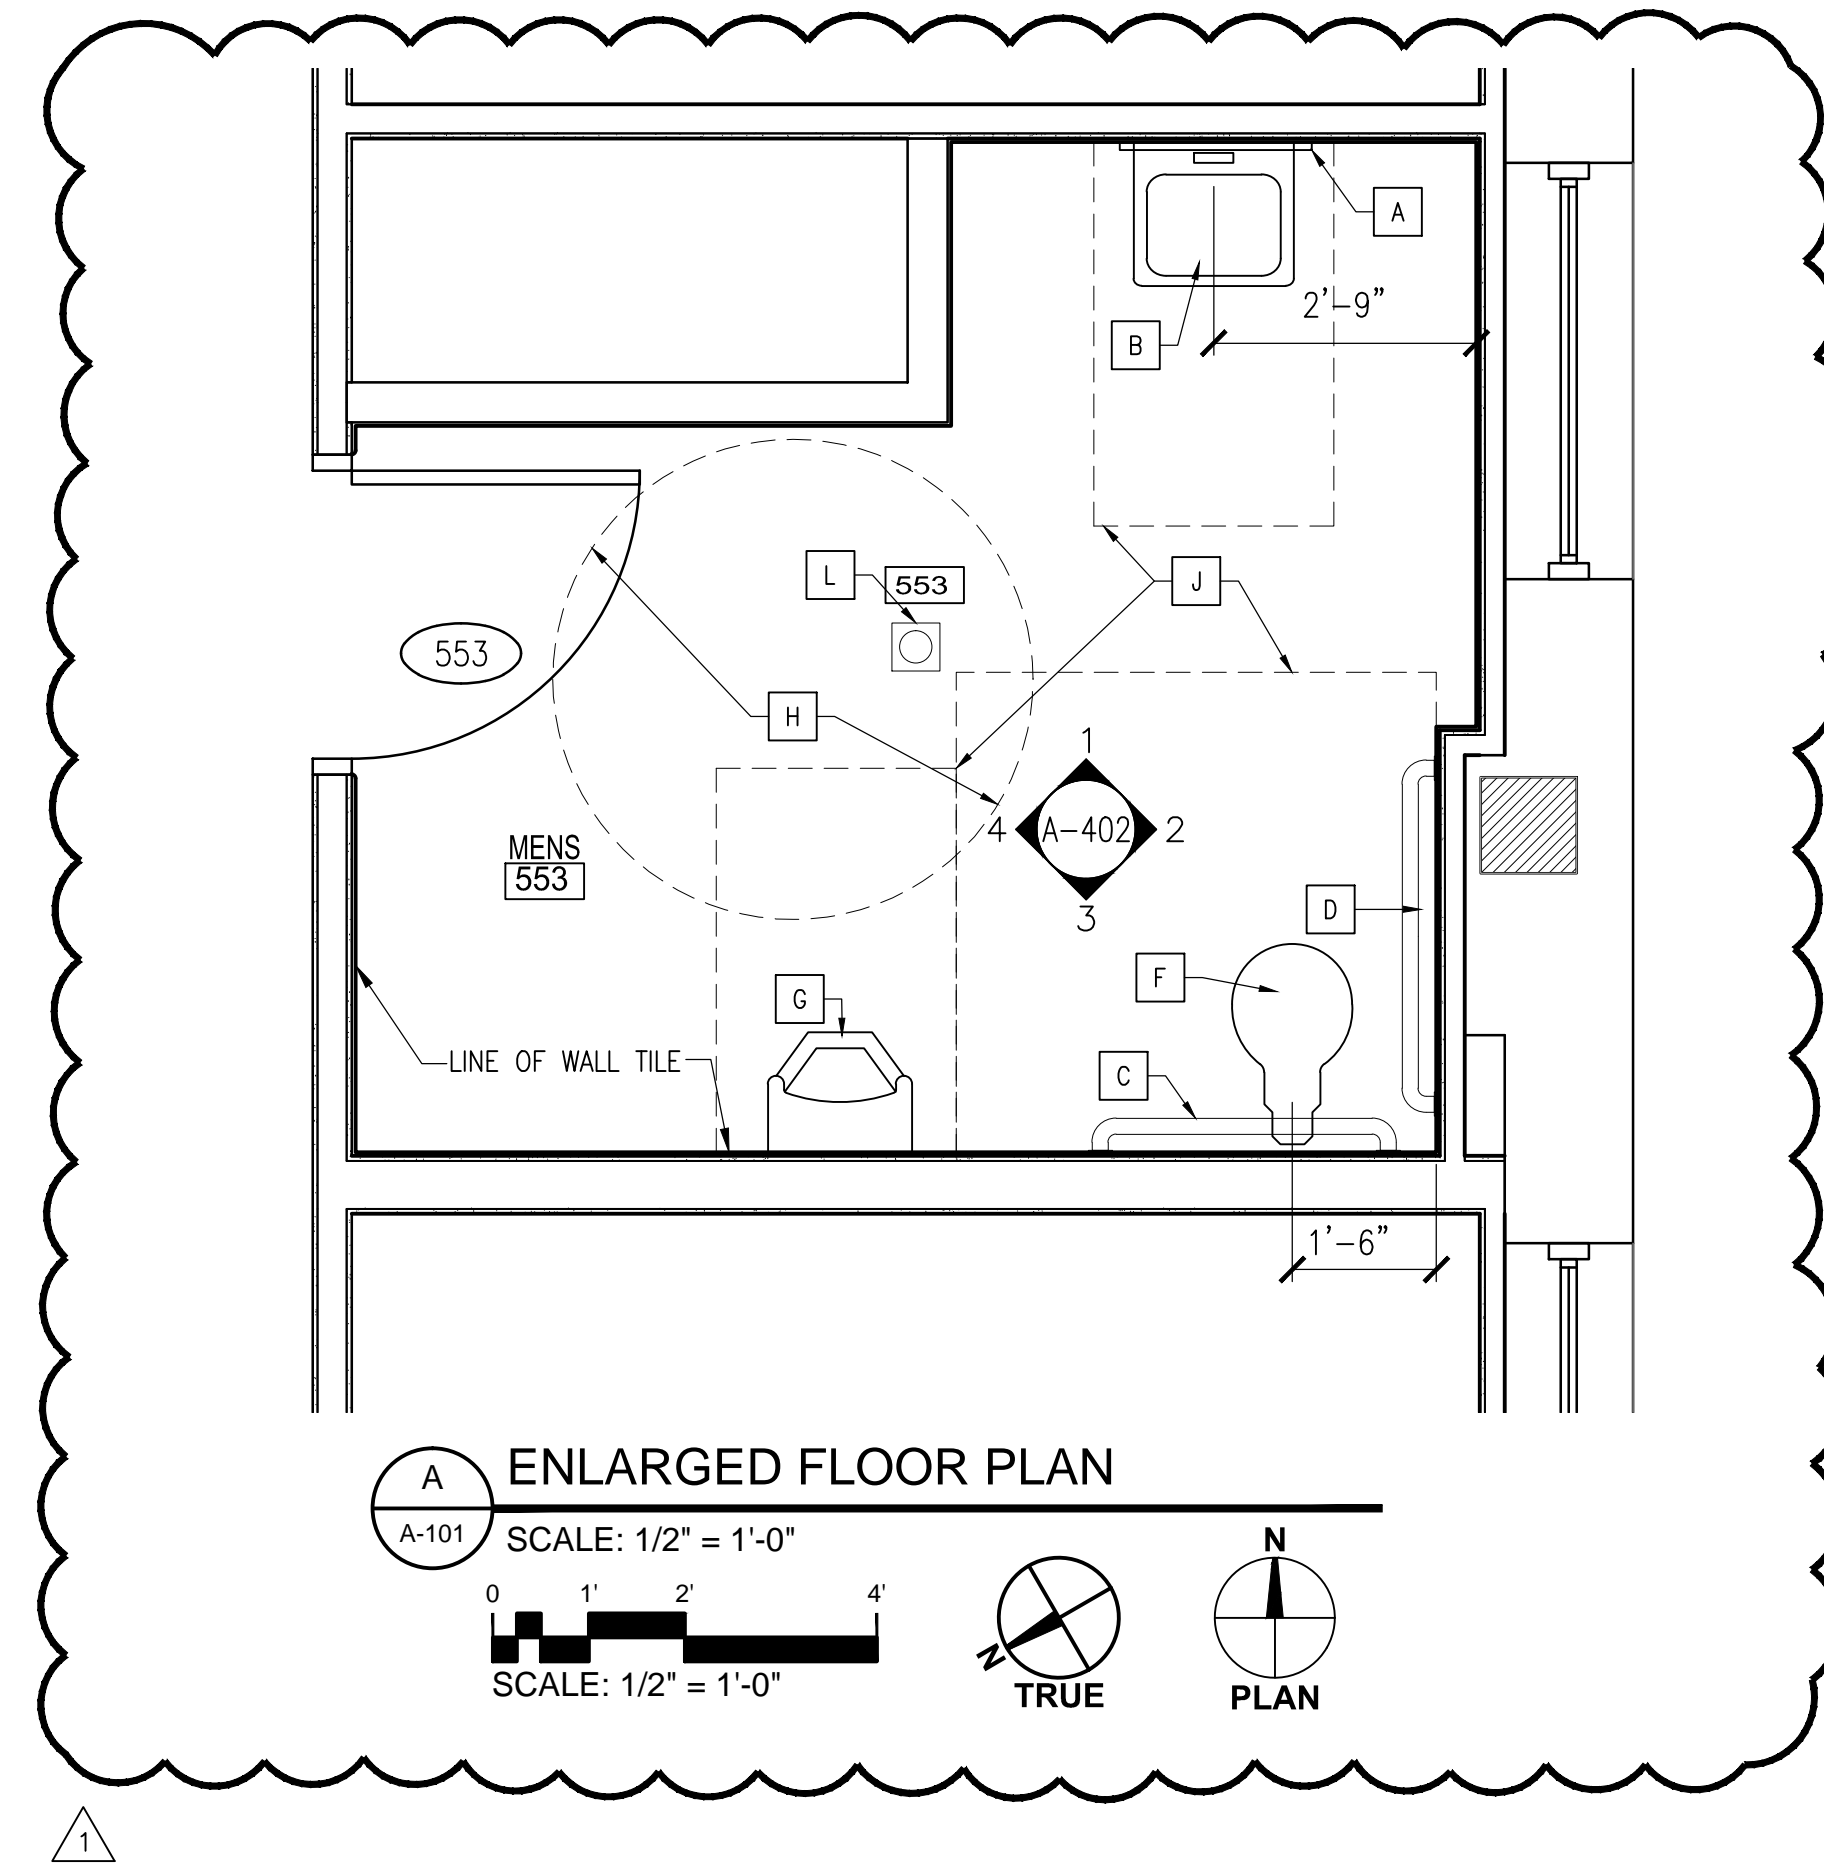

ENLARGED FLOOR PLAN

SCALE: 1/2" = 1'-0"
SCALE: 1/2" = 1'-0"

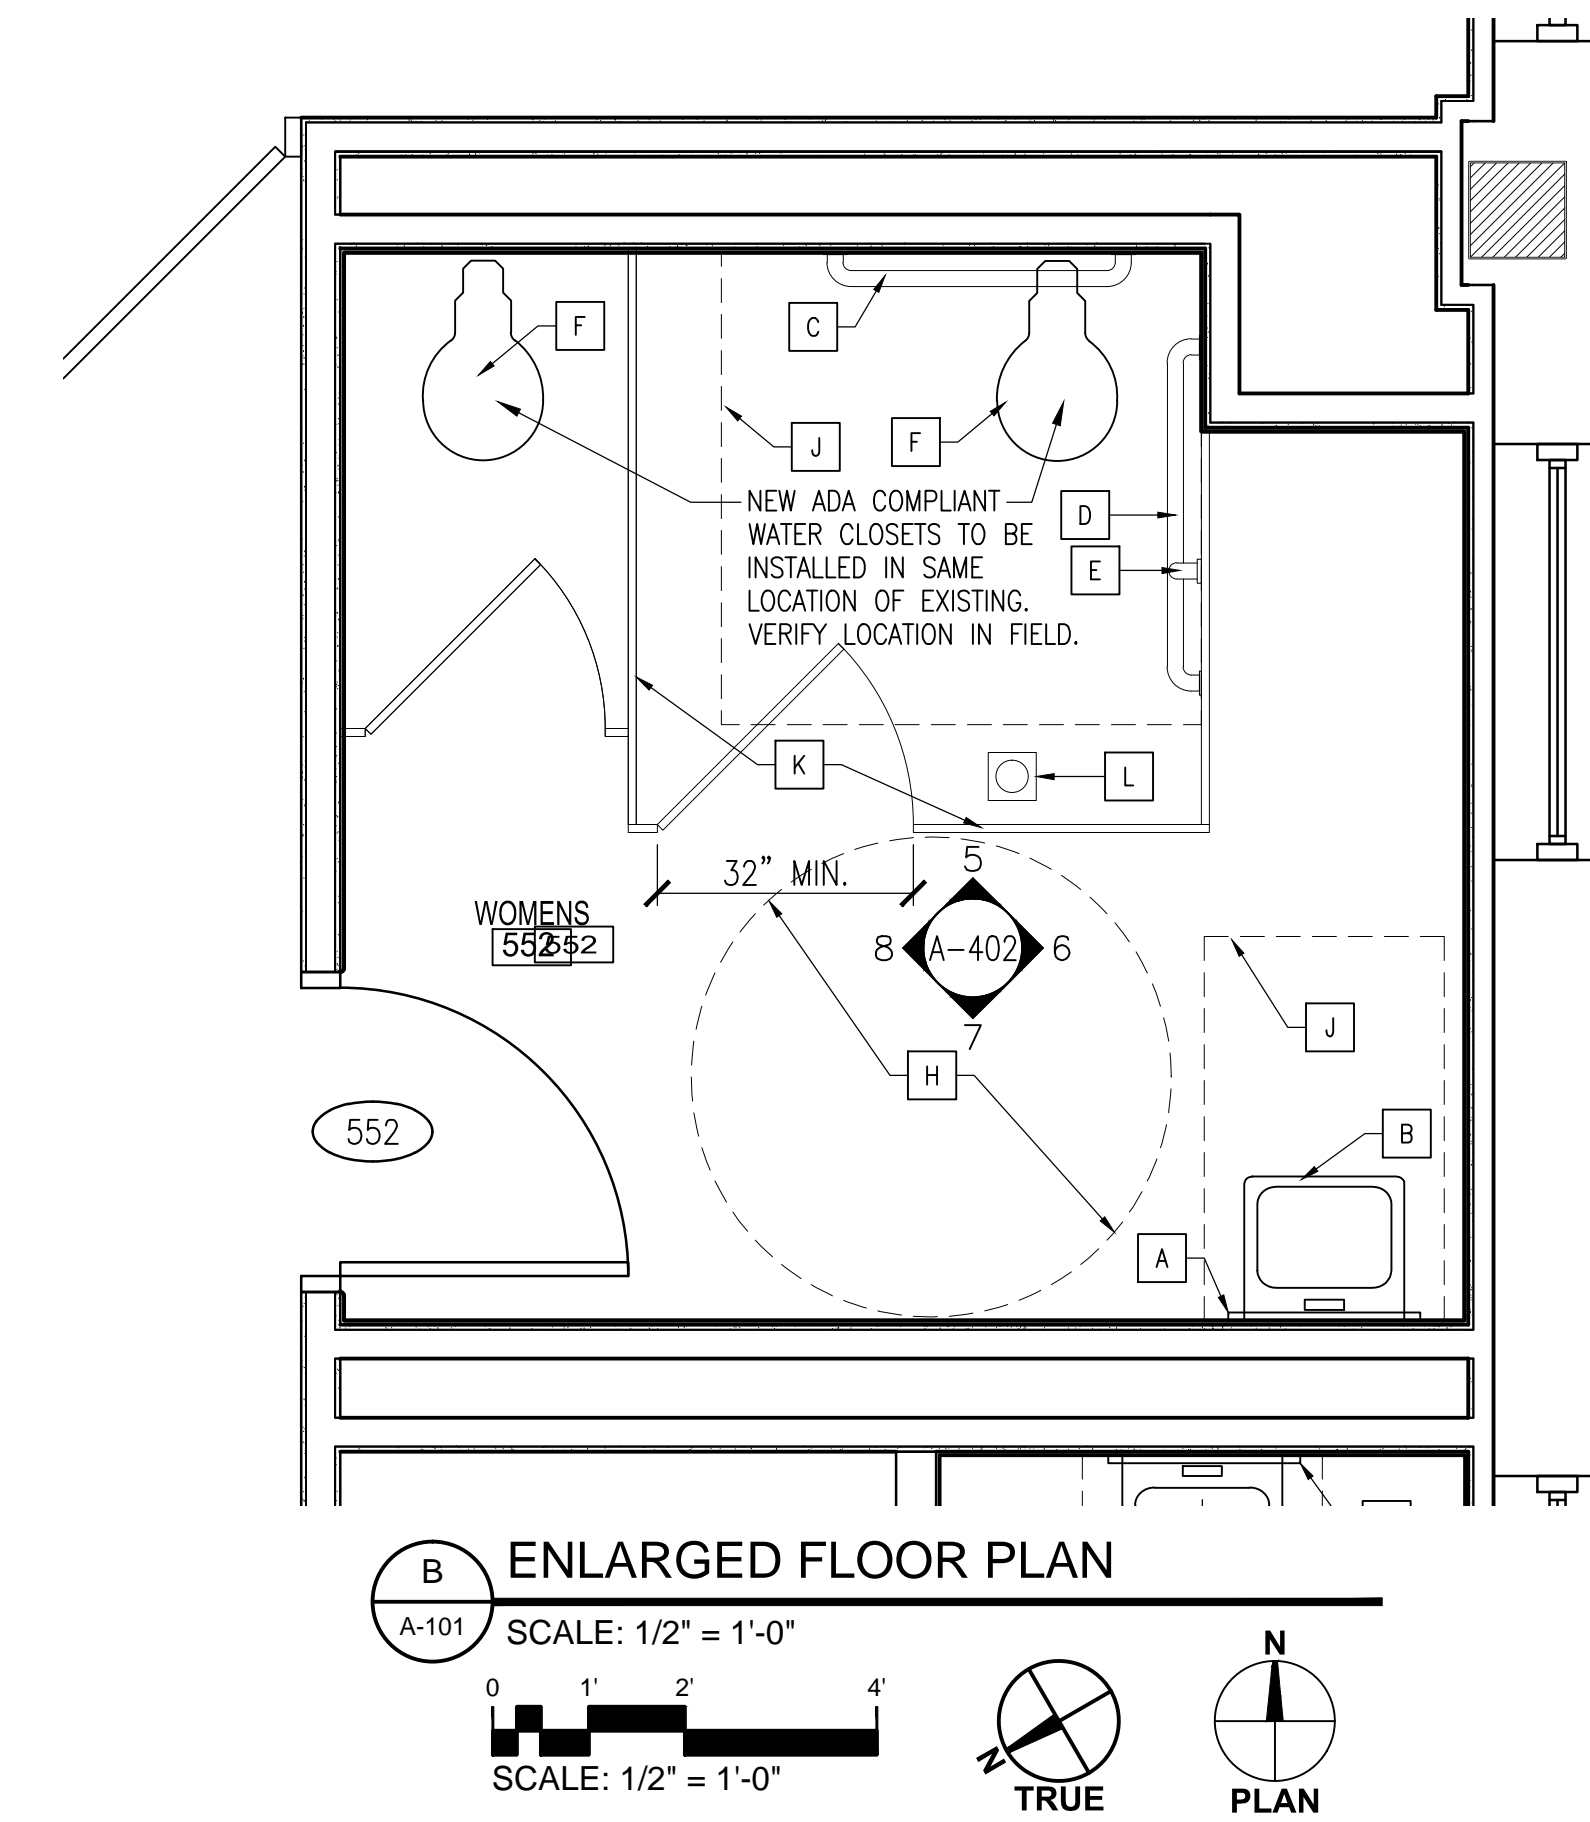

ENLARGED FLOOR PLAN


SCALE: 1/2" = 1'-0"
SCALE: 1/2" = 1'-0"

KEYNOTE LEGEND

- A WALL MOUNTED MIRROR (24" x 36")
- B LAVATORY (ACCESSIBLE). SEE PLUMBING DRAWINGS
- C HORIZONTAL GRAB BAR(S) (36" LONG MIN.; MAY BE SPLIT IF REQ.)
- D HORIZONTAL GRAB BAR (42" LONG MIN.)
- E NOT USED
- F FLOOR MOUNTED TOILET WITH FLUSH VALVE. SEE PLUMBING DRAWINGS.
- G WALL MOUNTED URINAL WITH FLUSH VALVE. SEE PLUMBING DRAWINGS.
- H ADA/ABA WHEELCHAIR REQUIRED TURNING AREA
- J ADA/ABA REQUIRED CLEAR FLOOR SPACE
- K NEW ADA/ABA COMPLIANT TOILET PARTITIONS
- L NEW FLOOR DRAIN

GENERAL NOTES

- ADDITIONAL TOILET ACCESSORIES: (PAPER & SOAP DISPENSER, ETC.) TO BE VA PROVIDED AND VA INSTALLED. NOT PART OF THIS CONTRACT. SEE ELEVATIONS FOR MOUNTING HEIGHTS ON A-402.
- SEE FINISH SCHEDULE FOR ADDITIONAL NOTES FOR WALL TILE.

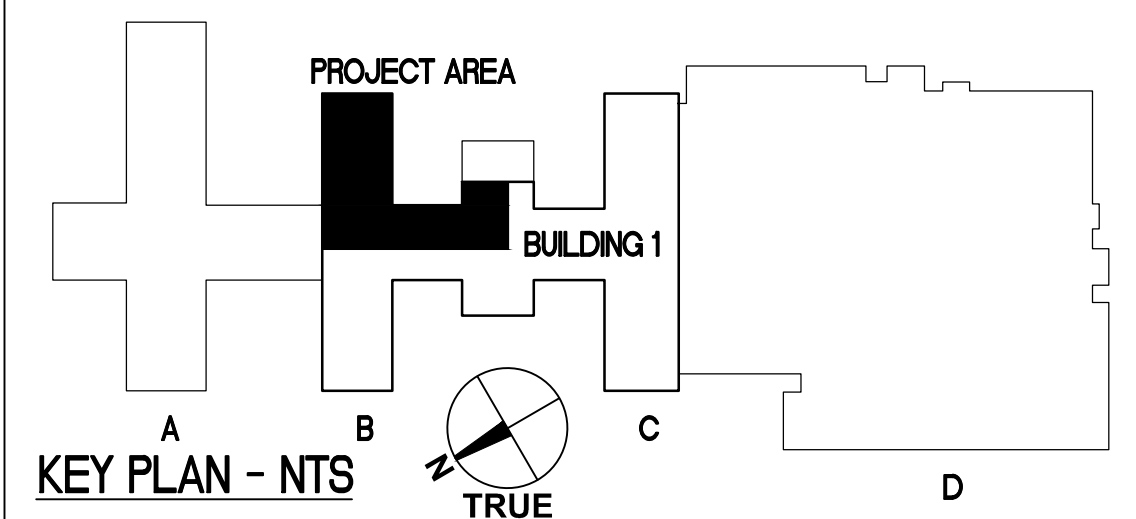

REVISION	DATE
1	06/09/15
2	06/09/15
3	06/09/15
4	06/09/15
5	06/09/15
6	06/09/15
7	06/09/15
8	06/09/15
9	06/09/15
10	06/09/15
11	06/09/15
12	06/09/15
13	06/09/15
14	06/09/15
15	06/09/15
16	06/09/15

100% FINAL CONSTRUCTION DOCUMENTS



ARCHITECT/ENGINEERS:

Atriax
GROUP
www.atriaxgroup.com

Atriax, plc
102 3rd Avenue, NE
PO Box 1629, Hickory, NC 28603
T: 828.315.9962
F: 828.315.9964
NC Engineering License No.: P-0214
NC Architectural License No.: 51254

Dewberry
Dewberry Engineers Inc.
605 Eastowne Drive, Chapel Hill, NC 27514
T: 919.433.0075
F: 919.435.0079
NC Engineering License No.: F-0929

Drawing Title
ENLARGED TOILET PLANS AND DETAILS

Approved Project Director

Project Title
RENOVATE B-WING 5TH FLR FOR MENTAL HEALTH

Location
VAMC FAYETTEVILLE NC
Date
22 JULY 2014
Checked
EHH
Drawn
TLR

Project Number
565-13-209
Building Number
1
Drawing Number
A-401 RA
Dwg. 8 of 36

Office of
Construction
and Facilities
Management
Department of
Veterans Affairs