


three inches = one foot  
one and one half inches = one foot  
one inch = one foot  
three quarters inch = one foot  
one half inch = one foot  
one quarter inch = one foot  
one eighth inch = one foot  
one quarter inch = one foot  
one eighth inch = one foot  
one quarter inch = one foot  
one eighth inch = one foot

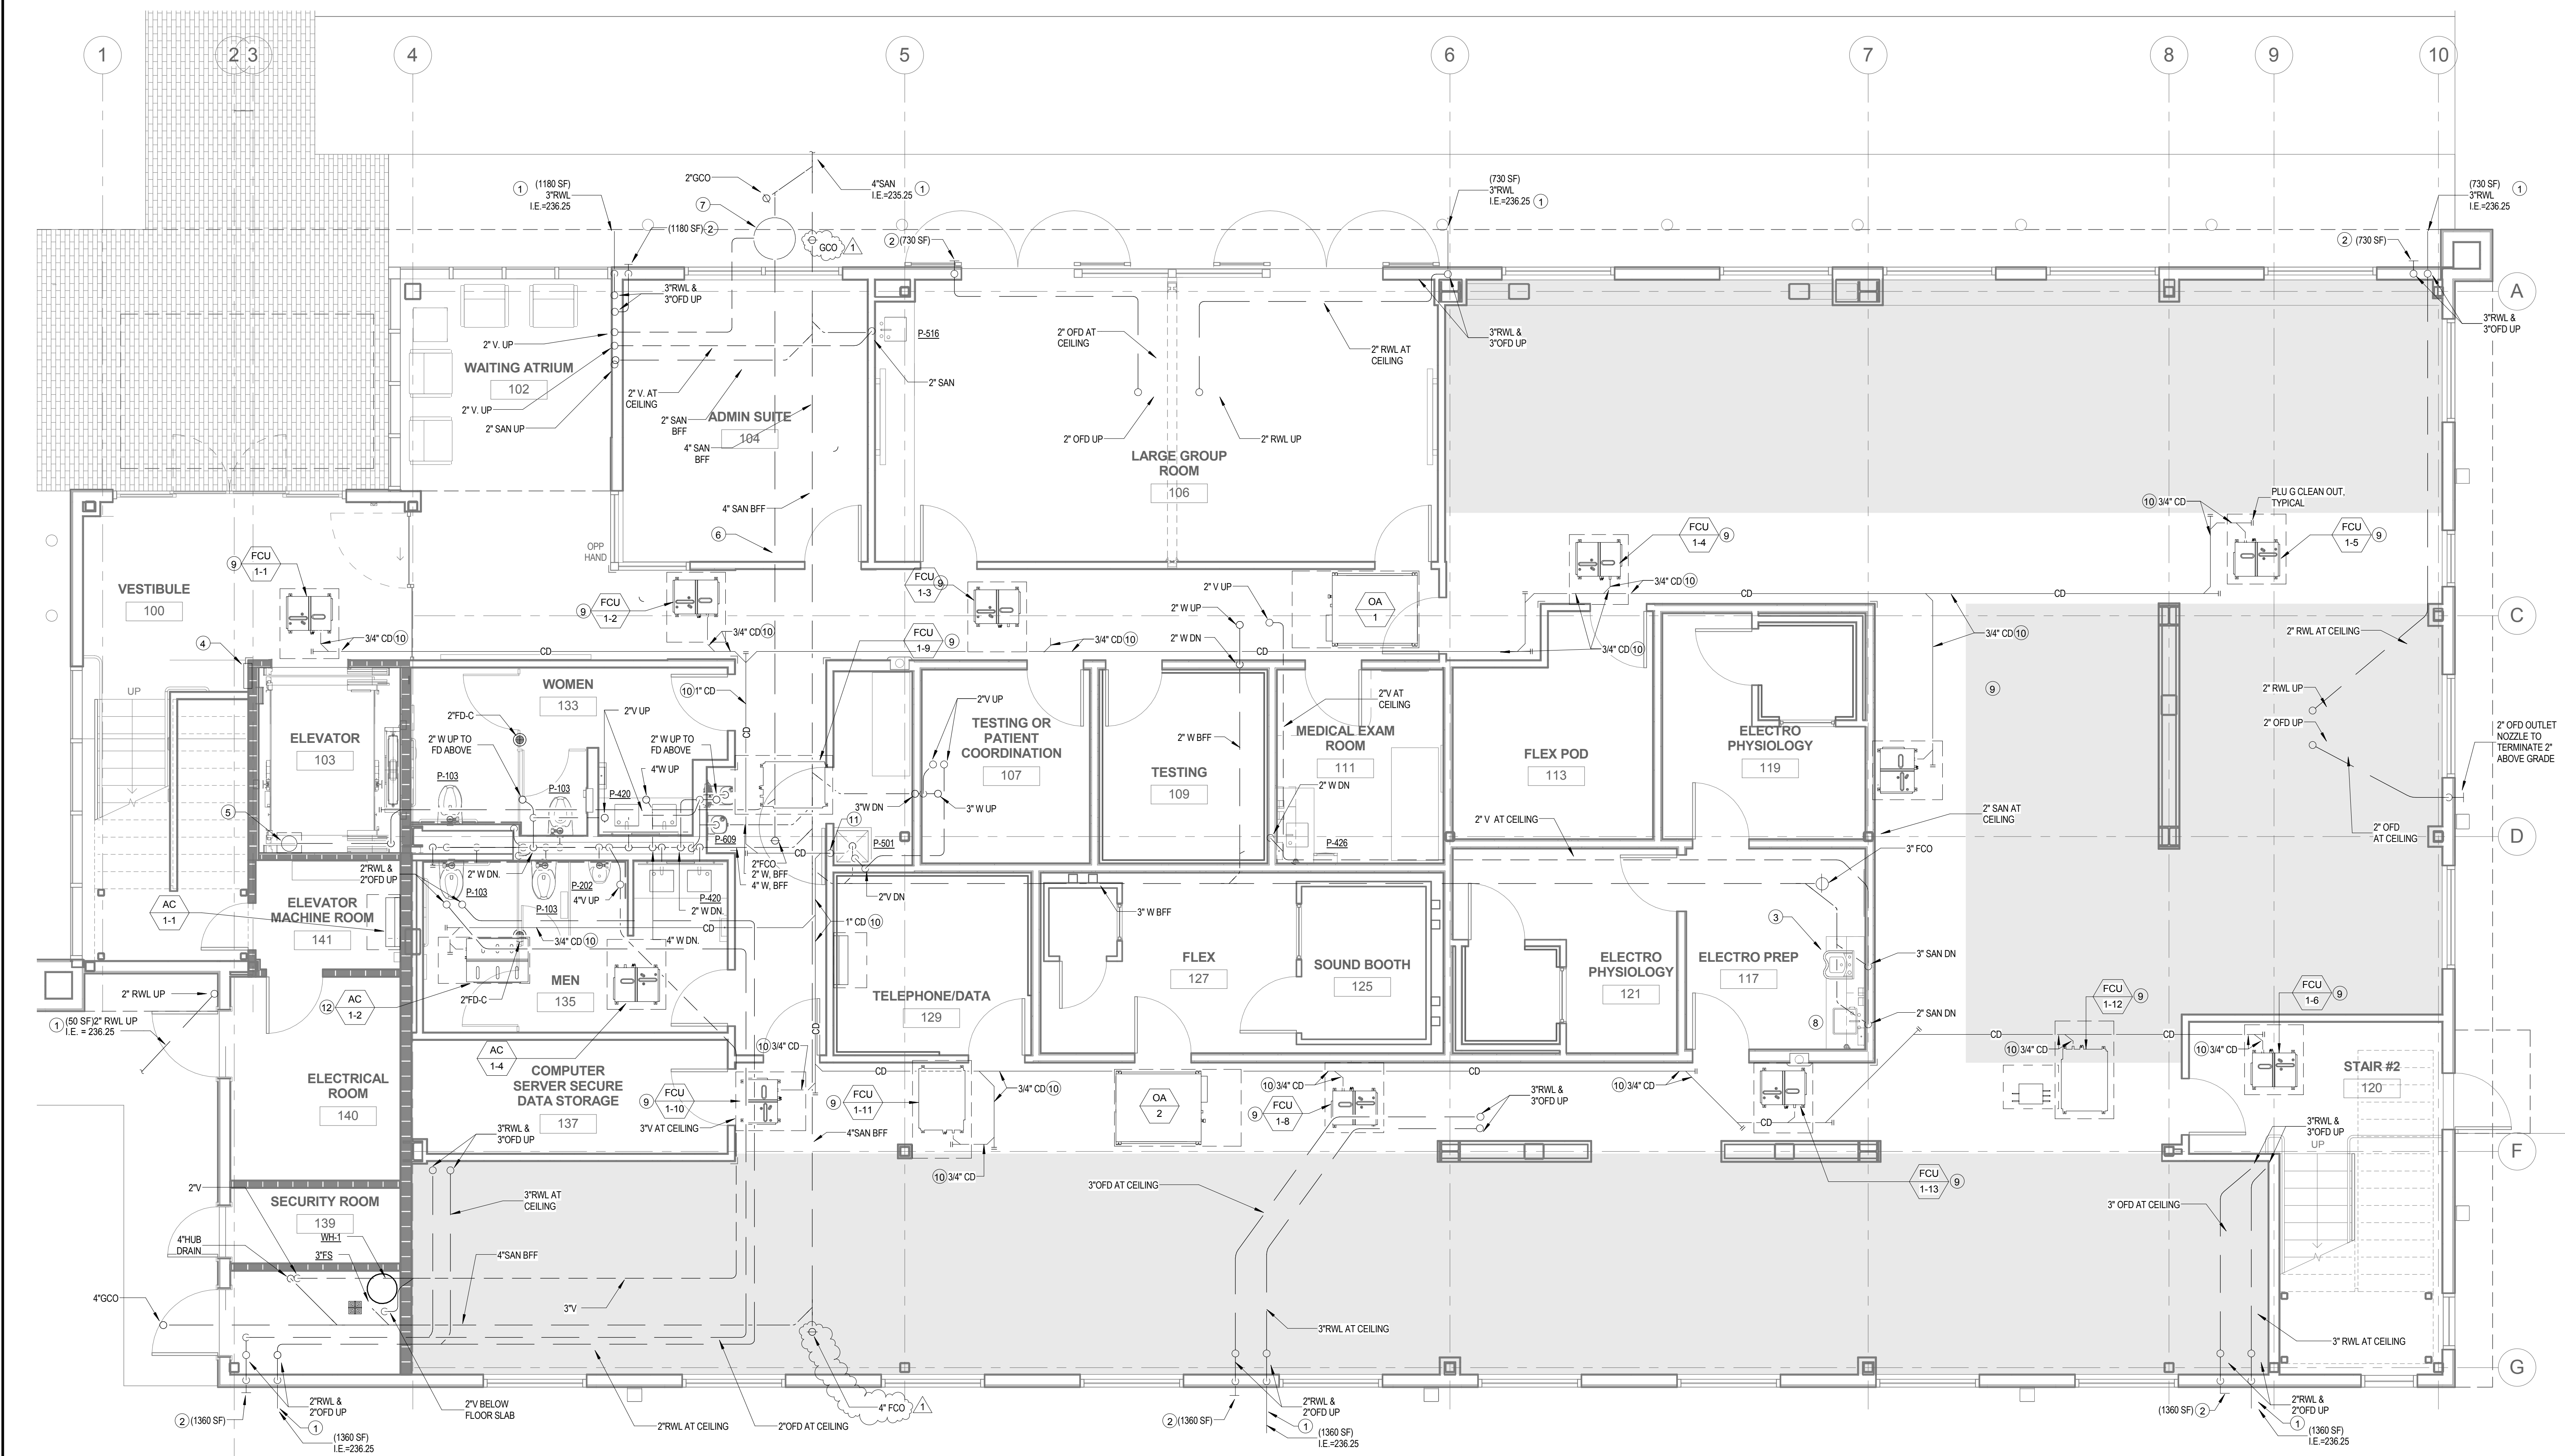

1 PLUMBING PLAN - FIRST FLOOR WASTE  
1/4" = 1'-0"

GENERAL SHEET NOTES

1. PROVIDE SUB DRAINAGE SYSTEM UNDERNEATH THE BUILDING SLAB AS DESCRIBED IN SECTION 7.4 OF GEOTECHNICAL REPORT. SEE SUB DRAINAGE DRAWINGS.
2. PROVIDE CONDENSATE DRAINAGE PIPING FROM FAN COIL UNITS (SEE MECHANICAL PLANS) TO TERMINATE SERVICE SINK (P-501).

KEY NOTES

1. SEE CIVIL DRAWING CS101 FOR CONTINUATION. SIZE AS NOTED.
2. 3" OFD OUTLET NOZZLE TO TERMINATE 12" ABOVE GRADE.
3. HEAD WASH SINK.
4. ELEVATOR SUMP PUMP CONTROL PANEL, SEE PP301.
5. SUMP PUMP IN A PIT, SEE PP301.
6. 2" SUMP PUMP DISCHARGE BELOW FLOOR SLAB.
7. SEPARATOR, SEE PP301.
8. HAND WASH SINK, SEE PP500.
9. FAN COIL UNIT, SEE MECHANICAL PLANS. INSTALL CONDENSATE DRAIN IN ACCORDANCE WITH MANUFACTURER & PUBLISHED INSTALLATION INSTRUCTIONS.
10. CONDENSATE DRAIN (CD) PIPING SLOPE AT 1/8" PER FOOT. SIZE AS NOTED.
11. 1" CD TO TERMINATE 6" ABOVE SERVICE SINK.
12. AC UNIT. SEE MECHANICAL PLANS. INSTALL CONDENSATE DRAIN IN ACCORDANCE WITH MANUFACTURER & PUBLISHED INSTALLATION INSTRUCTIONS.

100% CONSTRUCTION DOCUMENT SUBMISSION  
APRIL 20, 2015


DELTA 1	ADDENDUM #1	7/31/2015
Revisions:		Date

CONSULTANTS:

**MAZZETTI**  
220 Montgomery Street, Suite 650  
San Francisco, CA 94104  
TEL: (415) 632-3966  
www.mazzetti.com  
PROJECT NUMBER: 130-055



ARCHITECT

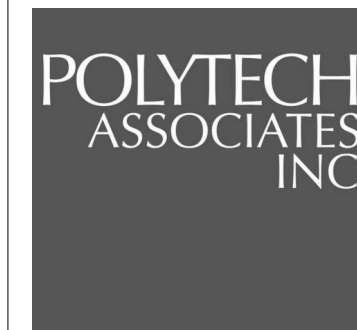

POLYTECH ASSOCIATES INC.  
235 Pine Street, 17th Floor  
San Francisco, CA 94104  
TEL (415) 397-3117  
FAX (415) 397-1517

Drawing Title  
PLUMBING WASTE, DRAIN AND VENT PIPING PLAN - FIRST FLOOR

Approved: Project Director

Project Title  
NEUROCOG TBI RESEARCH BUILDING / BUILDING R4  
DEMOLITION / NEW PARKING LOT

Location  
150 MIJR ROAD, MARTINEZ, CA 94553

Date  
10/20/14

Checked  
Author

Drawn  
Checker

Project Number  
612-125

Building Number

Drawing Number

PL101

Office of  
Construction  
and Facilities  
Management

