


NOTES:
1. INTAKES TO BE A MINIMUM OF 24" ABOVE ROOF EXCEPT MEDICAL FACILITIES WHICH SHALL BE 36".
2. RELIEF/EXHAUST TO BE A MINIMUM OF 18" ABOVE ROOF.

6 GOOSENECK DETAIL
SCALE: NTS

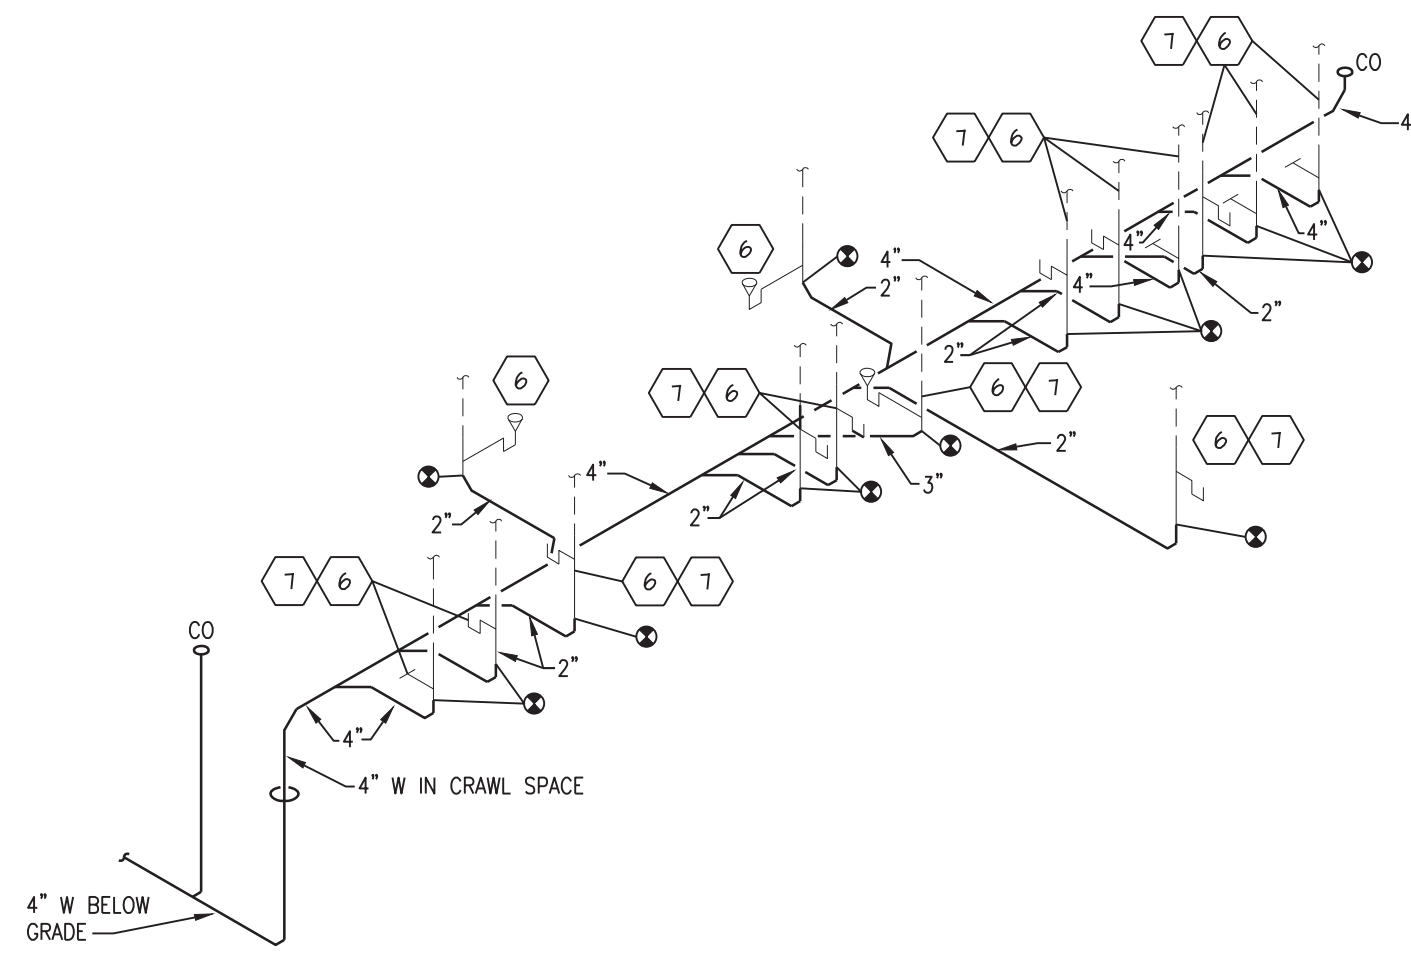

KEYED NOTES:
1. 4" WATER SUPPLY MAIN TO WATER SUPPLY MAIN
2. WATER SUPPLY PRESSURE GAUGE W/PETCOCK
3. 4" BACKFLOW ASSEMBLY WITH (2) TAMPER SWITCHES
4. CONNECTION TO SWANSE CONNECTION
5. VALVES W/TAMPER SWITCH
6. VANE-TYPE WATER FLOW SWITCH
7. INSP. TEST VALVES WITH SIGHT GLASSES (2)
8. MAIN DRAIN PIPE TO BUILDING EXTERIOR
9. W/ AUXILIARY DRAIN TO FLOOR DRAIN
10. ALARM BELL AND LIGHT, VERIFY LOCATION W/ A/H
11. 4" RISER TO WET SPRINKLER SYSTEM ZONE 1 (IMPACT)

4 IMPACT BUILDING PLAN - PLUMBING RISER
SCALE: NTS

