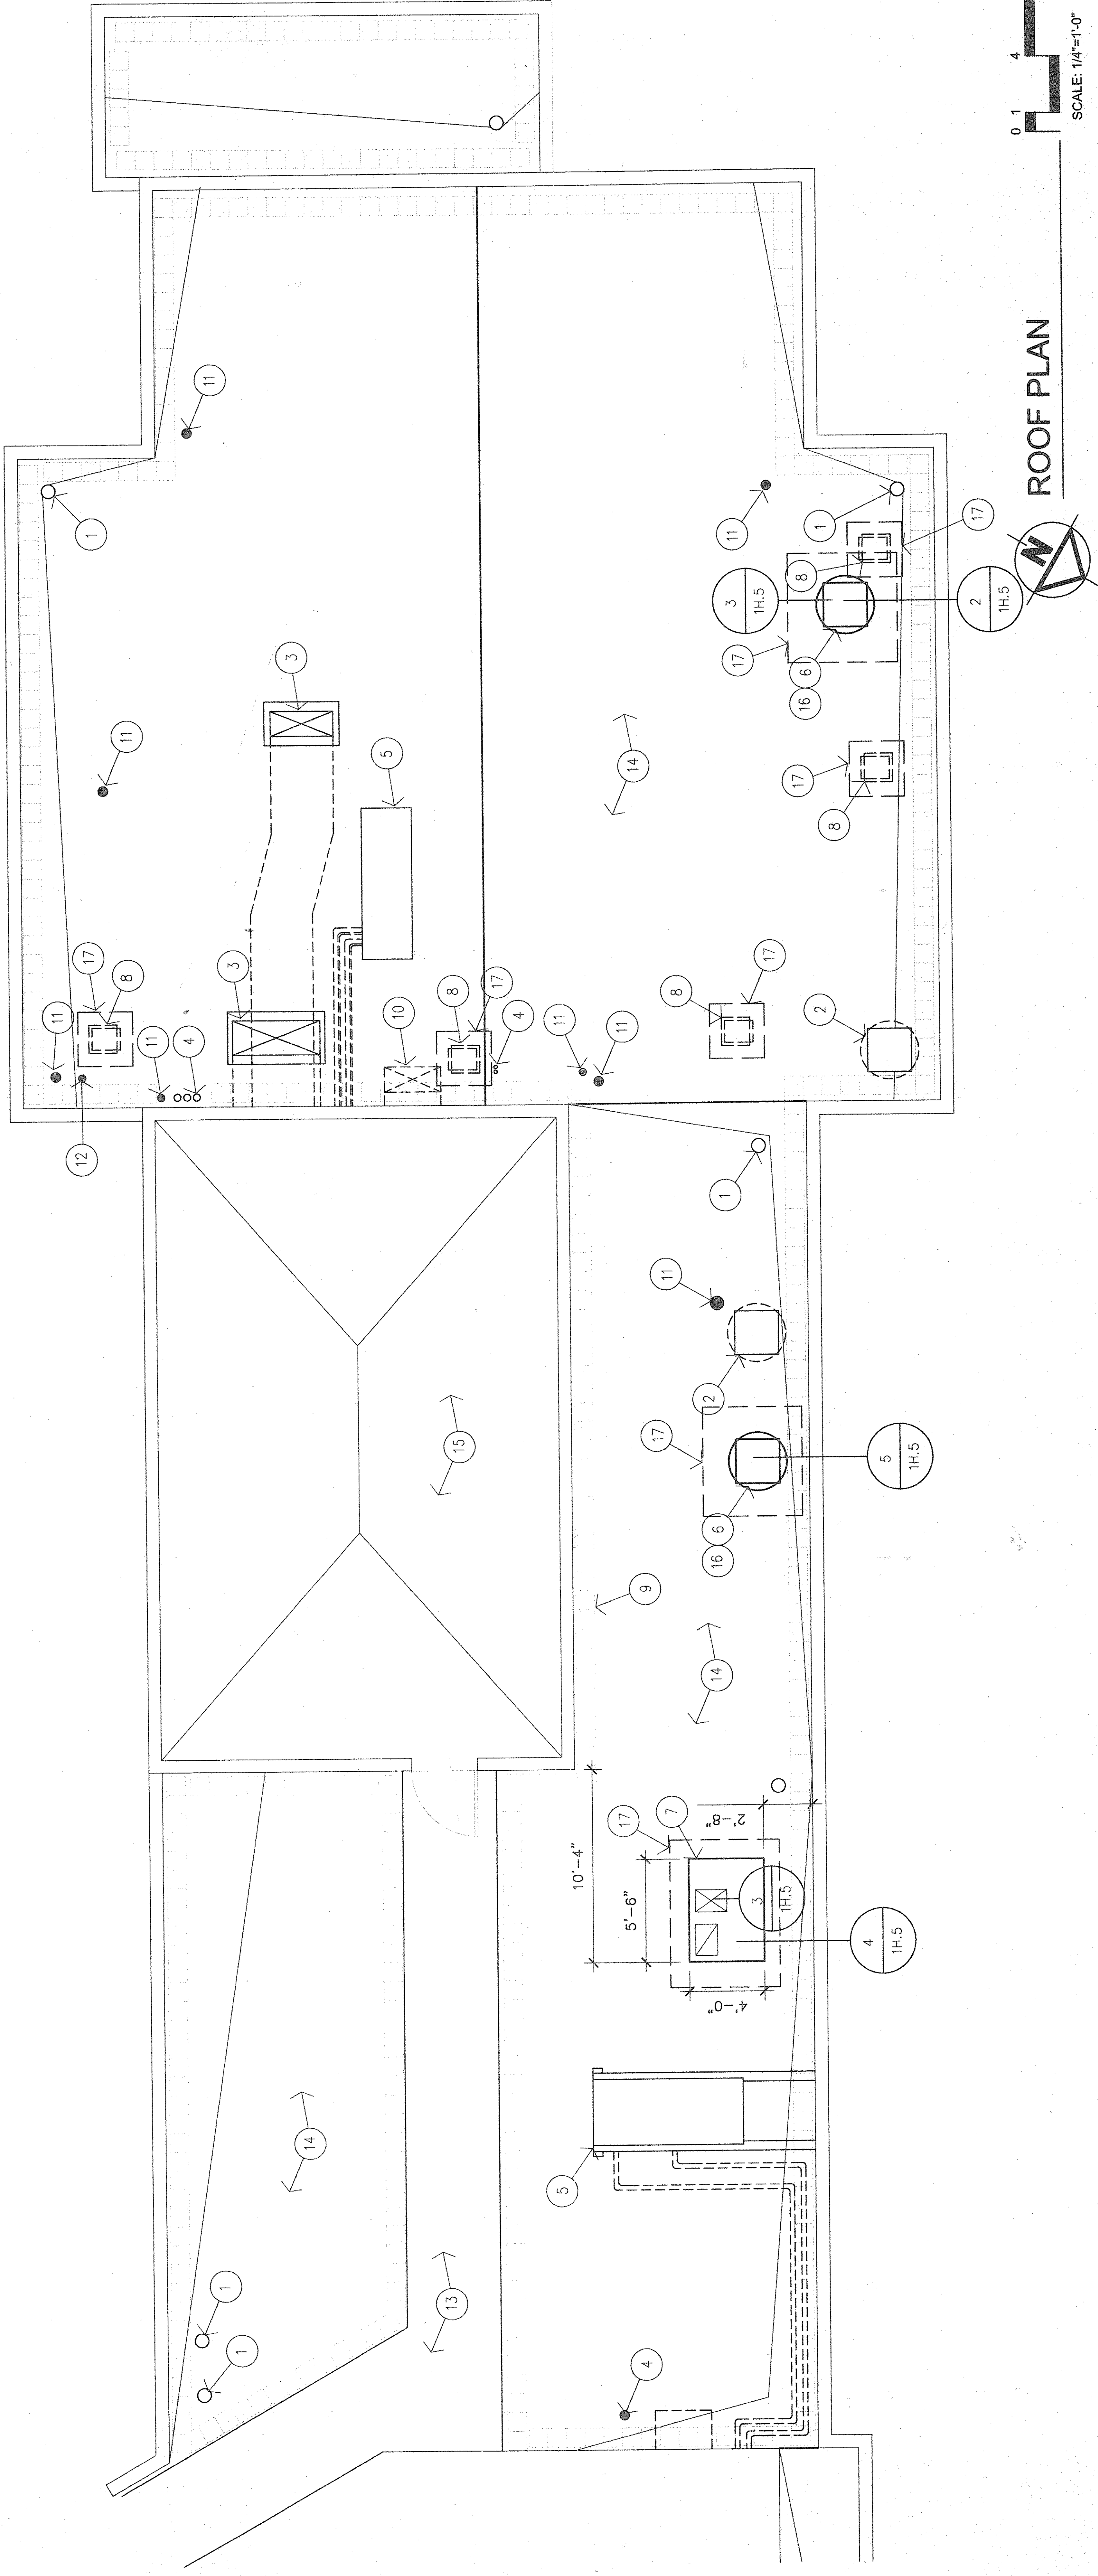
 


[illegible]

 Dept. of Veterans Affairs Medical Center 500 Highway 89 North Prescott, Arizona		<div style="border: 1px solid black; height: 100px; width: 100%;"></div>		Approved: Safety & Occupational Health Manager		Drawing Title ROOF PLAN - 4 WEST		Project Title RENOVATE ICU		Date 7/19/00		Department of Veterans Affairs	
				Approved: Facilities Manager						Scale: 1/4" = 1'-0"			
				Approved: Chief Executive Officer		Project No. 649-98-101		Contract No. V649P-2206		Designed By AL		Drawn By AL	
				Approved: Chief Medical Officer		Building No. 107		AutoCAD File Name		Location VA Medical Center Prescott, Arizona		Drawing No. 1-A.8	
												Dwg. 10 of 35	
Revisions		Date											