


GENERAL NOTES:
1. REFER TO SHEET M-001 FOR MECHANICAL GENERAL NOTES.

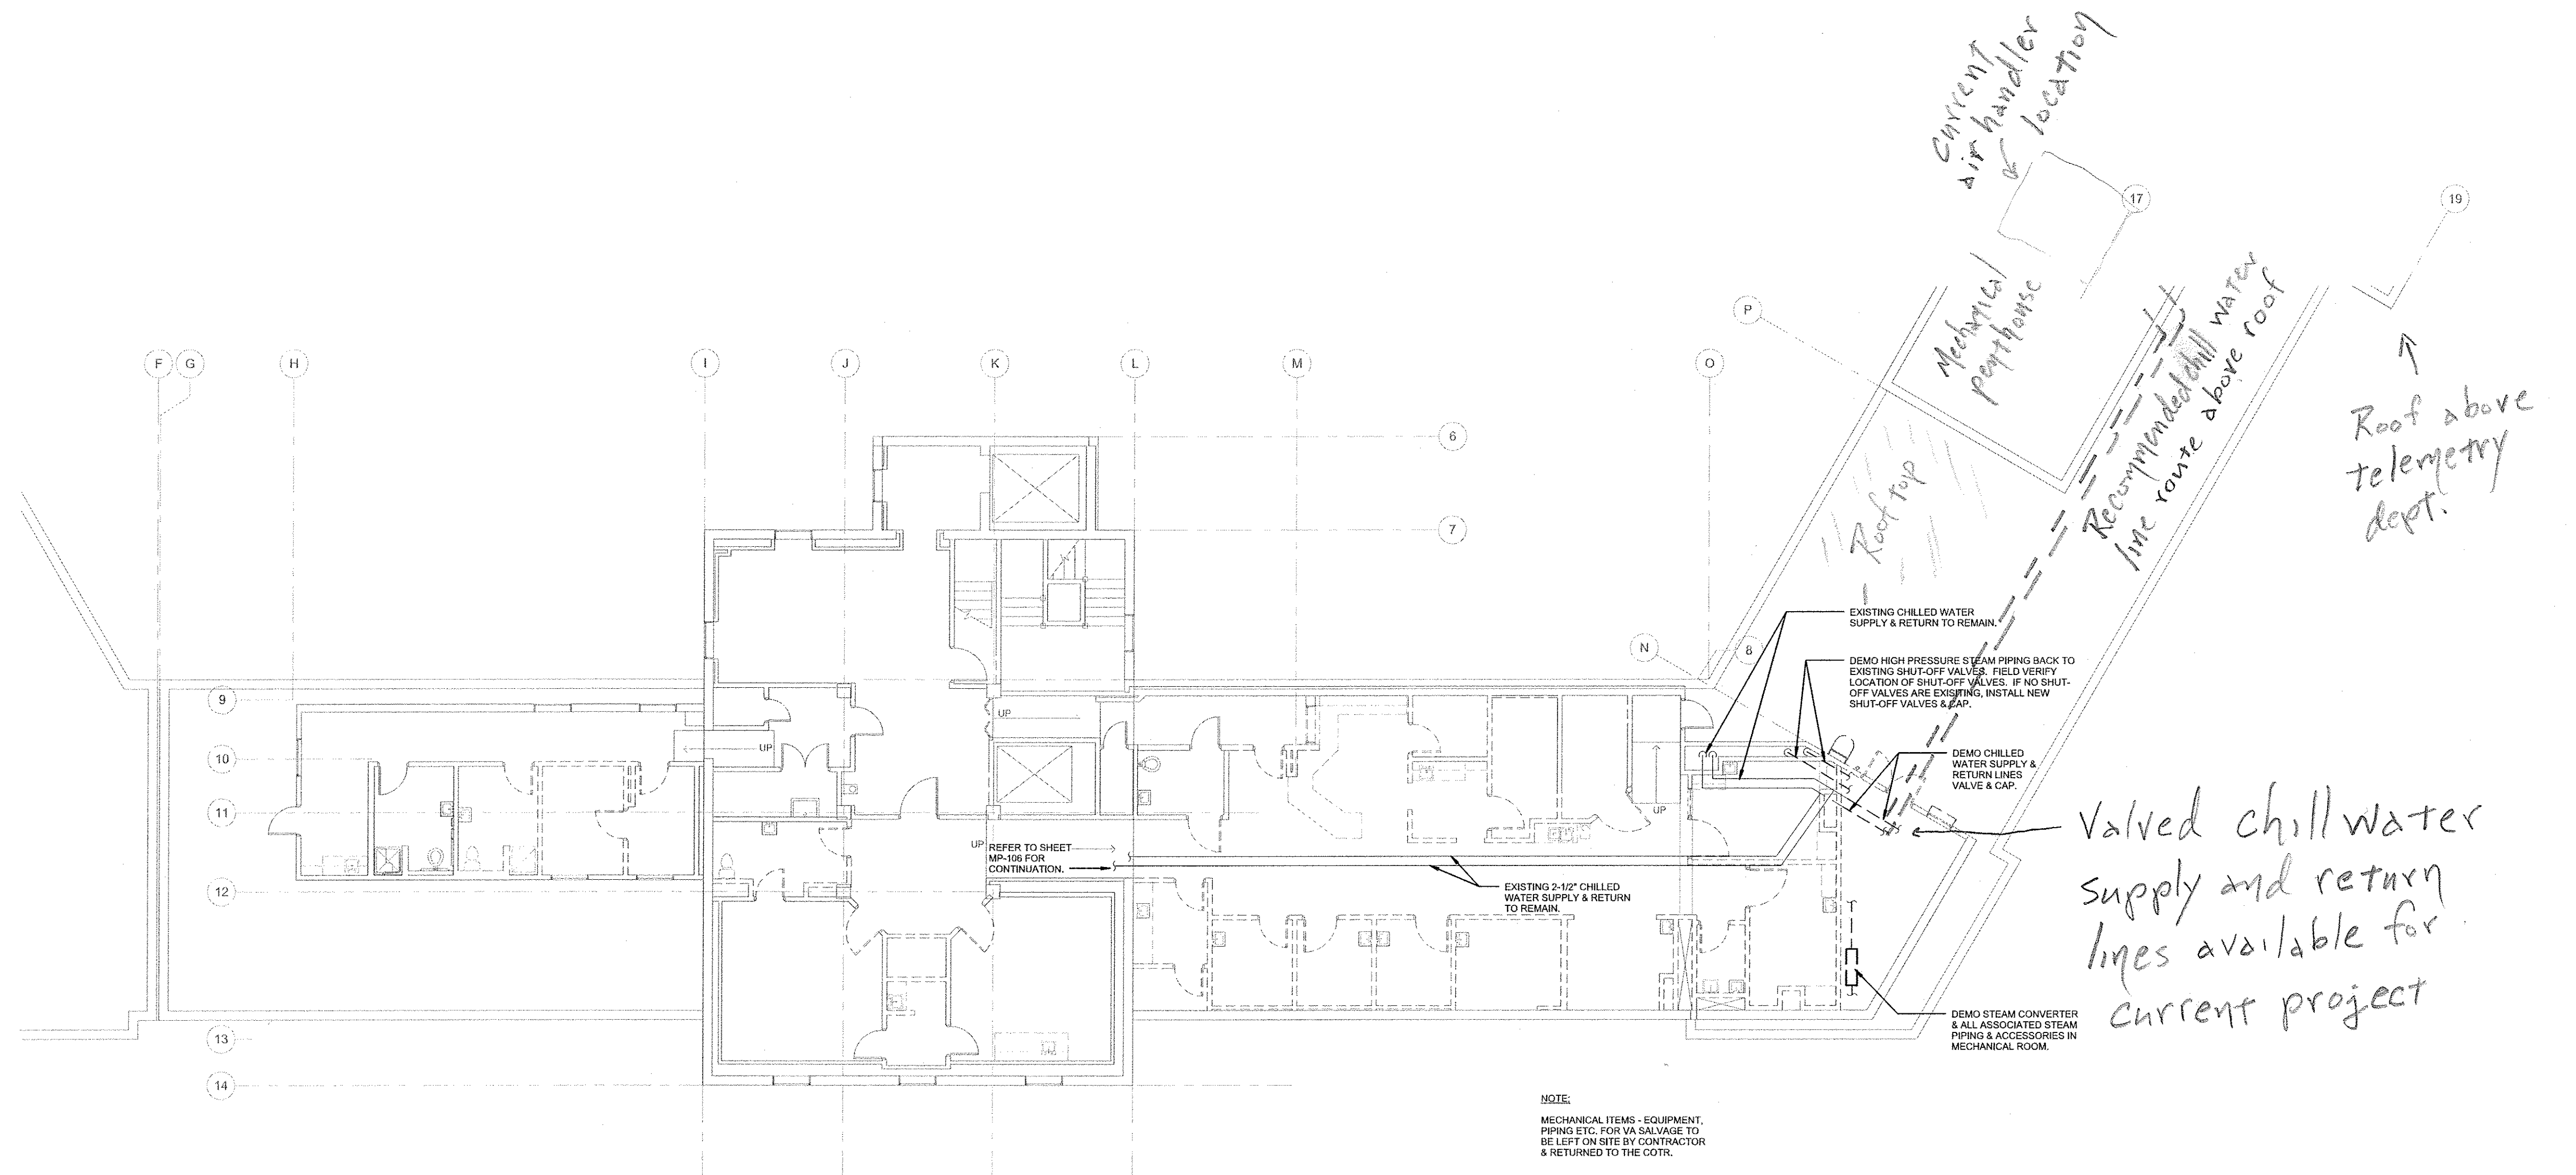

1 Mechanical Piping Plan - 5th Floor - Demo
1/8" = 1'-0"

1	BID SET SUBMITTAL	2/14/14
No.	Revisions	Date

Westlake
Reed
Leskosky
One East Camelback Road
Suite 690
Phoenix, Arizona 85012
© Westlake Reed Leskosky



Drawing Title:
MECHANICAL PIPING PLAN - FIFTH
FLOOR - DEMO

Approved Project Director:

Project Title:
BUILDING 107
RENOVATE ENDOSCOPY
UPGRADE HVAC

Building Number
107

PHOENIX, AZ


Checked
Checker

Drawn
WRL

Date
02/14/2014

Project No.
649-11-116
649-12-118

DRAWING NO.
107-MPD-105
Dwg 43 of 70

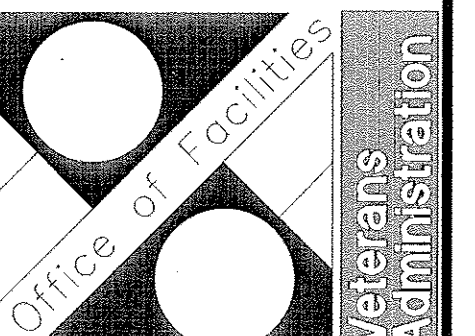

BID SET