


FLOOR PLAN NOTES

1. INSTALL CONTROL WIRING IN CONDUIT AND PAINT TO MATCH EXISTING SURFACE.

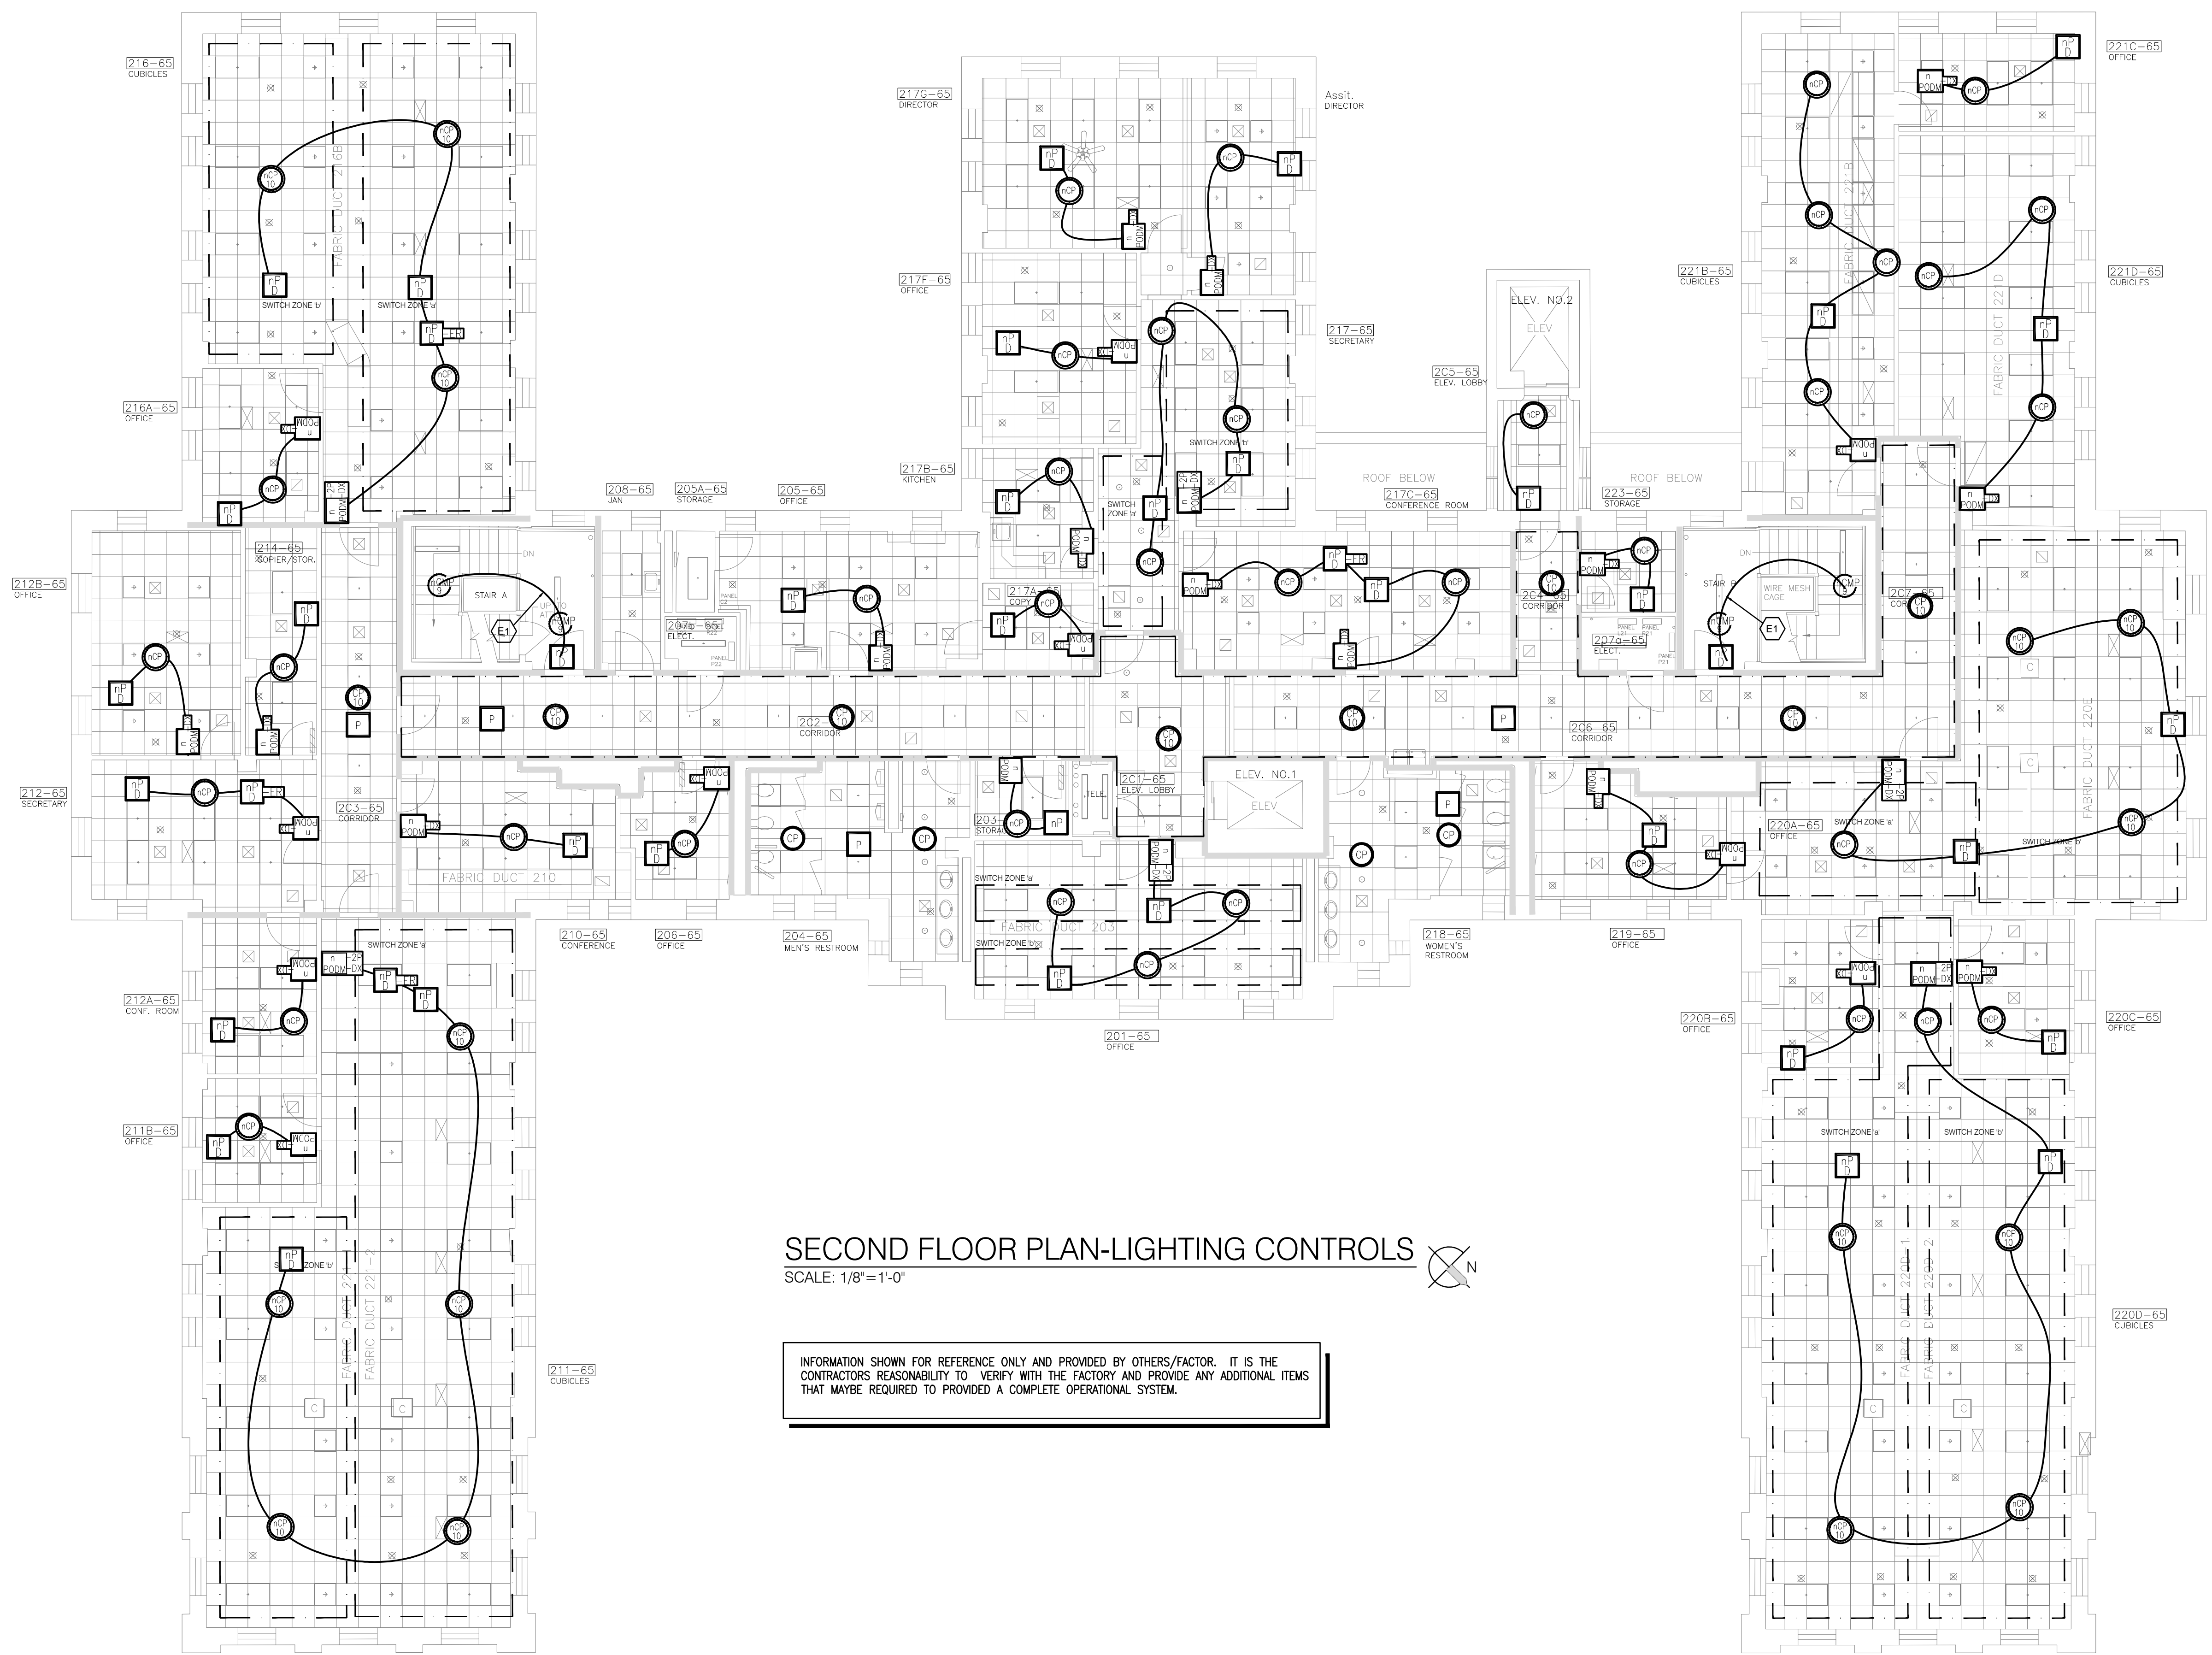

SECOND FLOOR PLAN-LIGHTING CONTROLS

SCALE: 1/8"=1'-0"

INFORMATION SHOWN FOR REFERENCE ONLY AND PROVIDED BY OTHERS/FACTOR. IT IS THE CONTRACTORS' RESPONSIBILITY TO VERIFY WITH THE FACTORY AND PROVIDE ANY ADDITIONAL ITEMS THAT MAYBE REQUIRED TO PROVIDED A COMPLETE OPERATIONAL SYSTEM.

Revision	Date
100% For Construction	02.20.15

CONSULTANTS:

Lankford | Fendler
and Associates
1730 Walnut Street
Kansas City, MO
64108
816.221.1411



ARCHITECT / ENGINEER:

TOMPKINS ARCHITECTS
507 Walnut Street, Suite 200, Kansas City, MO 64106
p. 816 472.5656 f. 816 472.5637 www.tom-arch.com

COPYRIGHT 2015 BY TOMPKINS ARCHITECTS, INC. ALL RIGHTS RESERVED. NO PART OF THESE DOCUMENTS MAY BE REPRODUCED, STORED IN A RETRIEVAL SYSTEM, OR TRANSMITTED IN ANY FORM OR BY ANY MEANS, ELECTRONIC, MECHANICAL, PHOTO COPYING, RECORDING, OR OTHERWISE, WITHOUT THE PRIOR WRITTEN PERMISSION OF TOMPKINS ARCHITECTS, INC.

Drawing Title

**SECOND FLOOR PLAN
LIGHTING CONTROLS**

Approved: Project Director

Project Title

**BUILDING 65
BUILDING DESIGN FOR LIGHTING
IMPROVEMENT**

Location

V.A.M.C. NLR DIVISION

Date

February 20, 2015

Checked

GJF

Drawn

BCD

Project Number

VA101V-14C-0104

Building Number

65

Drawing Number

E203A

**CENTRAL
ARKANSAS VA
HEALTH CARE
SYSTEM**



1730 Walnut Street, Kansas City, Missouri 64108
816.221.1411 | Fax: 816.221.1429
LANKFORD | FENDLER + ASSOCIATES, CONSULTING ENGINEERS, INC.
COPYRIGHT © 2015. Project No. 4884