


MALCOM RANDALL VETERANS ADMINISTRATION MEDICAL CENTER

1601 SOUTHWEST ARCHER ROAD
GAINESVILLE FLORIDA

PROJECT NUMBER 573-09-604
EXPAND SPRINKLER SYSTEM B - 1 (FCA D)

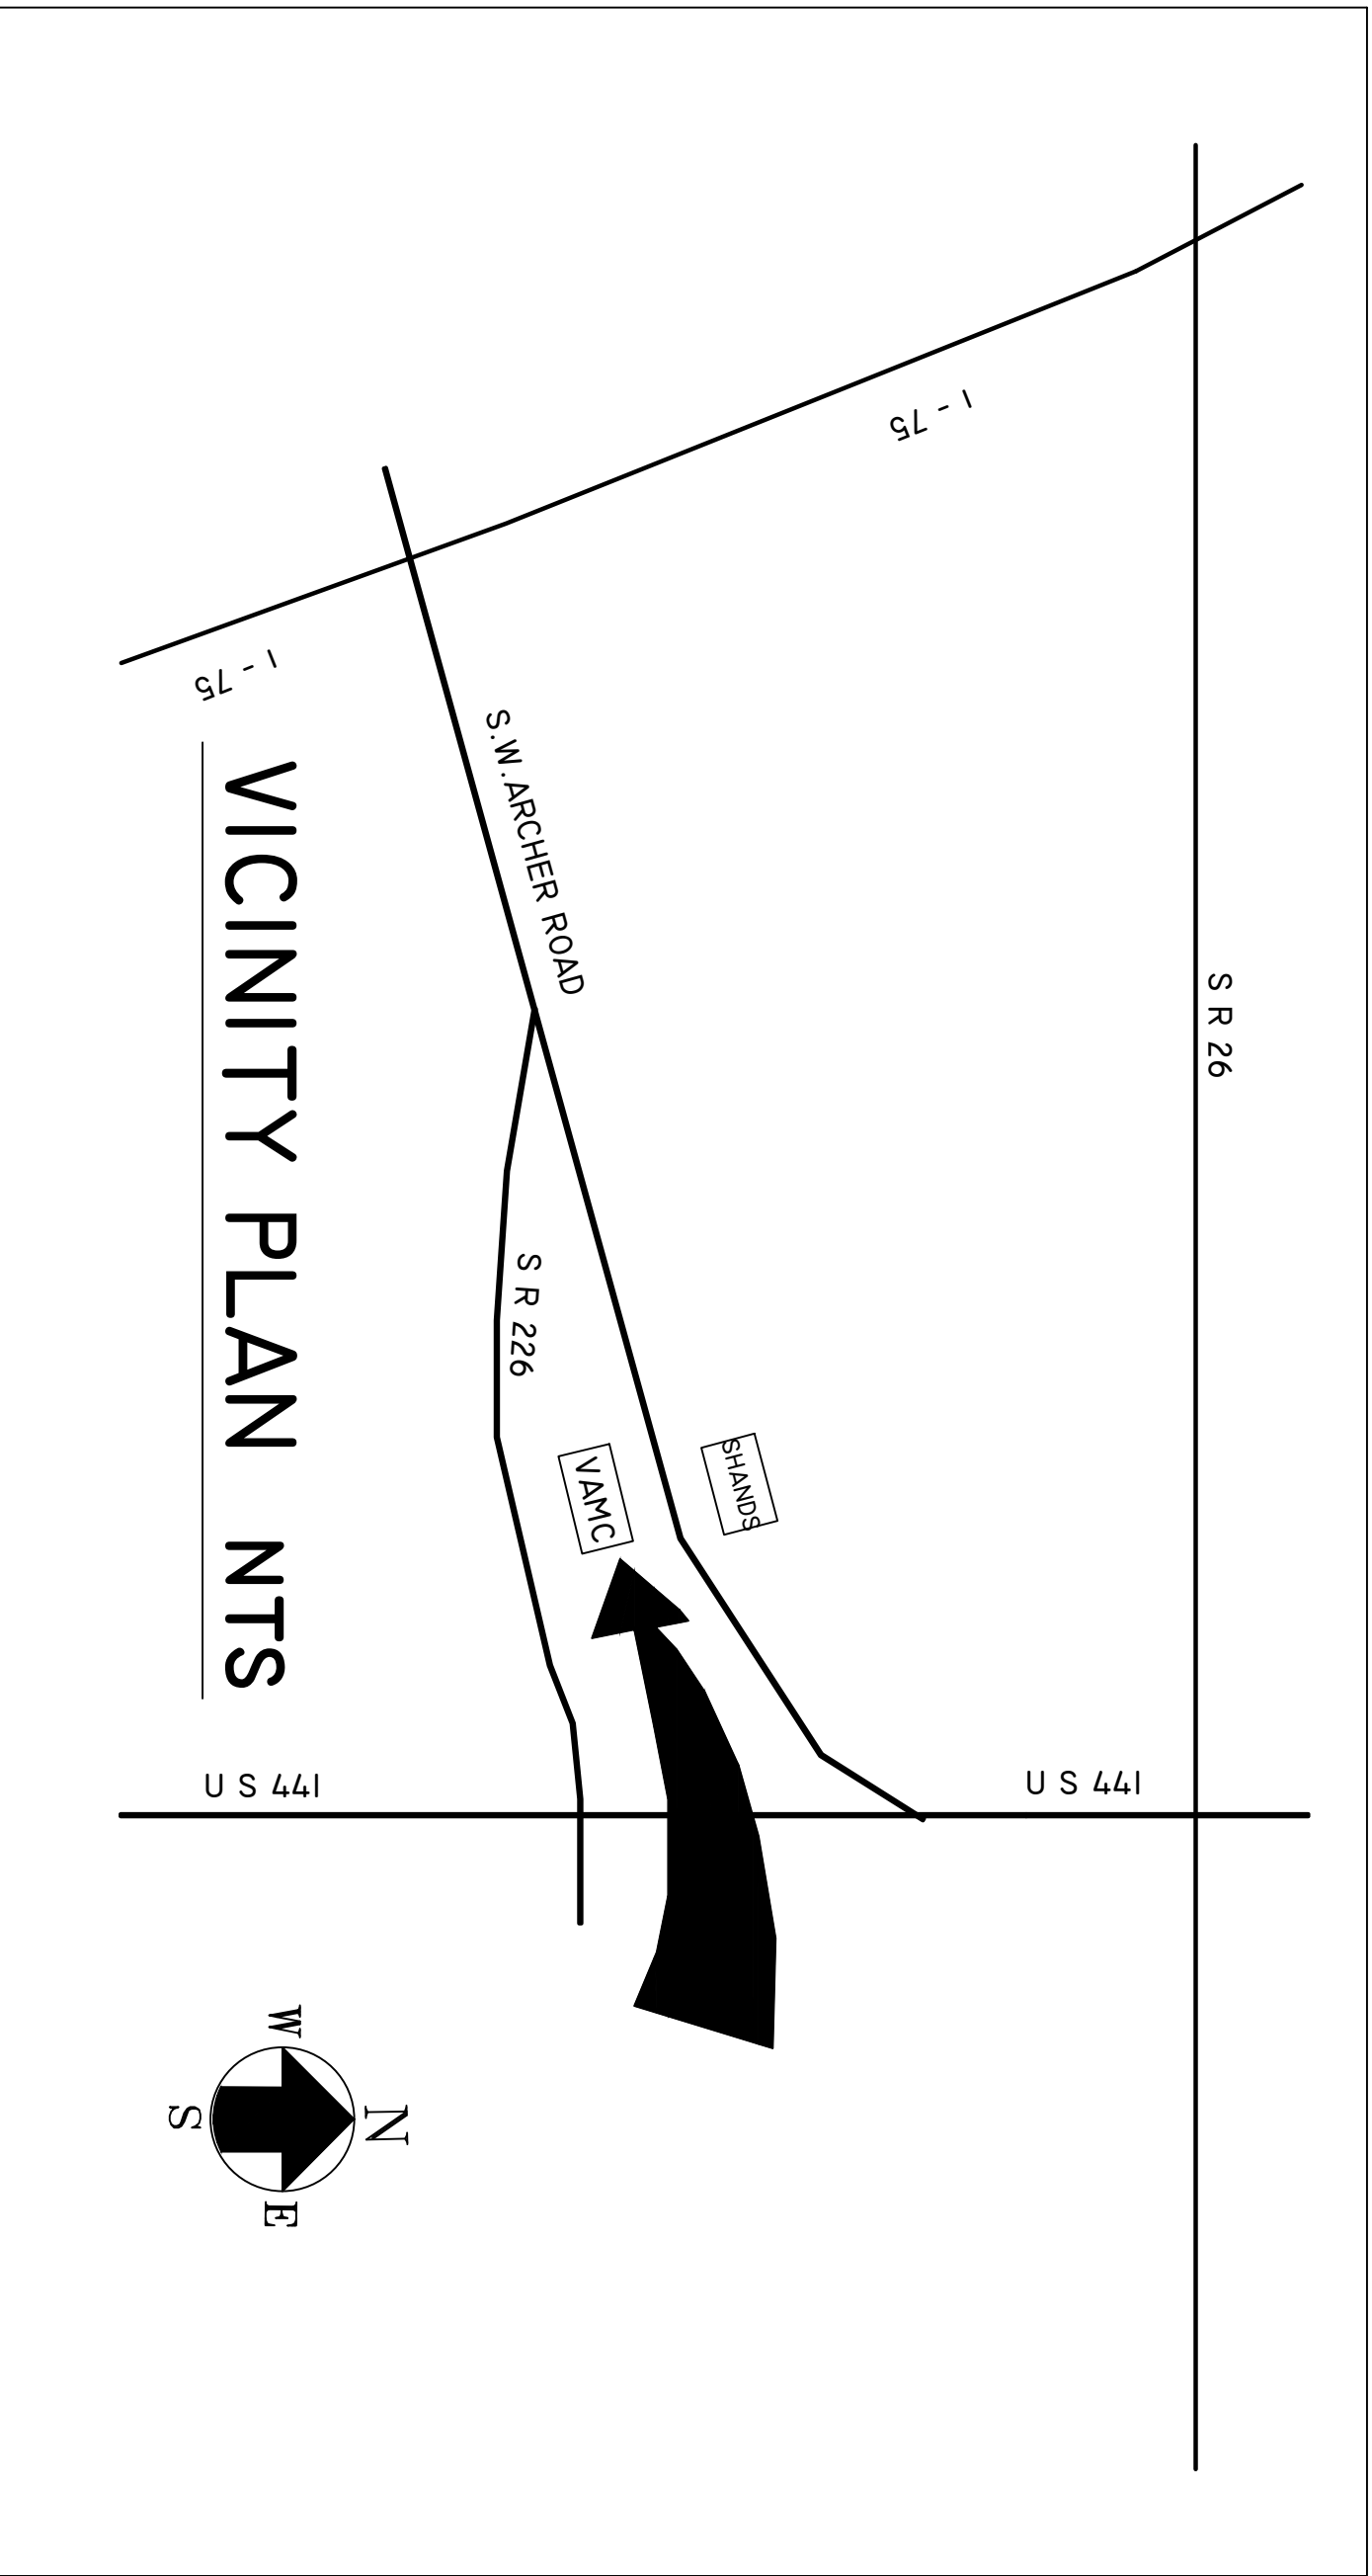

CONSULTANTS

DELTA FIRE PROTECTION ENGINEERING, INC.
Florida Authorization # 8473 - Delta Project # SD-13-0032
111 TECH DRIVE SANFORD, FLORIDA 32771
PHONE (407) 328-3000
FAX (407) 328-3001

INDEX OF DRAWINGS

FP-100 1 OF 19 BUILDING ONE FIRE SPRINKLER SYSTEM GENERAL NOTES
FP-101 2 OF 19 BUILDING ONE FIRE SPRINKLER SYSTEM GENERAL DETAILS
FP-102 3 OF 19 BUILDING ONE SUB BASEMENT MAIN SUPPLY FIRE SPRINKLER PLAN
FP-103 4 OF 19 BUILDING ONE BASEMENT NE QUADRANT FIRE SPRINKLER PLAN
FP-104 5 OF 19 BUILDING ONE BASEMENT SE QUADRANT FIRE SPRINKLER PLAN
FP-105 6 OF 19 BUILDING ONE BASEMENT SW QUADRANT FIRE SPRINKLER PLAN
FP-106 7 OF 19 BUILDING ONE BASEMENT NW QUADRANT FIRE SPRINKLER PLAN
FP-107 8 OF 19 BUILDING ONE 1ST FLOOR NE QUADRANT FIRE SPRINKLER PLAN
FP-108 9 OF 19 BUILDING ONE 1ST FLOOR SE QUADRANT FIRE SPRINKLER PLAN
FP-109 10 OF 19 BUILDING ONE 1ST FLOOR SW QUADRANT FIRE SPRINKLER PLAN
FP-110 11 OF 19 BUILDING ONE 1ST FLOOR NW QUADRANT FIRE SPRINKLER PLAN
FP-111 12 OF 19 BUILDING ONE 2ND FLOOR EAST TOWER FIRE SPRINKLER PLAN
FP-112 13 OF 19 BUILDING ONE 2ND FLOOR WEST TOWER FIRE SPRINKLER PLAN
FP-113 14 OF 19 BUILDING ONE 3RD FLOOR EAST TOWER FIRE SPRINKLER PLAN
FP-114 15 OF 19 BUILDING ONE 3RD FLOOR WEST TOWER FIRE SPRINKLER PLAN
FP-115 16 OF 19 BUILDING ONE 4TH FLOOR EAST TOWER FIRE SPRINKLER PLAN
FP-116 17 OF 19 BUILDING ONE 4TH FLOOR WEST TOWER FIRE SPRINKLER PLAN
FP-117 18 OF 19 BUILDING ONE 5TH FLOOR EAST TOWER FIRE SPRINKLER PLAN
FP-118 19 OF 19 BUILDING ONE 5TH FLOOR WEST TOWER FIRE SPRINKLER PLAN

PROJECT MANAGER

S E S , LLC - 1006 FLOYD CULLER COURT
OAK RIDGE, TN 37830
PHONE (865) 481-7837
FAX (865) 481-0290

CONSULTANTS:

DELTA FIRE PROTECTION ENGINEERING, Inc.
Florida Authorization # 8473 - Delta Project # SD-13-0032
111 TECH DRIVE SANFORD, FLORIDA 32771
PHONE (407) 328-3000
FAX (407) 328-3001

PROJECT MANAGER:

SES, LLC
1006 FLOYD CULLER COURT
OAK RIDGE, TN 37830
Tel (865) 481-7837
Fax (865) 481-0290

Drawing Title

BUILDING ONE
COVER SHEET

Project Title
EXPAND SPRINKLER SYSTEM
B-1 (FCA D)

Location
VAMC GAINESVILLE, FLORIDA

Project Number
573-09-604

Building Number
1

Office of
Construction
and Facilities
Management

Approved Project Director

Location
MALCOM RANDALL VA MEDICAL CENTER

Drawing Number
000

Department of
Veterans Affairs

one eighth inch = one foot
one quarter inch = one foot

VA FORM 09-5231