


MALCOM RANDALL VETERANS  
ADMINISTRATION MEDICAL CENTER  
GAINESVILLE, FLORIDA

PROJECT LOCATION

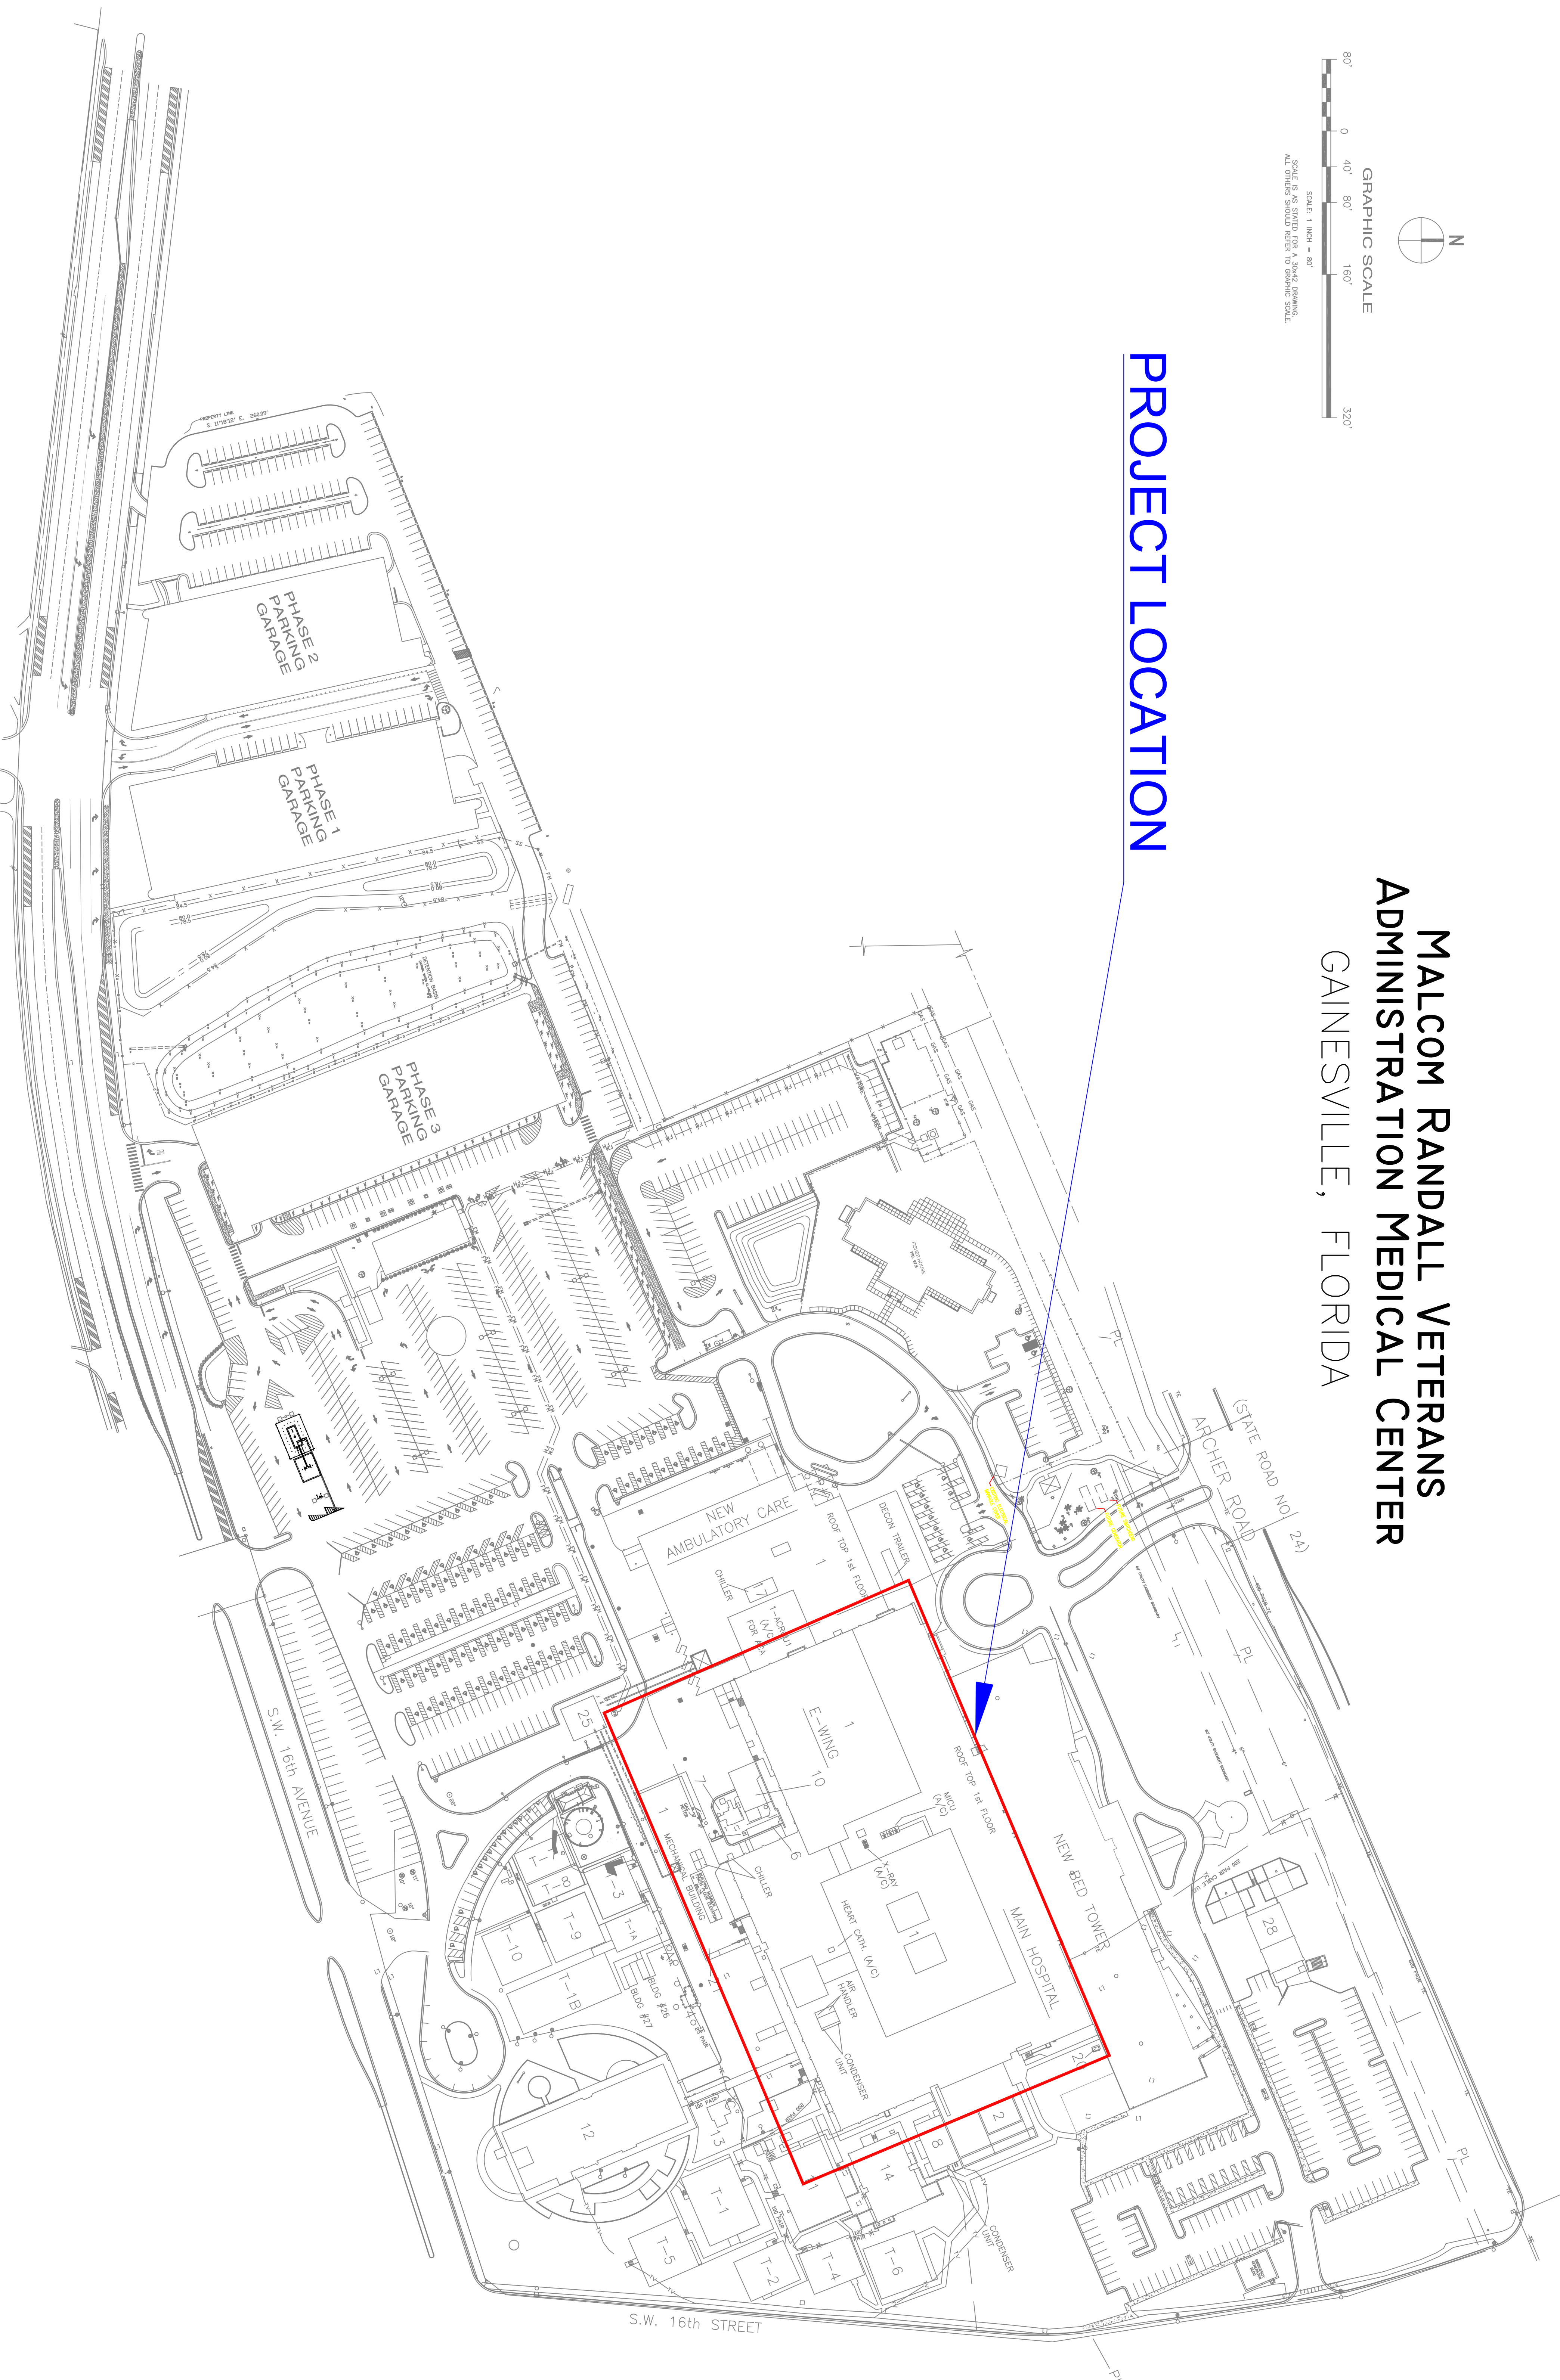

SITE PLAN

Revisions		Date		Seal	
Approved:		Facilities Management Service		Drawing Title	
Approved: Chief, Facilities Management Service		Approved: Service Director		Project Title	
Approved: Chief, Facilities Management Service		Approved: Service Director		EXPAND SPRINKLER SYSTEM B-1 (FCA D)	
Approved: Service Director		Approved: Service Director		Building Number	
Approved: Service Director		Approved: Service Director		NONE	
Approved: Service Director		Approved: Service Director		Checked	
Approved: Service Director		Approved: Service Director		SSH	
Approved: Service Director		Approved: Service Director		Drawn	
Approved: Service Director		Approved: Service Director		RDT	
Approved: Service Director		Approved: Service Director		Location	
Approved: Service Director		Approved: Service Director		Malcom Randall VA Medical Center	
Approved: Service Director		Approved: Service Director		Date	
Approved: Service Director		Approved: Service Director		JANUARY 20, 2015	
Approved: Service Director		Approved: Service Director		Project No.	
Approved: Service Director		Approved: Service Director		573-16-600	
Approved: Service Director		Approved: Service Director		Drawing No.	
Approved: Service Director		Approved: Service Director		DWG. OF	
Approved: Service Director		Approved: Service Director		Office of Facilities	
Approved: Service Director		Approved: Service Director		Department of Veterans Affairs	