


ISSUED FOR CONSTRUCTION DOCUMENTS (FINAL BD)	11/26/13
ISSUED FOR 100% DESIGN SUBMITTAL	10/28/13
ISSUED FOR 75% DESIGN DEVELOPMENT	08/22/13
Provisions	Date

CONSULTANTS:

CONSULTANTS:


ARCHITECT/ENGINEERS:


EPSTEIN
600 West Fulton Street
Chicago, Illinois 60661


Drawing Title MECHANICAL CONTROLS	Project Title REPLACEMENT OF AHU S-10A IN BUILDING 30	Project Number 537-10-122
		Building Number BUILDING 30
Approved Project Director	Location 820 S. DAMEN AVE CHICAGO, IL 60612	Drawing Number 30-M-600
Date 11/26/2013	Checked YW	Drawn AM
		Dwg 06 of 10

FULLY SPRINKLERED

3 VARIABLE AIR VOLUME AIR HANDLING UNIT WITH MINIMUM OUTSIDE AIR CONTROL DIAGRAM
NTS

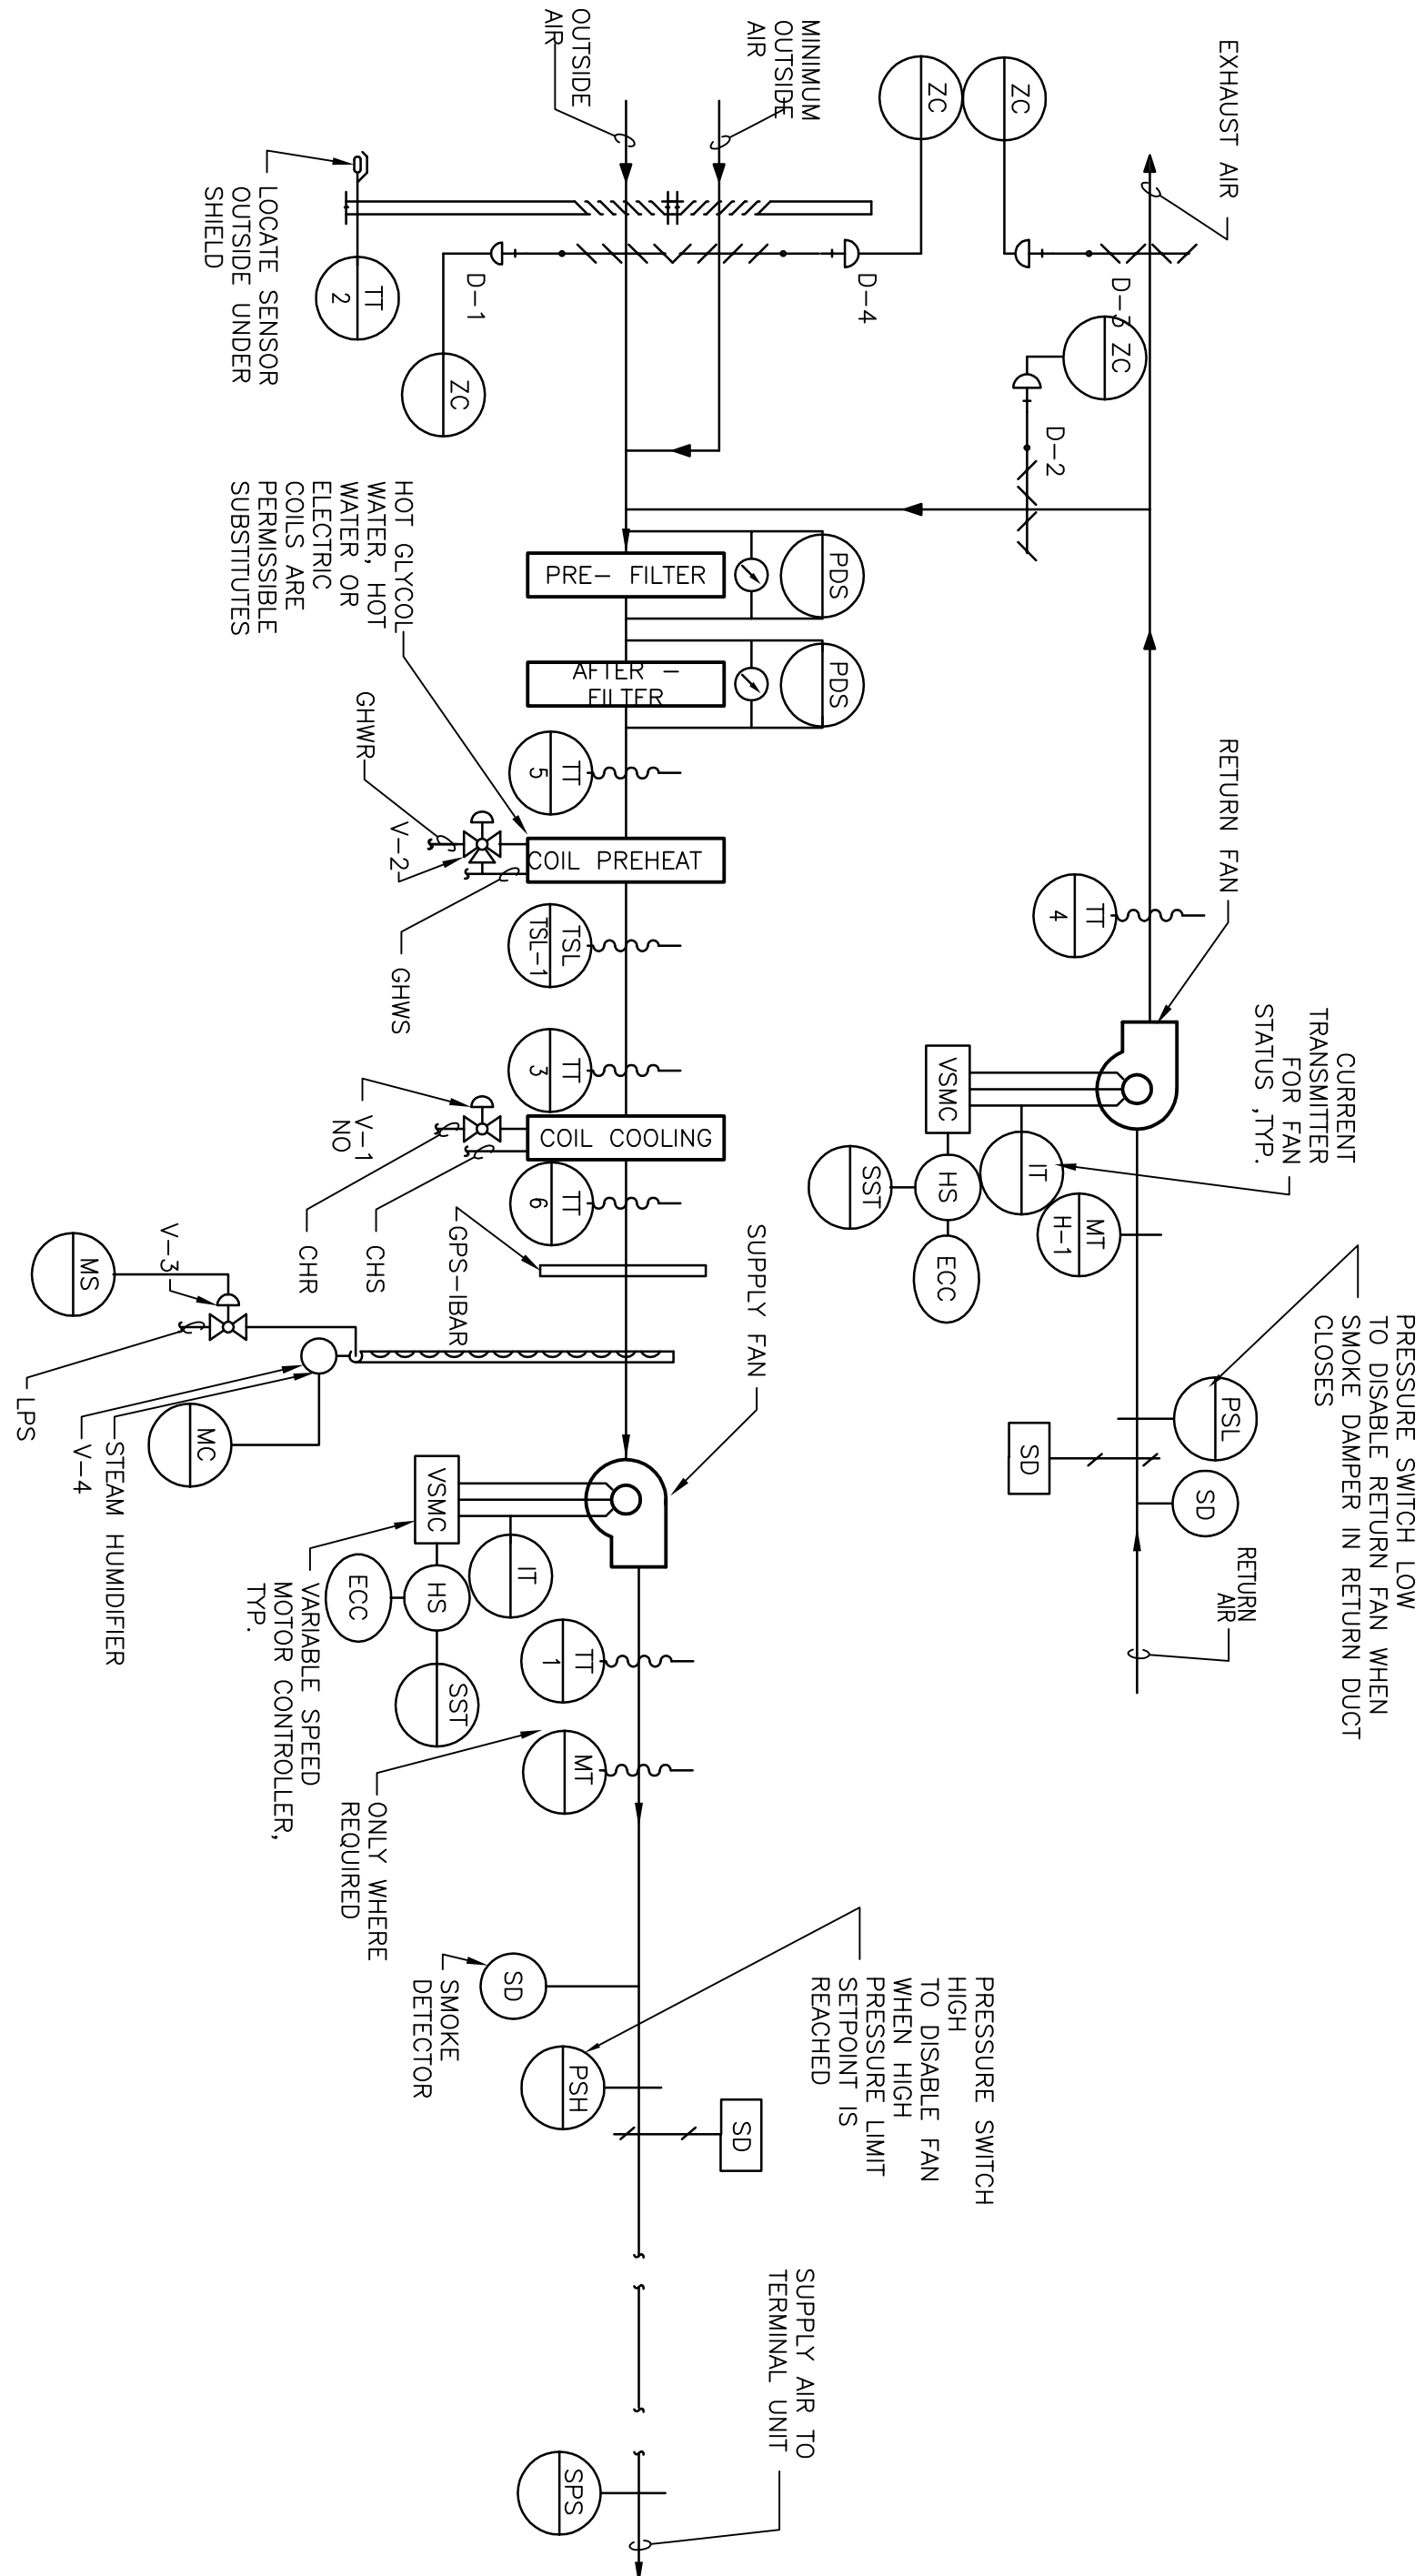

4 STEAM HUMIDIFIER CONTROLS

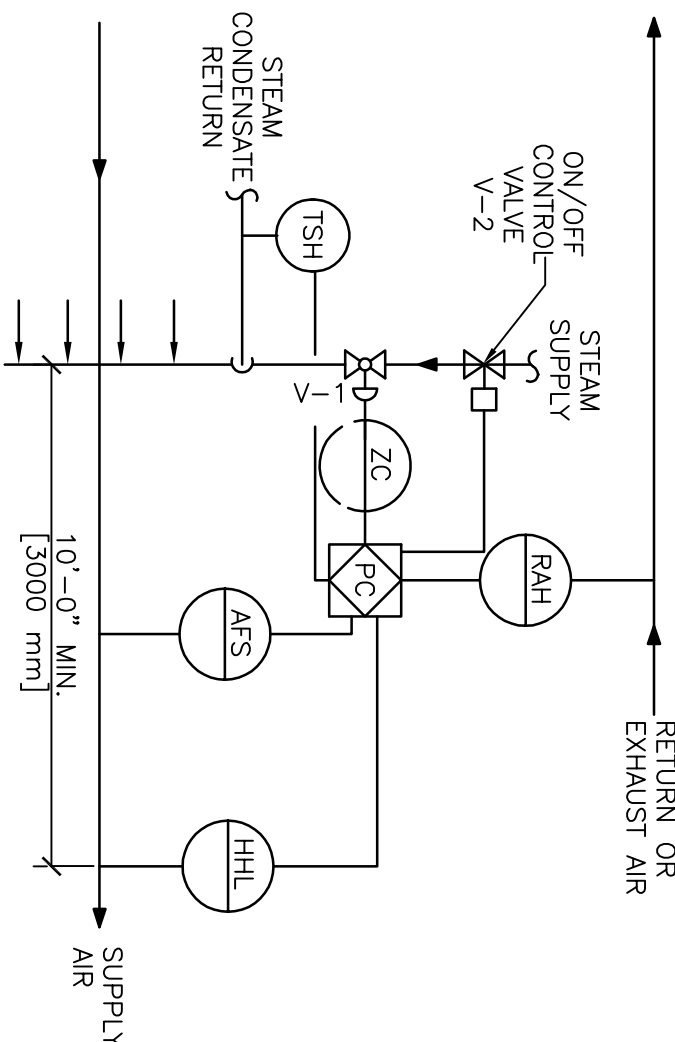
[illegible]

2 POINTS LIST FOR VAV AIR HANDLING UNIT WITH MINIMUM OUTSIDE AIR

NTS

[illegible]

1 SEQUENCE OF OPERATION FOR VARIABLE AIR VOLUME AIR HANDLING UNIT WITH MINIMUM OUTSIDE AIR

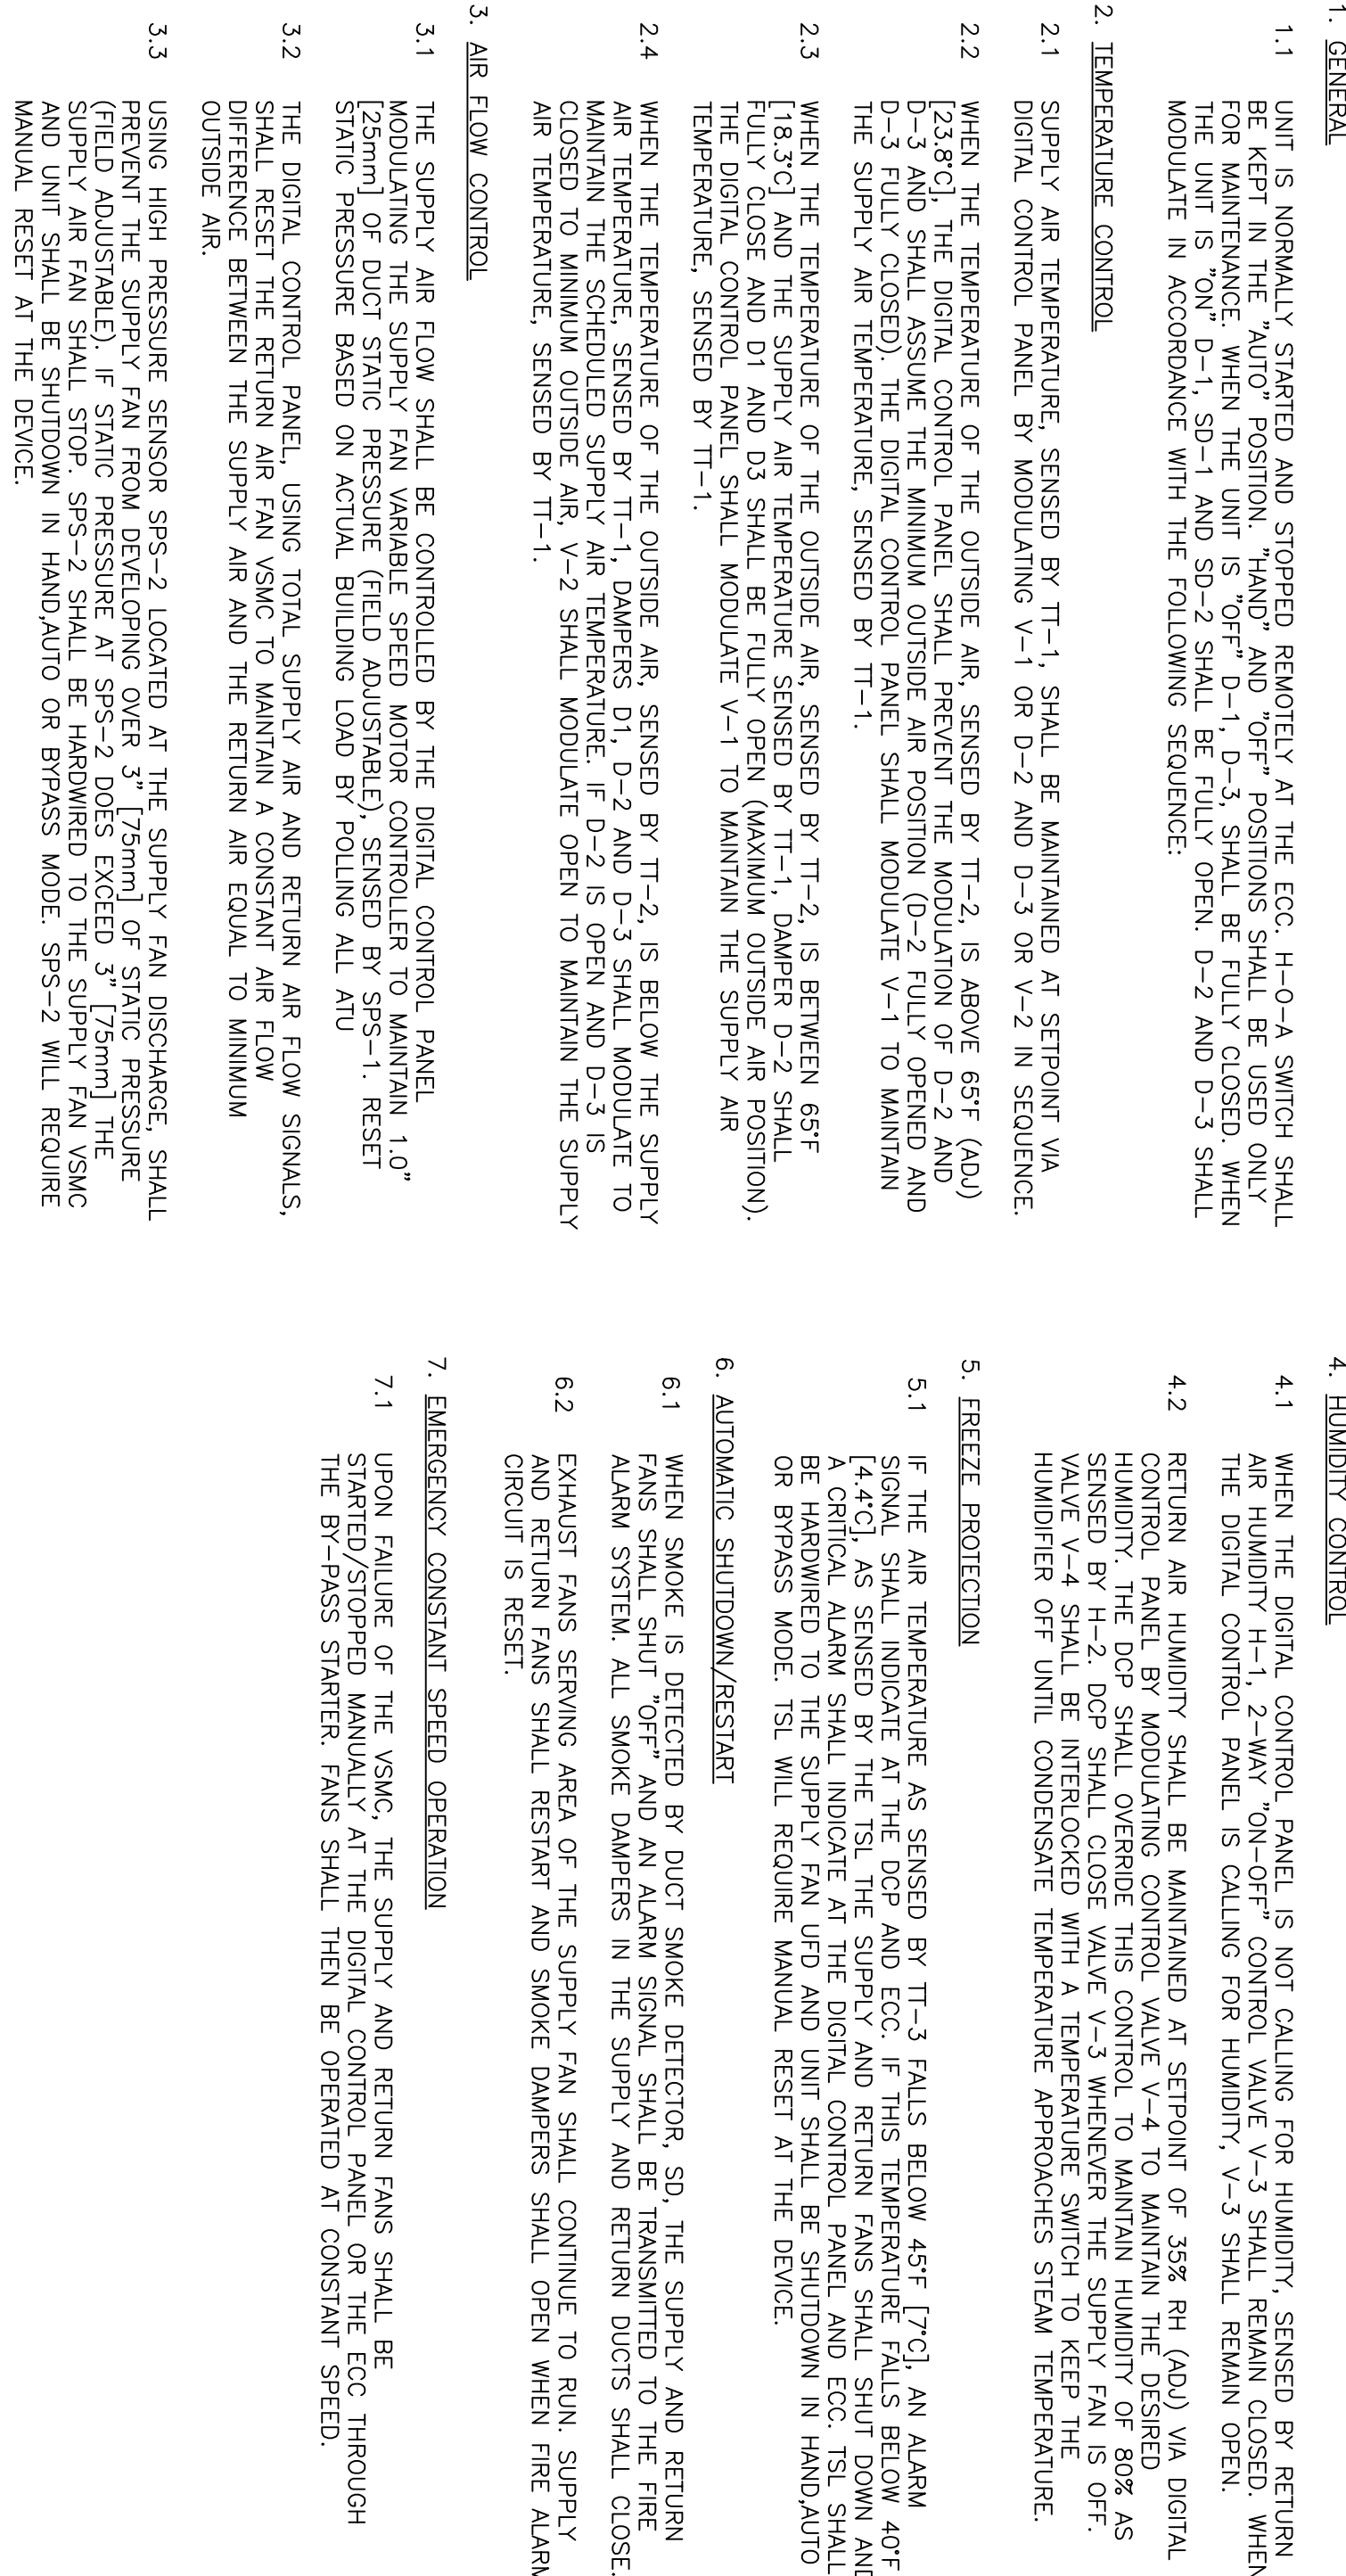

 Department of Veterans Affairs

Construction and Facilities Management