

ISSUED FOR CONSTRUCTION DOCUMENTS (FINAL BD)	07/26/12
ISSUED FOR 100% DESIGN SUBMITTAL	06/01/12
Prepared	Date

CONSULTANTS:

ARCHITECT/ENGINEERS:

STEPSTEIN  
600 West Fulton Street  
Chicago, Illinois 60661

Drawing Title  
MECHANICAL ROOM  
ELECTRICAL PLAN

Project Title  
REPLACEMENT OF AHU S-10B  
IN BUILDING 30

Project Number  
537-07-138  
Building Number  
BUILDING 30


Approved Project Director

Location  
820 S. DAMEN AVE CHICAGO, IL 60612  
Date  
07/26/2012  
Checked  
JP  
Drawn  
JF

Drawing Number  
30-E-101  
Dwg 09 of 09

Office of  
Construction  
and Facilities  
Management  
Department of  
Veterans Affairs

FULLY SPRINKLERED

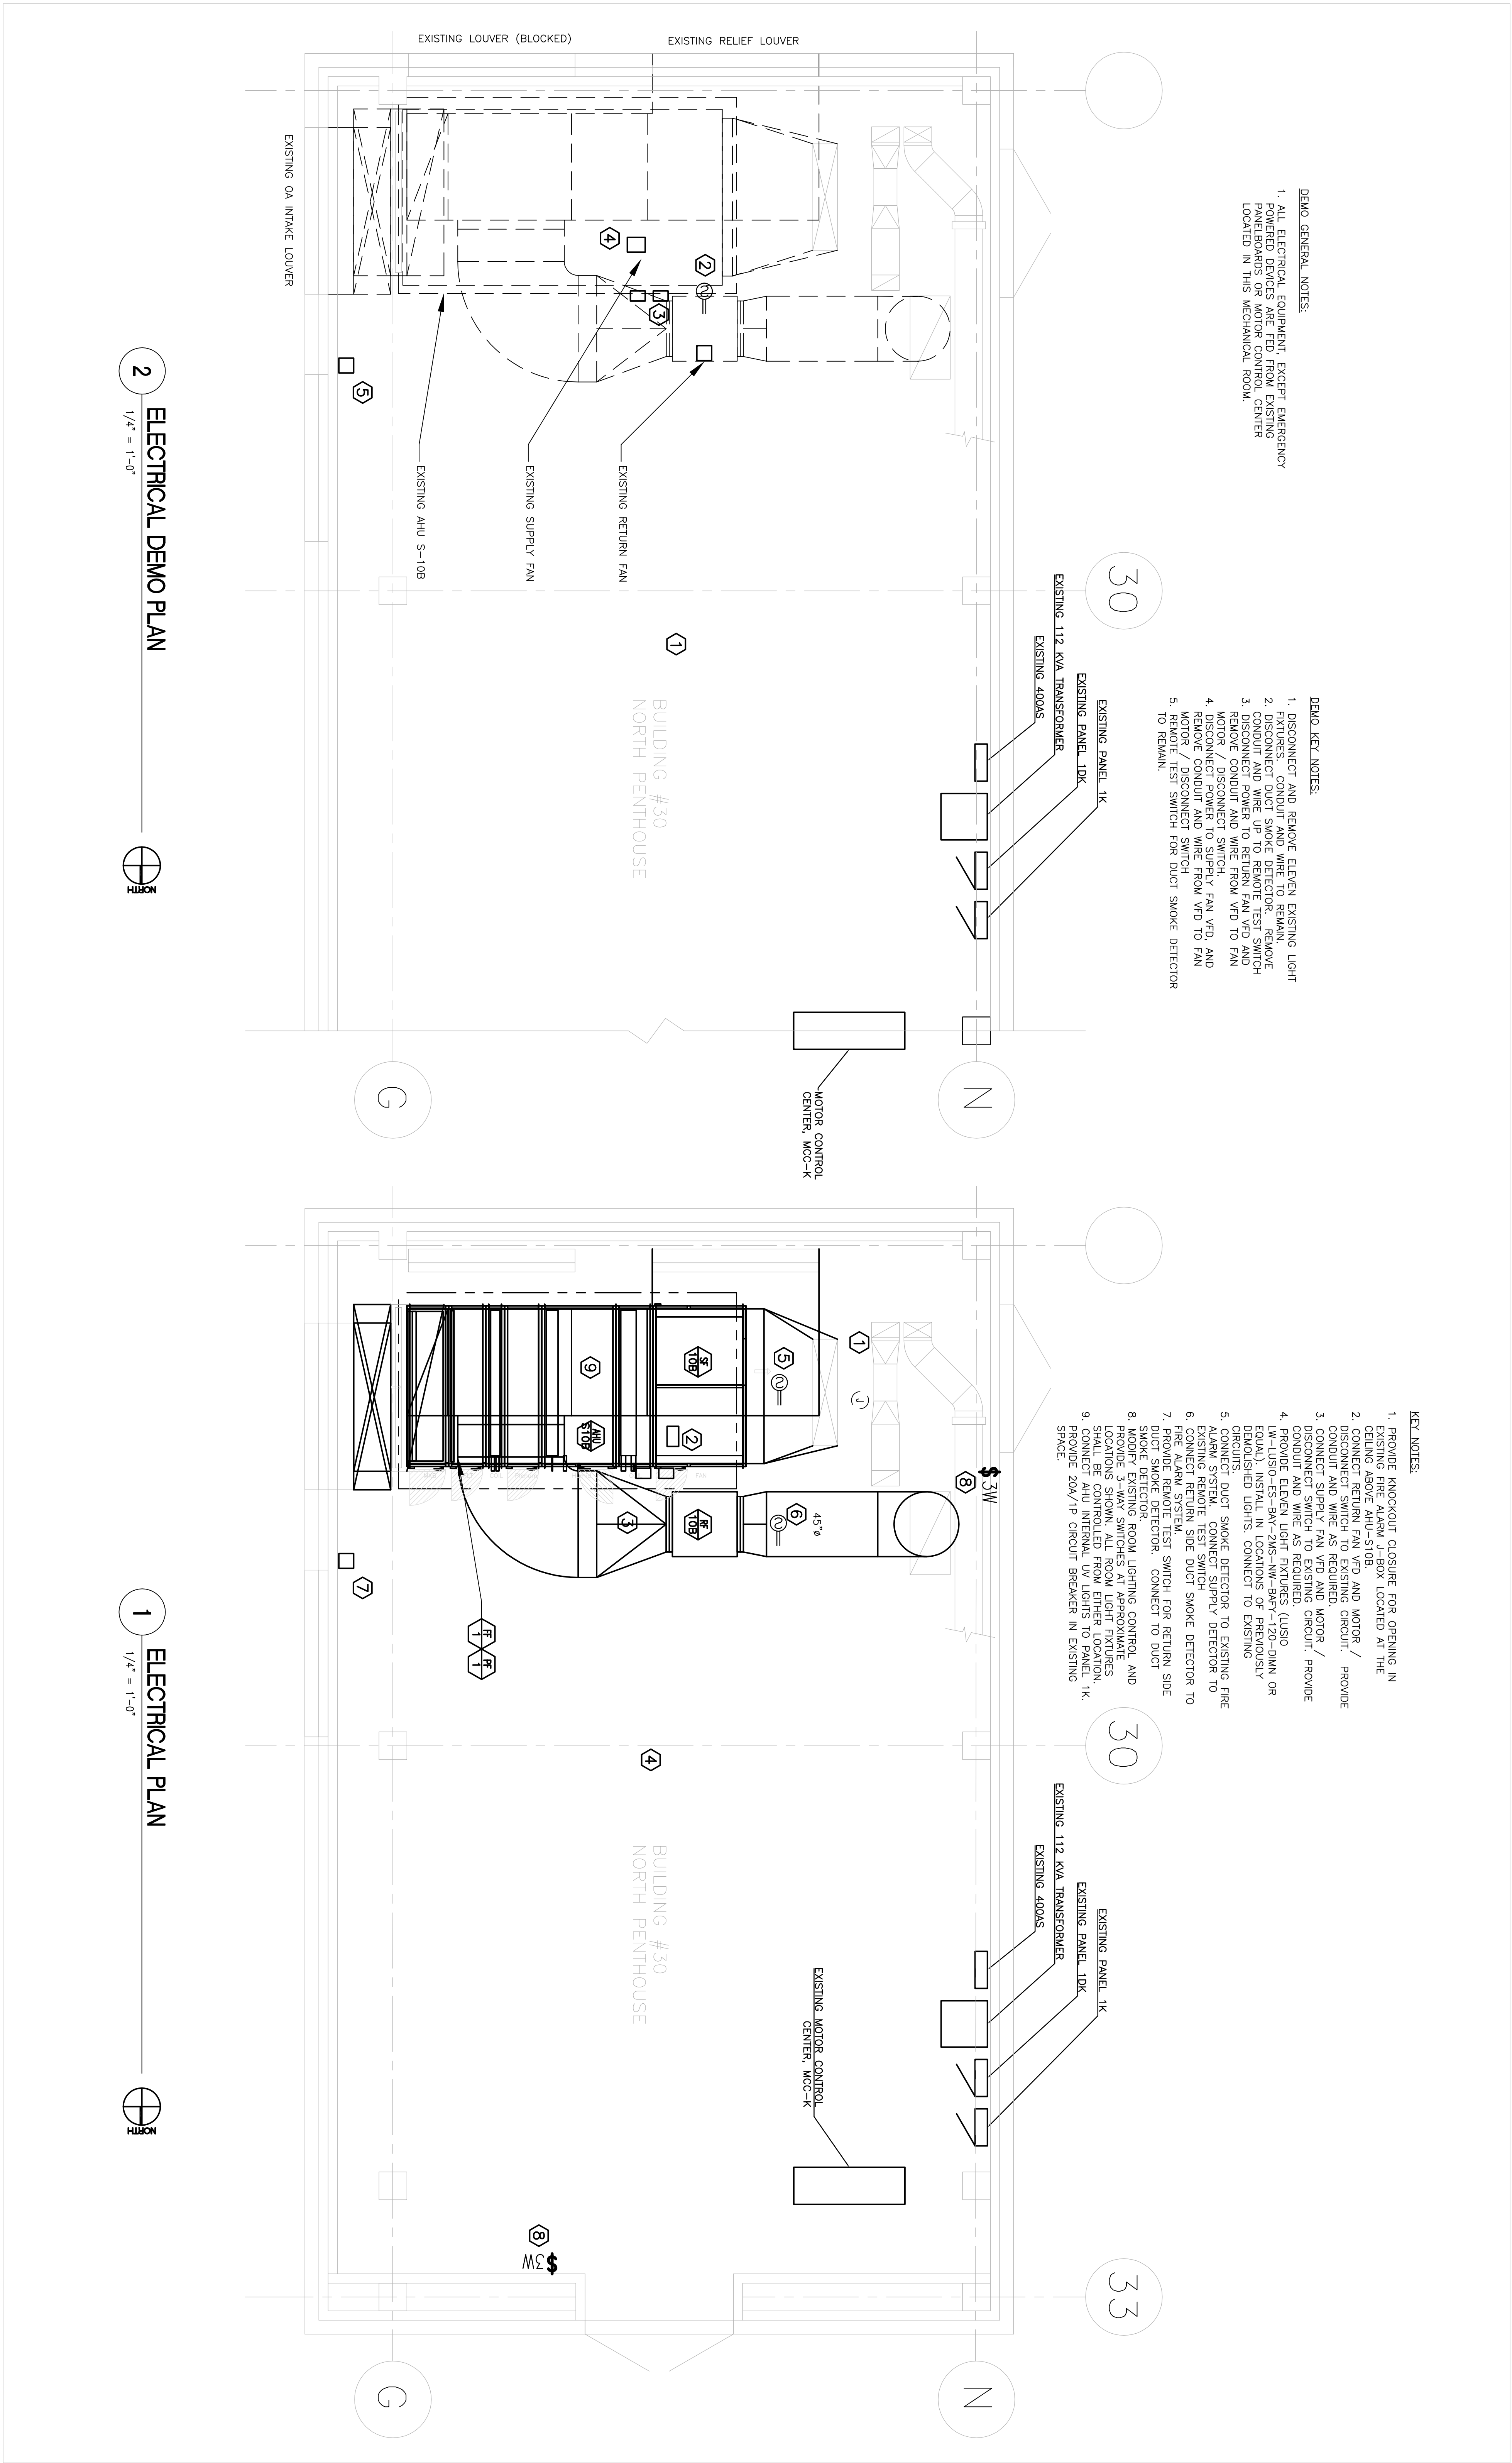

2 ELECTRICAL DEMO PLAN  
1/4" = 1'-0"

1 ELECTRICAL PLAN  
1/4" = 1'-0"