



VA JESSE BROWN MEDICAL CENTER

820 SOUTH DAMEN AVENUE

CHICAGO, ILLINOIS 60680



VA PROJECT NUMBER 537-07-138
EPSTEIN DESIGN PROJECT NUMBER 11226. TASK# 1

PROJECT NAME: REPLACEMENT OF AHU S-10B IN BUILDING #30
PROJECT LOCATION: BUILDING #30 NORTH PENTHOUSE

DRAWING INDEX:

S-10B REPLACEMENT	ISSUED FOR 50% DESIGN DEVELOPMENT 04/20/2012	ISSUED FOR 100% DESIGN SUBMITTAL 06/13/2012	ISSUED FOR CONSTRUCTION DOCUMENTS (FINAL BID) 07/25/2012
GENERAL INDEX AND TITLE SHEET	0	1	1
HEATING VENTILATING AIR CONDITIONING AND PIPING			
30-M-101 NOTES, SYMBOLS & ABBREVIATIONS			
30-M-101 MECHANICAL ROOM VENTILATION PLAN			
30-M-101 MECHANICAL ROOM PIPING PLAN			
30-M-101 MECHANICAL ROOM PIPING SCHEDULES			
30-M-101 MECHANICAL EQUIPMENT SCHEDULES			
ELECTRICAL ELECTRICAL SYMBOLS AND ABBREVIATIONS			
30-E-101 MECHANICAL ROOM ELECTRICAL PLAN			

Approved:	
Chief PMIS:	Approver
Chief of Projects:	Approver
Chief of Safety:	Approver
Chief of Staff:	Approver
ED Director:	Approver
Inspection Control:	Approver

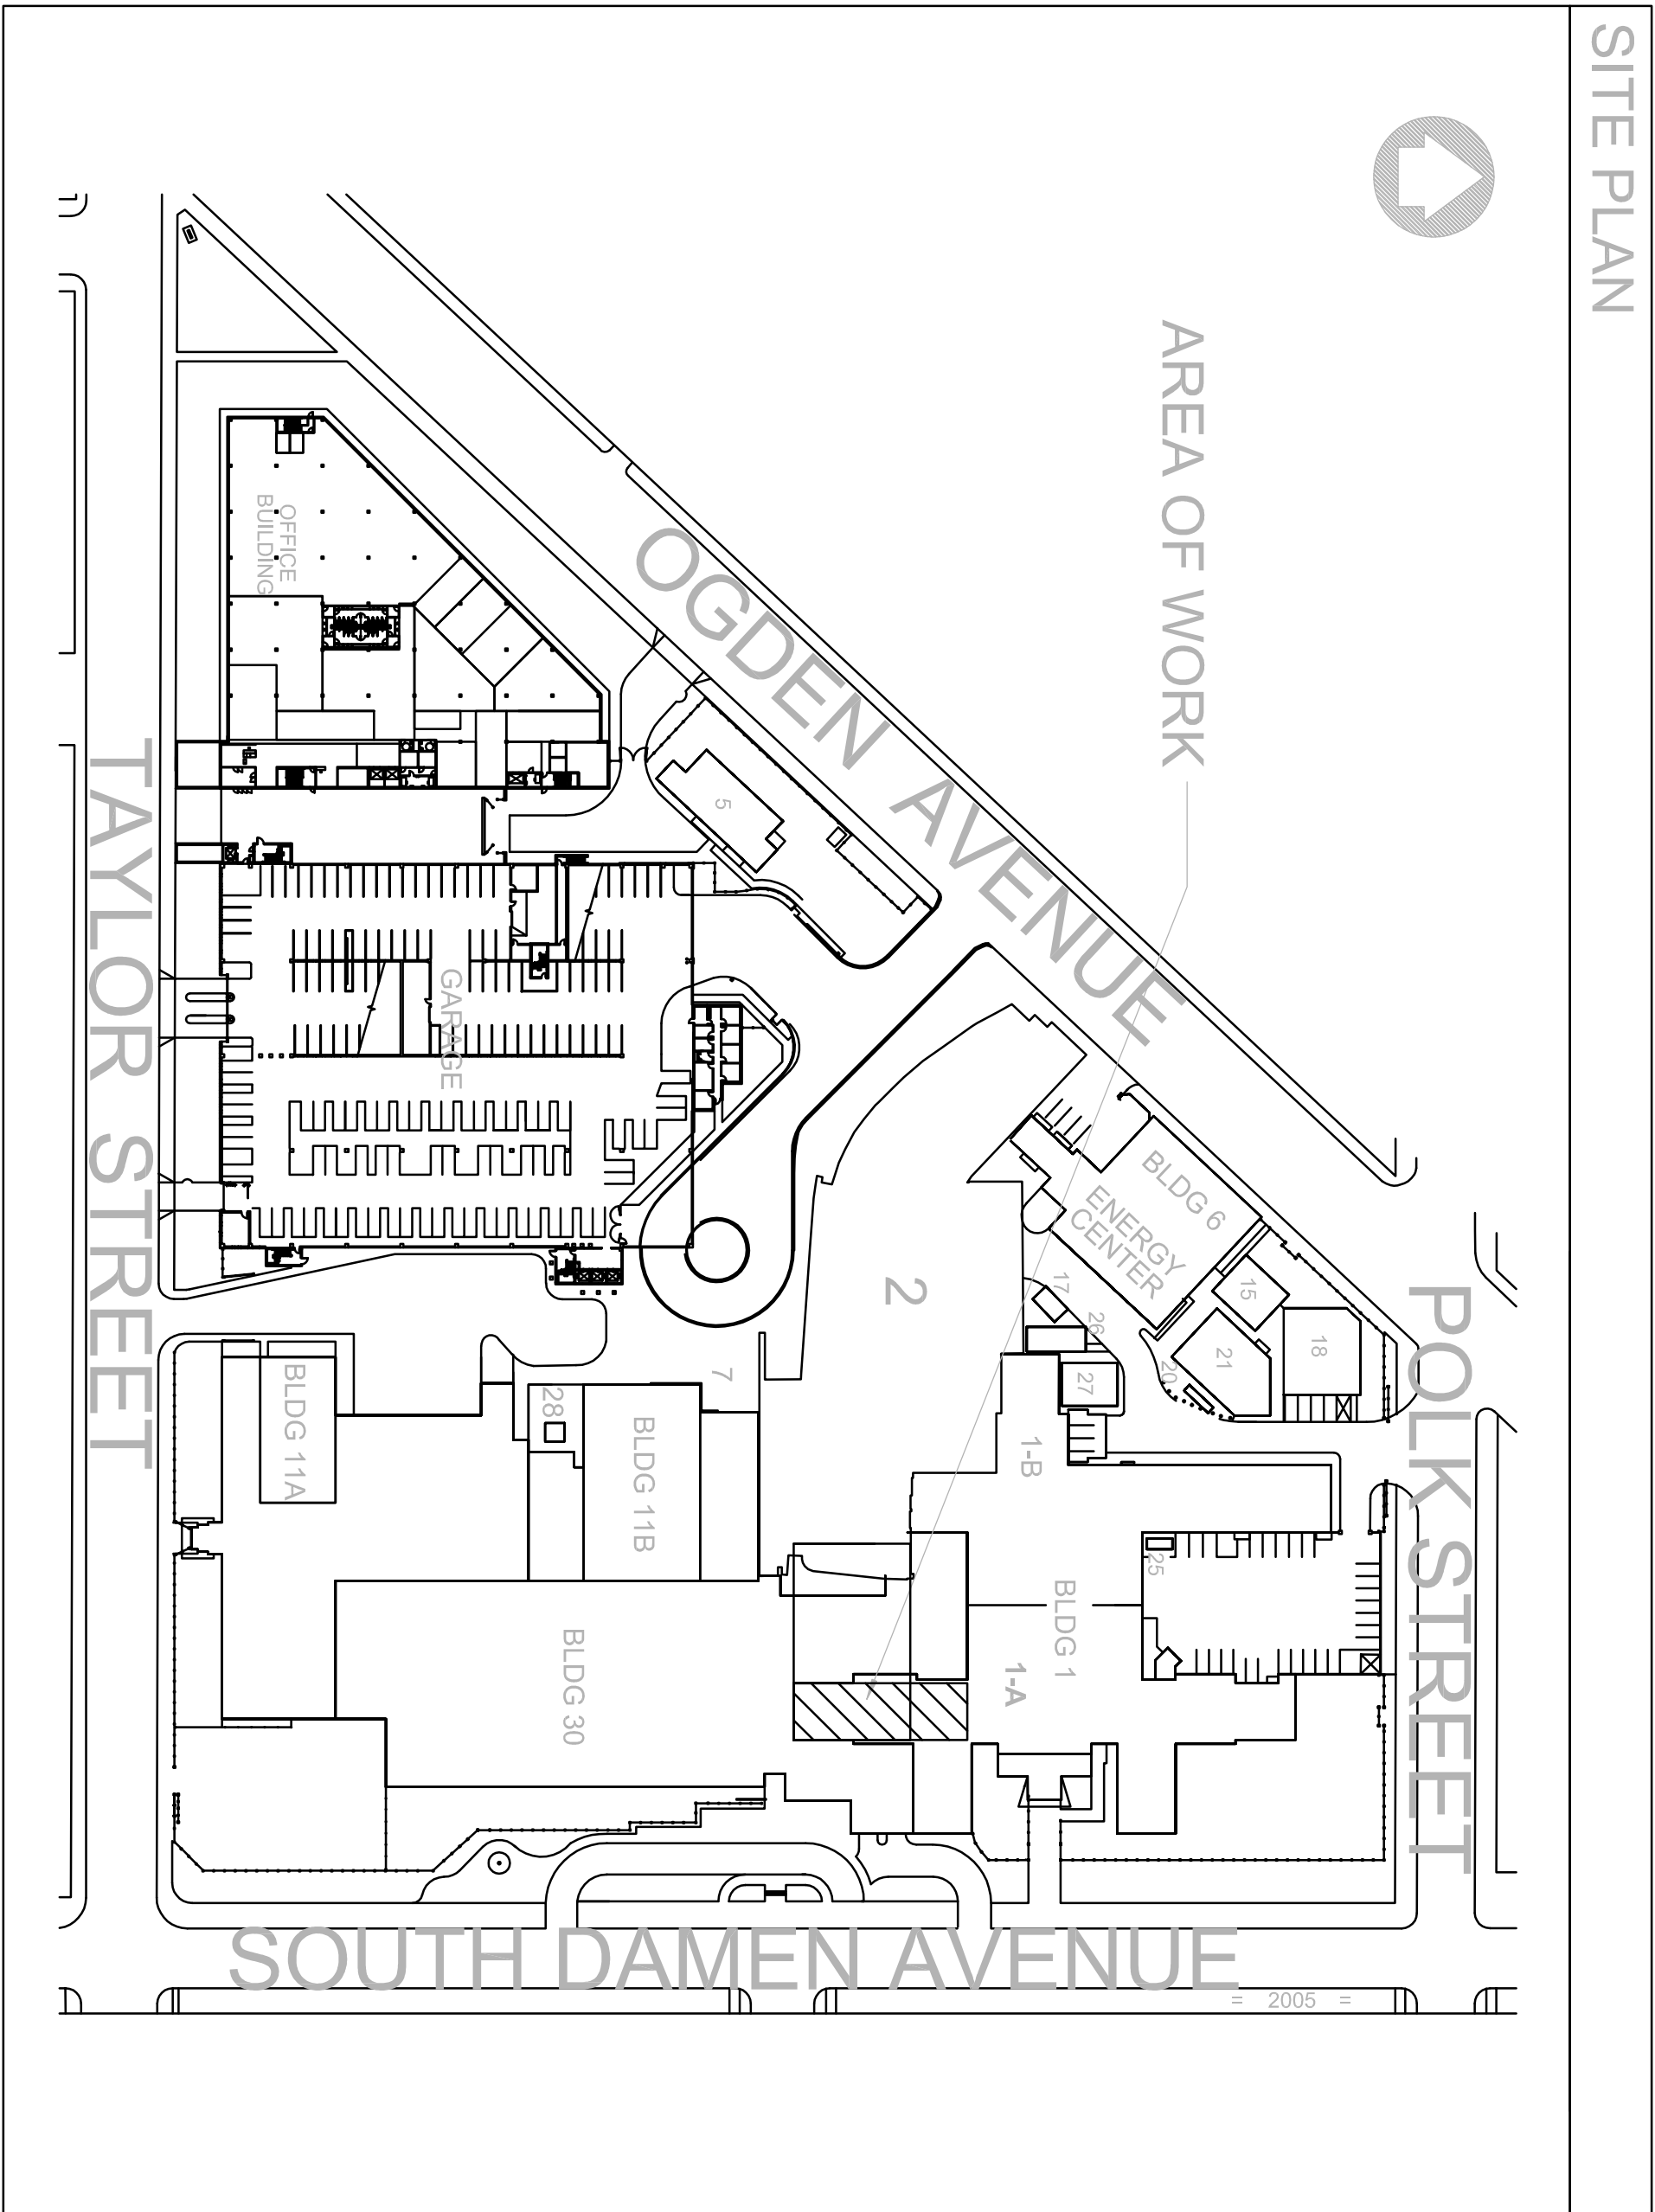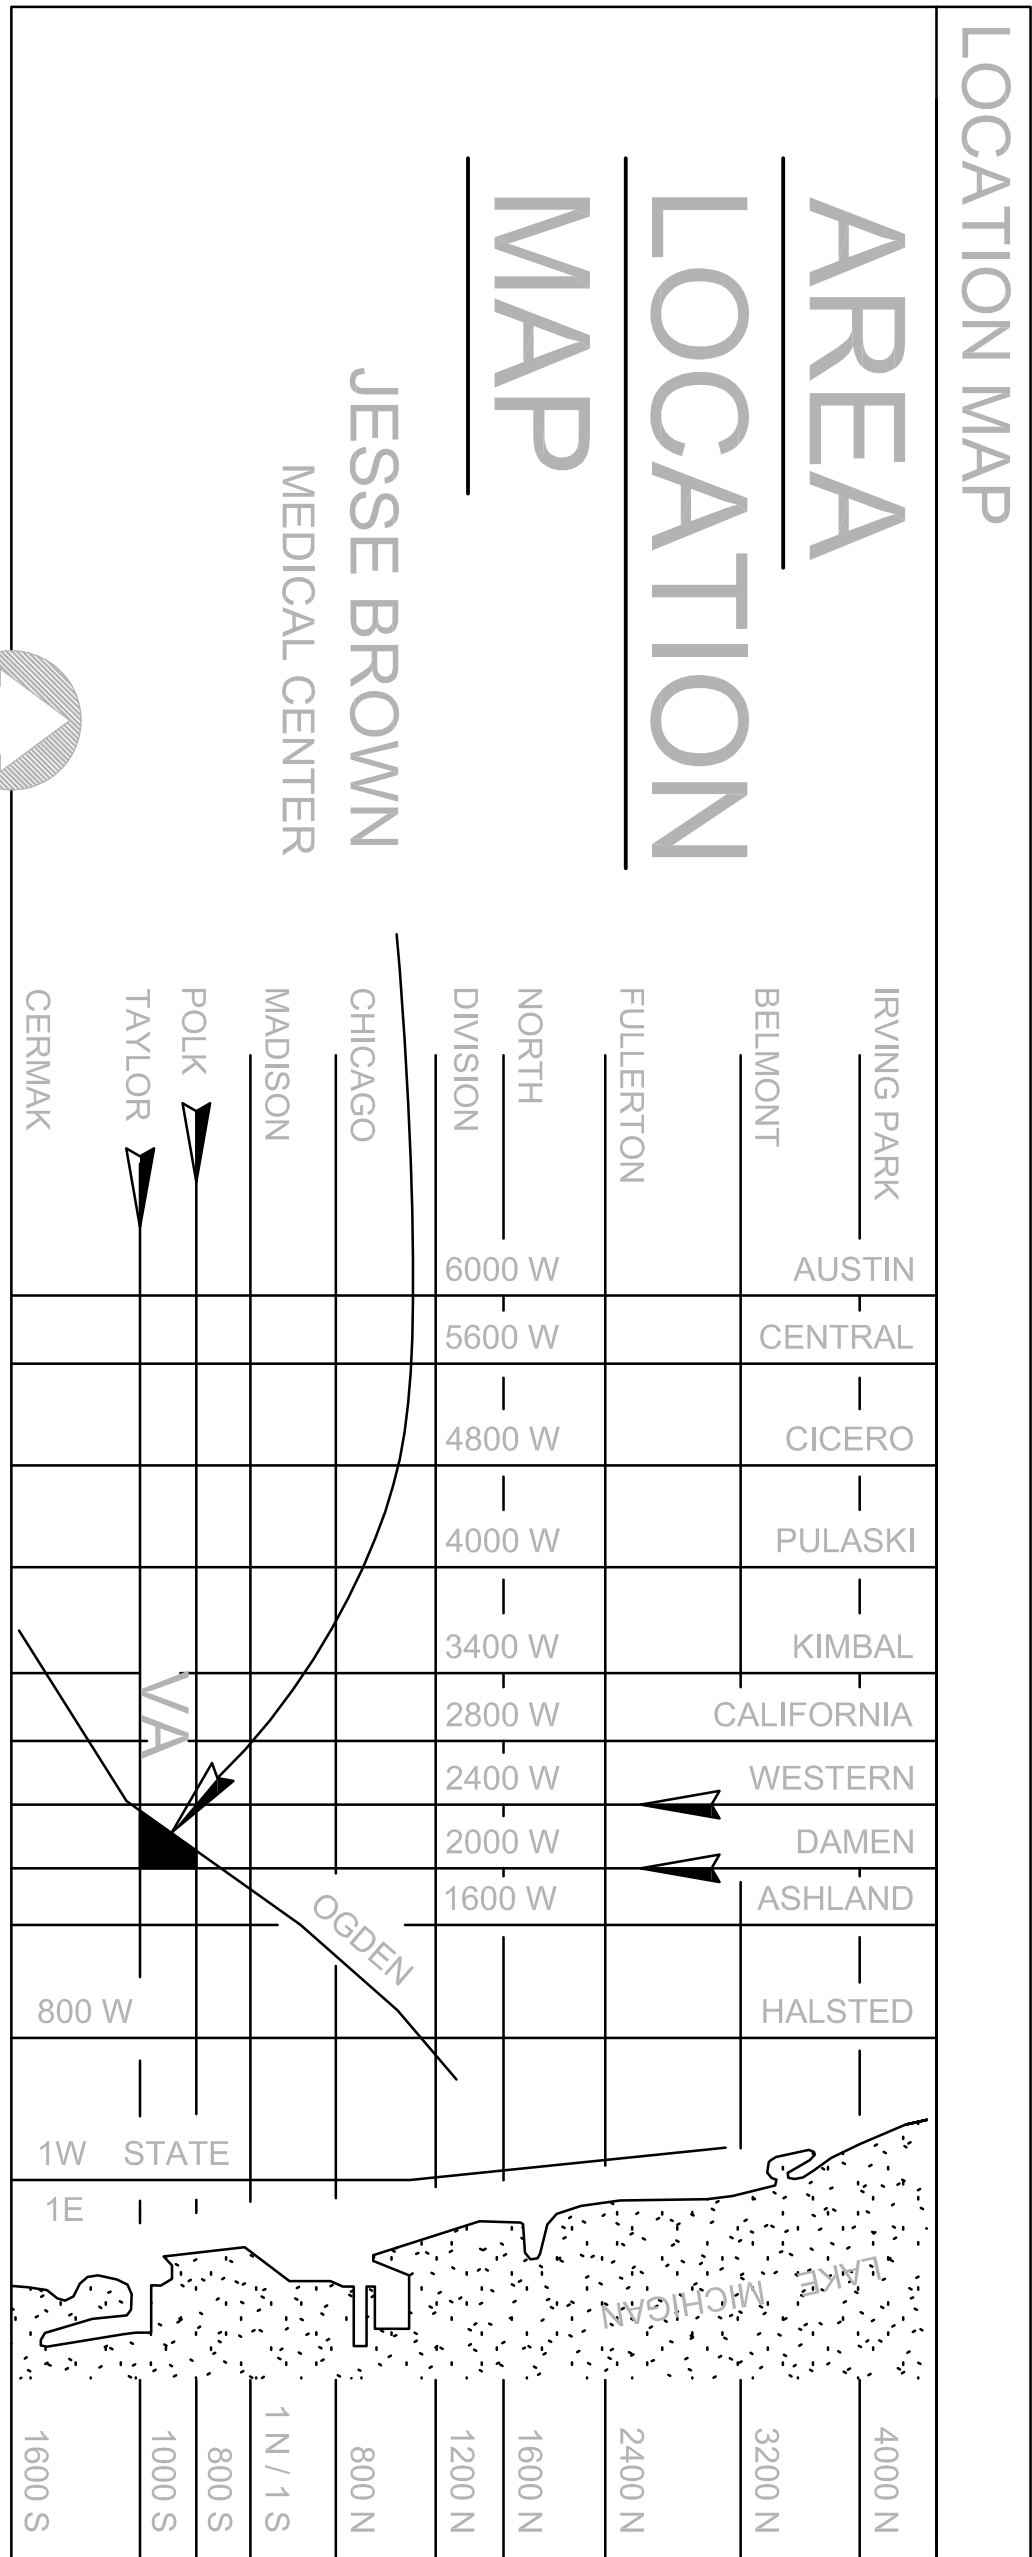

ISSUED FOR CONSTRUCTION DOCUMENTS (FINAL BID)	07/25/12
ISSUED FOR 100% DESIGN SUBMITTAL	06/13/12
DATE	
CONSULTANTS:	
ARCHITECT/ENGINEERS:	
EPSTEIN	600 West Fulton Street Chicago, Illinois 60661
Drawing Title	INDEX AND TITLE SHEET
Project Title	REPLACEMENT OF AHU S-10B IN BUILDING 30
Project Number	537-07-138
Building Number	BUILDING 30
Drawing Number	30-GI-001
Location	820 S. DAMEN AVE CHICAGO, IL 60612
Date	07/25/2012
Checked	YW
Drawn	YW
Dwg. Of	d 09
Office of Construction and Facilities Management	Department of Veterans Affairs

FULLY SPRINKLERED

