



8 AIR HANDLER UNIT SECTIONS DETAIL
NTS

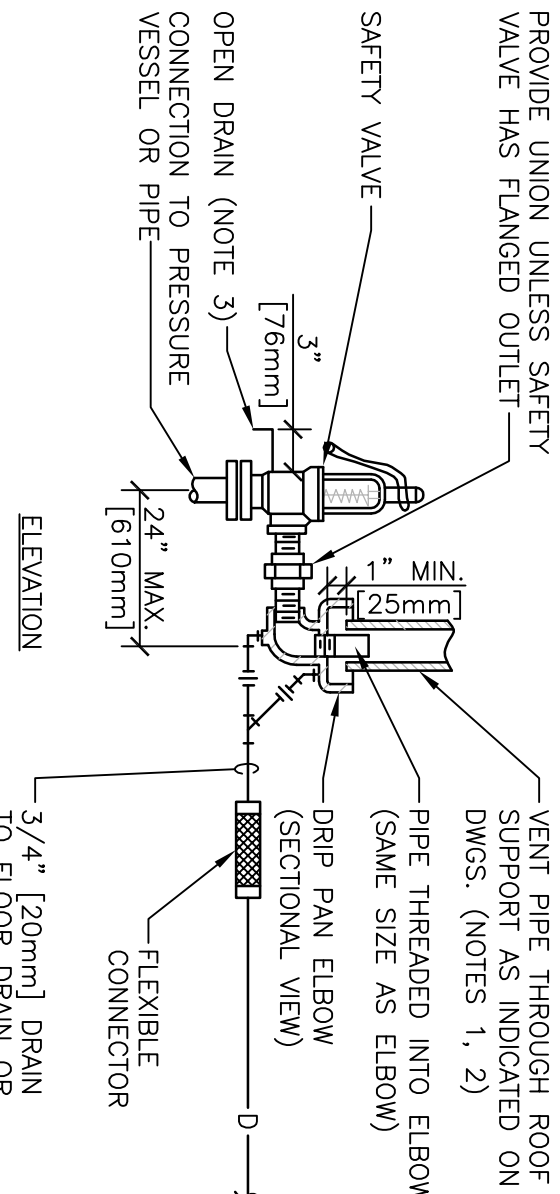


- NOTES:
- UNLESS OTHERWISE SHOWN ON THE DRAWINGS, SIZE THE STEAM PIPE SO THAT STEAM IS SUPPLIED TO THE SAFETY VALVE WITHOUT THE PIPE BEING FULL OF CONDENSATE. (CONTAINED IN ANSI B31.1, POWER PIPING CODE, APPENDIX II).
 - VENT PIPE SHALL TERMINATE 6" [152mm] MIN. ABOVE FINISHED ROOF.
 - DISCHARGE OF DRAIN MUST BE DIRECTED AWAY FROM PLATFORMS OR OTHER AREAS WHICH PERSONNEL MAY OCCUPY.
 - DO NOT CONNECT ANY OTHER DRAIN TO THE DRIP PAN ELBOW DRAIN PIPE.


6 STEAM SAFETY VALVE
NTS

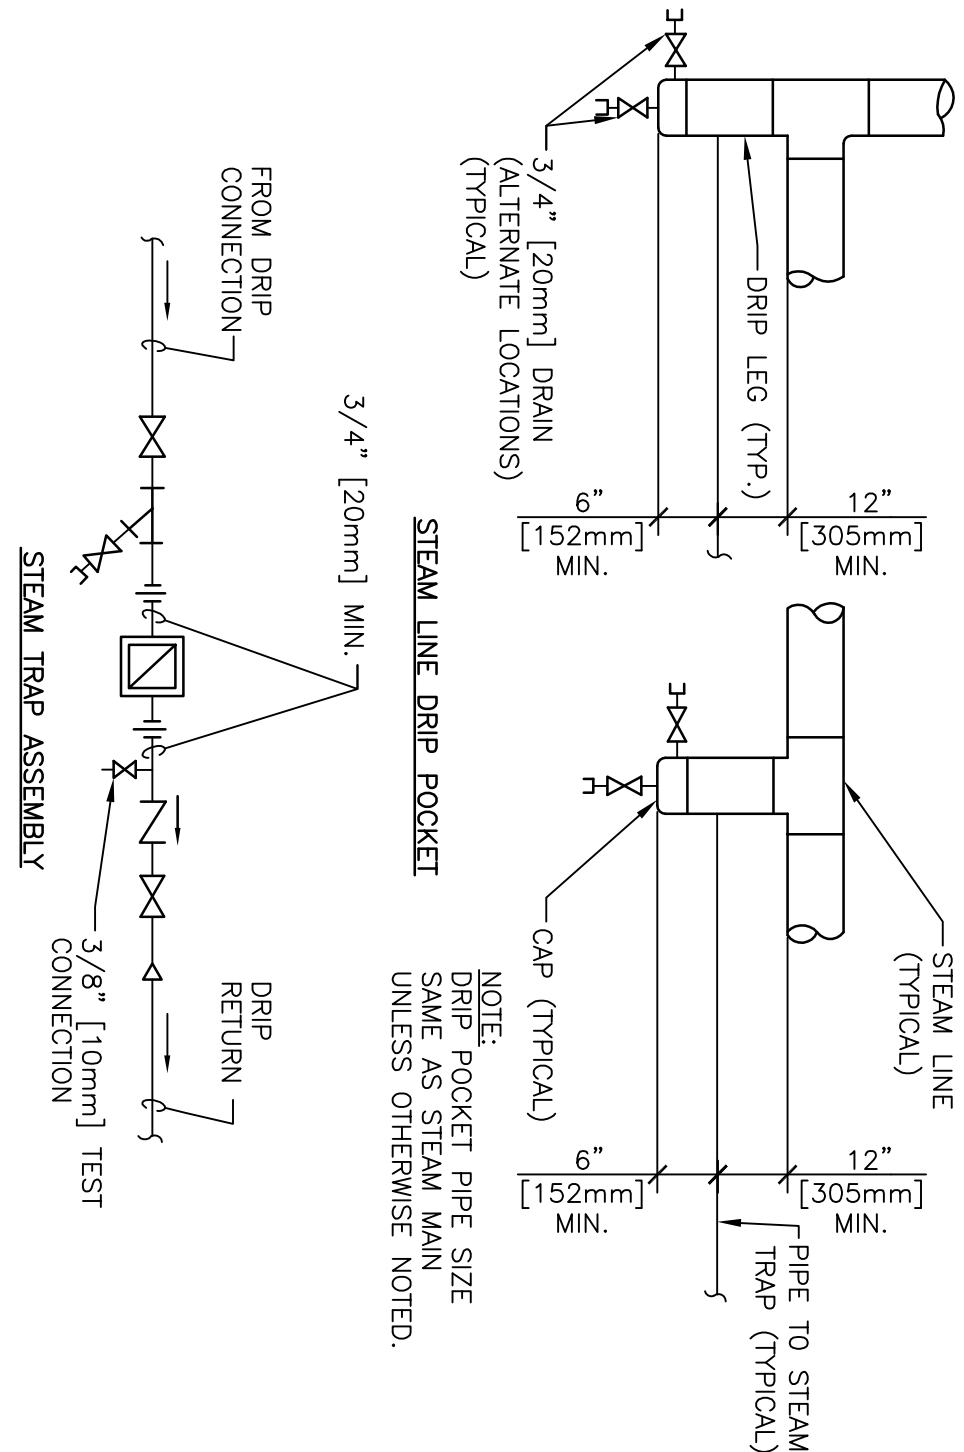

4 STEAM TRAP ASSEMBLY
NTS

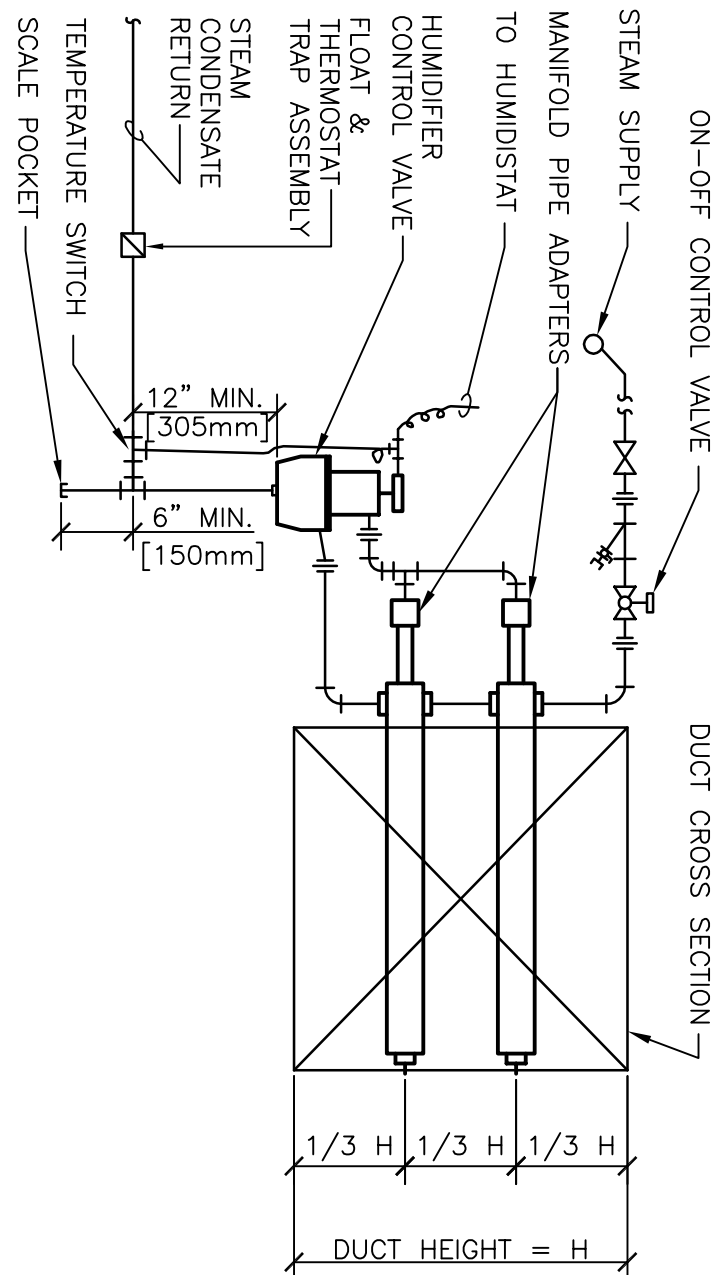

2 STEAM HUMIDIFIER - PIPING CONNECTIONS (MULTIPLE DISPERSION TUBES)
NTS

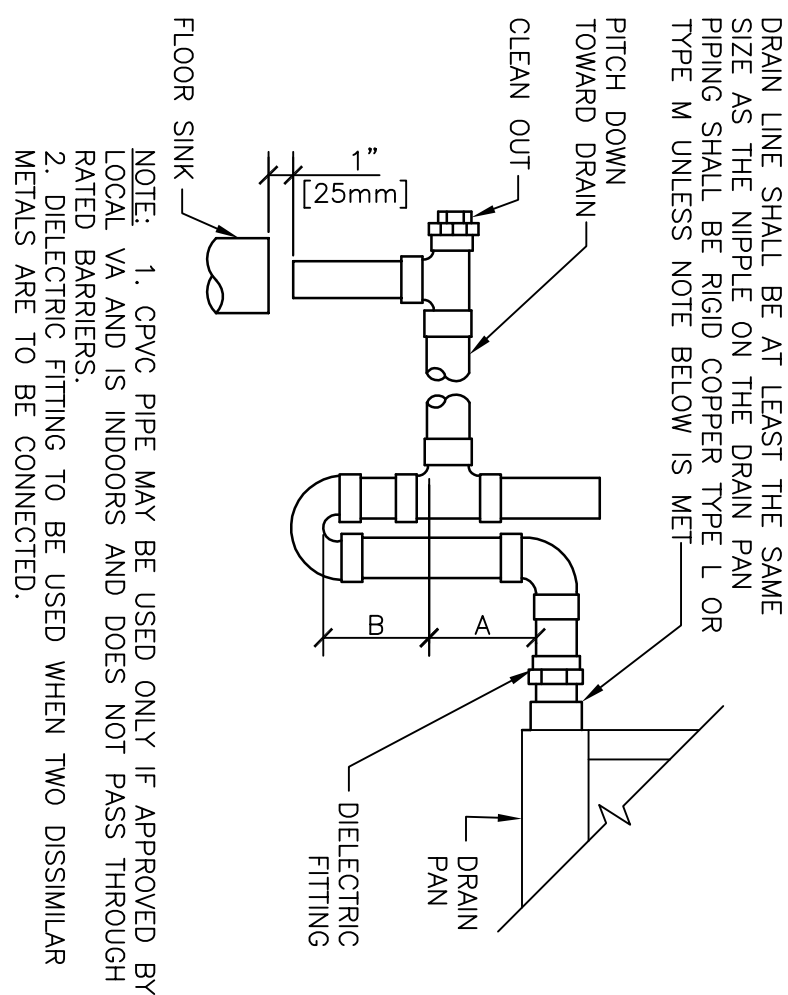


NOTE: 1. DRAIN PIPE MAY BE USED ONLY IF APPROVED BY THE DESIGNER. 2. DIELECTRIC FITTING TO BE USED WHEN TWO DISSIMILAR METALS ARE TO BE CONNECTED.

UNIT TYPE	A	B
DRAIN THRU PLUS X	2" [50mm]	X
BLOW THRU MINIMUM	1" [25mm]	2X


WHERE X = STATIC PRESSURE IN PAN

7 AIR HANDLING UNIT DRAIN TRAP DETAIL
NTS

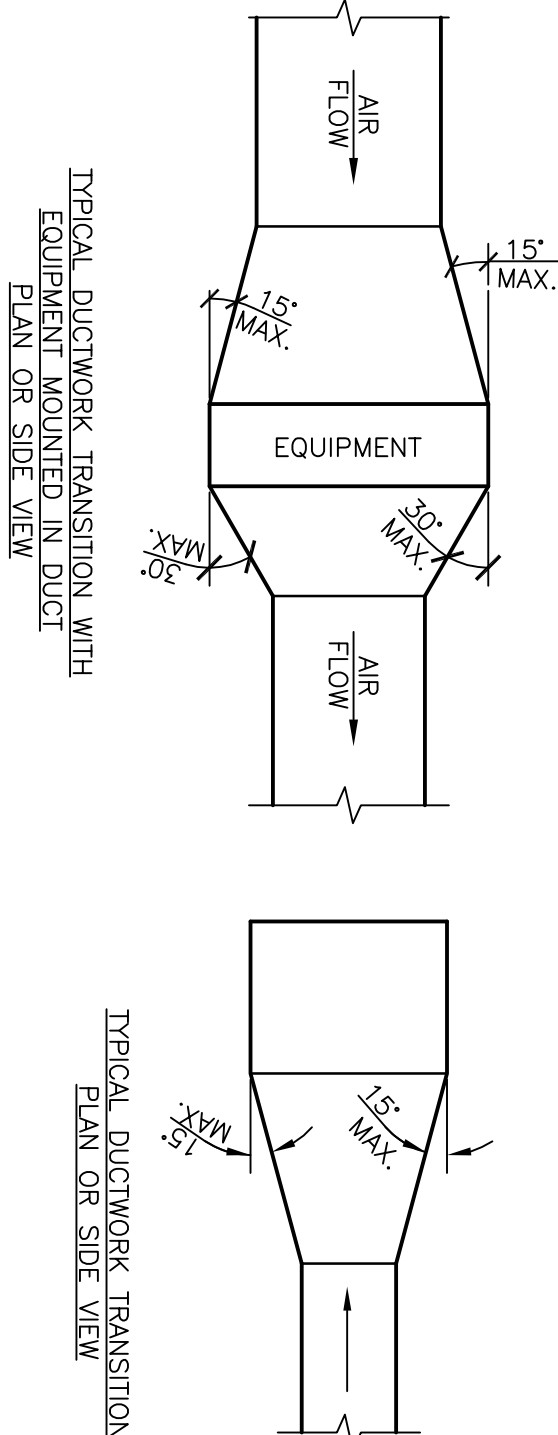


NOTE: UNLESS OTHERWISE INDICATED ON PLANS, MAXIMUM ANGLES SHOWN SHALL APPLY.

5 DUCTWORK - REDUCTIONS + TRANSITIONS
NTS

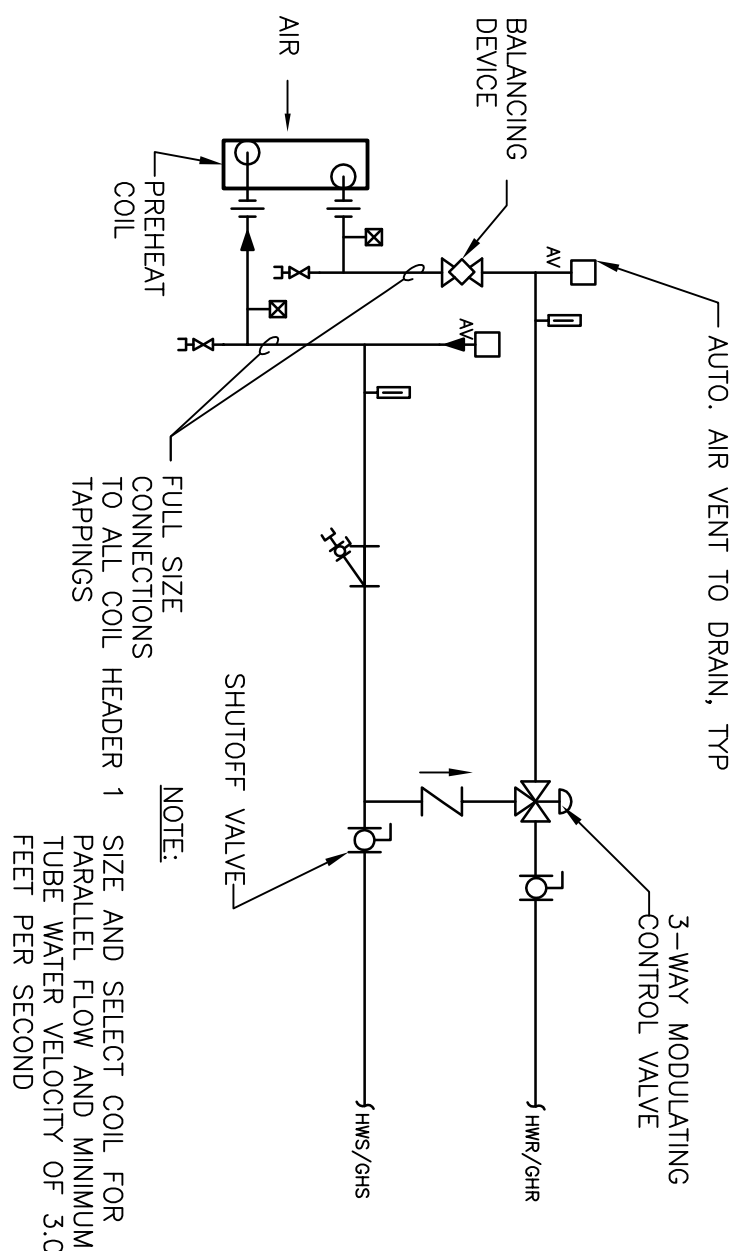

3 PREHEAT COIL (HOT WATER) - HWC-5-1
NTS

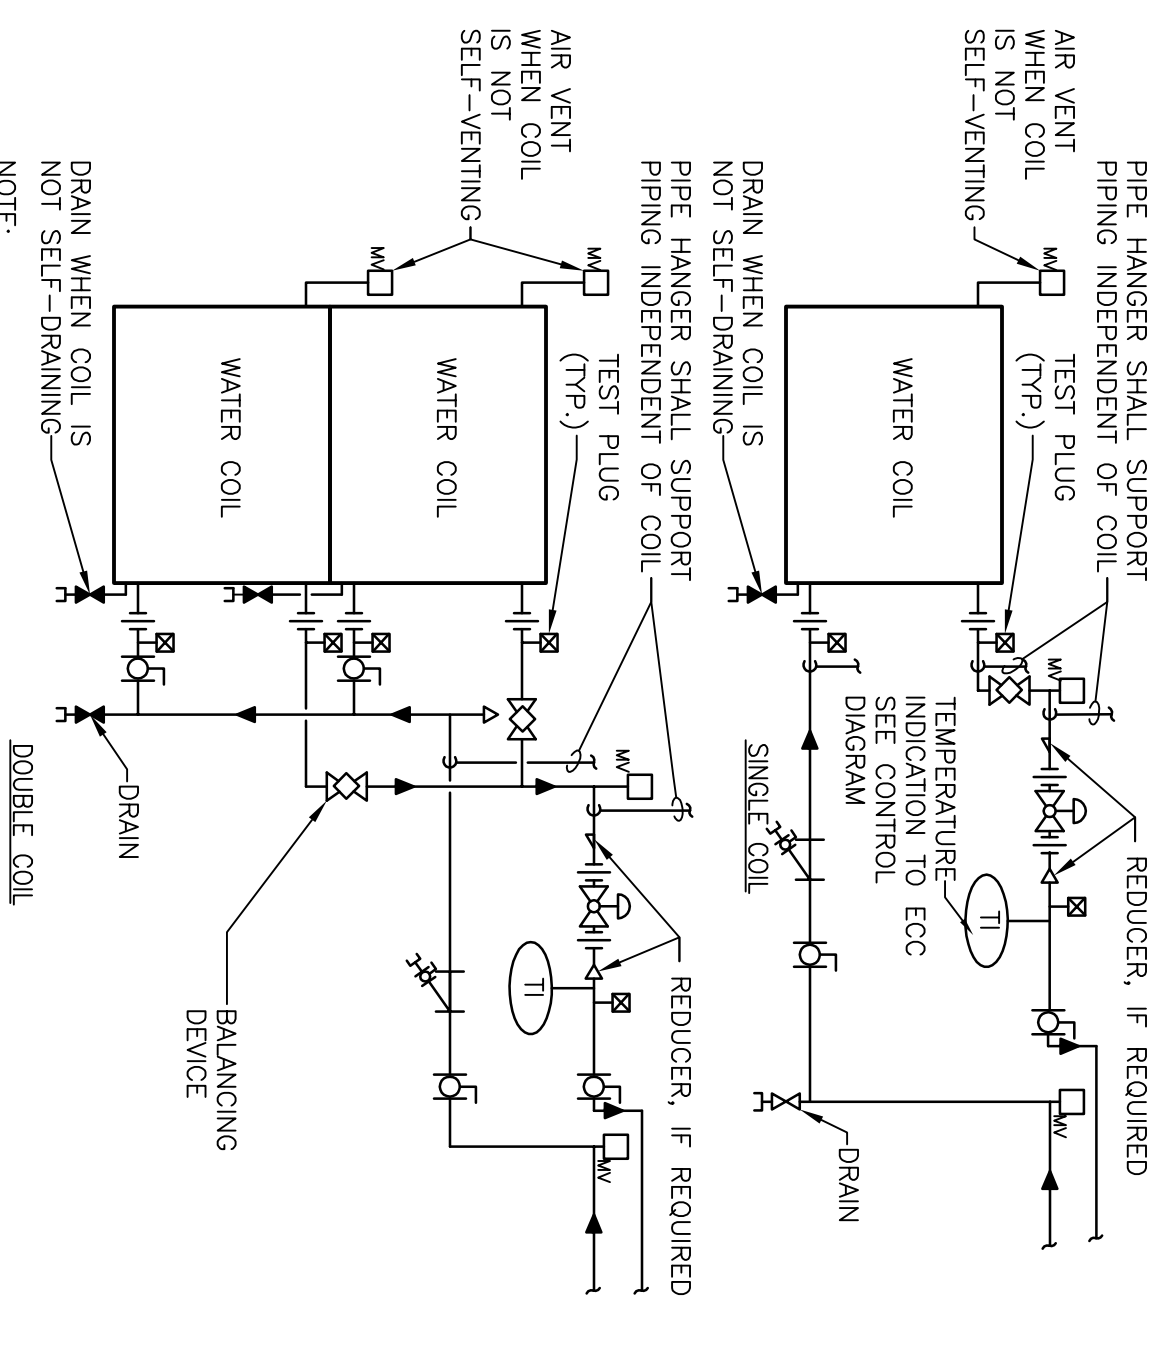

1 CHILLED WATER COILS - PIPING CONNECTIONS
NTS

ISSUED FOR CONSTRUCTION DOCUMENTS (FINAL BD)	07/25/12
ISSUED FOR 80% DESIGN SUBMITTAL	06/09/12
ISSUED FOR 50% DESIGN DEVELOPMENT	04/20/12
Revised	Date

CONSULTANTS:

ARCHITECT/ENGINEERS:

STEPSTEIN
600 West Fulton Street
Chicago, Illinois 60661

Drawing Title
MECHANICAL DETAILS

Approved Project Director

Project Title REPLACEMENT OF AHU S-10B IN BUILDING 30	Project Number 537-07-138
Location 820 S. DAMEN AVE CHICAGO, IL 60612	Drawing Number 30-M-500
Date 07/25/2012	Checked yw
	Drawn yw
	Dwg 05 of 09

Office of Construction and Facilities Management
Department of Veterans Affairs

FULLY SPRINKLERED