



A
three inches = one foot
1
0
6
B
one and one half inches = one foot
1
0
6
C
one inch = one foot
1
0
6
D
three quarters inch = one foot
2
0
6
E
one half inch = one foot
4
0
6
F
three eighths inch = one foot
4
0
6
G
one quarter inch = one foot
8
0
6
H
one eighth inch = one foot
16
0
6

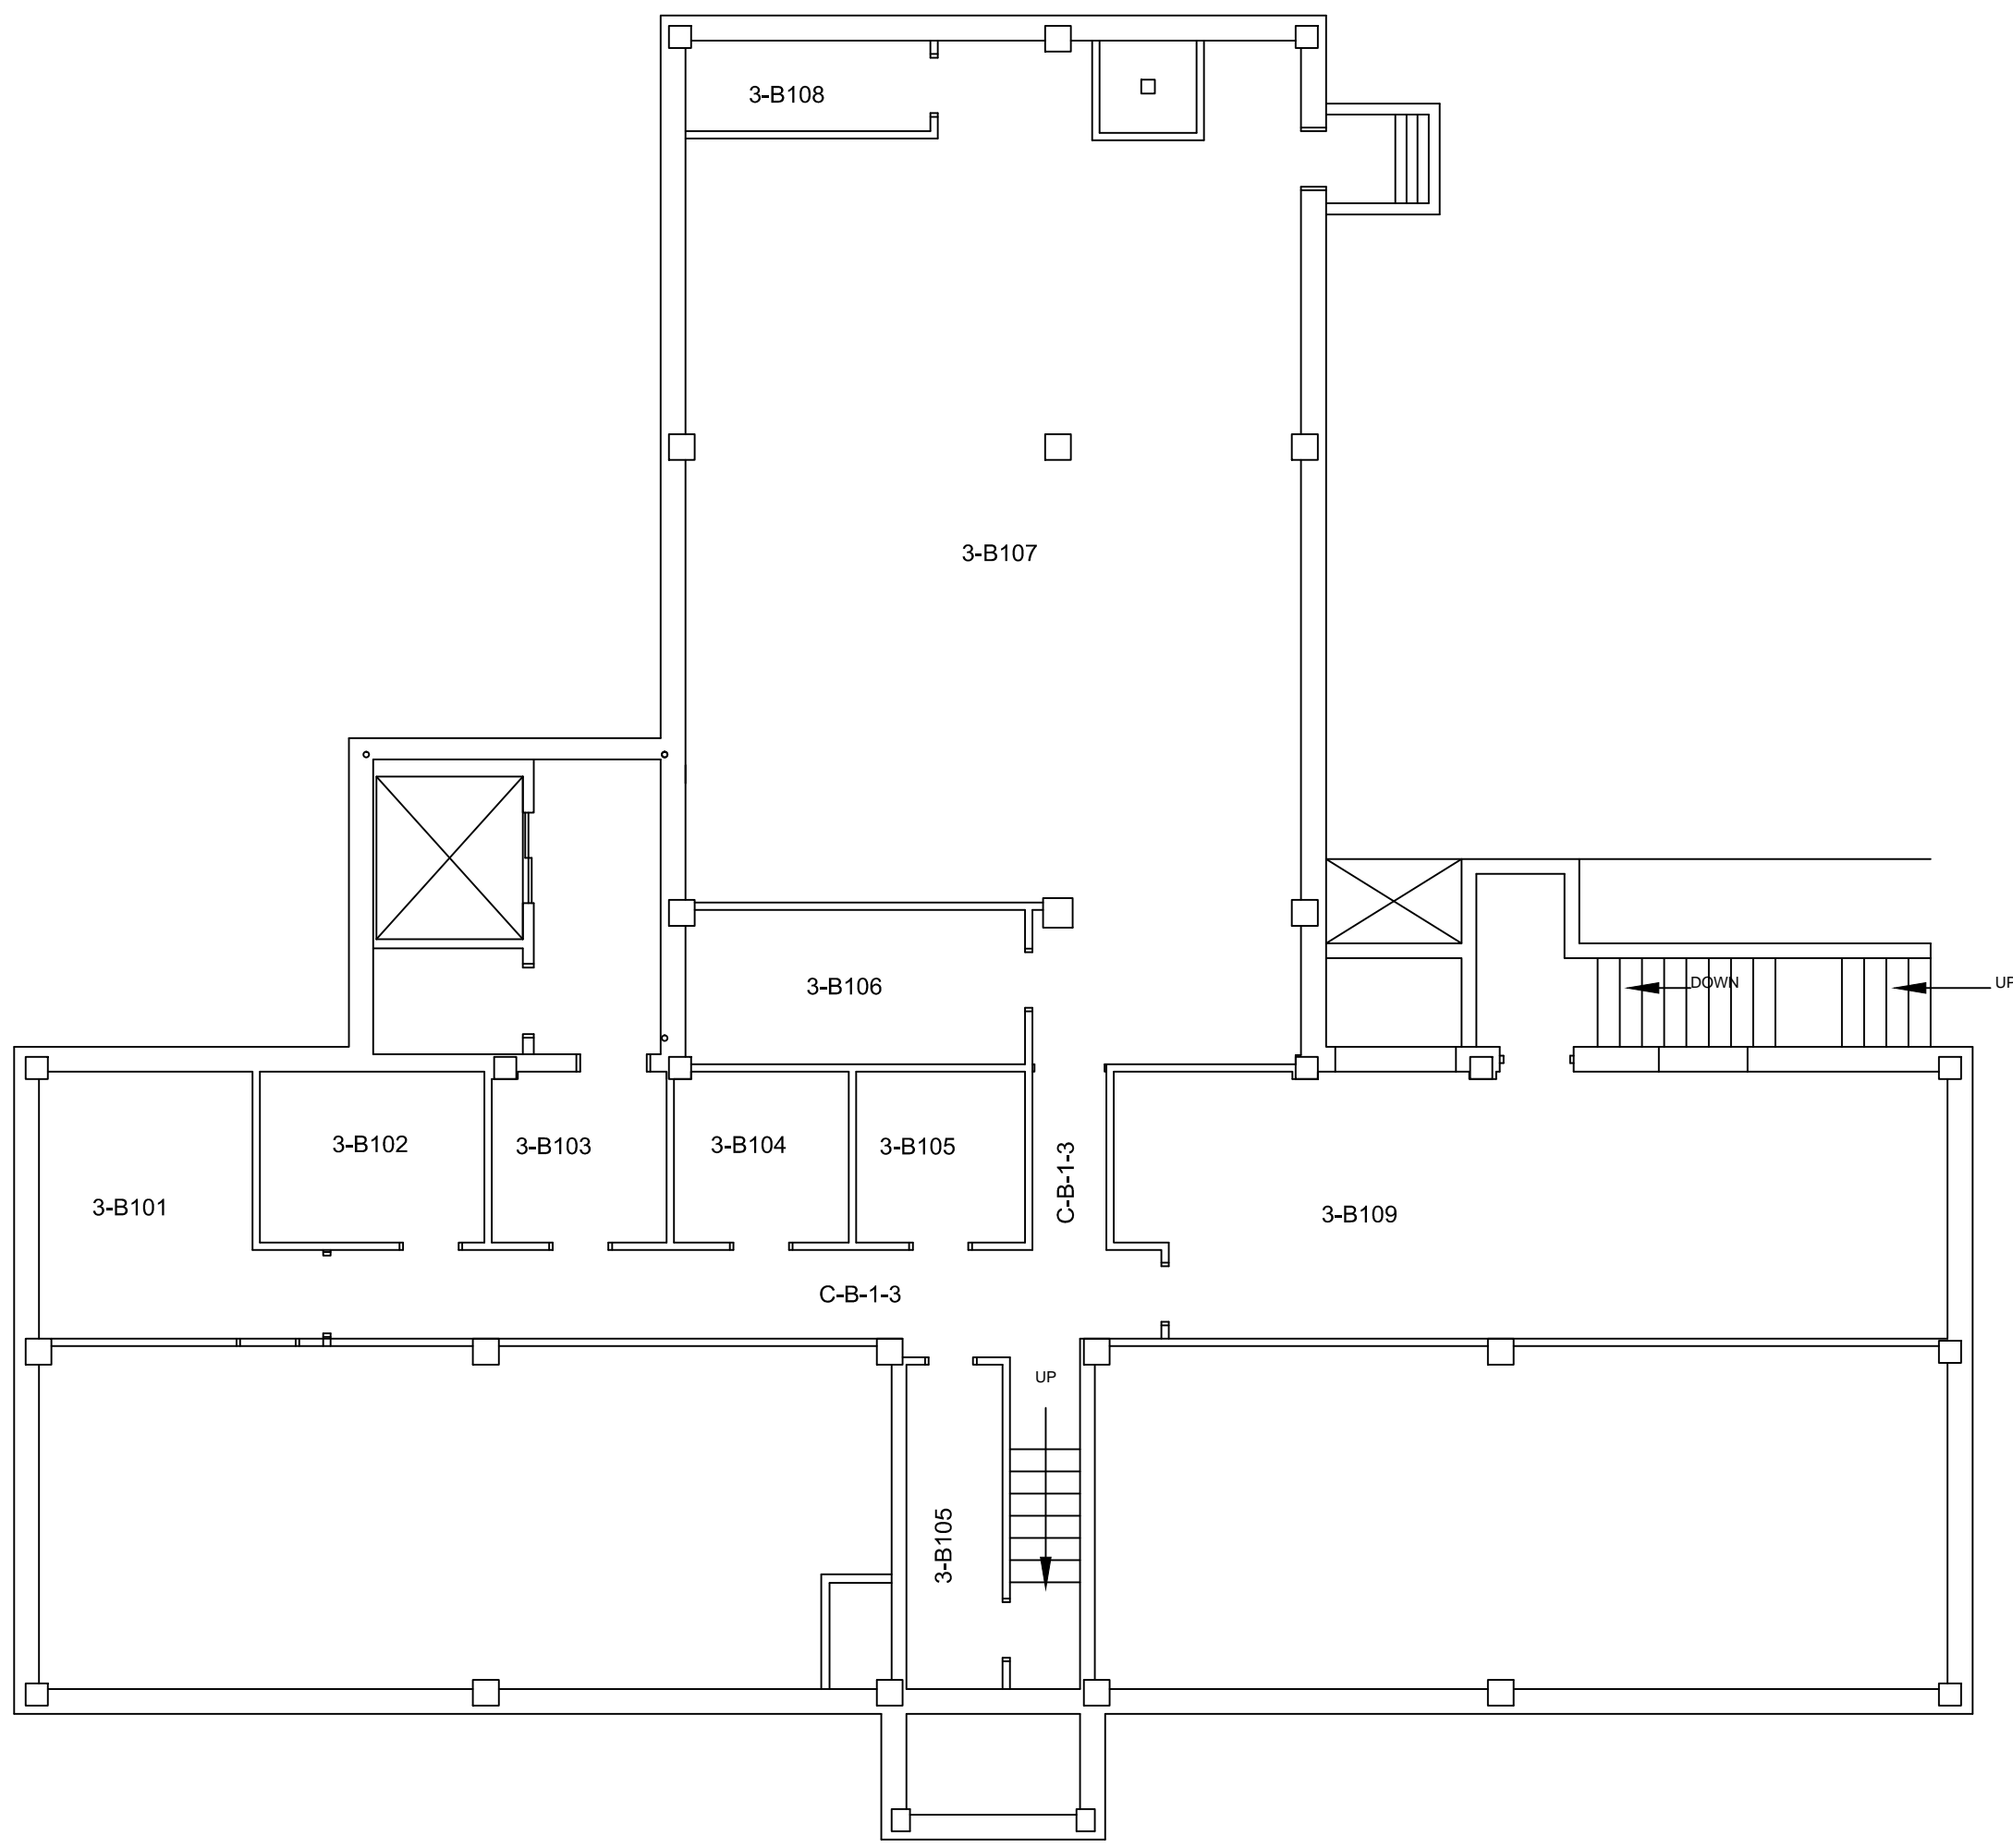


1 BASEMENT PLAN

SCALE: 1/8" = 1'-0"

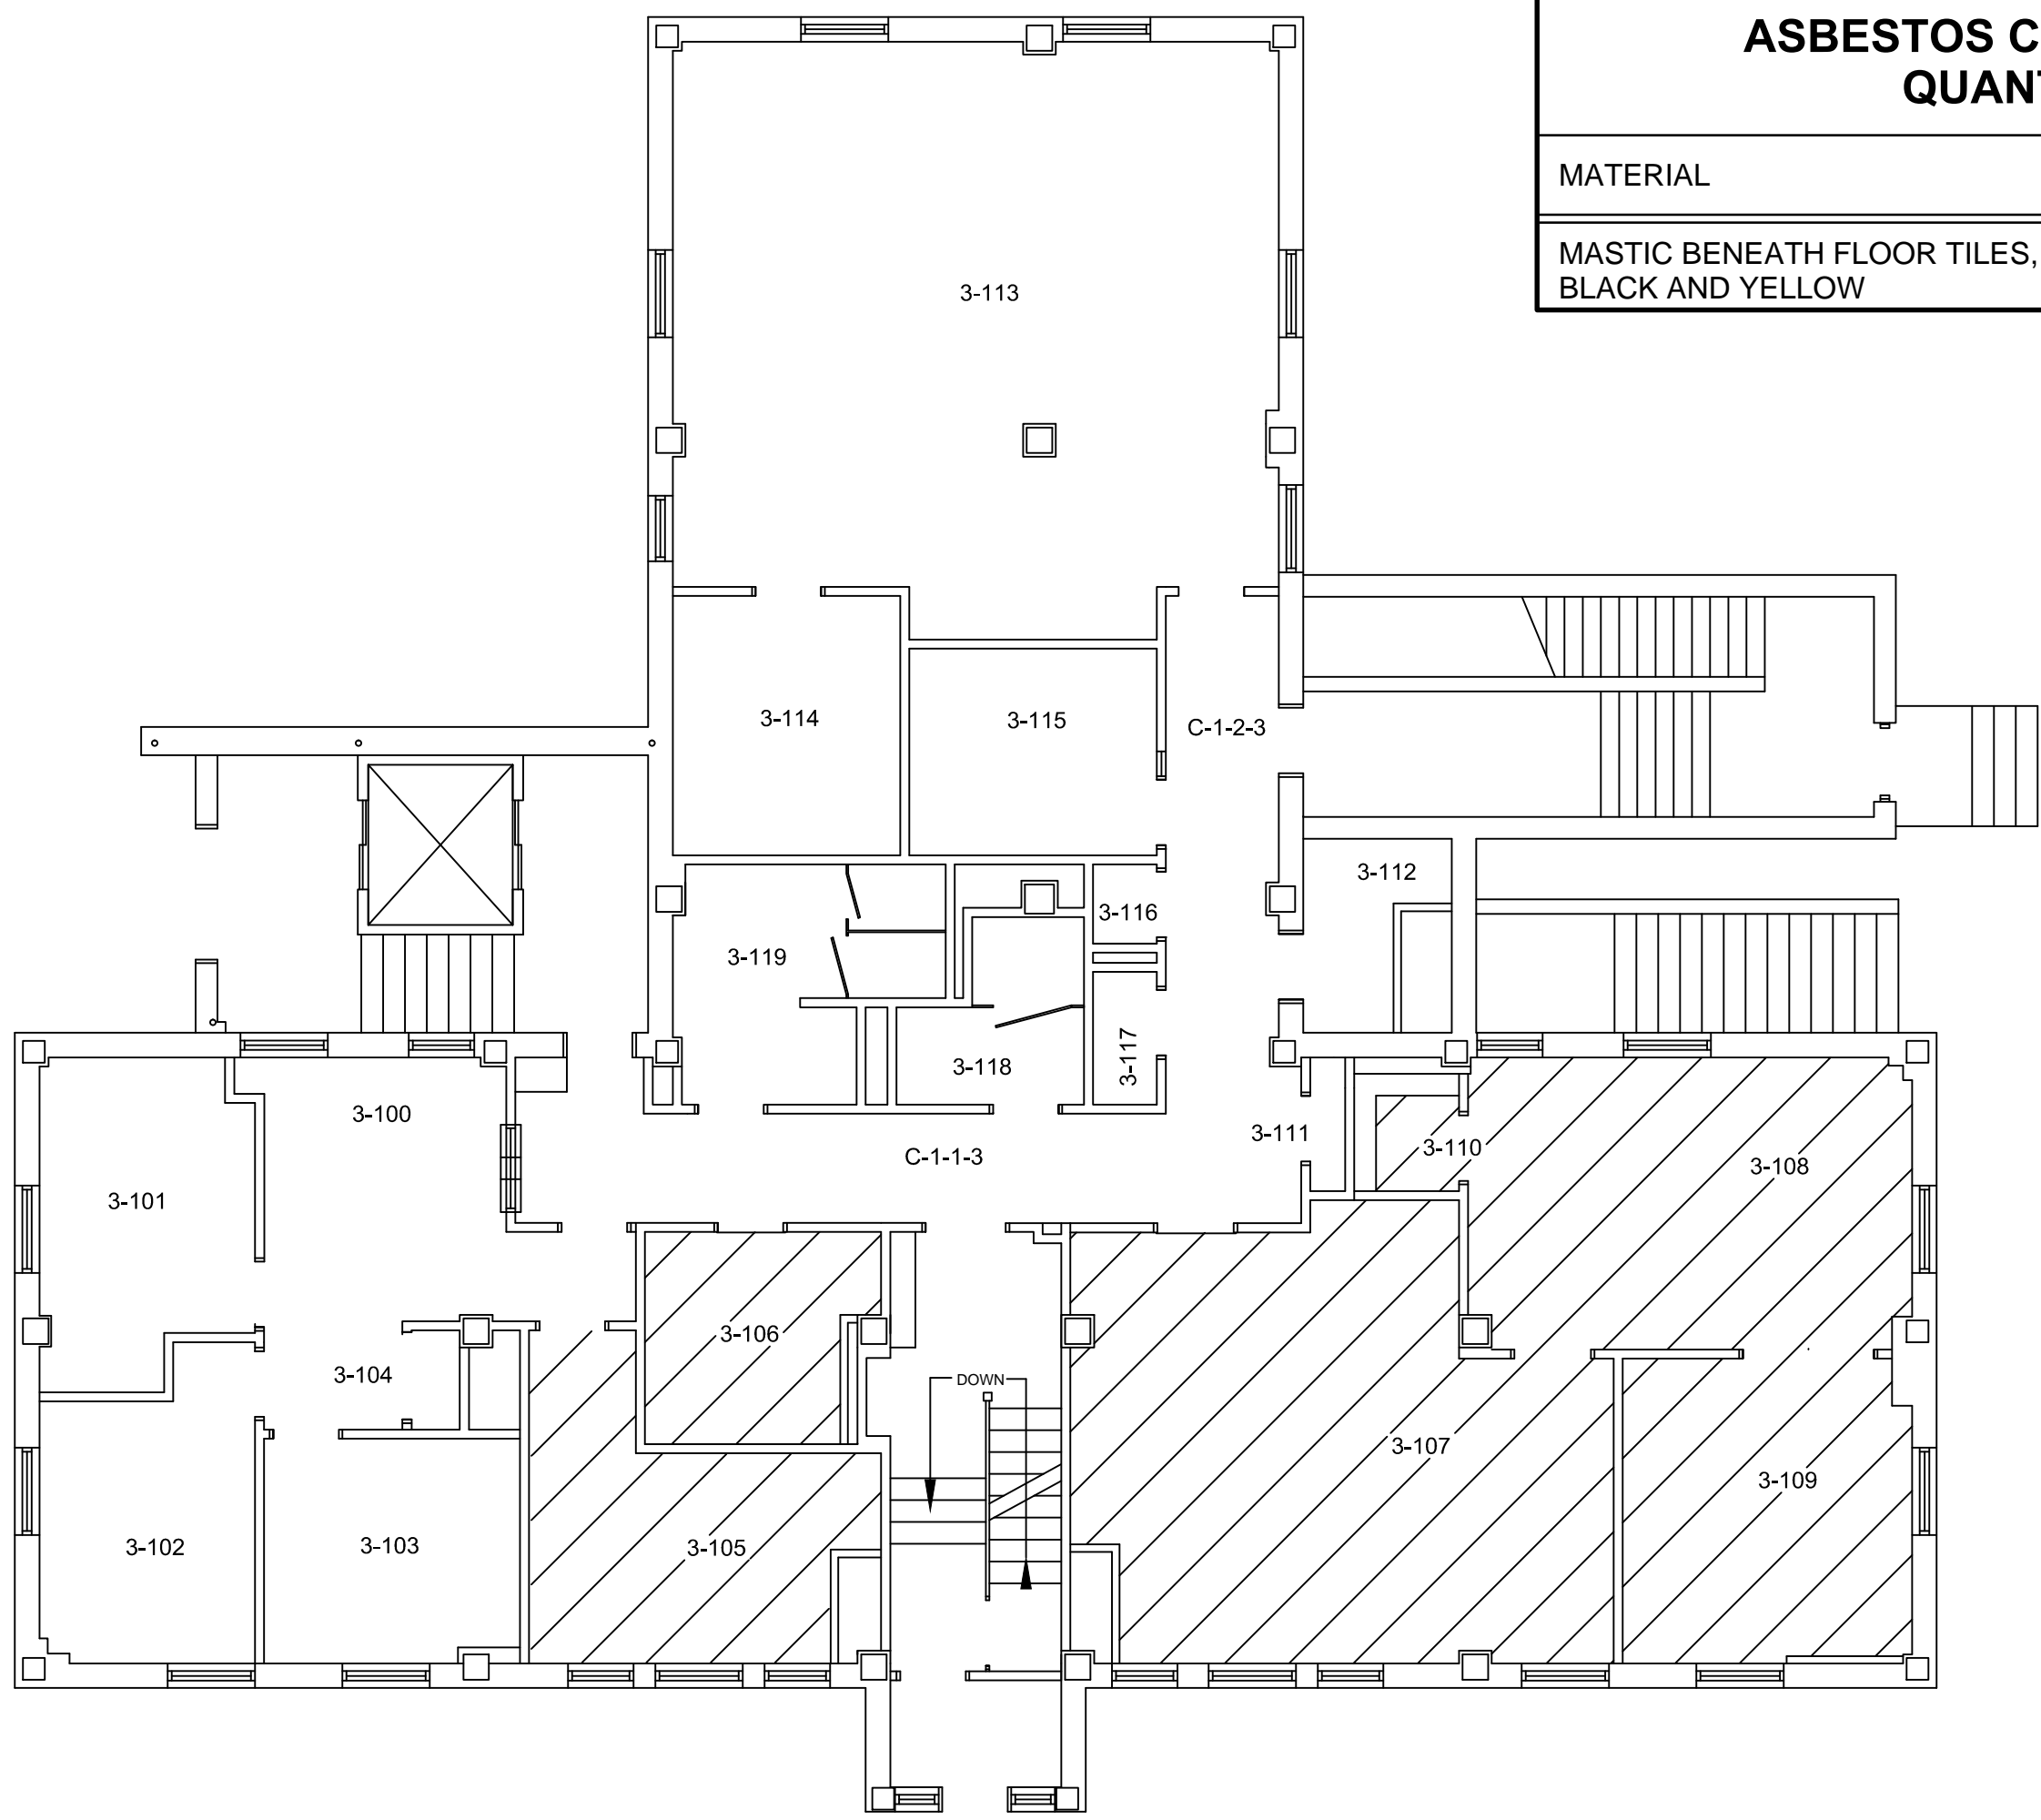

2 FIRST FLOOR PLAN

SCALE: 1/8" = 1'-0"

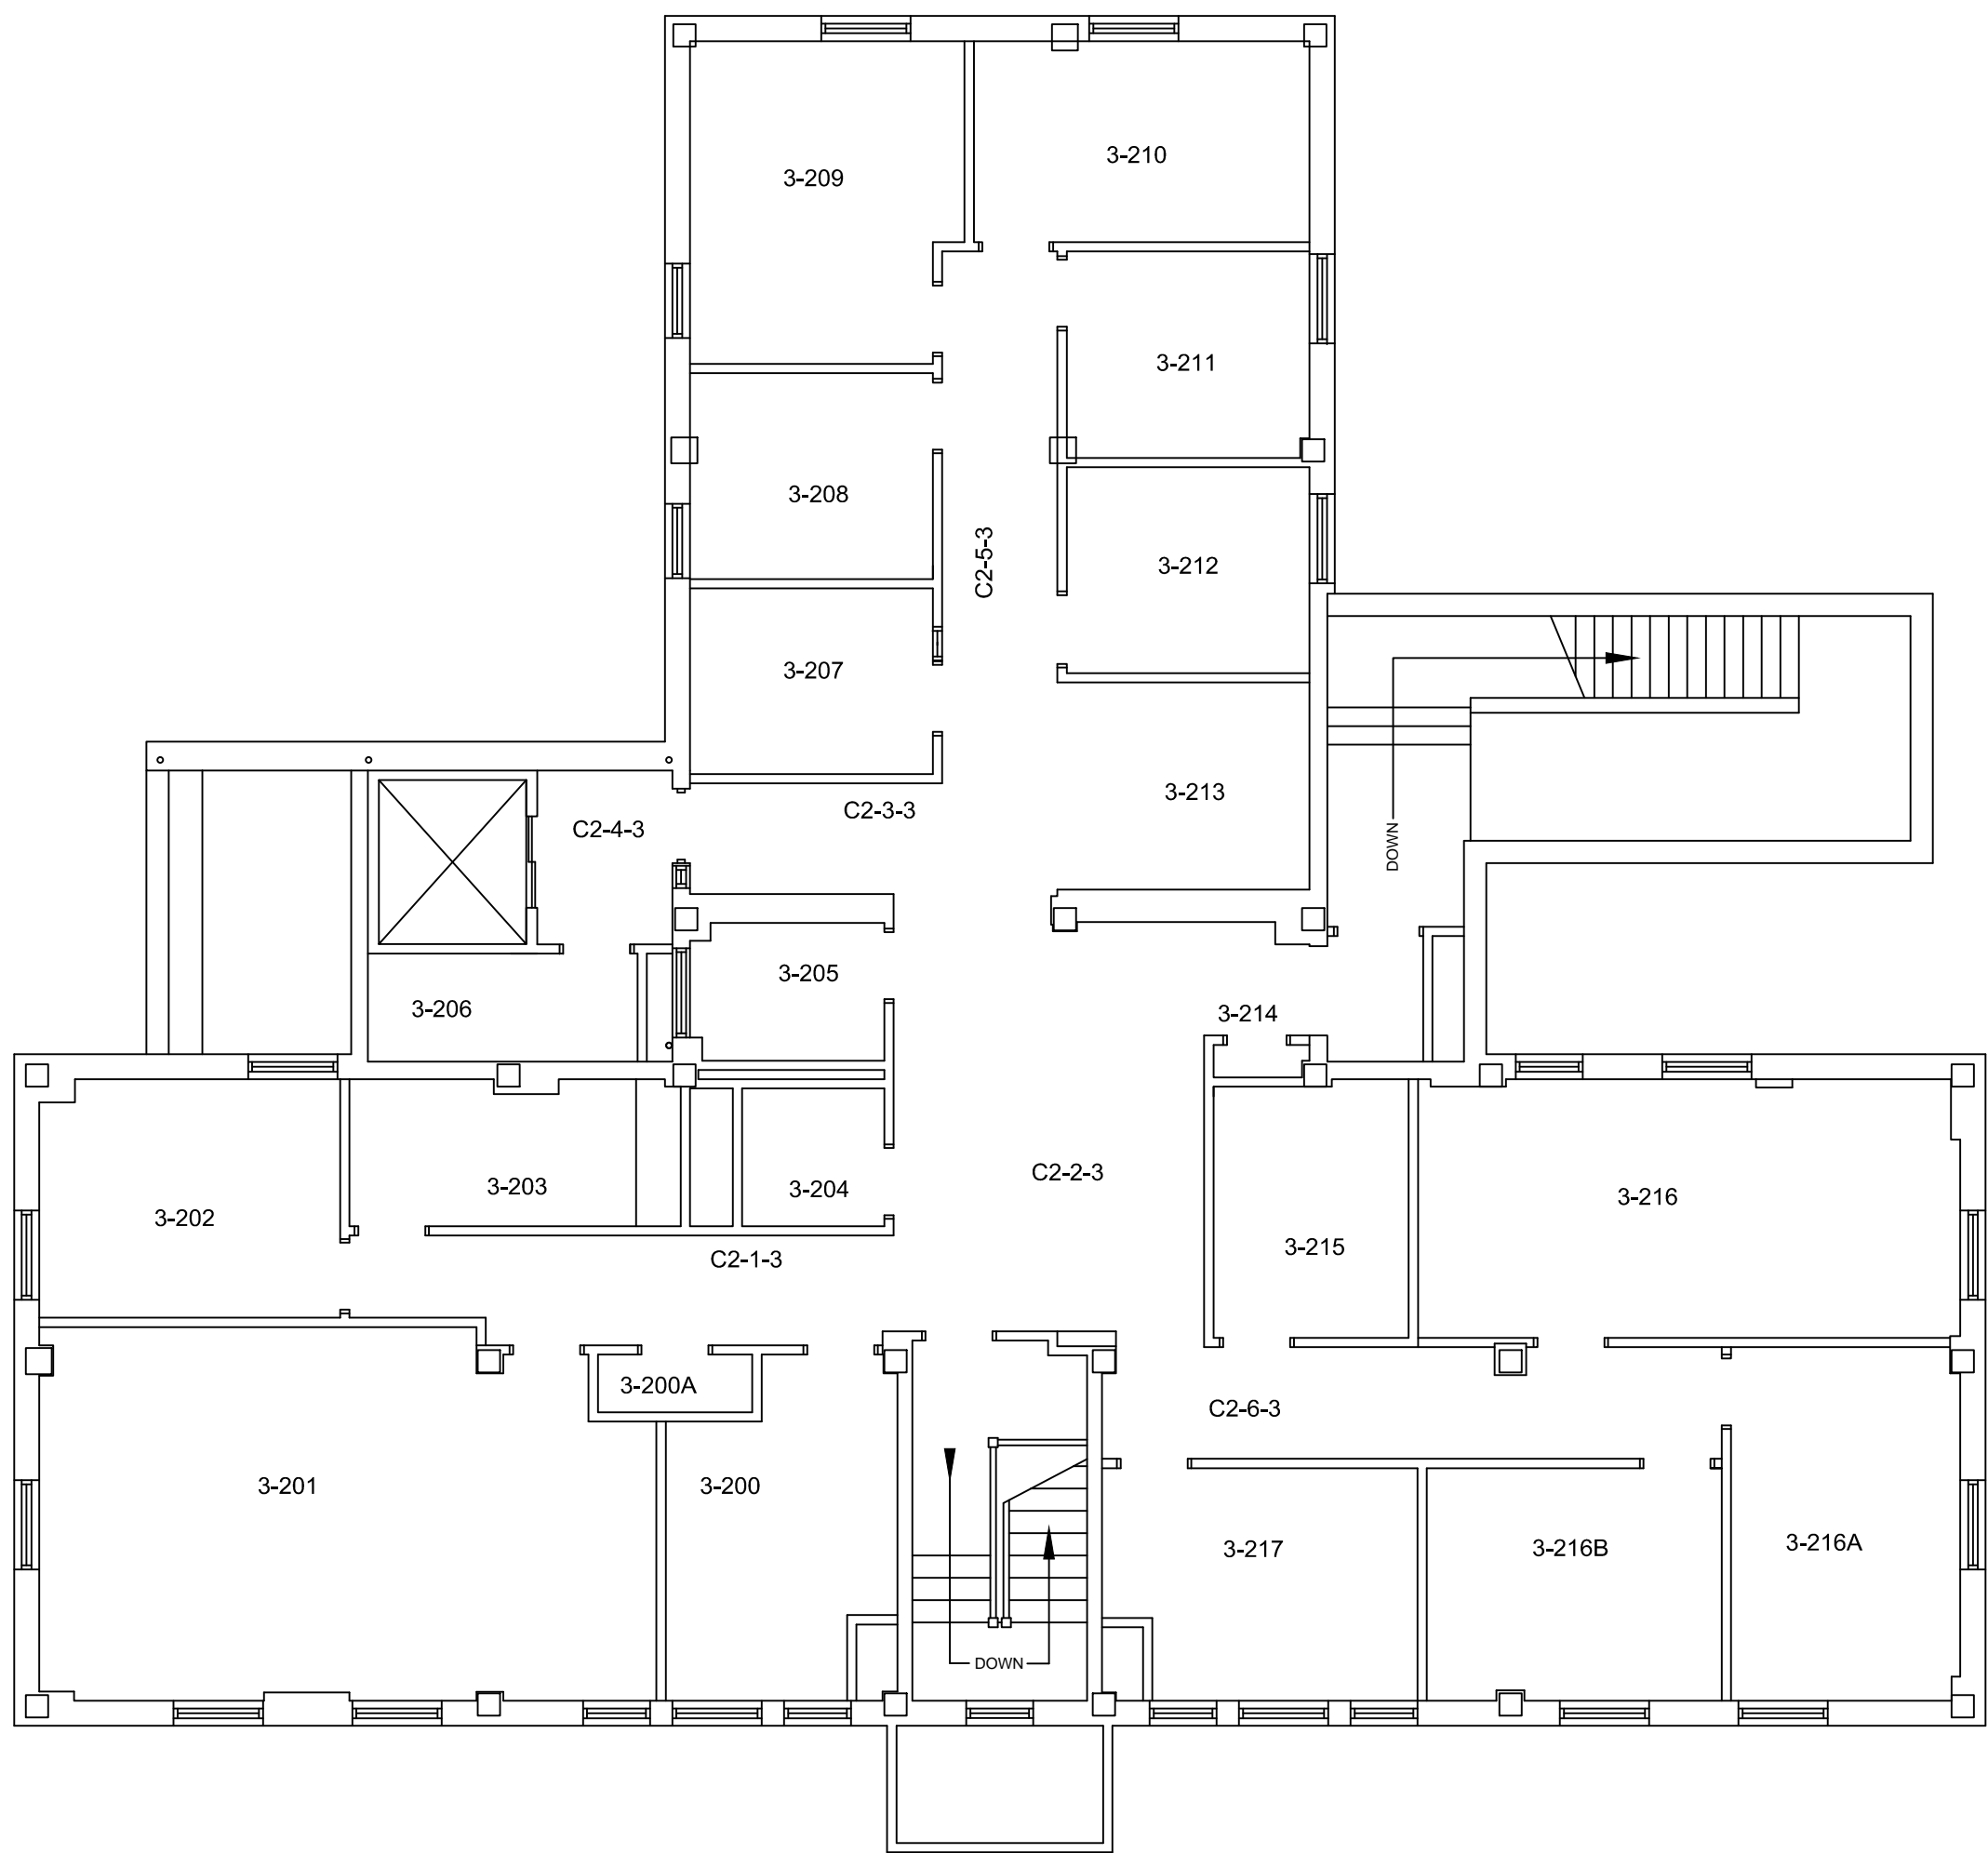


3 SECOND FLOOR PLAN

SCALE: 1/8" = 1'-0"

ASBESTOS CONTAINING MATERIAL QUANTITY SUMMARY	
MATERIAL	QUANTITY (1ST FLOOR ONLY)
MASTIC BENEATH FLOOR TILES, BLACK AND YELLOW	1,200 SF

LEGEND	
	ACM PIPE INSULATION / ELBOWS
	PIPE FITTING INSULATION
	HVAC DUCT SEAM SEALANTS (WHITE/TAN) AND COMPOUNDS (WHITE) APPLIED ON FIBERGLASS INSULATION AND ON METAL DUCT
	HVAC REGISTER (2'x2' OR 4'x6'")
	BLACK TAR SEALANT ON PIPE INSULATION AND PIPE FITTINGS
	FLOOR TILE AND MASTIC
	MASTIC BENEATH FLOOR TILE/CARPET (BLACK AND YELLOW)
	BLACK SPRAY-ON MASTIC ON WALLS
	CHASE WITH THERMAL PIPE INSULATION/ACM ELBOWS, DUCT COMPOUND MASTIC AND BLACK TAR SEALANT
	JOINT COMPOUND APPLIED ON DRYWALL WALLS
	BLOWN-IN INSULATION
	INSULATION ABOVE REFRIGERATOR
	COUNTERTOP
	LINEAR FEET SQUARE FEET
	W = OUTER DIAMETER OF PIPE X = INSULATION THICKNESS Y = TYPE OF SYSTEM Z = QUANTITY
	A = DUCT SIZE B = INSULATION THICKNESS C = TYPE OF SYSTEM
CWS = COLD WATER SUPPLY CWR = COLD WATER RETURN CHWS = CHILLED WATER SUPPLY CHWR = CHILLED WATER RETURN HWS = HOT WATER SUPPLY HWR = HOT WATER RETURN SSL = STEAM SUPPLY LINE SSR = STEAM RETURN LINE SWS = SECONDARY WATER SUPPLY SWR = SECONDARY WATER RETURN SR = STEAM SUPPLY RISER RR = STEAM RETURN RISER HS = HVAC SUPPLY HR = HVAC RETURN ELB = ELBOW (TSI) EA = EXHAUST AIR	

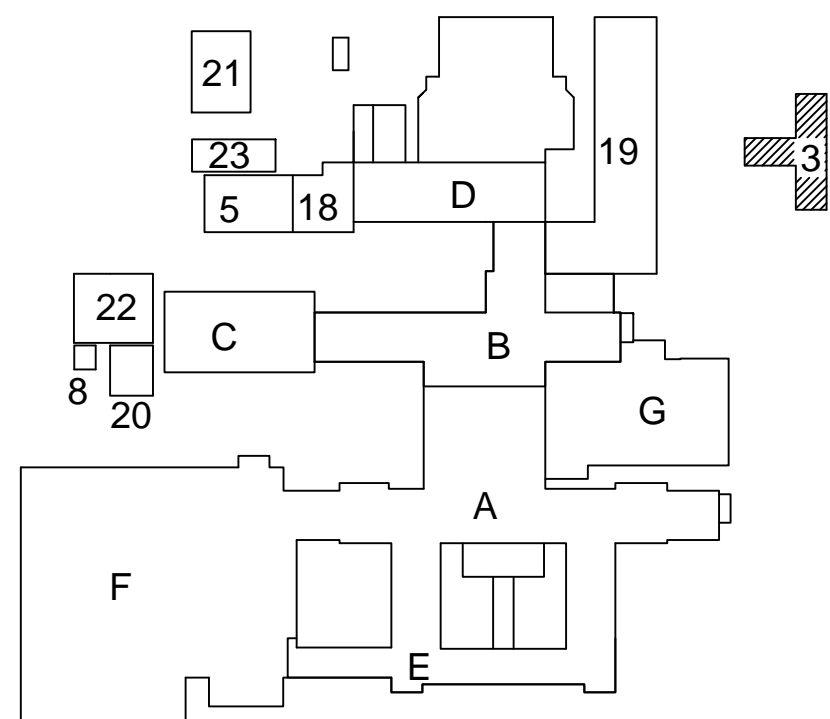

KEY PLAN

Revisions:		Date:	CONSULTANTS:		ARCHITECT/ENGINEERS:		Drawing Title BASEMENT, 1ST & 2ND FLOOR PLAN		Project Title ASBESTOS CONTAINING MATERIALS		Project Number 635-14-102	
					BES DESIGN/BUILD		Approved: Project Director		Location VAMC, OKLAHOMA CITY, OKLAHOMA		Building Number 3	
					THESE DRAWINGS ARE NOT TO BE USED FOR CONSTRUCTION, BIDDING, RECORDATION, CONVEYANCE, SALES, OR AS THE BASIS FOR THE ISSUANCE OF A PERMIT				Date 12 JUNE 2015		Drawn TA	
									Checked LW		Drawing Number 3HA101	
											Dwg. 14 of 22	

100% RESUBMISSION

OFFICE OF
CONSTRUCTION and
FACILITIES
MANAGEMENT

Department of
Veterans Affairs