


WARD 2C REMODEL: INTENSIVE CARE UNIT

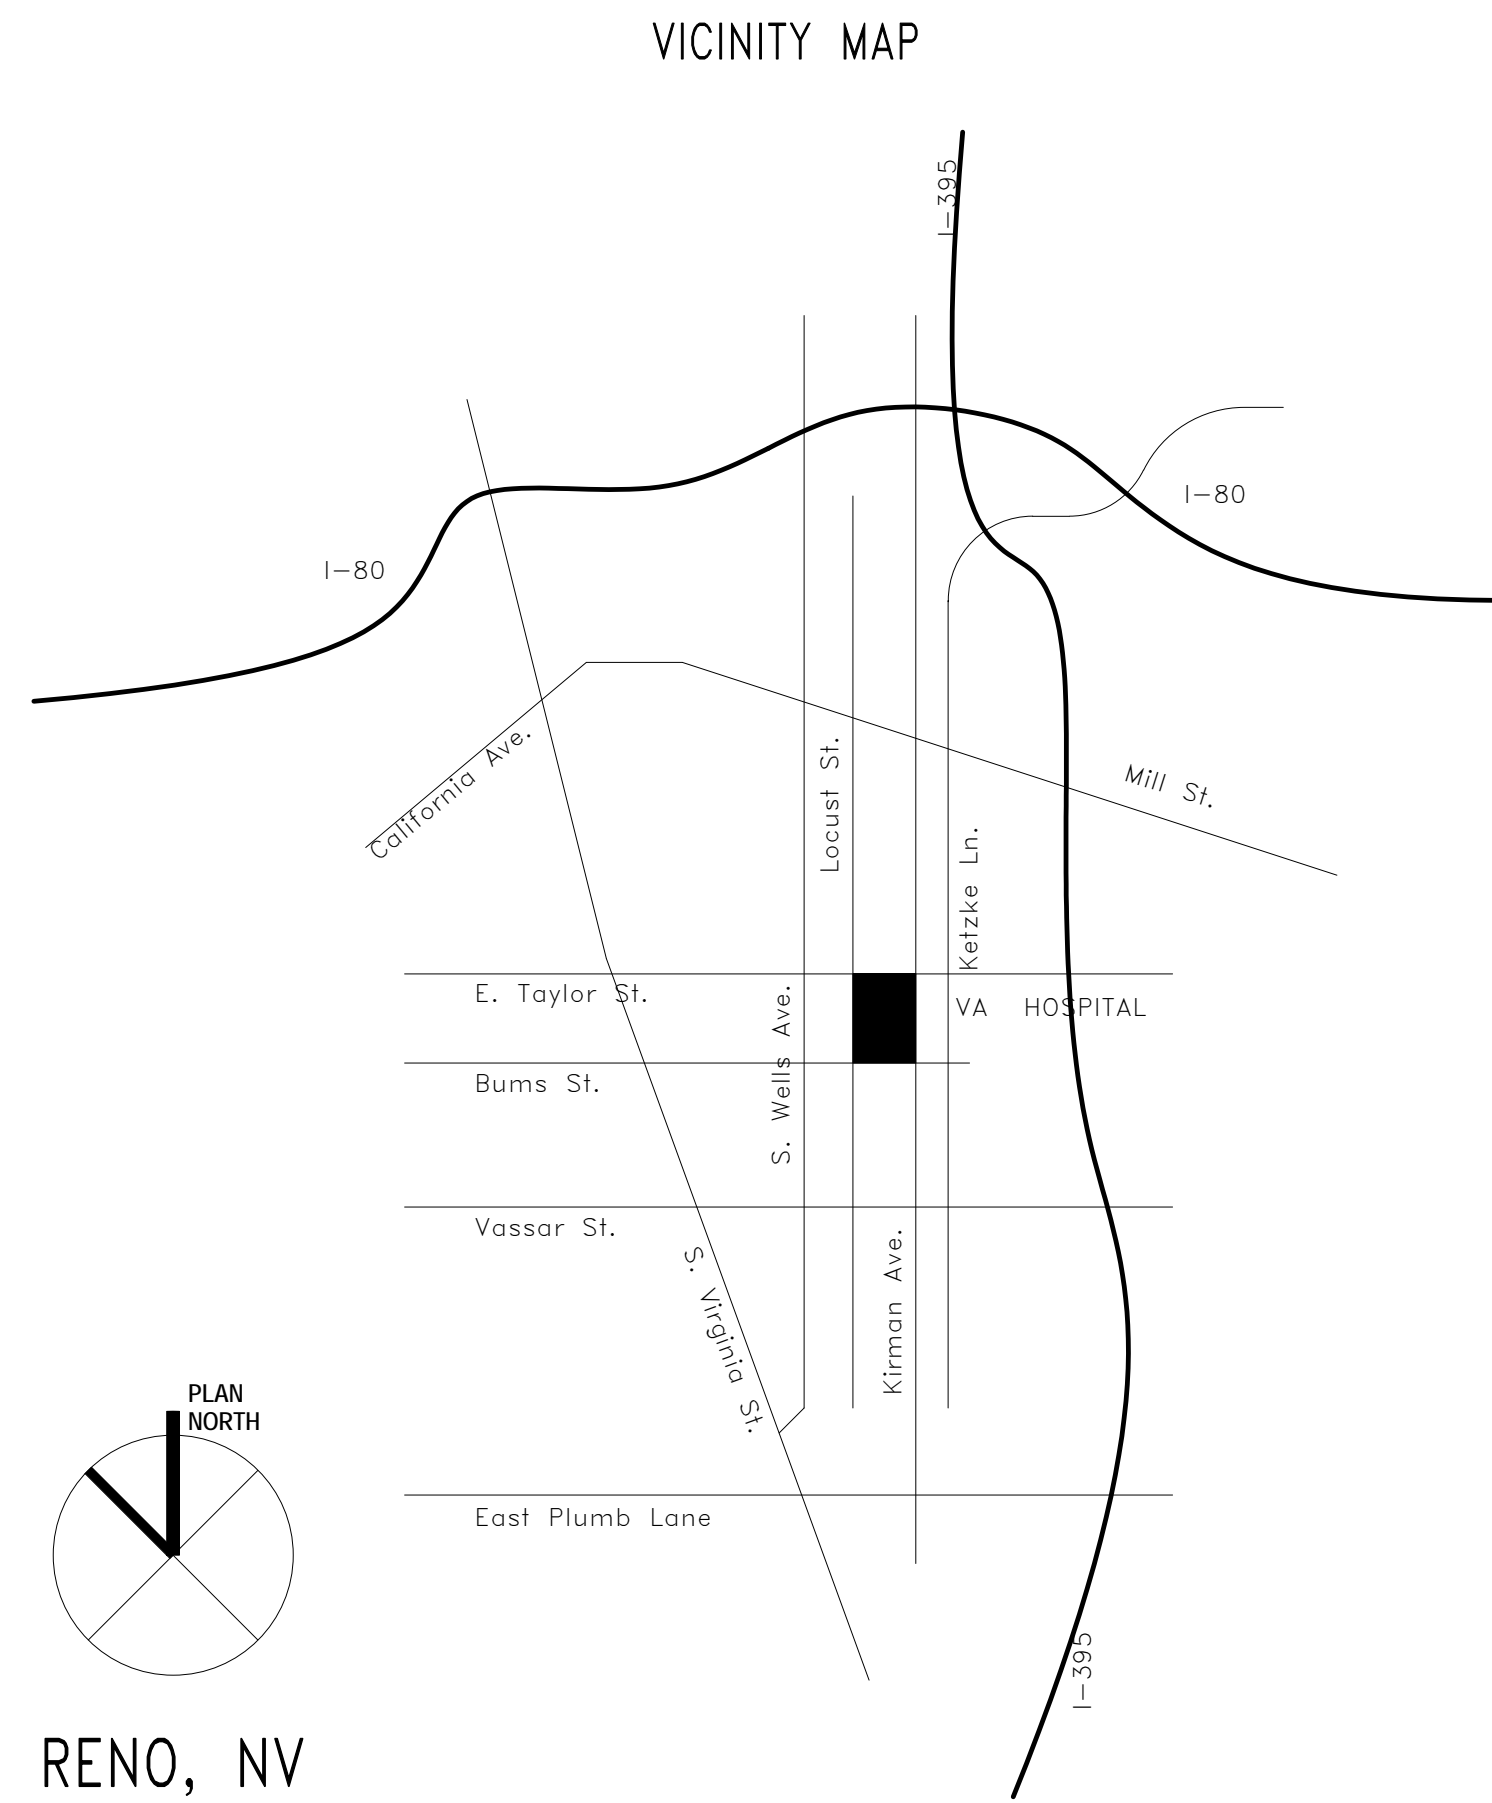

RENO FACILITY
975 KIRMAN AVE
RENO, NV 89502

Contact: Kevin Brun
Contact: 775-326-5789



Architecture | Engineering | Planning
Hammel, Green and Abrahamson, Inc.
1410 Rocky Ridge Drive, Suite 250
Roseville, California USA 95661
Telephone 916.787.5100 Facsimile 916.784.7738
Contact: Douglas Whiteaker



AINS WORTH ASSOCIATES
MECHANICAL ENGINEERS
3741 BUSINESS DR. 1420 HOLCOMB AVE., SUITE 201
SACRAMENTO, CA 95820 RENO, NV 89502
TEL: 916-737-6014 TEL: 775-328-9100
FAX: 916-737-6015 FAX: 775-329-9105
Contact: David Ainsworth



PK Electrical, Inc.
Engineering Design Consulting
681 Sierra Rose Dr., Ste. B / Reno, Nevada 89511 / 775.828.8010
4800 South Syracuse, 9th Floor / Denver, Colorado 80527 / 303.256.6598
pk-electrical.com 2008-2011 PK Electrical, Inc.
Contact: Joey Ganser

BID DOCUMENTS – FINAL

01/30/2015

hga commission number: 2941-011-00

DRAWING INDEX	
SHEET NUMBER	SHEET NAME
1-GENERAL	
12-001	COVER SHEET
12-002	GENERAL PROJECT INFORMATION AND ABBREVIATIONS
12-003	SYMBOLS
12-010	FACILITY DOCUMENTATION
12-101	FIRST FLOOR LIFE SAFETY PLAN
12-102	THIRD FLOOR LIFE SAFETY PLAN
12-103	AREA SCHEDULES
12-105	SITE PLAN
4-ARCHITECTURAL	
12-110	FIRST FLOOR DEMOLITION PLAN
12-112	SECOND FLOOR DEMOLITION PLAN
12-113	THIRD FLOOR DEMOLITION PLAN
12-114	THIRD FLOOR SLAB MODIFICATION PLAN
12-115	DEDUCTIVE ALTERNATES
12-116	EXTERIOR DEMOLITION ELEVATIONS
12-117	EXTERIOR DEMOLITION ELEVATIONS
12-121	FIRST FLOOR PLAN
12-122	SECOND FLOOR PLAN
12-123	THIRD FLOOR PLAN
12-123A	ENLARGED THIRD FLOOR PLAN - AREA A
12-123B	ENLARGED THIRD FLOOR PLAN - AREA B
12-123C	ENLARGED THIRD FLOOR PLAN - AREA C
12-123D	ENLARGED THIRD FLOOR PLAN - AREA D
12-133A	THIRD FLOOR EQUIPMENT PLAN - AREA A
12-133B	THIRD FLOOR EQUIPMENT PLAN - AREA B
12-133C	THIRD FLOOR EQUIPMENT PLAN - AREA C
12-133D	THIRD FLOOR EQUIPMENT PLAN - AREA D
12-150	ROOF PLAN
12-161	FIRST FLOOR REFLECTED CEILING PLAN
12-162	SECOND FLOOR REFLECTED CEILING PLAN
12-163	THIRD FLOOR REFLECTED CEILING PLAN
12-163A	ENLARGED THIRD FLOOR REFLECTED CEILING PLAN - AREA A
12-163B	ENLARGED THIRD FLOOR REFLECTED CEILING PLAN - AREA B
12-163C	ENLARGED THIRD FLOOR REFLECTED CEILING PLAN - AREA C
12-163D	ENLARGED THIRD FLOOR REFLECTED CEILING PLAN - AREA D
12-201	EXTERIOR ELEVATIONS
12-201	ISOMETRIC VIEW
12-210	MOUNTING HEIGHTS
12-211	INTERIOR ELEVATIONS
12-212	INTERIOR ELEVATIONS

DRAWING INDEX	
SHEET NUMBER	SHEET NAME
12-213	INTERIOR ELEVATIONS
12-214	INTERIOR ELEVATIONS
12-215	INTERIOR ELEVATIONS
12-300	BUILDING SECTIONS
12-310	WALL SECTIONS
12-400	ENLARGED PLANS
12-510	EXTERIOR WALL TYPES
12-511	EXTERIOR DETAILS
12-512	EXTERIOR DETAILS
12-520	INTERIOR PARTITION TYPES
12-521	INTERIOR METAL STUD FRAMING DETAILS
12-522	INTERIOR DETAILS
12-526	ACOUSTICAL CEILING DETAILS AND NOTES
12-527	GYP SUM BOARD CEILING DETAILS
12-529	CASEWORK DETAILS
12-530	ROOF TYPES AND DETAILS
12-590	DOOR AND WINDOW DETAILS
12-600	DOOR SCHEDULE AND TYPES
12-601	WINDOW SCHEDULE
12-603	ROOM FINISH SCHEDULE
12-605	EQUIPMENT SCHEDULE
6-INTERIORS	
12-1101	THIRD FLOOR FINISH PLAN
12-1102	ENLARGED FINISH PLANS & ELEVATIONS
12-1103	THIRD FLOOR ACCENT PAINT PLAN
12-1104	THIRD FLOOR WALL PROTECTION PLAN - AREA A
12-1105	THIRD FLOOR WALL PROTECTION PLAN - AREA B
12-1106	THIRD FLOOR WALL PROTECTION PLAN - AREA C
12-1107	THIRD FLOOR WALL PROTECTION PLAN - AREA D
8-STRUCTURAL	
12-5001	GENERAL NOTES
12-5102	FOUNDATION PLAN
12-5103	FIRST FLOOR & THIRD FLOOR FRAMING PLAN
12-5105	THIRD FLOOR FRAMING PLAN
12-5106	FOURTH FLOOR FRAMING PLAN
12-5300	MOMENT FRAME ELEVATIONS AND CONNECTIONS DETAILS
12-5500	FOUNDATION DETAILS
12-5700	GENERAL STEEL DETAILS
12-5701	DETAILS
12-5720	GENERAL STEEL DECK DETAILS

DRAWING INDEX	
SHEET NUMBER	SHEET NAME
12-S721	GENERAL STEEL DECK DETAILS
12-S920	BOOM DETAILS
12-S921	PATIENT LIFT DETAILS
10-MECHANICAL	
12-M001	MECHANICAL - LEGEND AND SCHEDULES
12-M002	MECHANICAL SCHEDULES
12-M010	MECHANICAL - PARTIAL FIRST FLOOR DEMOLITION & NEW FLOOR PLANS
12-M101	MECHANICAL - OVERALL THIRD FLOOR DEMOLITION PLAN
12-M102	MECHANICAL PIPING - OVERALL THIRD FLOOR DEMOLITION PLAN
12-M110	MECHANICAL - OVERALL THIRD FLOOR PLAN
12-M111	MECHANICAL - PARTIAL THIRD FLOOR PLAN
12-M112	MECHANICAL - PARTIAL THIRD FLOOR PLAN
12-M113	MECHANICAL ROOF PLAN
12-M200	MECHANICAL PIPING PLAN
12-M501	MECHANICAL - DETAILS
12-M502	MECHANICAL - DETAILS
12-M601	TEMPERATURE CONTROLS
12-M201	ZONING PLAN
12-PLUMBING	
12-P001	PLUMBING - LEGEND AND SCHEDULES
12-P100	PLUMBING - PARTIAL BASEMENT FLOOR DEMOLITION AND NEW PLAN
12-P101	PLUMBING - PARTIAL FIRST FLOOR DEMOLITION AND NEW PLAN
12-P102	PLUMBING - PARTIAL THIRD FLOOR DEMOLITION PLAN
12-P103	PLUMBING - PARTIAL THIRD FLOOR DEMOLITION PLAN
12-P110	PLUMBING - OVERALL THIRD FLOOR PLAN
12-P111	PLUMBING - PARTIAL THIRD FLOOR PLAN - NORTHWEST
12-P112	PLUMBING - PARTIAL THIRD FLOOR PLAN - NORTHEAST
12-P113	PLUMBING - PARTIAL THIRD FLOOR PLAN - SOUTHWEST
12-P114	PLUMBING - PARTIAL THIRD FLOOR PLAN - SOUTHEAST
12-P115	PLUMBING - ROOF PLAN
12-P501	PLUMBING - DETAILS
14-FIRE PROTECTION	
12-FX101	FIRE PROTECTION - PARTIAL THIRD FLOOR DEMOLITION PLAN
12-FX102	FIRE PROTECTION - PARTIAL THIRD FLOOR NEW
16-ELECTRICAL	
12-GE001	ELECTRICAL LEGEND, FIRE ALARM LEGEND & DRAWING SCHEDULE
12-E501	DETAILS


DRAWING INDEX	
SHEET NUMBER	SHEET NAME
12-E502	DETAILS
12-E601	FIXTURE SCHEDULE & IECC CALCULATION
12-E602	PANEL SCHEDULES
12-E603	EXISTING ONE LINE DIAGRAM
12-ED111	DEMOLITION FIRST FLOOR ELECTRICAL PLAN
12-ED121	THIRD FLOOR DEMOLITION LIGHTING & CEILING PLAN - AREA A
12-ED122	THIRD FLOOR DEMOLITION LIGHTING & CEILING PLAN - AREA B
12-ED123	THIRD FLOOR DEMOLITION LIGHTING & CEILING PLAN - AREA C
12-ED124	THIRD FLOOR DEMOLITION LIGHTING & CEILING PLAN - AREA D
12-EDP121	THIRD FLOOR DEMOLITION POWER PLAN - AREA A
12-EDP122	THIRD FLOOR DEMOLITION POWER PLAN - AREA B
12-EDP123	THIRD FLOOR DEMOLITION POWER PLAN - AREA C
12-EDP124	THIRD FLOOR DEMOLITION POWER PLAN - AREA D
12-EDP131	UPPER ROOF ELECTRICAL DEMOLITION PLAN
12-EDY121	THIRD FLOOR DEMOLITION SIGNAL PLAN - AREA A
12-EDY122	THIRD FLOOR DEMOLITION SIGNAL PLAN - AREA B
12-EDY123	THIRD FLOOR DEMOLITION SIGNAL PLAN - AREA C
12-EDY124	THIRD FLOOR DEMOLITION SIGNAL PLAN - AREA D
12-EL111	FIRST FLOOR LIGHTING PLAN
12-EL121	THIRD FLOOR LIGHTING PLAN - AREA A
12-EL122	THIRD FLOOR LIGHTING PLAN - AREA B
12-EL123	THIRD FLOOR LIGHTING PLAN - AREA C
12-EL124	THIRD FLOOR LIGHTING PLAN - AREA D
12-EP111	FIRST FLOOR POWER PLAN
12-EP120	THIRD FLOOR OVERALL POWER PLAN
12-EP121	THIRD FLOOR POWER PLAN - AREA A
12-EP122	THIRD FLOOR POWER PLAN - AREA B
12-EP123	THIRD FLOOR POWER PLAN - AREA C
12-EP124	THIRD FLOOR POWER PLAN - AREA D
12-EP125	THIRD FLOOR MECHANICAL POWER PLAN - AREA A
12-EP126	THIRD FLOOR MECHANICAL POWER PLAN - AREA B
12-EP127	THIRD FLOOR MECHANICAL POWER PLAN - AREA C
12-EP128	THIRD FLOOR MECHANICAL POWER PLAN - AREA D
12-EP131	UPPER ROOF ELECTRICAL PLAN
12-FA121	THIRD FLOOR FIRE ALARM PLAN - AREA A
12-FA122	THIRD FLOOR FIRE ALARM PLAN - AREA B
12-FA123	THIRD FLOOR FIRE ALARM PLAN - AREA C
12-FA124	THIRD FLOOR FIRE ALARM PLAN - AREA D
12-GT001	TELECOM GENERAL NOTES, LEGEND, LABELING & DRAWING SCHEDULE
12-T121	THIRD FLOOR TELECOM PLAN - AREA A
12-T122	THIRD FLOOR TELECOM PLAN - AREA B
12-T123	THIRD FLOOR TELECOM PLAN - AREA C

DRAWING INDEX	
SHEET NUMBER	SHEET NAME
12-T124	THIRD FLOOR TELECOM PLAN - AREA D
12-T401	ENLARGED TELECOM ROOM & RACK ELEVATION
12-T501	TELECOM DETAILS
12-T502	DOOR ACCESS CONTROL DETAILS
12-T601	IP VIDEO SURVEILLANCE CAMERA SINGLE LINE DIAGRAMS & DETAILS
12-T602	PAGING AND NURSE CALL SINGLE LINE DIAGRAMS

BIDDING RFI #16.1	8/20/2015
BIDDING RFI #16	8/5/2015
Revisions:	Date:

CONSULTANTS:

ARCHITECT/ENGINEERS:

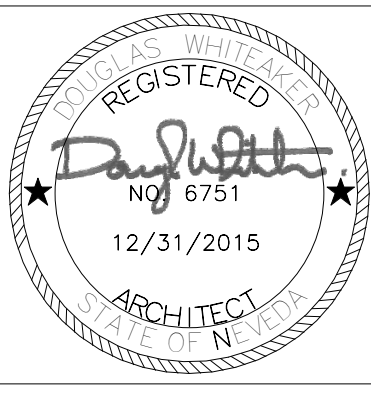

Architecture | Engineering | Planning
Hammel, Green and Abrahamson, Inc.
1410 Rocky Ridge Drive, Suite 250
Roseville, California USA 95661
Telephone 916.787.5100 Facsimile 916.784.7738
Contact: Douglas Whiteaker

Drawing Title	COVER SHEET
Approved: Project Director	

Project Title	WARD 2C REMODEL: INTENSIVE CARE UNIT
Project Number	654-412
Building Number	12
Location	975 KIRMAN AVE. RENO, NV 89520
Date	01/30/2015
Checked	DW
Drawn	SL/JW
Drawing Number	12-001
Dwg. of	

Office of
Construction
and Facilities
Management



Scale:

BID DOCUMENTS - FINAL