


CAMPUS WIDE FIRE SPRINKLING TEST STATION MODIFICATIONS AND DEFICIENCIES STUDY

660-10-110

GEORGE E. WAHLEN
DEPARTMENT OF VETERANS AFFAIRS
MEDICAL CENTER
500 FOOTHILL DRIVE
SALT LAKE CITY, UTAH 84112

FINAL DRAFT
OCTOBER 1, 2010

*No plans for parking structure
in this set: (4 dry systems) / piv
Building 1 no roof manifold
for standpipe
Building 14 no roof manifold
for standpipe
Building 47 no roof
wet system / piv*

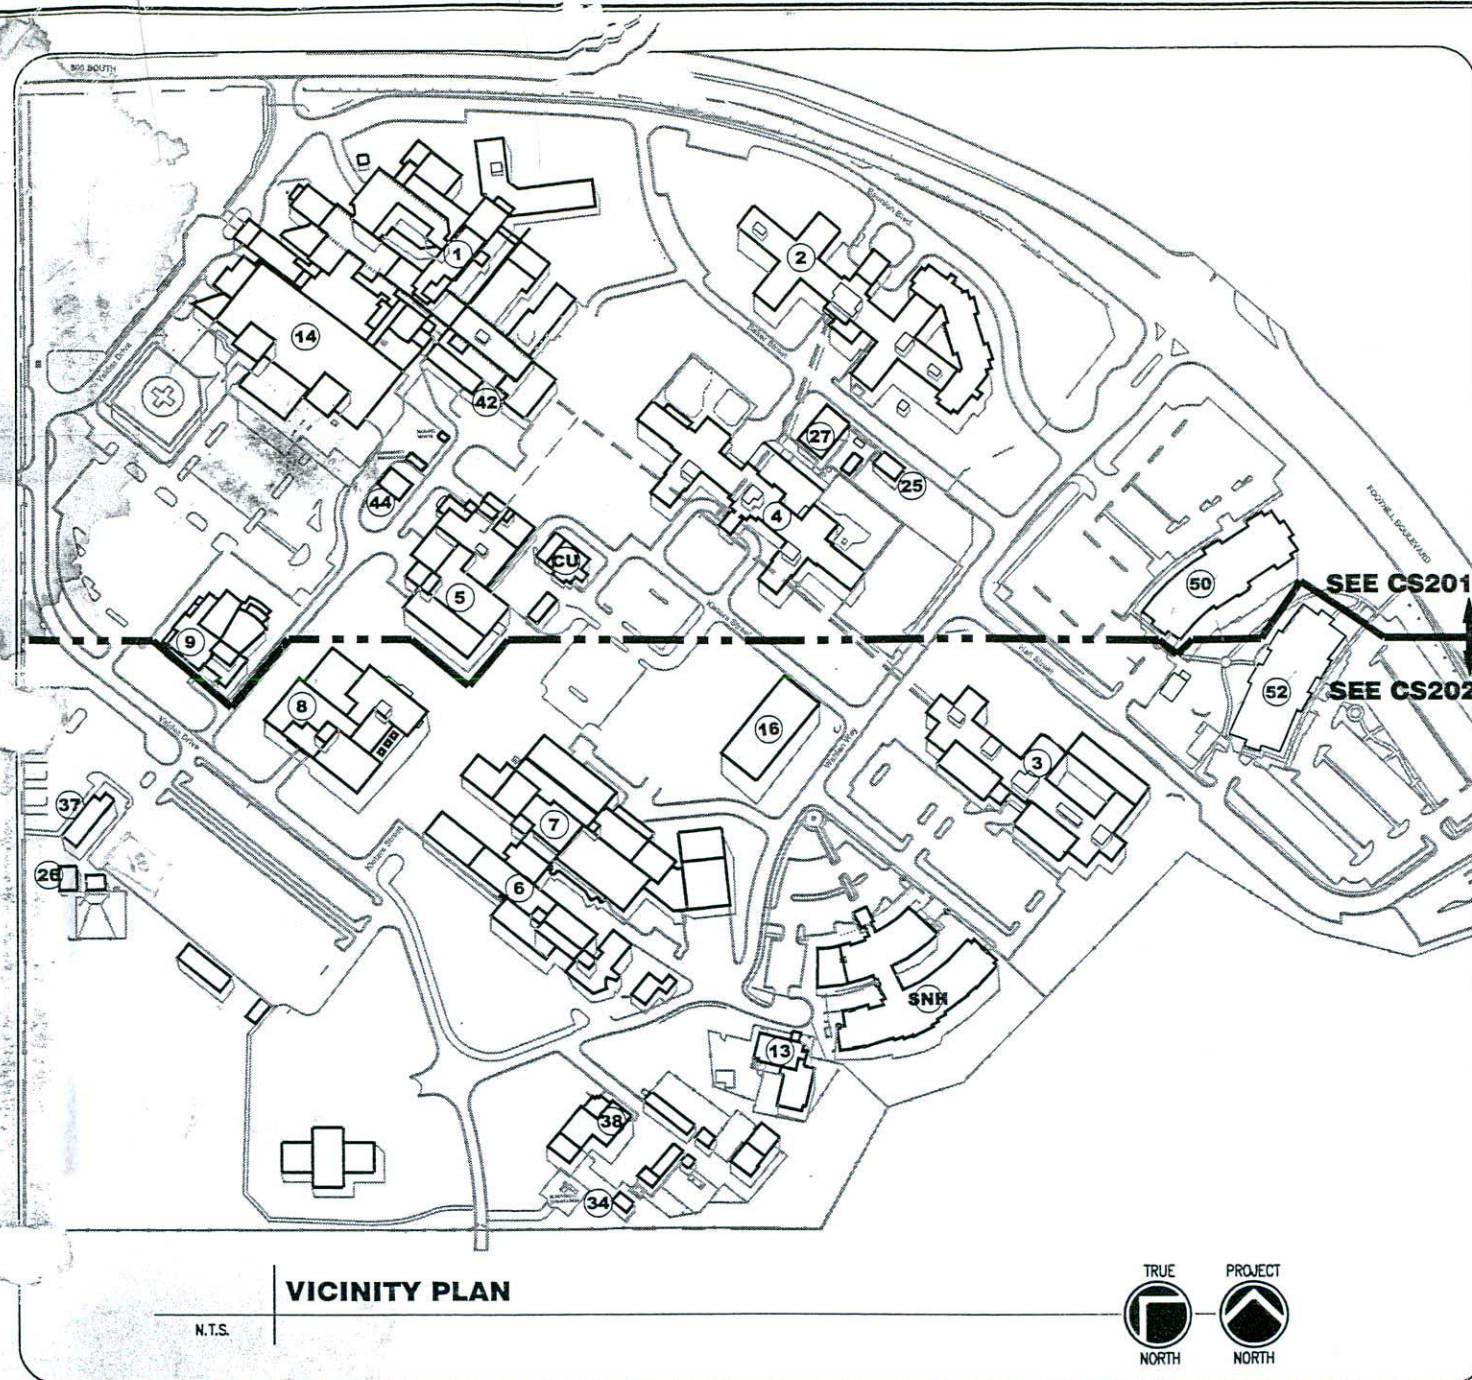

*Gauges on campus
replaced in 2013
2 1/2" Hose valves
replaced 2013*

Revisions

Date
Date

Consultant



324 South State Street, Suite 400
Salt Lake City, Utah 84111
801.328.5151
800.678.7077
FAX 801.328.5155
www.spectrum-engineers.com

Project Title
CAMPUS WIDE FIRE SPRINKLING TEST STATION
MODIFICATION AND DEFICIENCIES STUDY

Consultant Project No. 20100195

Drawn
BXW

Checked
JDD

Drawing Title

COVER SHEET
& SITE PLAN

Date

08.03.2010
Project No.
660-10-110

Building No.

DRAWING No.

CS100

Dep. of XX



AS-BUILT RECORD DRAWINGS

Department of
Veterans Affairs