


File Name: P:\2010\20100195\Drawings\Sheet\950201.dwg Last Plotted: 2010/11/01 12:29 PM By: bww



Revisions	Date

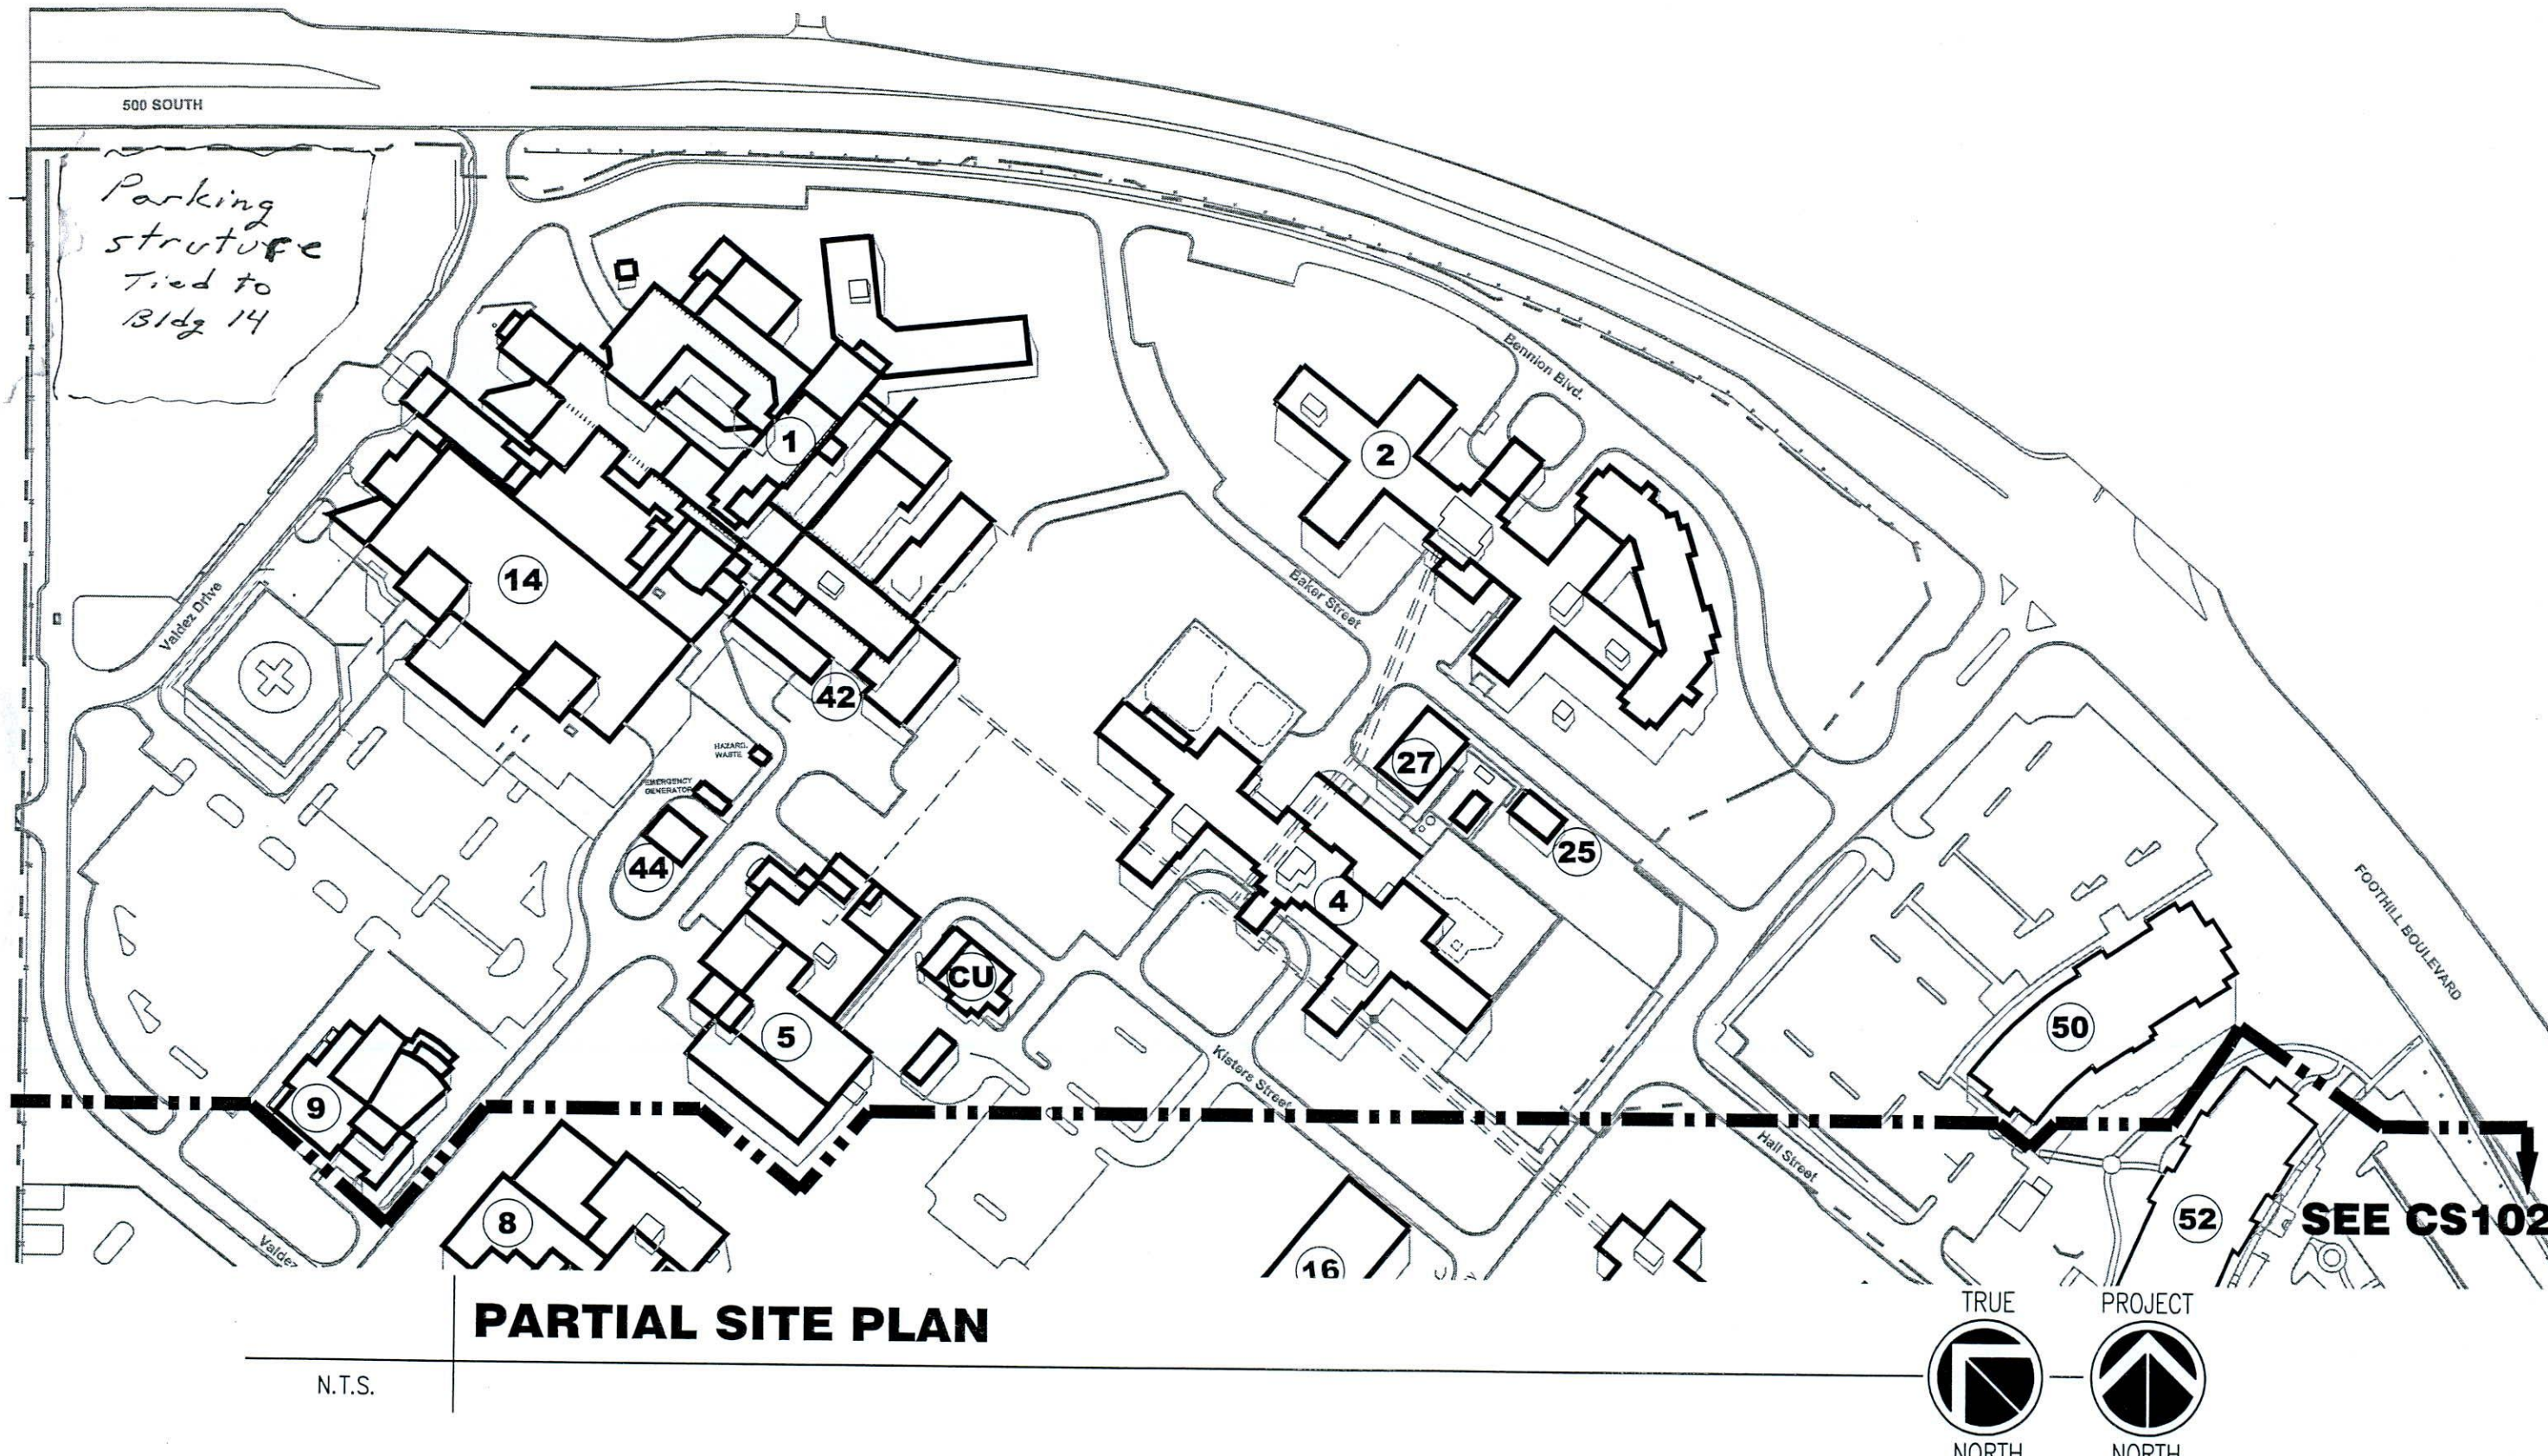

Consultant
324 South State Street, Suite 400
Salt Lake City, Utah 84111
801.328.5151
800.678.7077
FAX 801.328.5155
www.spectrum-engineers.com

Project Title
CAMPUS WIDE FIRE SPRINKLING TEST STATION
MODIFICATION AND DEFICIENCIES STUDY
Consultant Project No. 20100195
Drawn BXW
Checked JDD

Drawing Title
PARTIAL SITE PLAN

Date
08.03.2010
Project No.
660-10-110
Building No.
-

DRAWING No.
CS201
Dep. of XX
VAMC
TO QUALITY

AS-BUILT RECORD DRAWINGS
Department of Veterans Affairs