



 





 
 


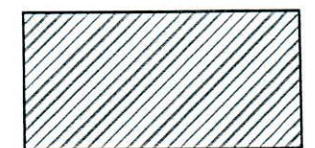
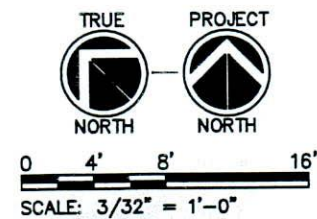
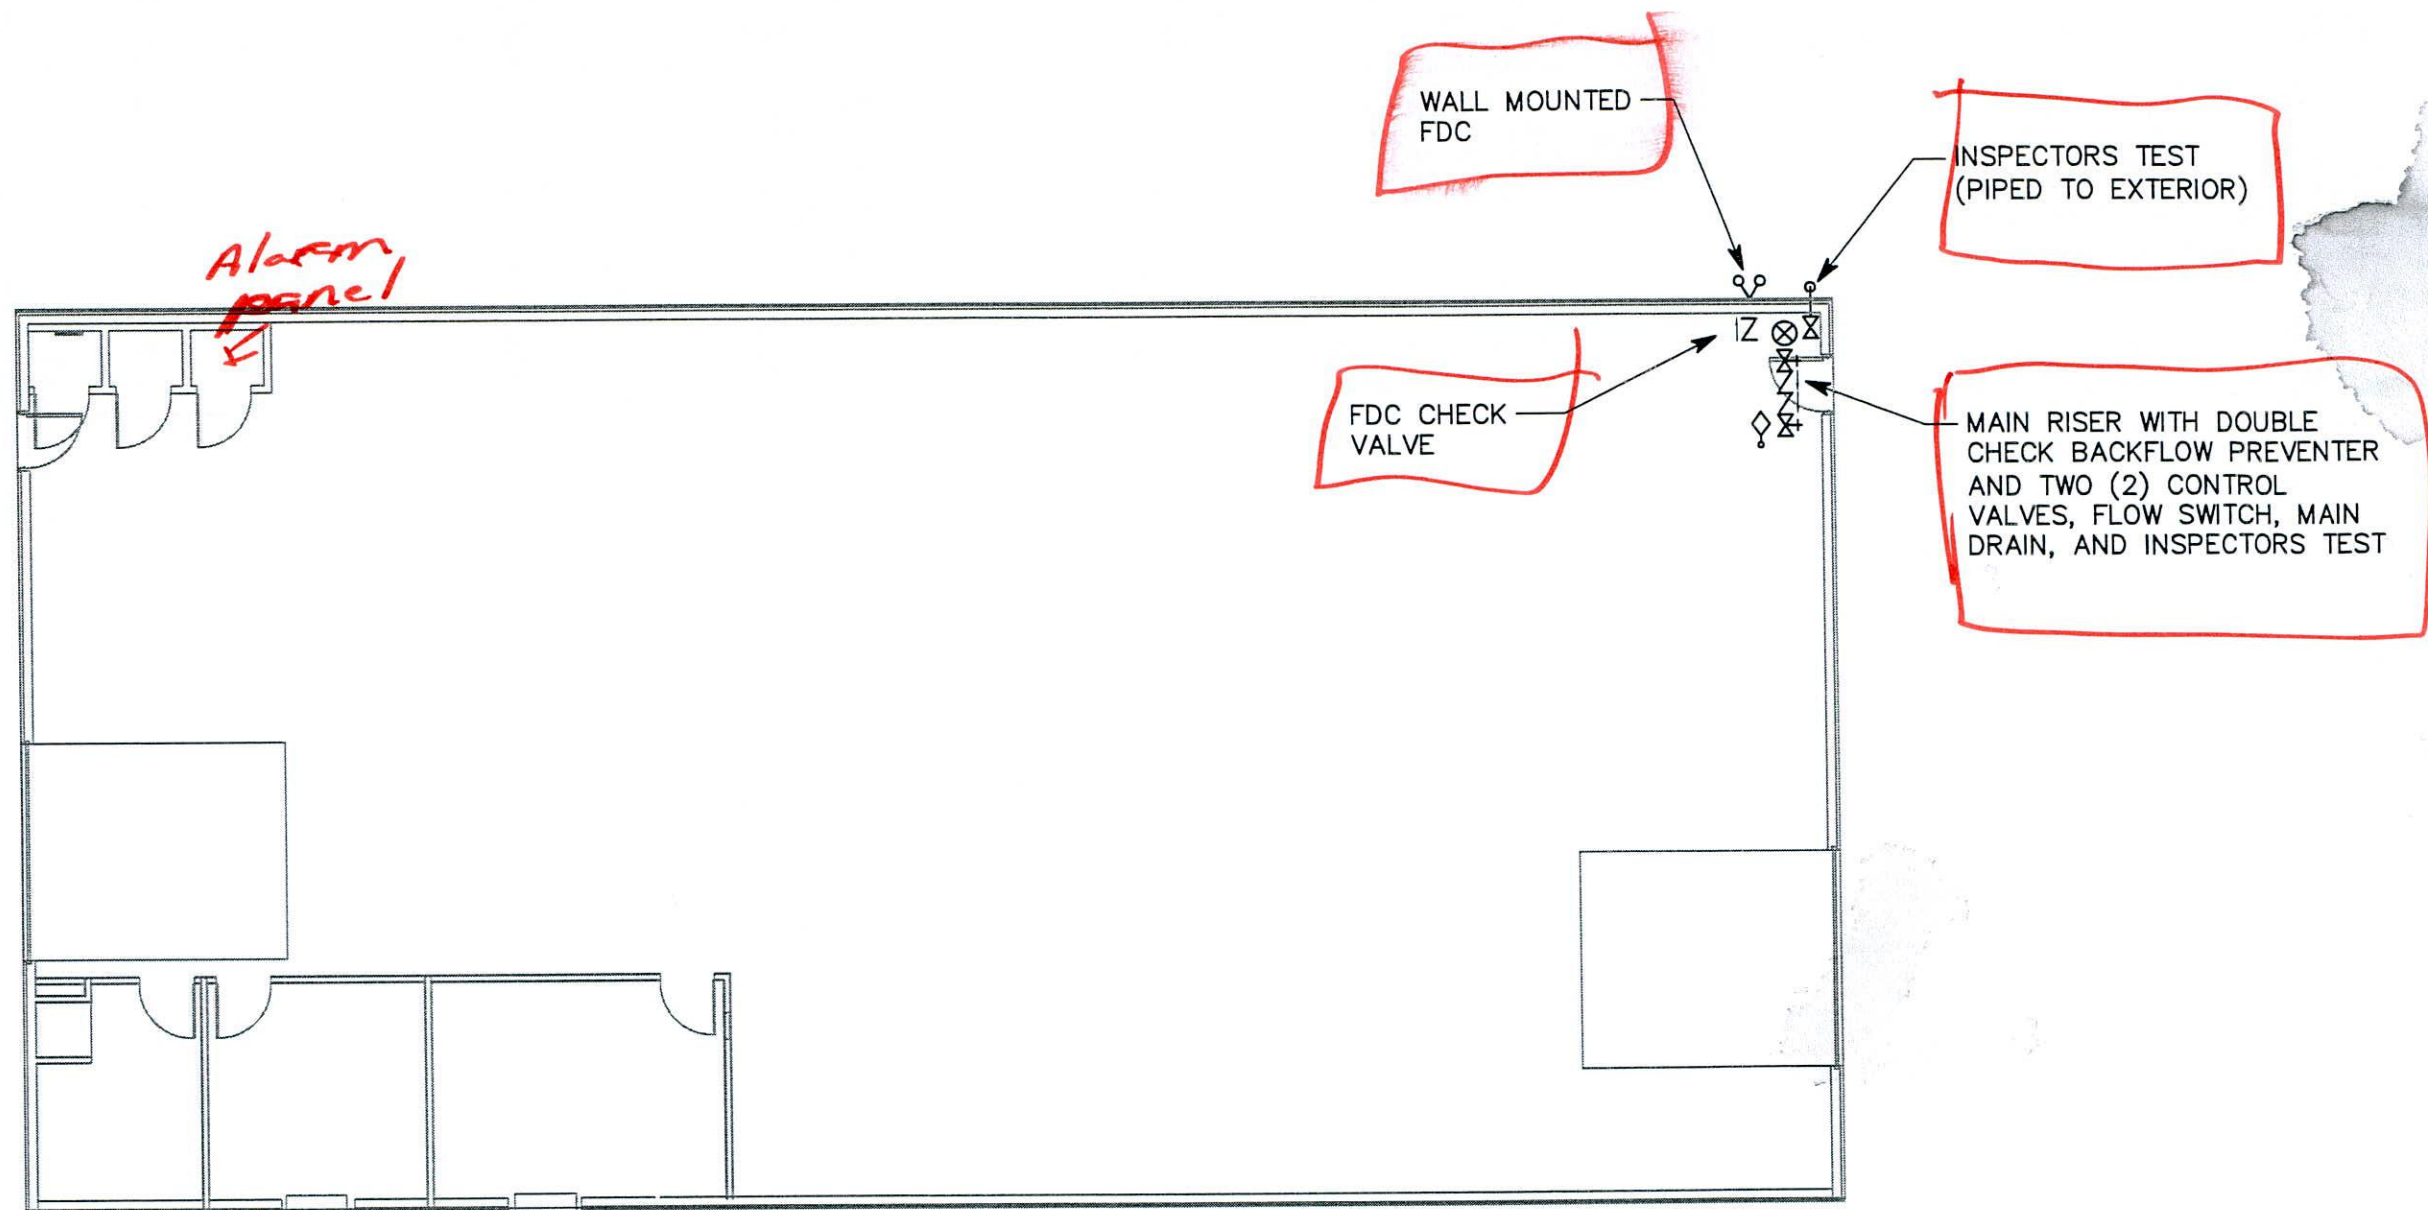


File Name: P:\2010\20100195\Drawings\Bldg 18\3Sheet\95F.18.1.dwg Last Plotted: 2010/11/01 12:18 PM By: jdd

LEGEND	
	CONTROL VALVE
	FLOW SWITCH
	IT AND/OR DRAIN VALVE
	HOSE VALVE
	IT AND/OR DRAIN OUTLET
	POST INDICATOR VALVE
	FIRE PUMP
	FIRE PUMP TEST HEADER
	MAIN FIRE SPRINKLER RISER
	BYPASS FLOW METER
	FREE STANDING FIRE DEPARTMENT CONNECTION
	WALL MOUNTED FIRE DEPARTMENT CONNECTION
	CHECK VALVE
	DOUBLE CHECK BACKFLOW PREVENTER WITH CONTROL VALVES



KEY PLAN

Revisions	Date

Consultant

324 South State Street, Suite 400
Salt Lake City, Utah 84111
801.328.5151
800.678.7077
FAX 801.328.5155
www.spectrum-engineers.com

Project Title
CAMPUS WIDE FIRE SPRINKLING TEST STATION
MODIFICATION AND DEFICIENCIES STUDY
Consultant Project No. 20100195
Drawn BXW
Checked JDD

Drawing Title
BUILDING 18
FIRST LEVEL

Date
08.03.2010
Project No.
660-10-110
Building No.
18

Drawing No.
F.18.1
Dep. of
XX


AS-BUILT RECORD DRAWINGS

Department of
Veterans Affairs