



# VA JESSE BROWN MEDICAL CENTER

## 820 SOUTH DAMEN AVENUE

### CHICAGO, ILLINOIS 60612

V/A PROJECT NUMBER 537-10-122  
EPSTEIN DESIGN PROJECT NUMBER 11226. TASK ORDER #4


PROJECT NAME: REPLACEMENT OF AHU S-10A IN BUILDING #30  
PROJECT LOCATION: BUILDING #30 2ND FLOOR PENTHOUSE

#### DRAWING INDEX:


S-10A REPLACEMENT			
GENERAL			
1	30-GI-001	INDEX AND TITLE SHEET	1
HEATING, VENTILATING, AIR CONDITIONING, AND PIPING			
1	30-H-001	NOTES, SYMBOLS & ABBREVIATIONS	1
2	30-H-101	MECHANICAL ROOM VENTILATION PLAN	2
3	30-H-201	MECHANICAL ROOM PIPING PLAN	3
4	30-H-301	MECHANICAL ROOM PIPING PLAN	4
5	30-H-401	MECHANICAL ROOM PIPING PLAN	5
6	30-H-501	MECHANICAL ROOM PIPING PLAN	6
ELECTRICAL			
1	30-E-001	ELECTRICAL SYMBOLS AND ABBREVIATIONS	1
2	30-E-101	ELECTRICAL SINGLE LINE DIAGRAM	2
3	30-E-101	MECHANICAL ROOM ELECTRICAL PLAN	3
10	10	10	10

Approved:	
Chief PMIS:	Approver
Chief of Projects:	Approver
Chief of Safety:	Approver
ED Director:	Approver
Inspection Control:	Approver

#### LOCATION MAP

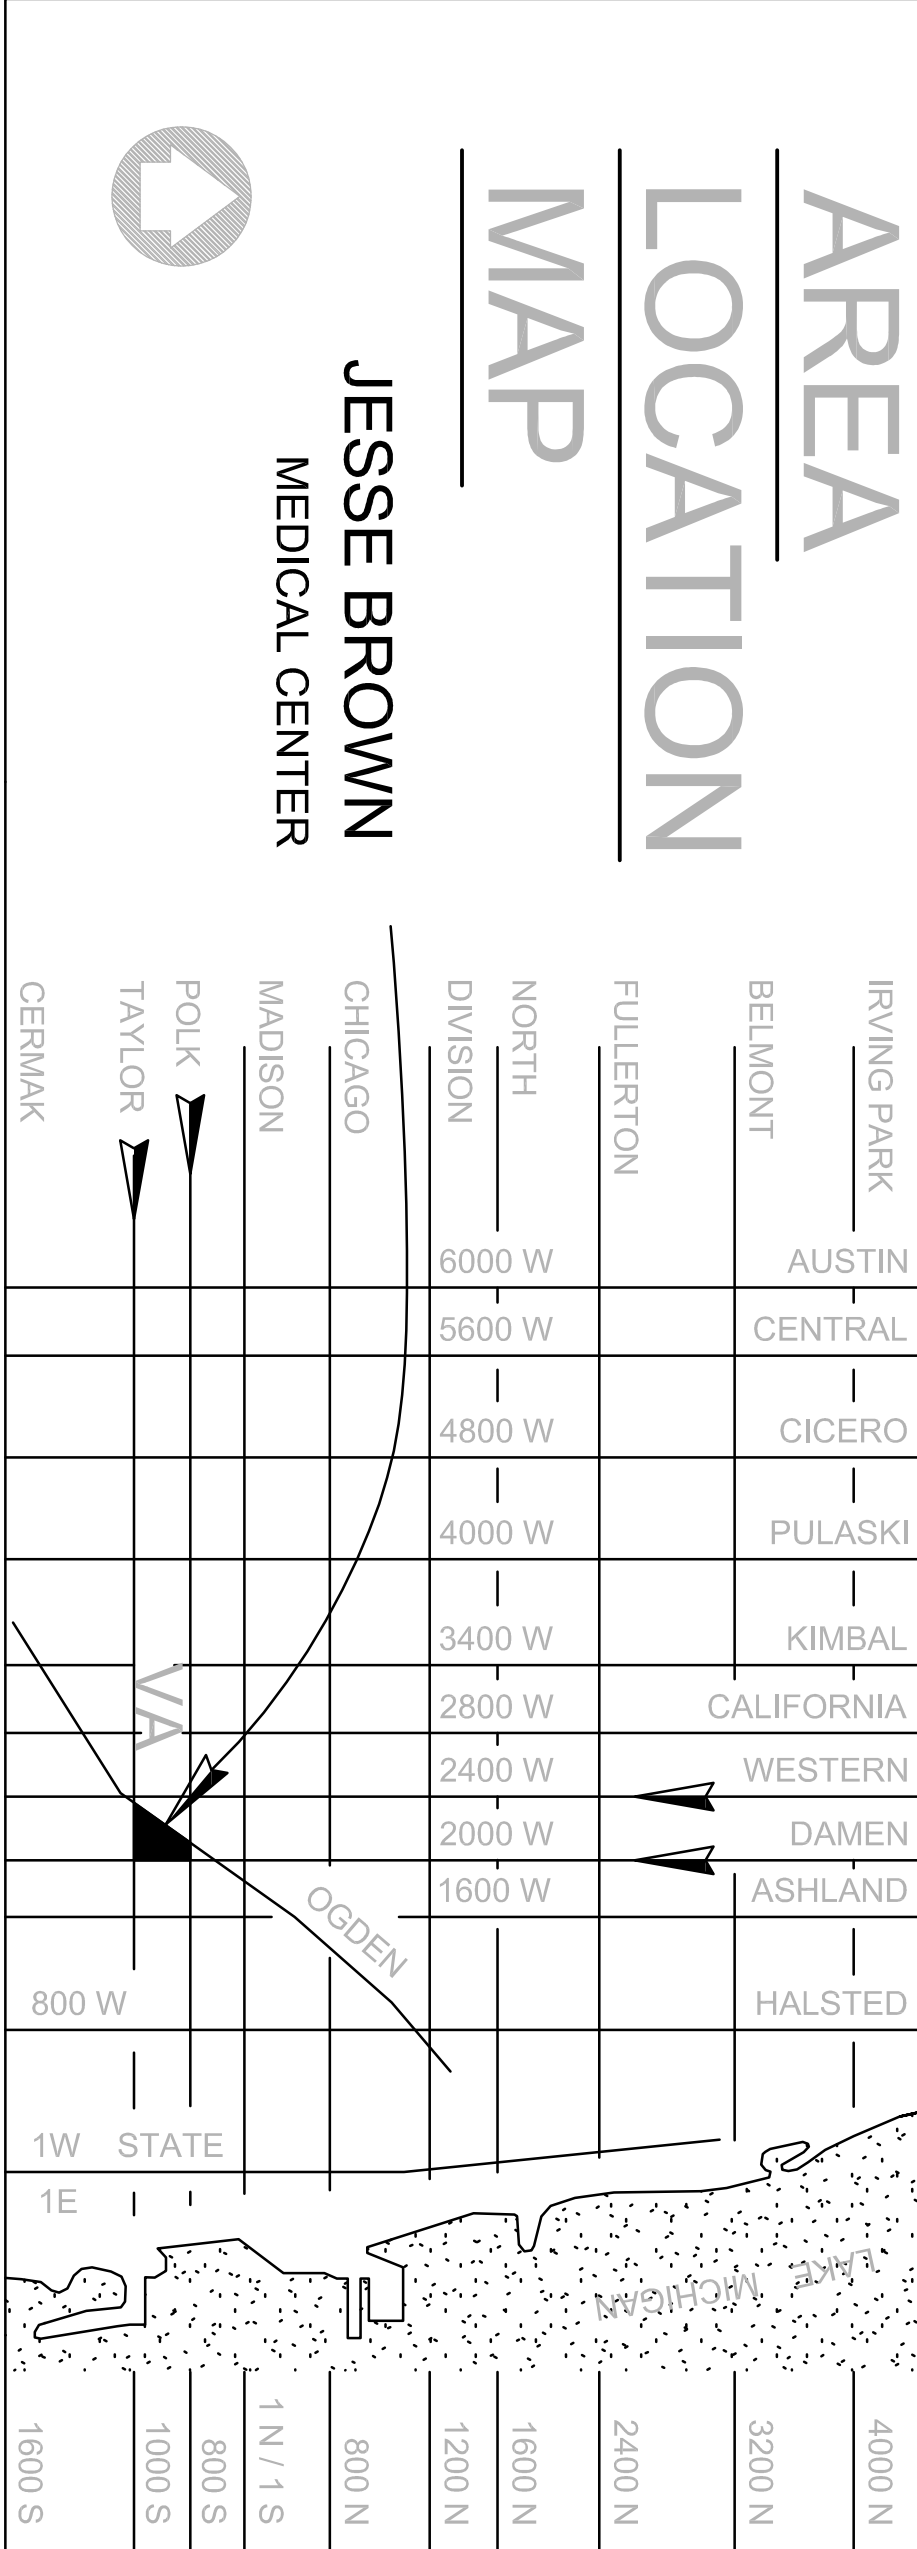

#### SITE PLAN

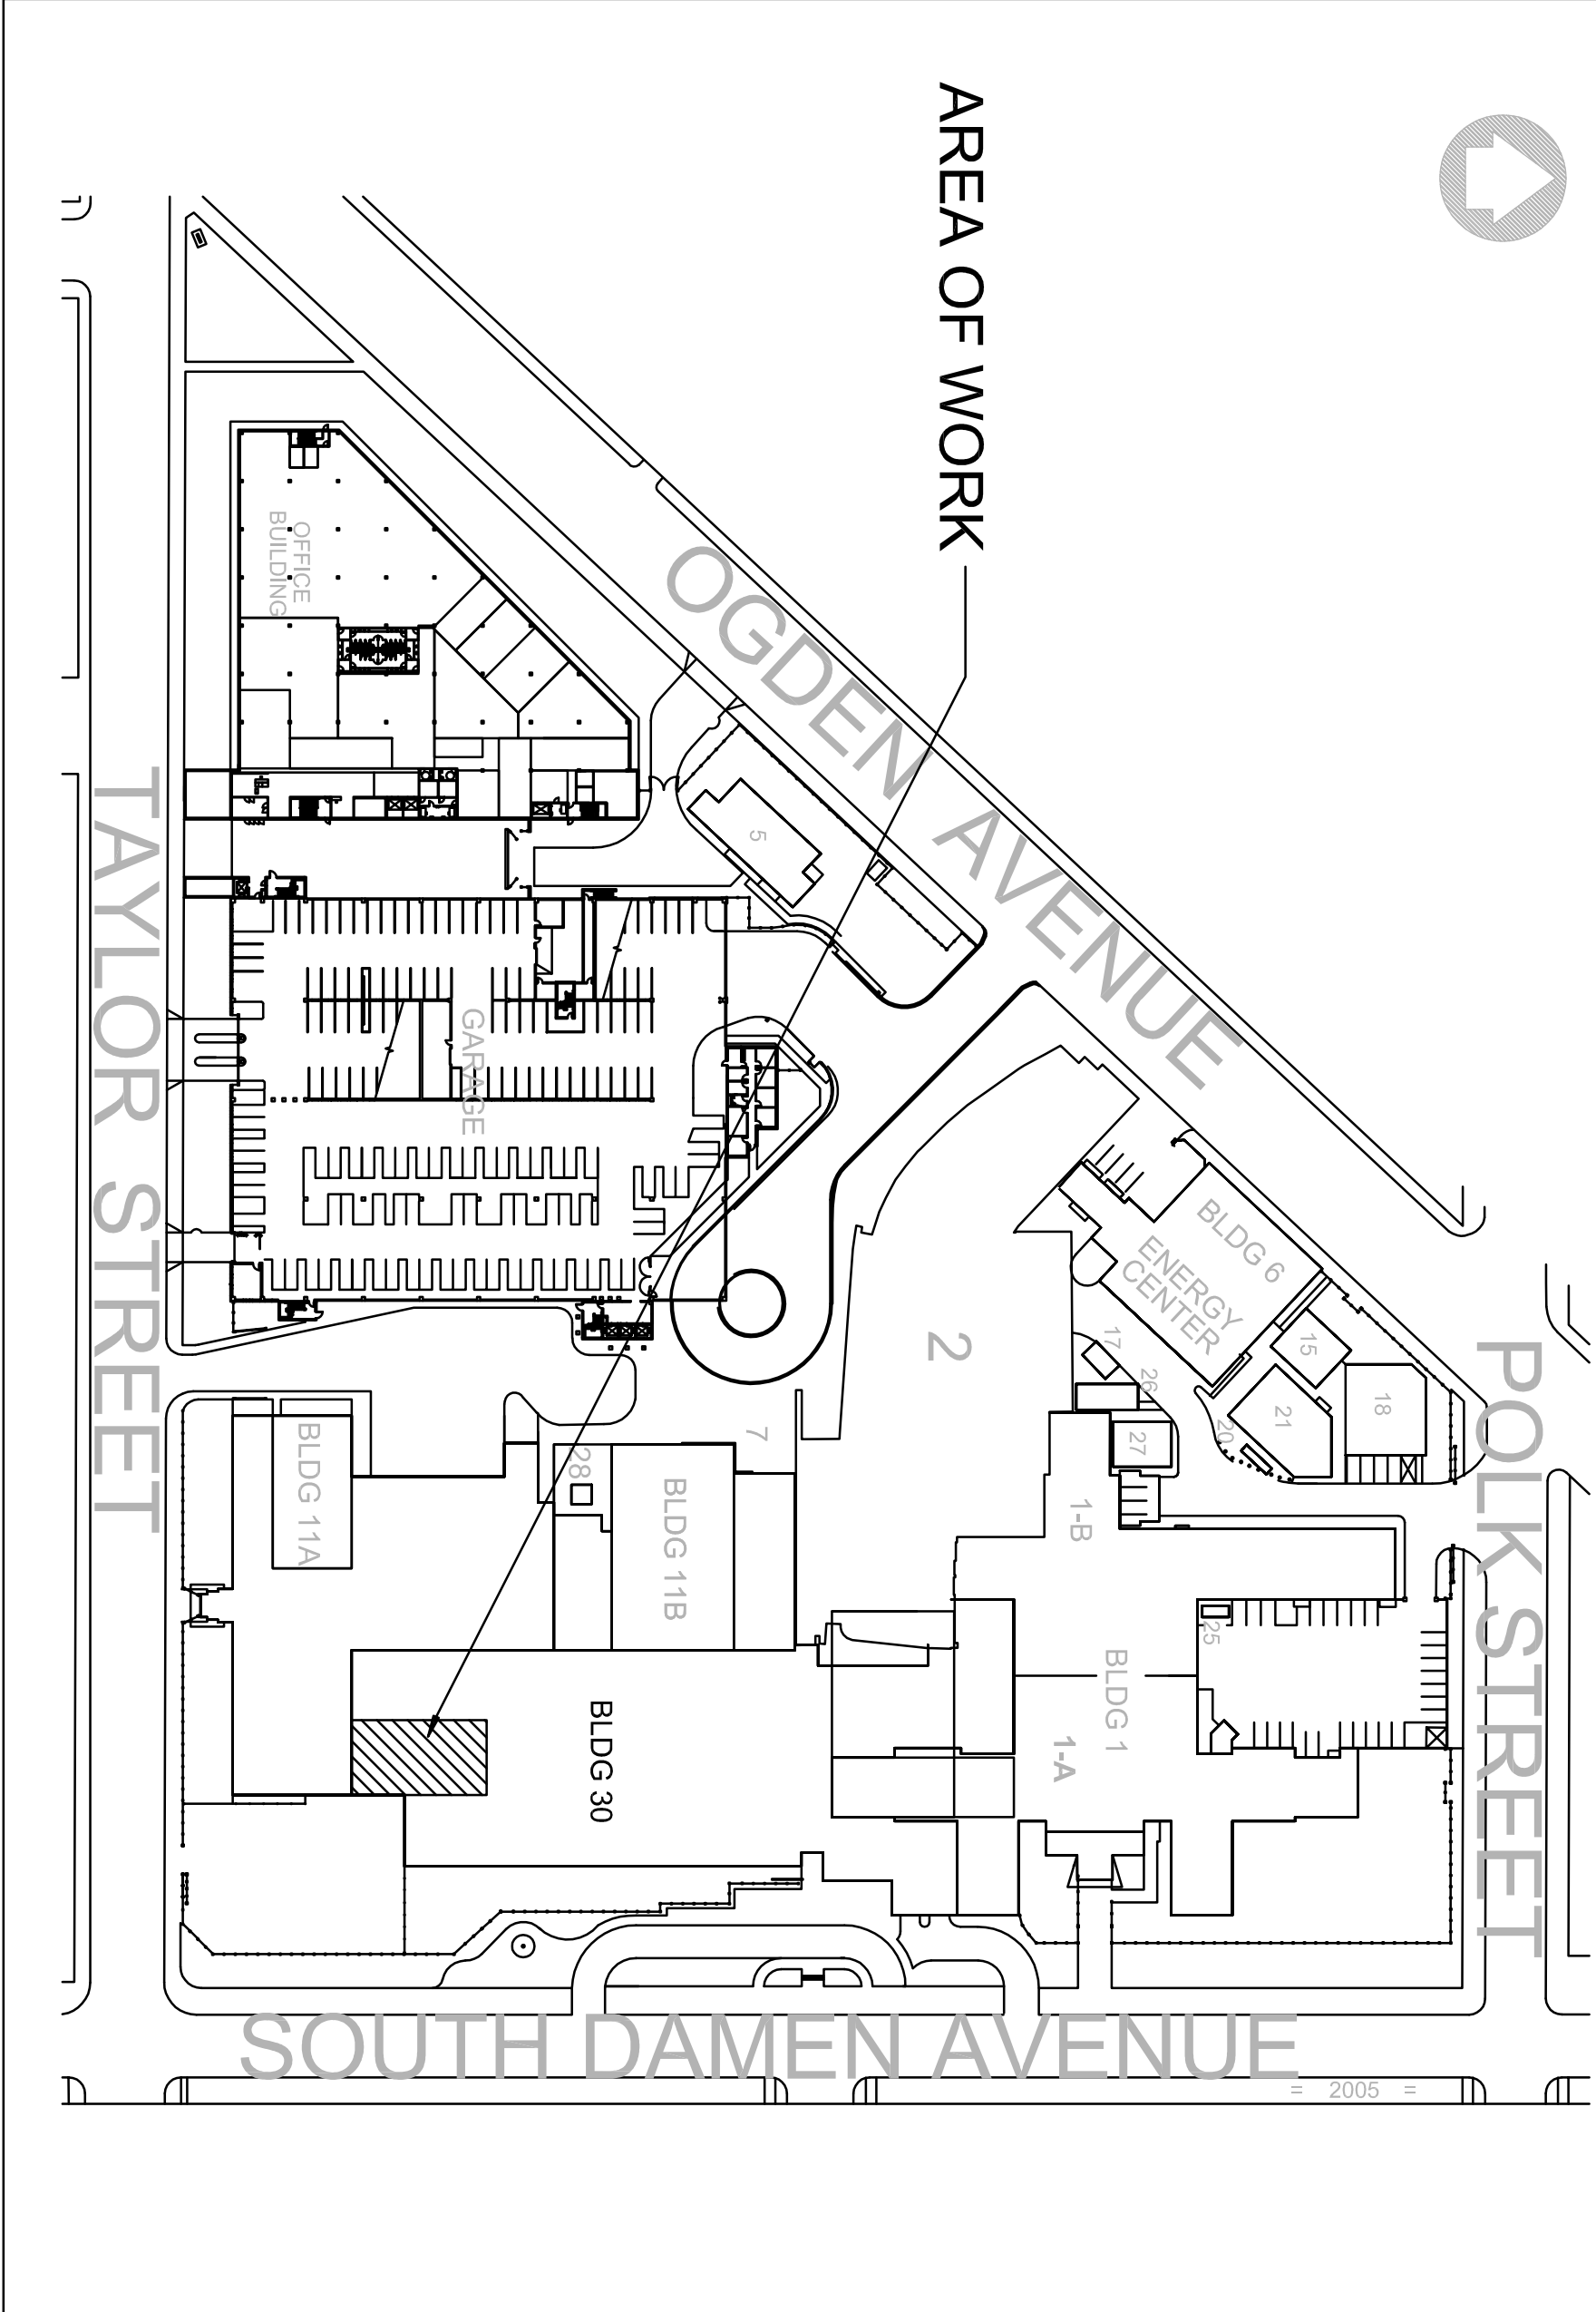

#### FULLY SPRINKLERED

ISSUED FOR CONSTRUCTION DOCUMENTS (FINAL BID)		11/26/13	
ISSUED FOR 100% DESIGN SUBMITTAL		10/28/13	
ISSUED FOR 75% DESIGN DEVELOPMENT		10/22/13	
Project Name		Date	
CONSULTANTS:			
ARCHITECT/ENGINEERS:			
Drawing Title			
INDEX AND TITLE SHEET		Project Title	
REPLACEMENT OF AHU S-10A IN BUILDING 30		537-10-122	
Approved Project Director		Building Number	
Location		Drawing Number	
820 S. DAMEN AVE CHICAGO, IL 60612		30-GI-001	
Date		Dwg. Of	
11/26/2013		1 of 10	
Checked		Drawn	
YW		AM	
Office of Construction and Facilities Management Department of Veterans Affairs			