
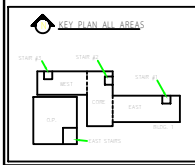


MAIN RISER PIPING CRITICAL DIAGRAM

BUILDING 1 SOUTH ELEVATION VIEW

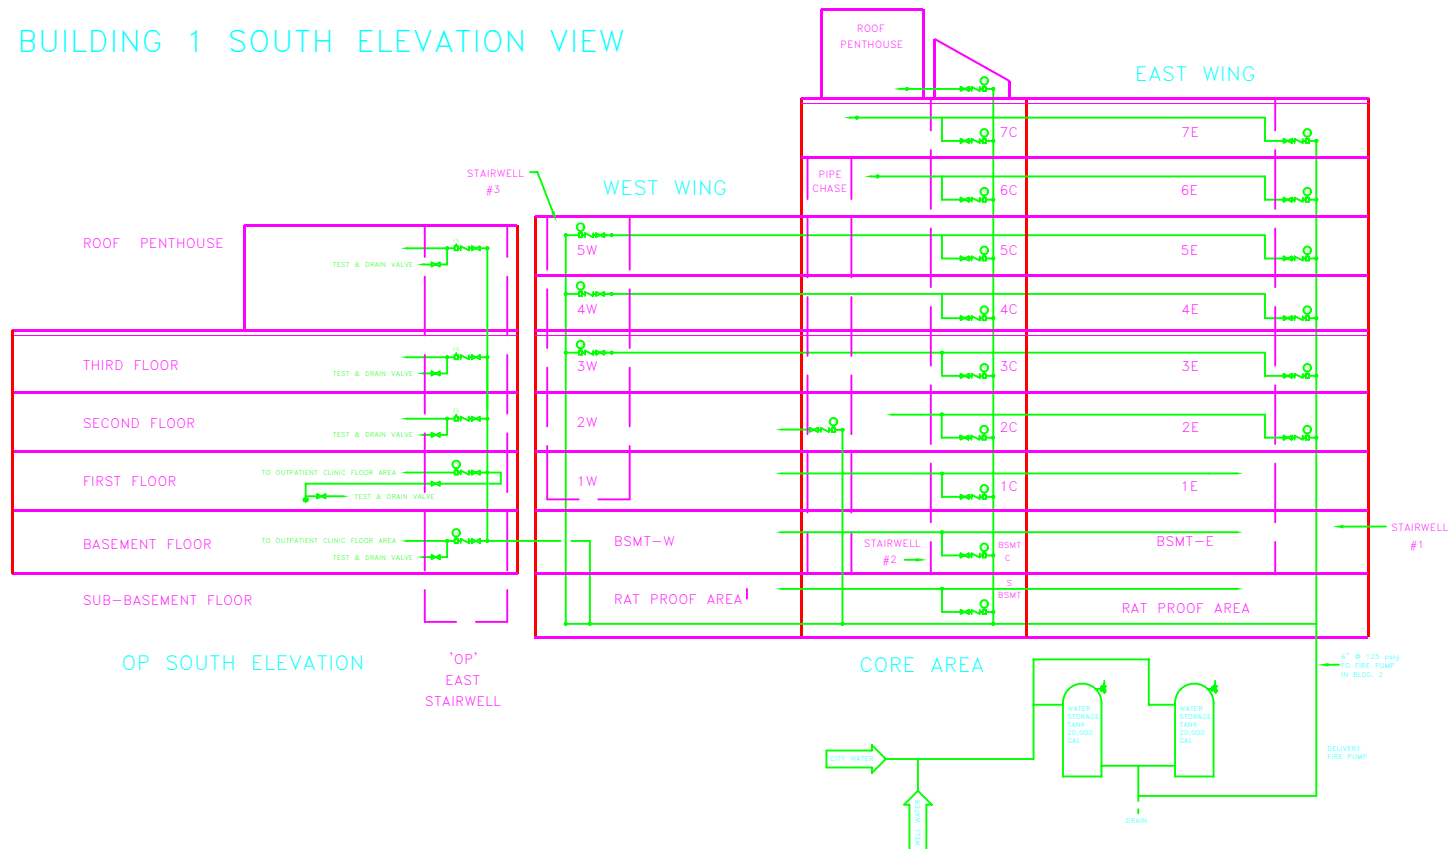

FIRE SPRINKLER PIPING MAIN RISER DIAGRAM

Critical Utility Systems Diagram

Issued For:	
Drawn By:	
Checked By:	
Design Date:	
Design Revision:	
Design Reference:	

FIRE PROTECTION SYSTEM

ENVIRONMENT OF CARE, JCAHO

JULY 2001

ONE
VAMC / FRESNO

RI HELT

