
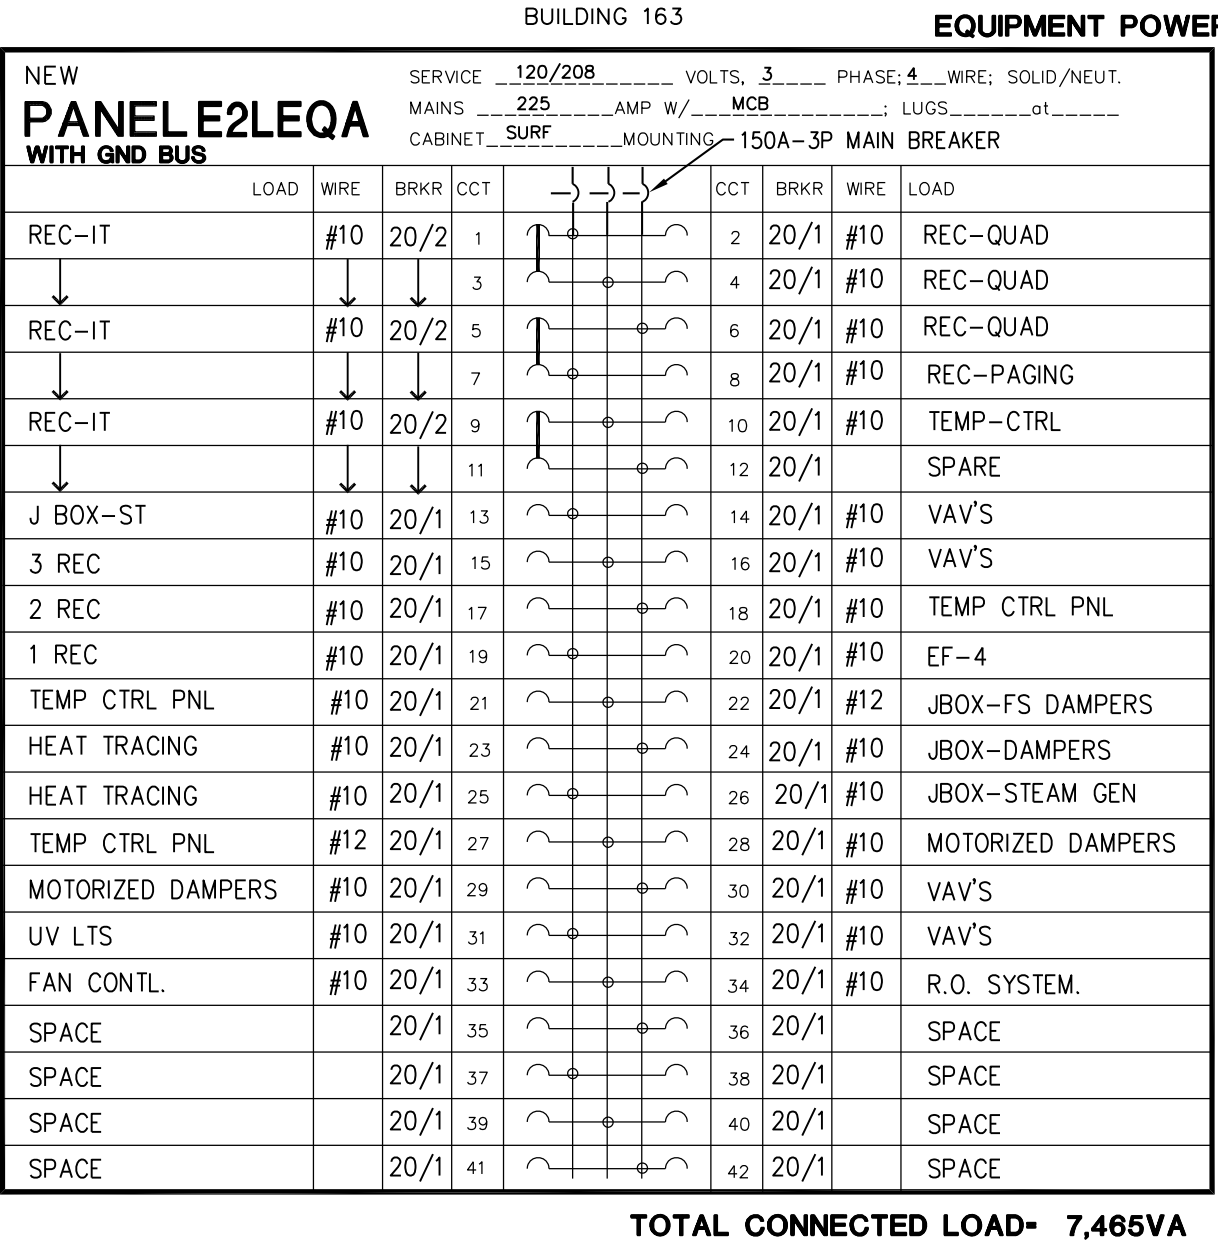
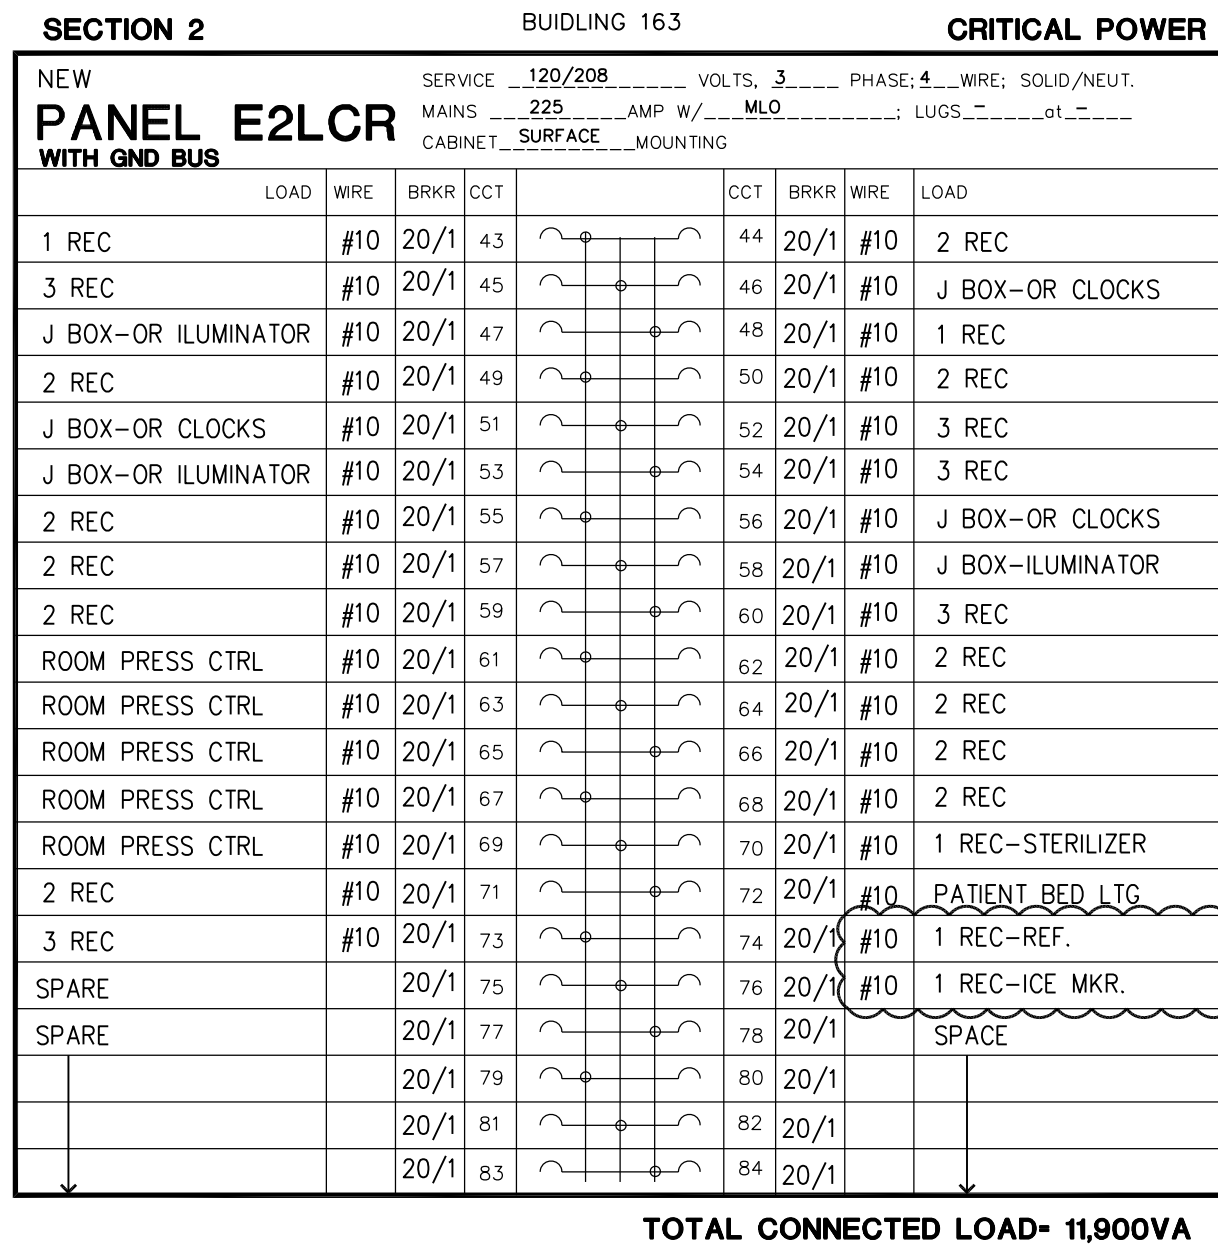
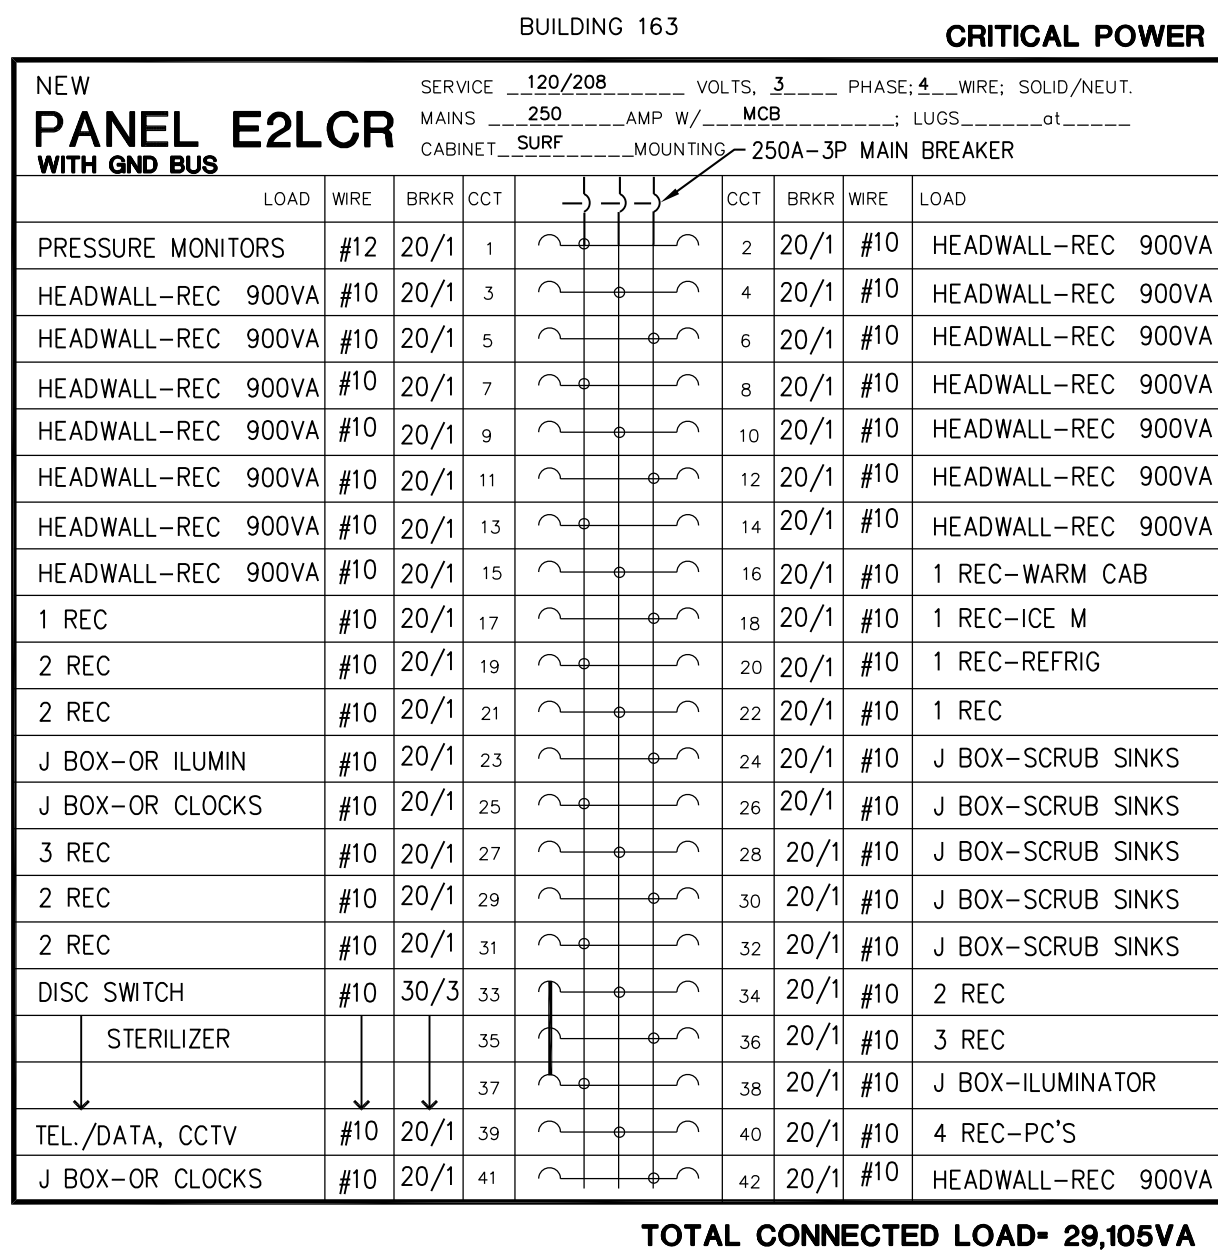
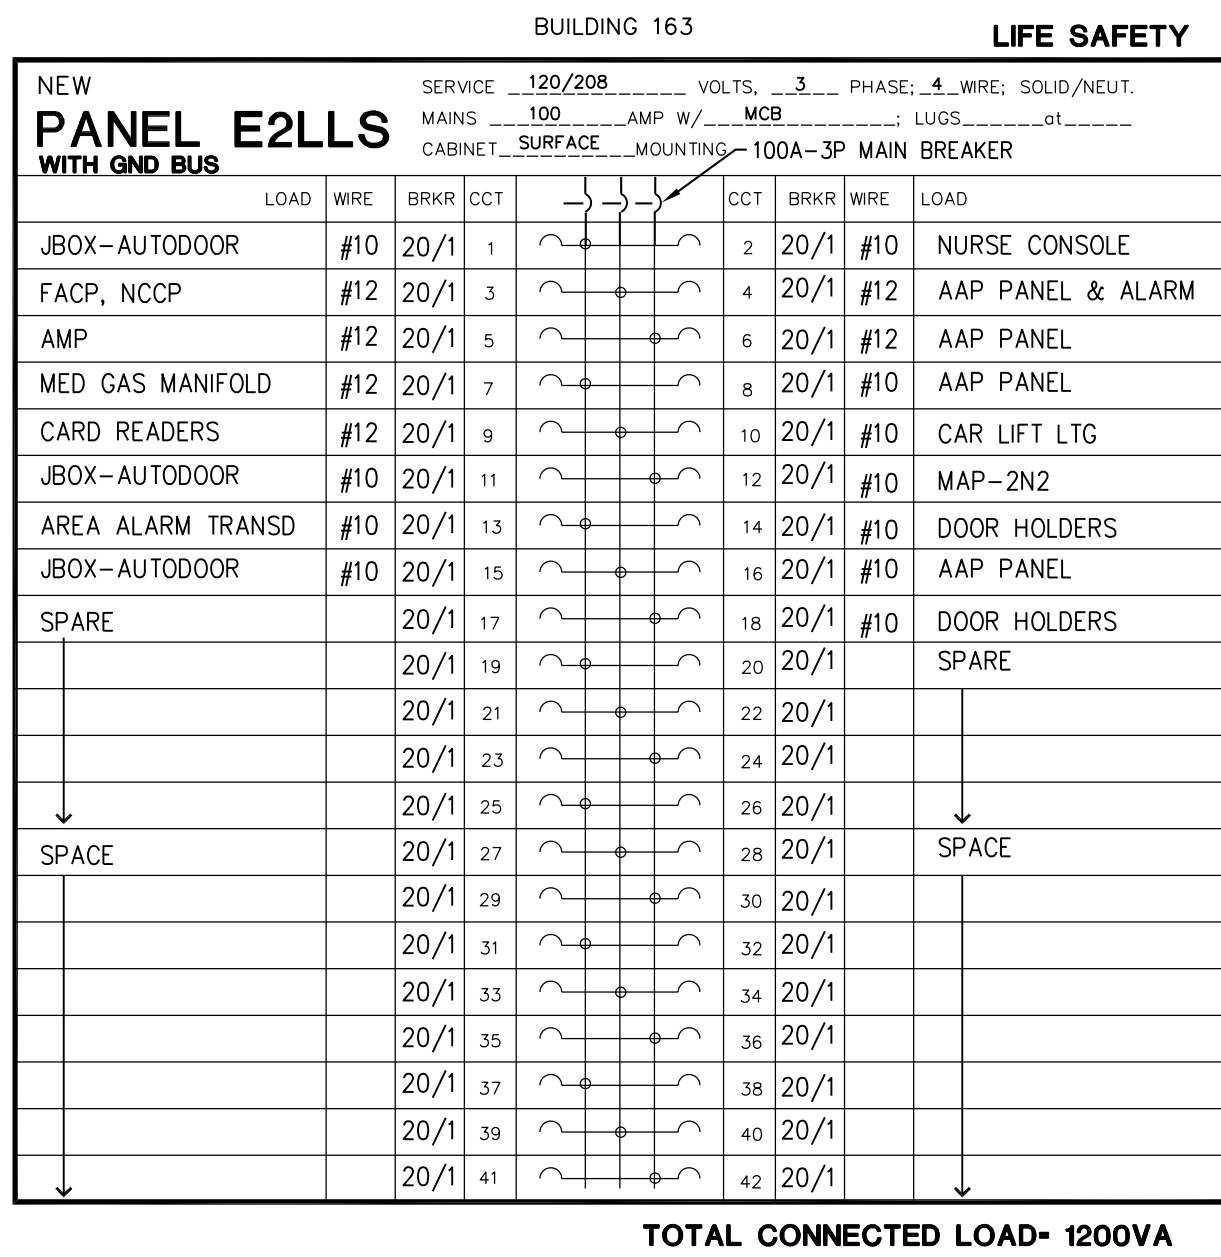
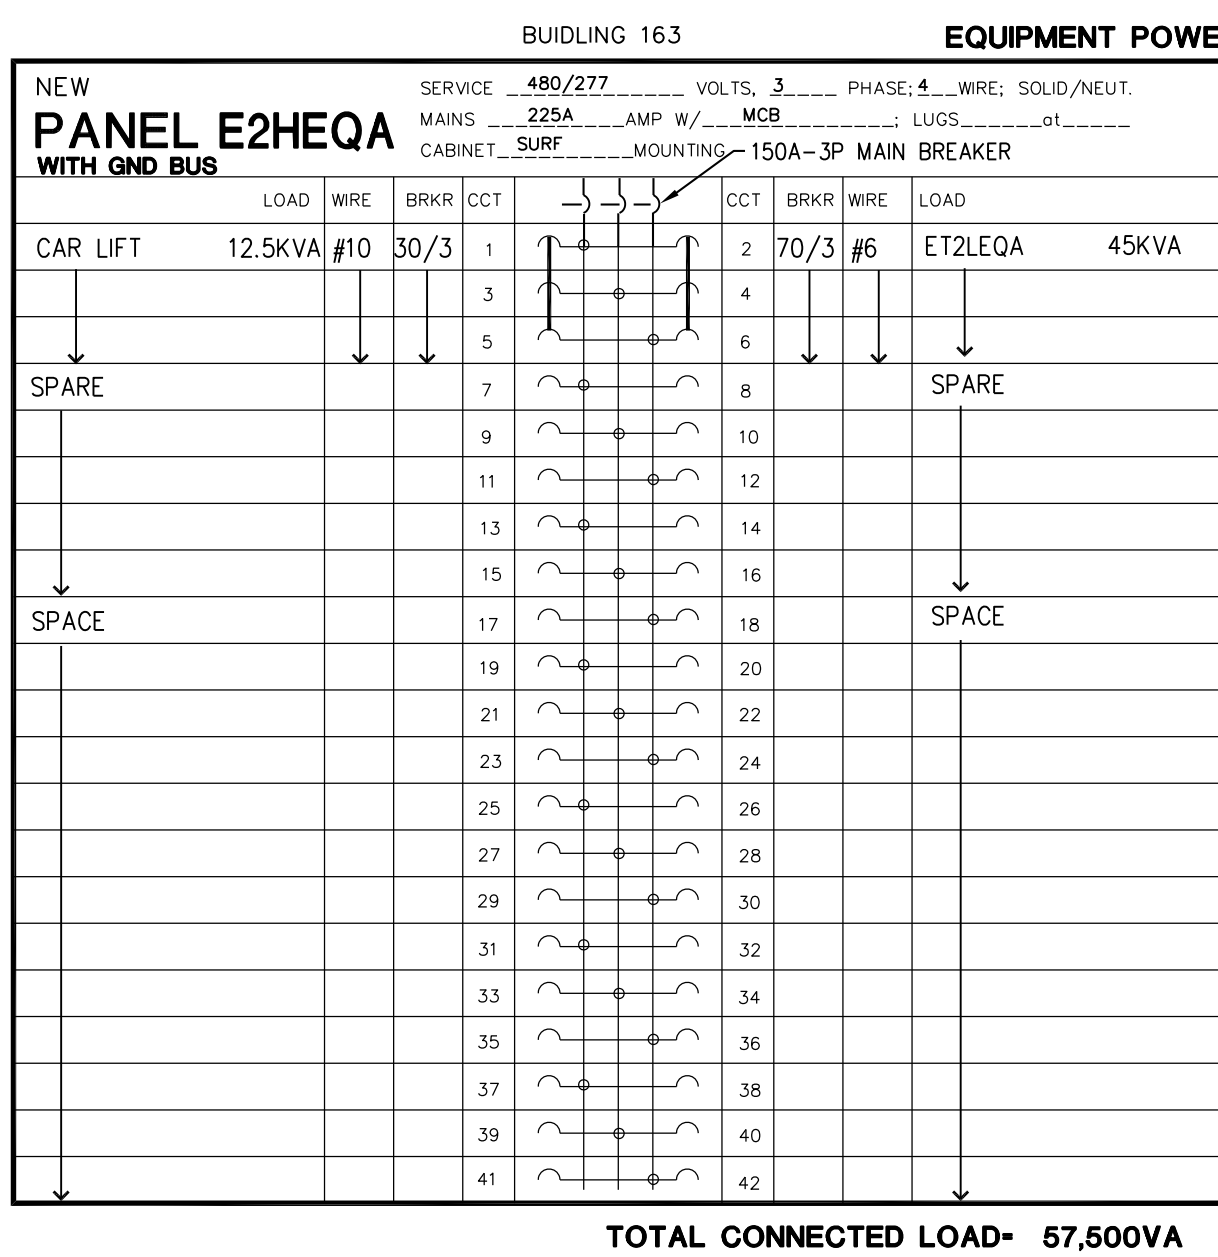
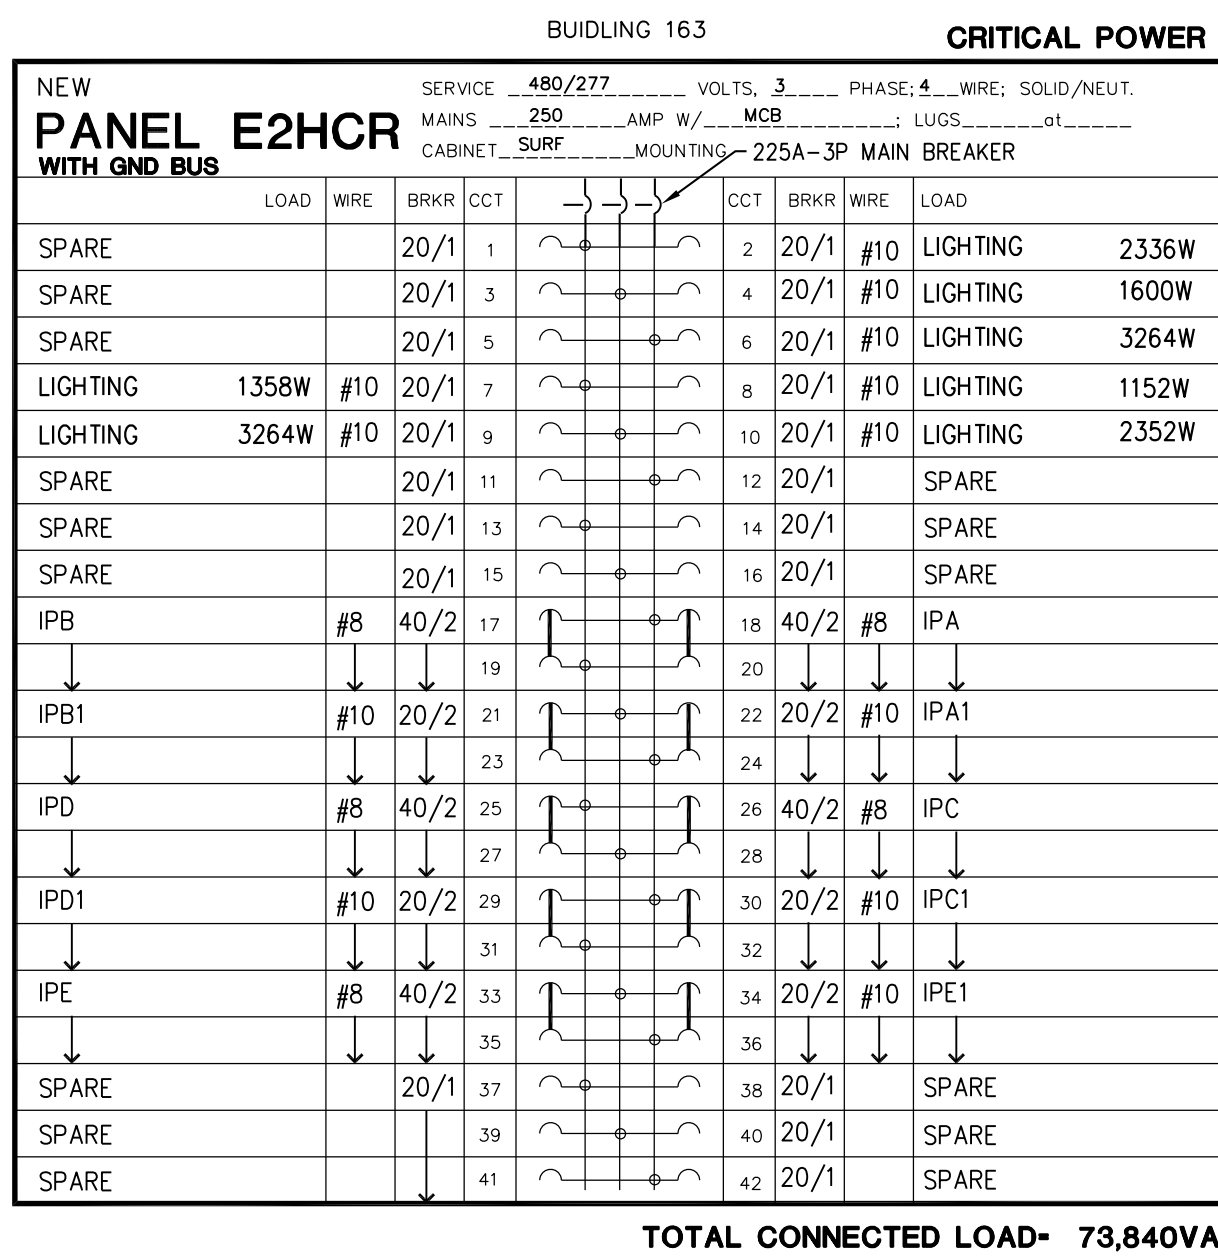
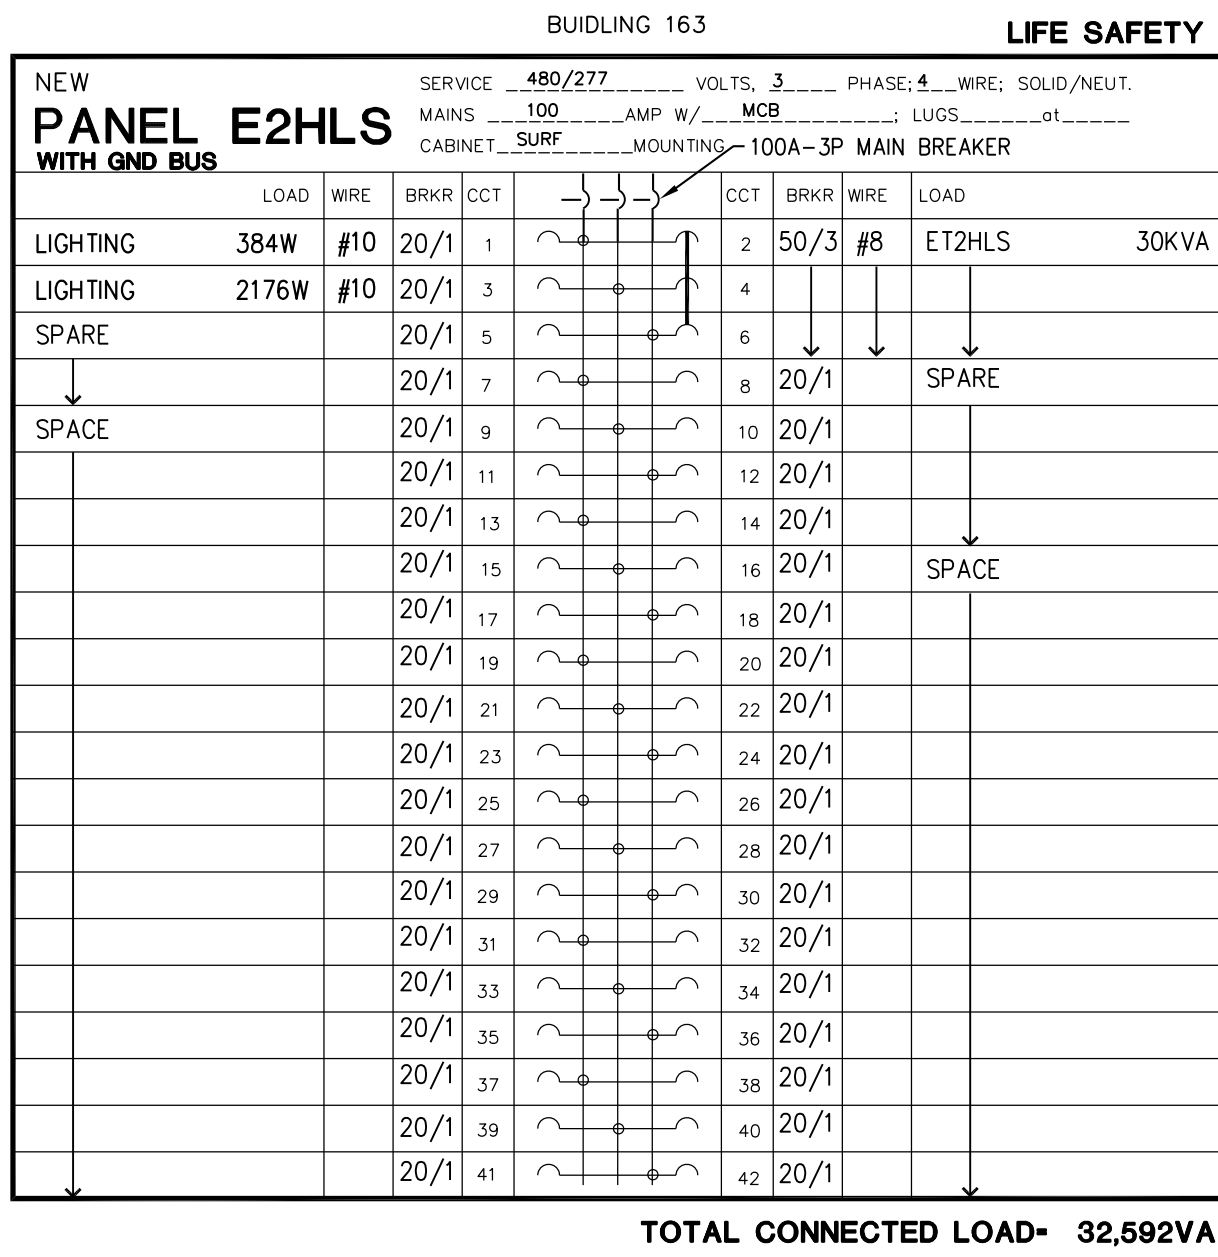
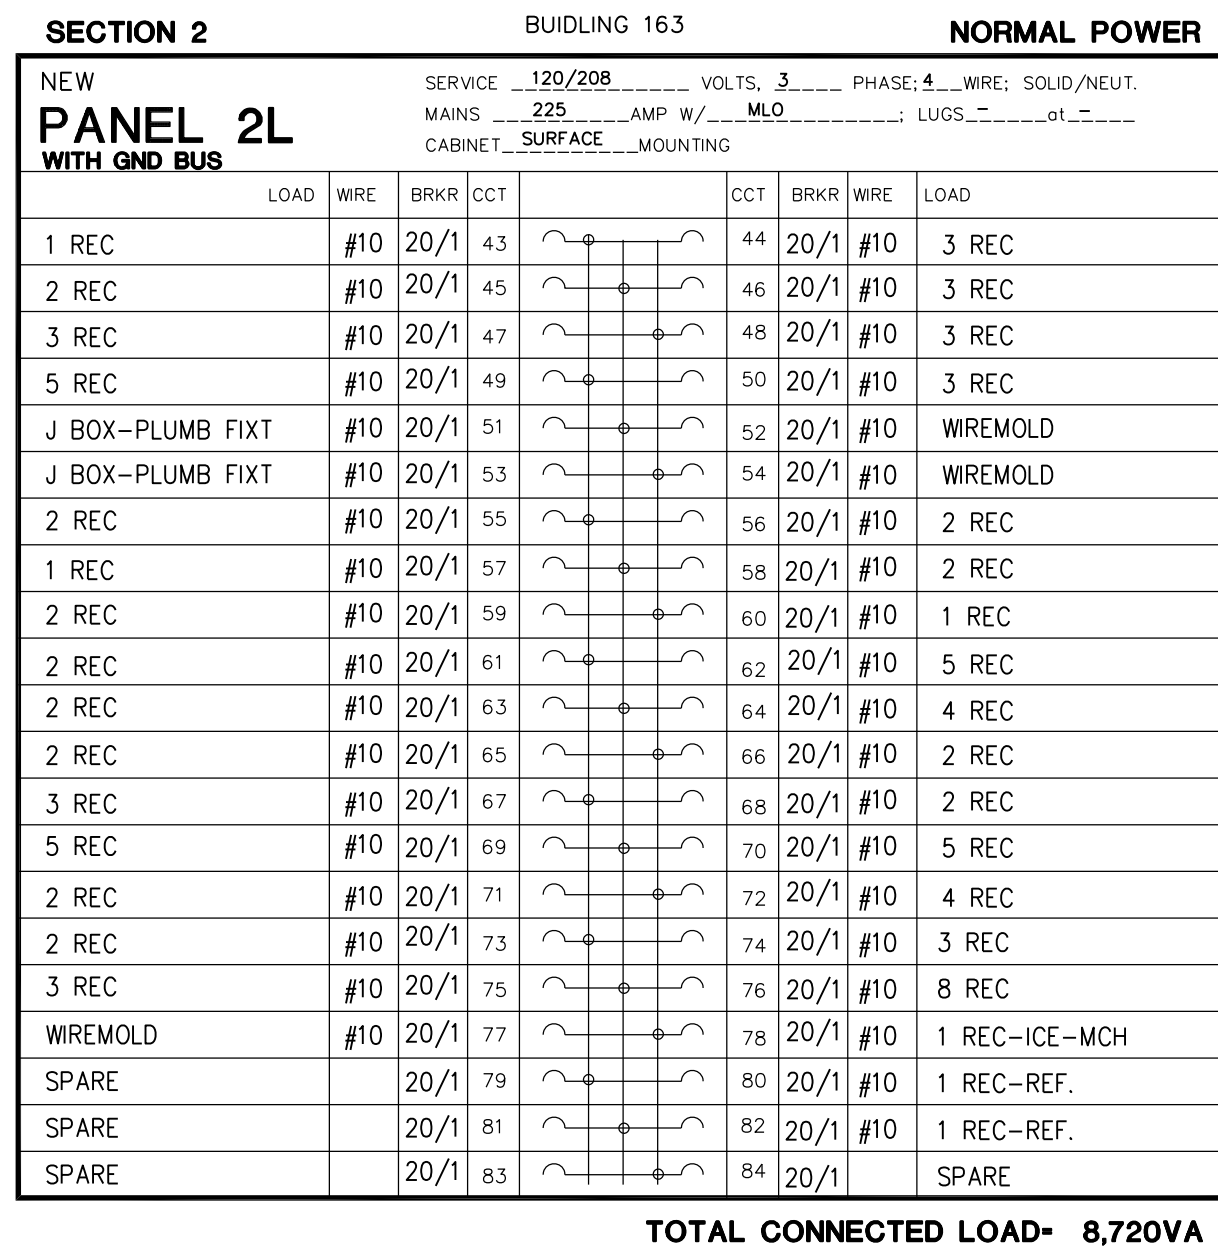
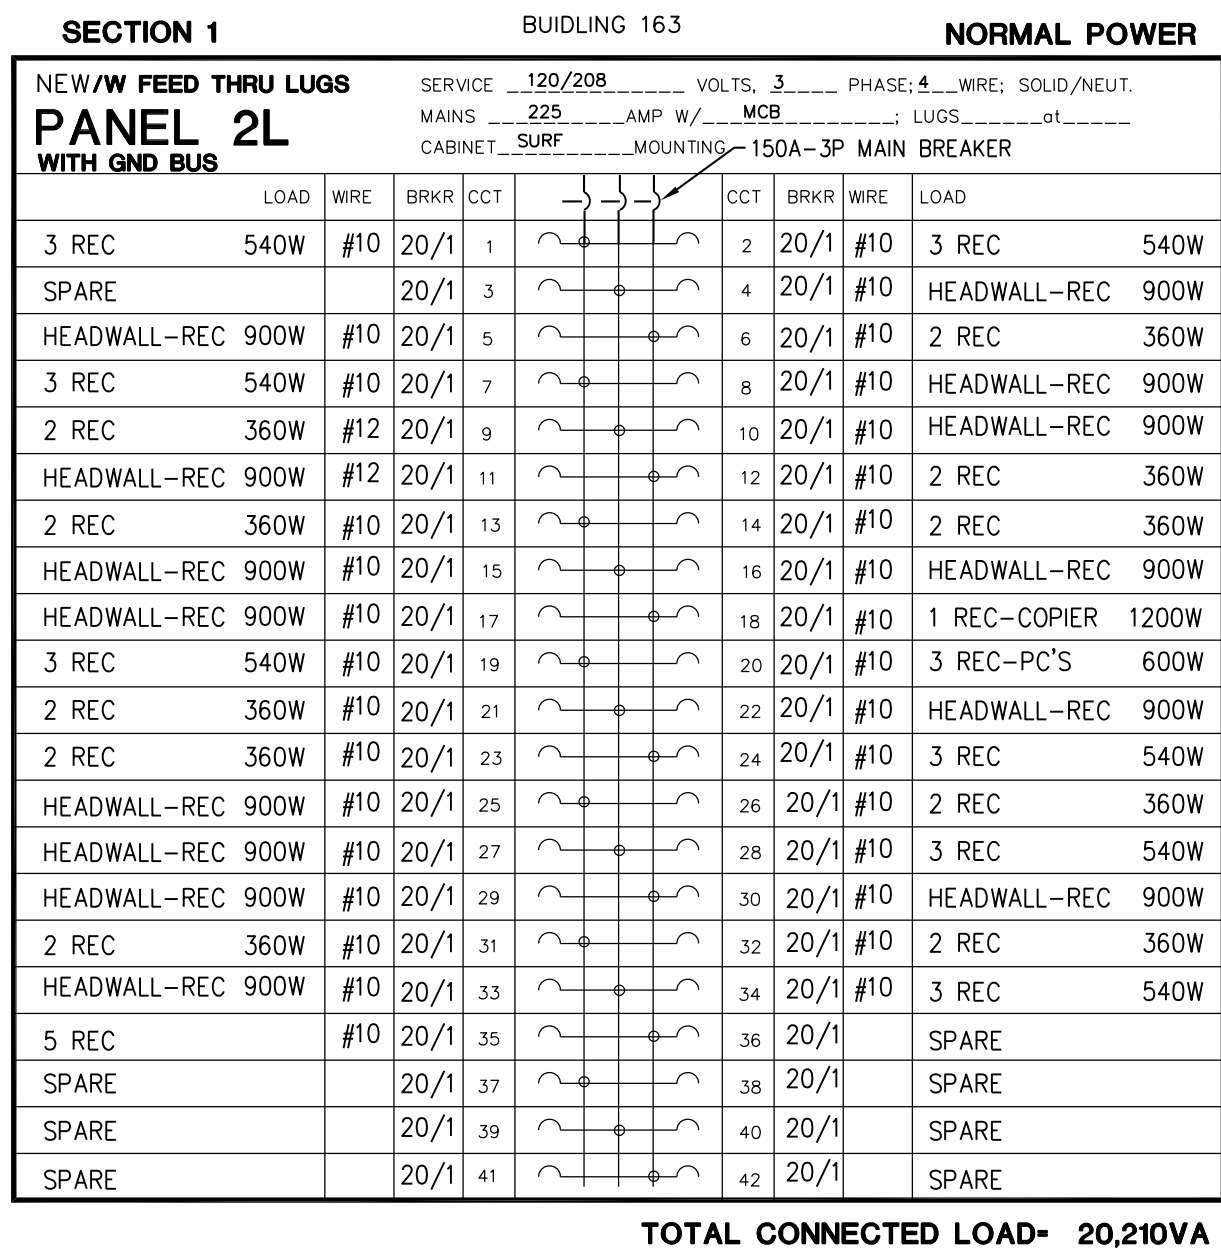
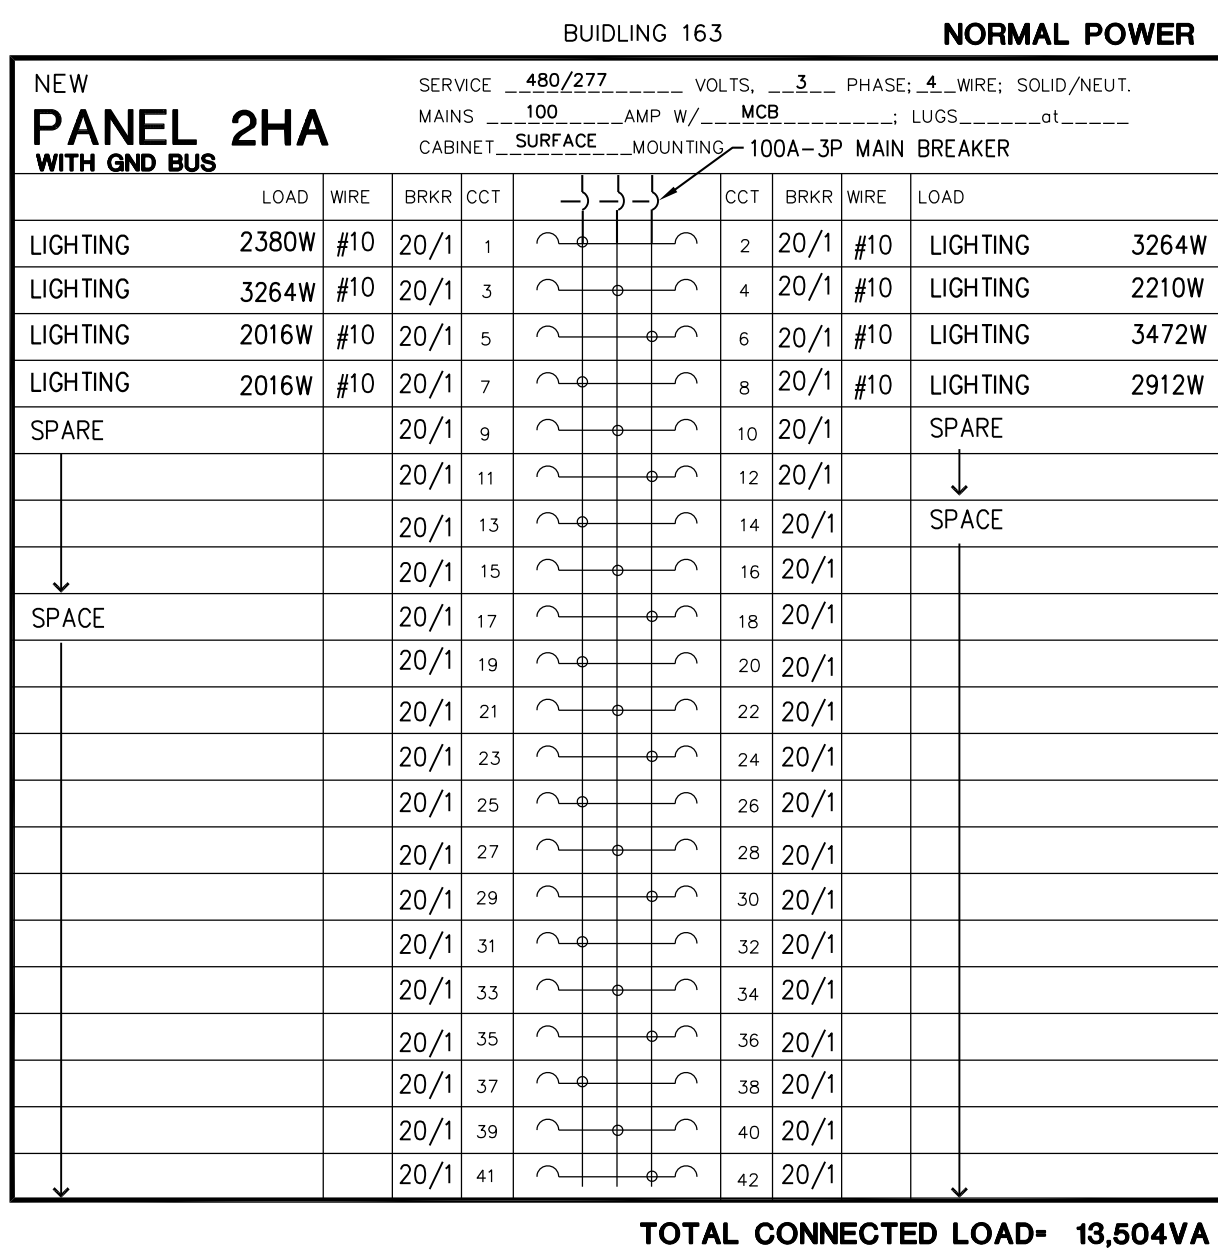


- ① WIRE AND CONNECT TO EMERGENCY (LIFE SAFETY BRANCH) 277 VOLT NON SWITCHED LIGHTING CIRCUIT IN THIS AREA. LIGHTING CIRCUIT NOT TO EXCEED 3800W PER 20A-1P CIRCUIT BREAKER
- ② #12 GND, 2 #12, 3/4" STAIR LIGHTING FOR CONDUIT RISER.
- ③ WIRE AND CONNECT TO EXISTING EMERGENCY (CRITICAL BRANCH) 277 VOLT LIGHTING CIRCUIT IN THIS AREA. LIGHTING CIRCUIT NOT TO EXCEED 3800W PER 20A-1P CIRCUIT BREAKER.
- ④ WIRE AND CONNECT TO EXISTING NORMAL 277 VOLT LIGHTING CIRCUIT IN THIS AREA. LIGHTING CIRCUIT NOT TO EXCEED 3800W PER 20A-1P CIRCUIT BREAKER.
- ⑤ NO WORK IN AREA IF DEDUCT ALTERNATE NOTED IS ACCEPTED.

Department of

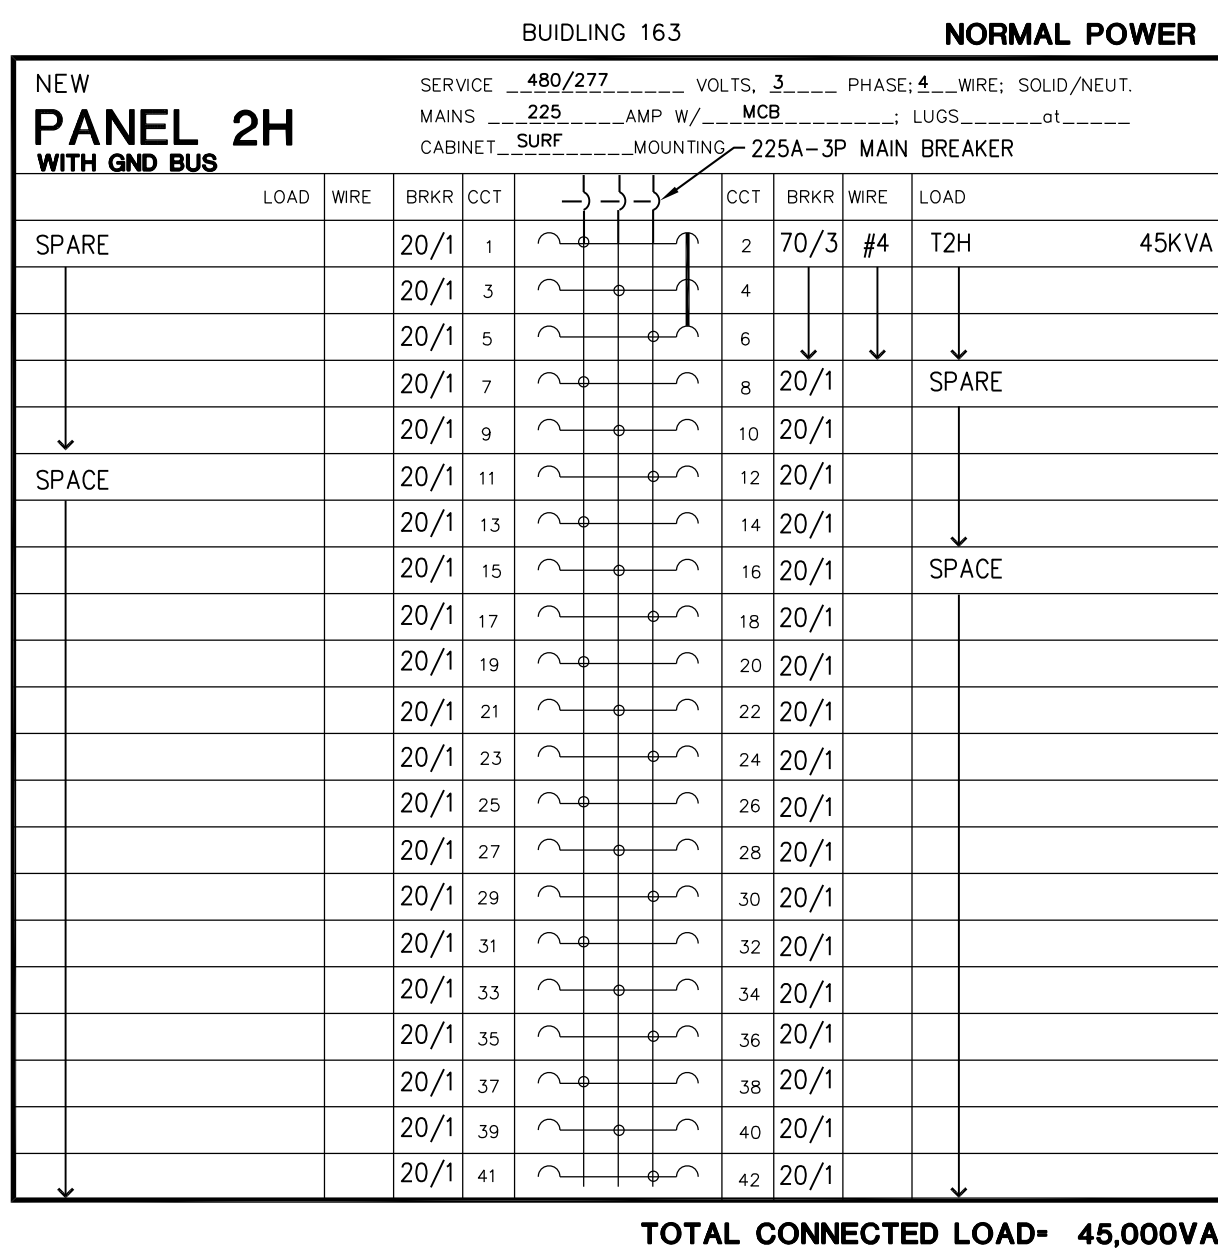

ELECTRICAL PANEL SCHEDULES


SCALE: NOT TO SCALE

BLD: 163

CONSULTANTS :

ARCHITECT / ENGINEERS :

WILSON ARCHITECTURAL GROUP
505 WESTMEIER SUITE 200 HOUSTON, TEXAS 77058
BURNS DeLATTÉ AND MCCOY, INC.
PINNACLE STRUCTURAL
BREWER AND ESCALANTE
PROTECTION DEVELOPMENT INC.
FIRE PROTECTION ENGINEERS

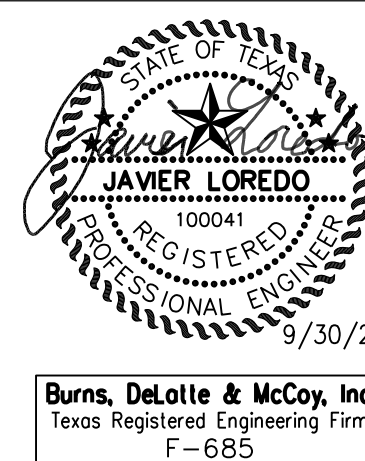

Drawing Title :
PANEL SCHEDULES
NO SCALE
Approved Project Director :

AMENDMENT NO. 01
Project Title :
BLDG 163 SURGERY SUITE ADDITION
Bldg No. : 163
Checked : JL
Drawn : JL
Location : TEMPLE, TEXAS
Date : 09-30-15
Project No. : 674-277
Drawing No. : ES7.01
Dwg. of

