

1. REFER TO SHEET M1.1 FOR GENERAL MECHANICAL NOTES THAT SHALL APPLY TO ALL SHEETS IN THIS SET UNLESS NOTED OTHERWISE IN THE KEYED NOTES.
2. ALL EXISTING DUCTWORK, PIPING SIZES & LOCATIONS ARE TAKEN FROM AVAILABLE RECORD DOCUMENTS & SITE OBSERVATIONS. CONTRACTOR SHALL FIELD VERIFY ALL EXISTING CONDITIONS PRIOR TO CONSTRUCTION.


1. TAP 6" CHS AND CHR TO EXISTING 6" BRANCH LINES PREVIOUSLY SERVING BUILDING 162 CHW LOOP.
2. DISCONNECT ABANDONED CHW PIPING PREVIOUSLY SERVING BUILDING 162 AND CAP PIPES TO REMAIN IN SERVICE.
3. 6" CHS AND 6" CHR DOWN.
4. 6" CHS AND CHR TO MECHANICAL ROOM BD111; RISE AND RUN PARALLEL TO EX. 4" CHS AND CHR. CORE THRU WALL WHERE NEEDED. PROVIDE SLEEVES AT WALL PENETRATIONS, SEAL AND CAULK SPACE AROUND PIPING.
5. 6" CHS AND CHR DOWN TO PIPE SPACE. CORE THRU WALL WHERE NEEDED. PROVIDE SLEEVES AT WALL PENETRATIONS, SEAL AND CAULK SPACE AROUND PIPING.
6. SEE SHEET M4.3 FOR CONTINUATION.

--- EXISTING TO REMAIN
 _____ NEW WORK

FOR INFORMATION ONLY

1 CENTRAL PLANT MECHANICAL PLAN

SCALE: 1/4" = 1'-0"

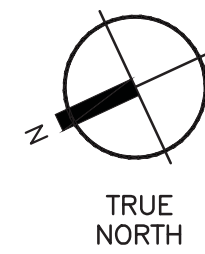[illegible]

CONSULTING ENGINEER:



O'CONNELL ROBERTSON

Austin 811 Barton Springs Road, Suite 900, Austin, Texas 78704 p: 512.478.7286 f: 512.478.7441
San Antonio 4040 Broadway, Suite 200, San Antonio, Texas 78209 p: 210.224.6032 f: 210.224.6453



ENGINEERING FIRM:
O'CONNELL ROBERTSON
FIRM REGISTRATION NO. F-2708

OR PROJECT NO. 0917.06


ARCHITECT:




Architectural Edge Inc.

3010 Scott Blvd. Suite 102 Temple, Texas 76504
254.771.2054 P 254.773.2144 F

ISSUED FOR INFORMATION ONLY TO VA PROJECT NO. 674-277 AMENDMENT NO. 01 9-29-15 **FULLY SPRINKLERED**

Drawing Title CENTRAL PLANT MECHANICAL PLAN		Project Title URGENT CARE - TEMPLE		Project Number 674-276	Office of Construction and Facilities Management
				Building Number 163	
Approved: Project Director Victor Gaw		Location TEMPLE VAMC		Drawing Number <div style="border: 2px solid black; border-radius: 15px; padding: 5px; text-align: center;"> 163-M4.4 </div>	 Department of Veterans Affairs
		Date 02/15/13	Checked 	Drawn 	

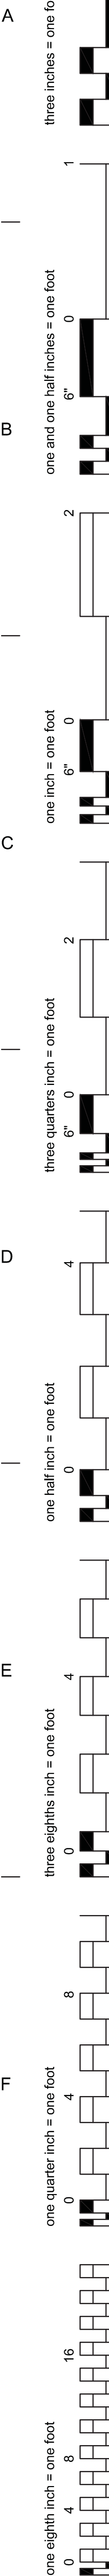

2 STEAM AND HEATING WATER RISER DIAGRAMS



----- EXISTING TO REMAIN
 _____ NEW WORK

CONSULTING ENGINEER:

Drawn

Department of
Veterans Affairs