



Drawing File: \\VA301A\5317-Correct Facility Life Safety Deficiencies\Drawings\5317 FP107.dwg
Plotted by: mcmrwell
Plotted Date: Sep 04, 2014 - 2:35pm


one-eighth inch = one foot
one-quarter inch = one foot
three-eighths inch = one foot
one-half inch = one foot
three-quarters inch = one foot
one inch = one foot
one and one-half inches = one foot
three inches = one foot

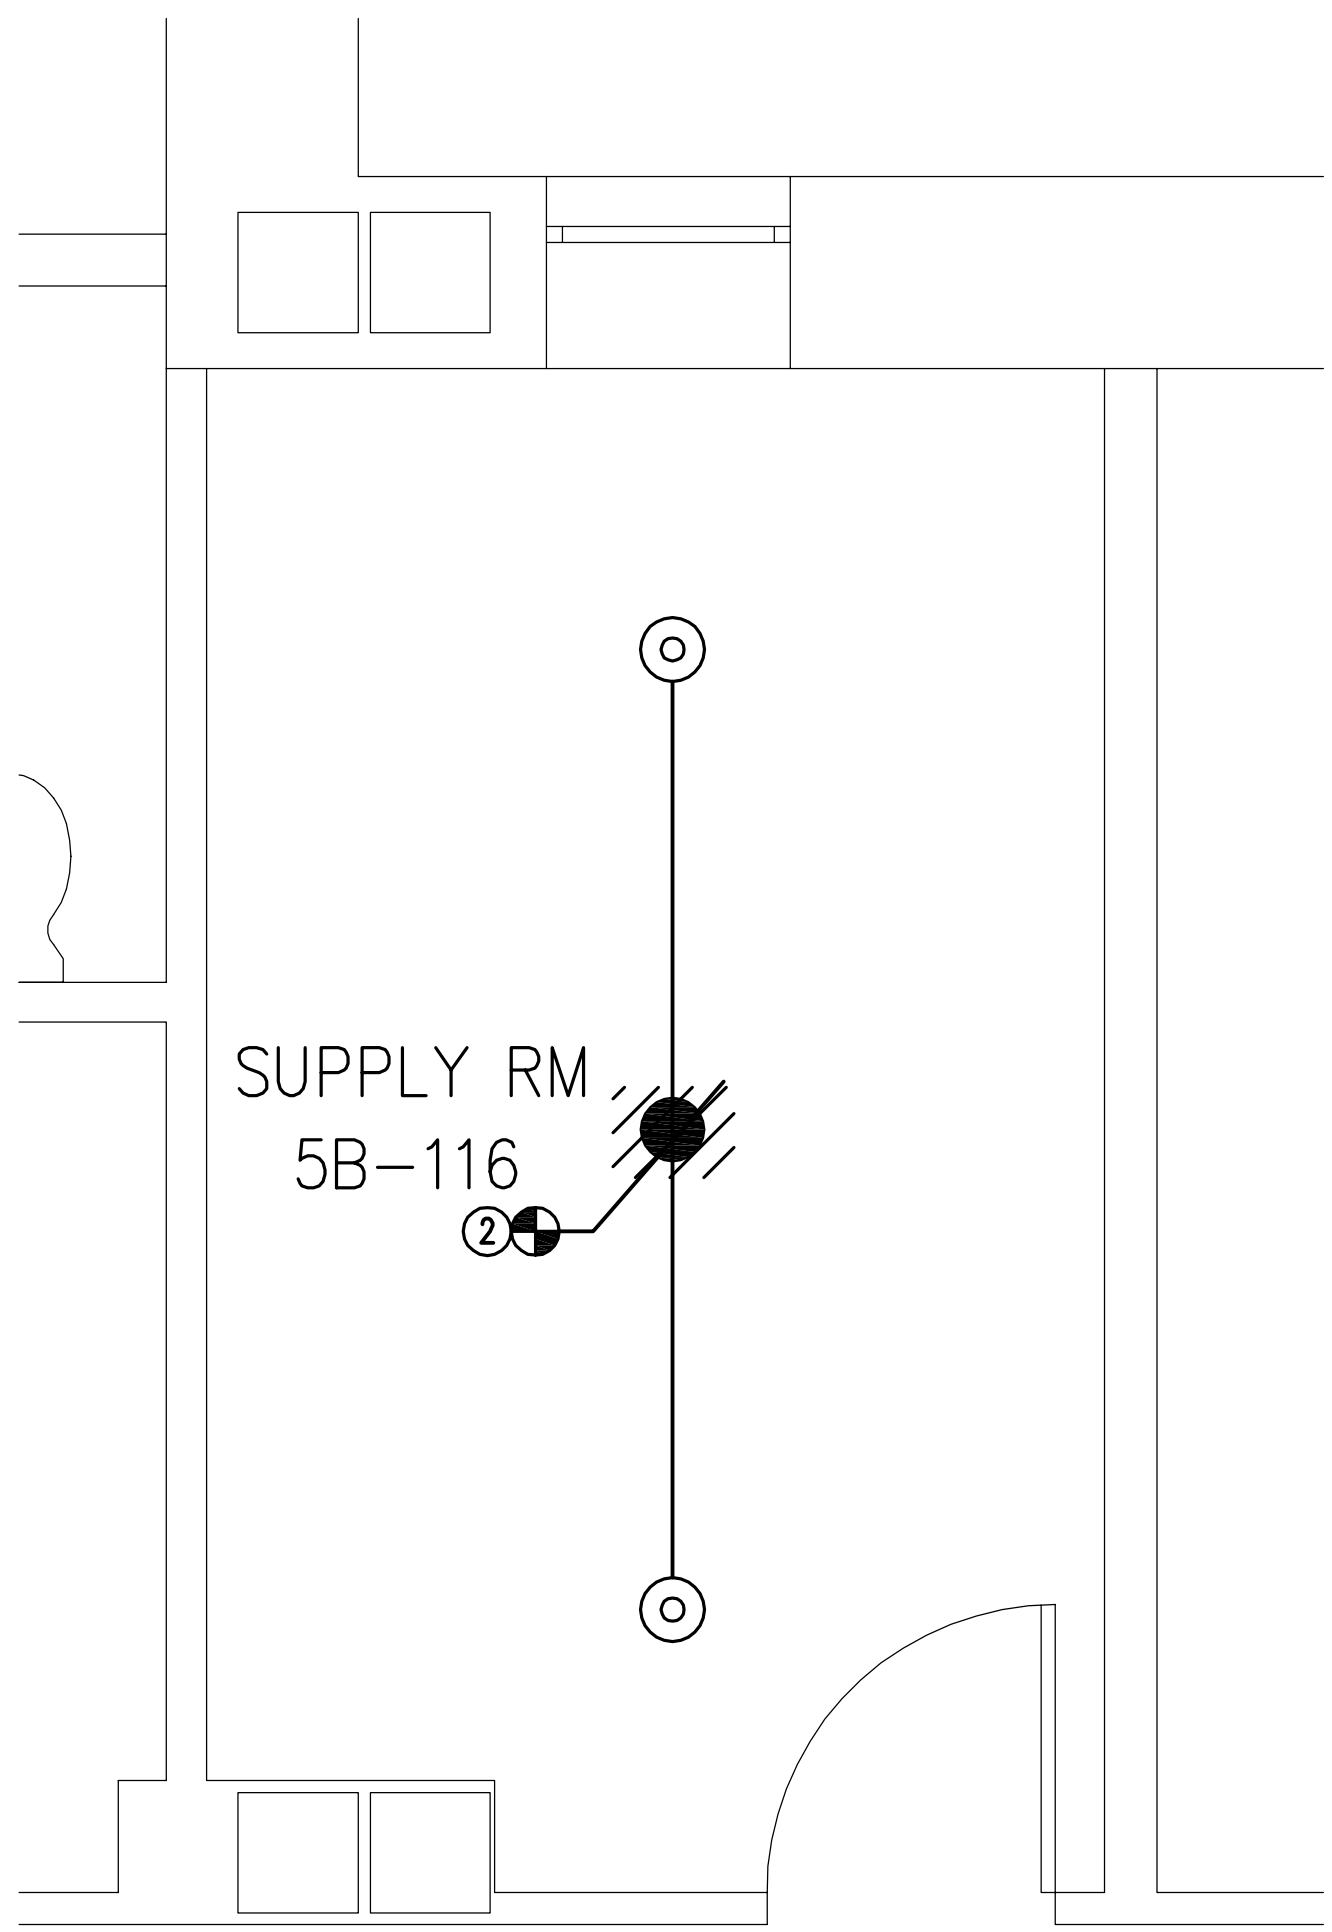


ROOM 5B-116 - FIRE PROTECTION
SCALE: 1/2" = 1'-0"

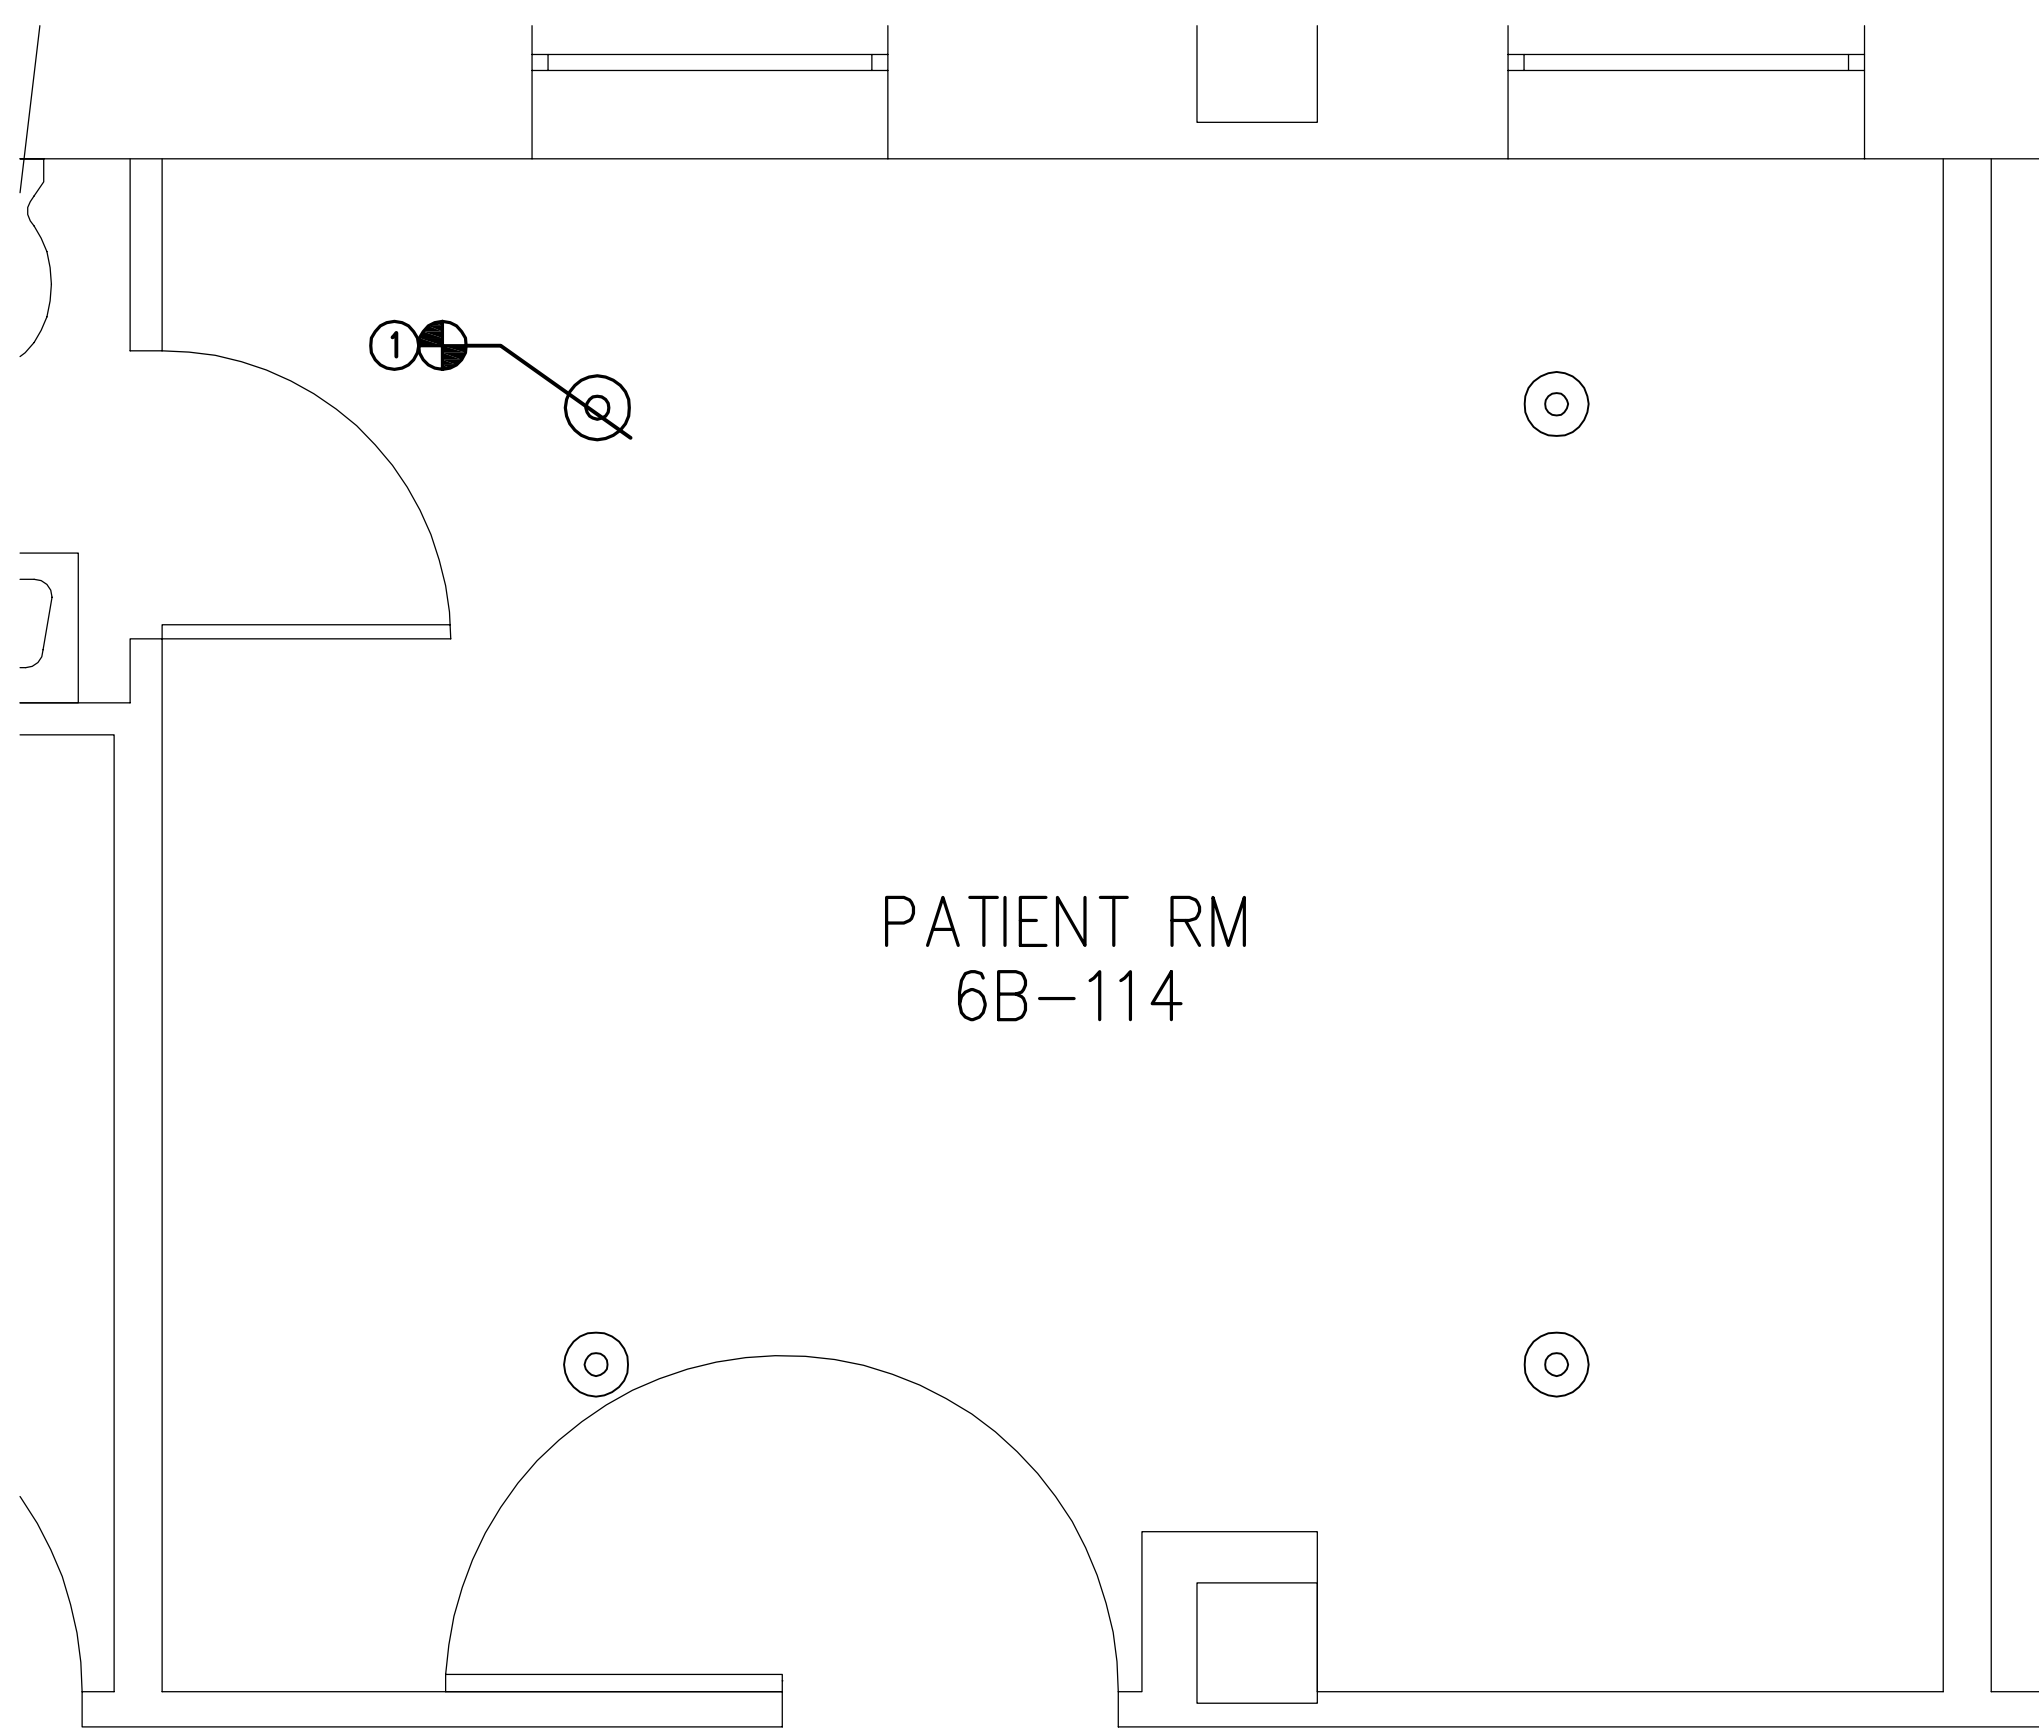


ROOM 6B-114 - FIRE PROTECTION
SCALE: 1/2" = 1'-0"

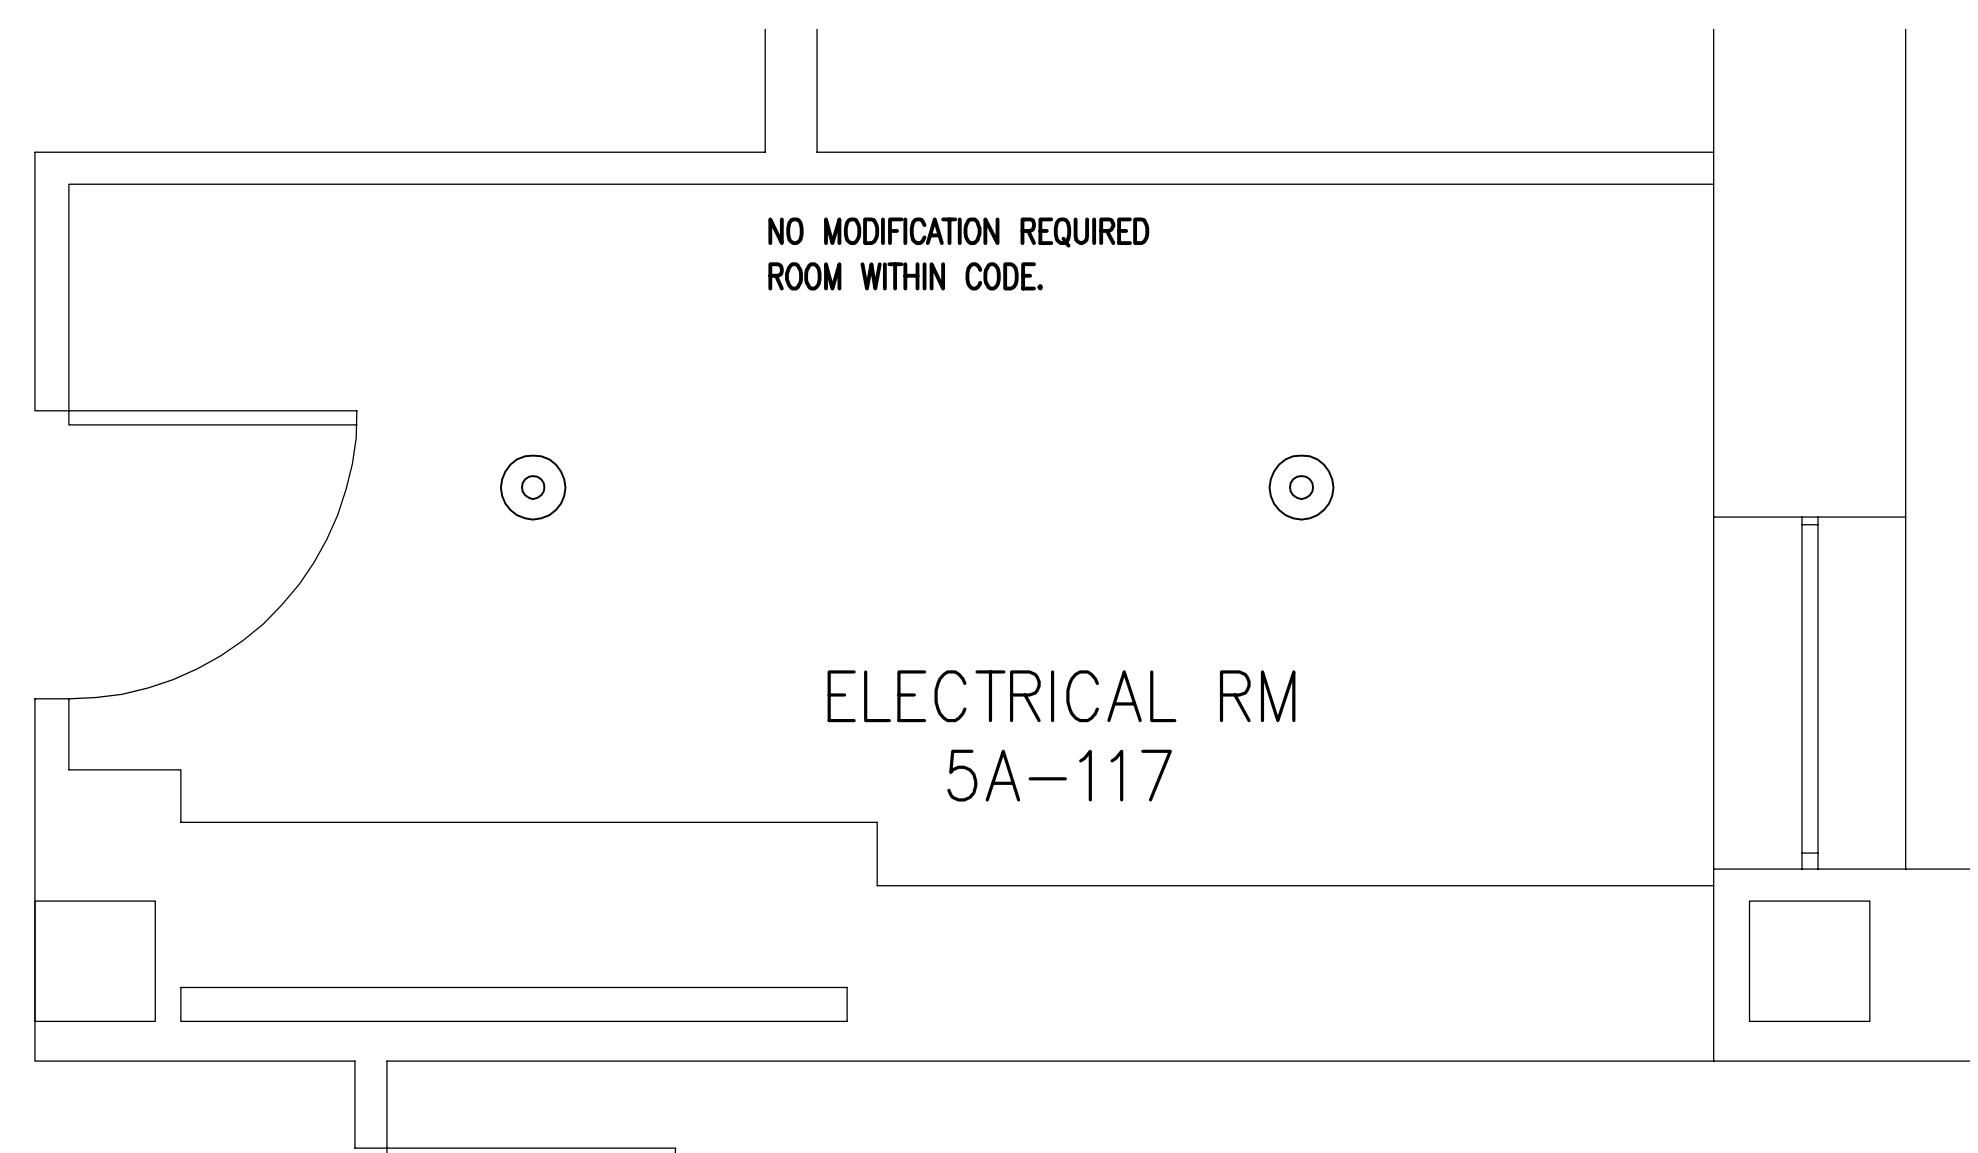


ROOM 5A-117 - FIRE PROTECTION
SCALE: 1/2" = 1'-0"

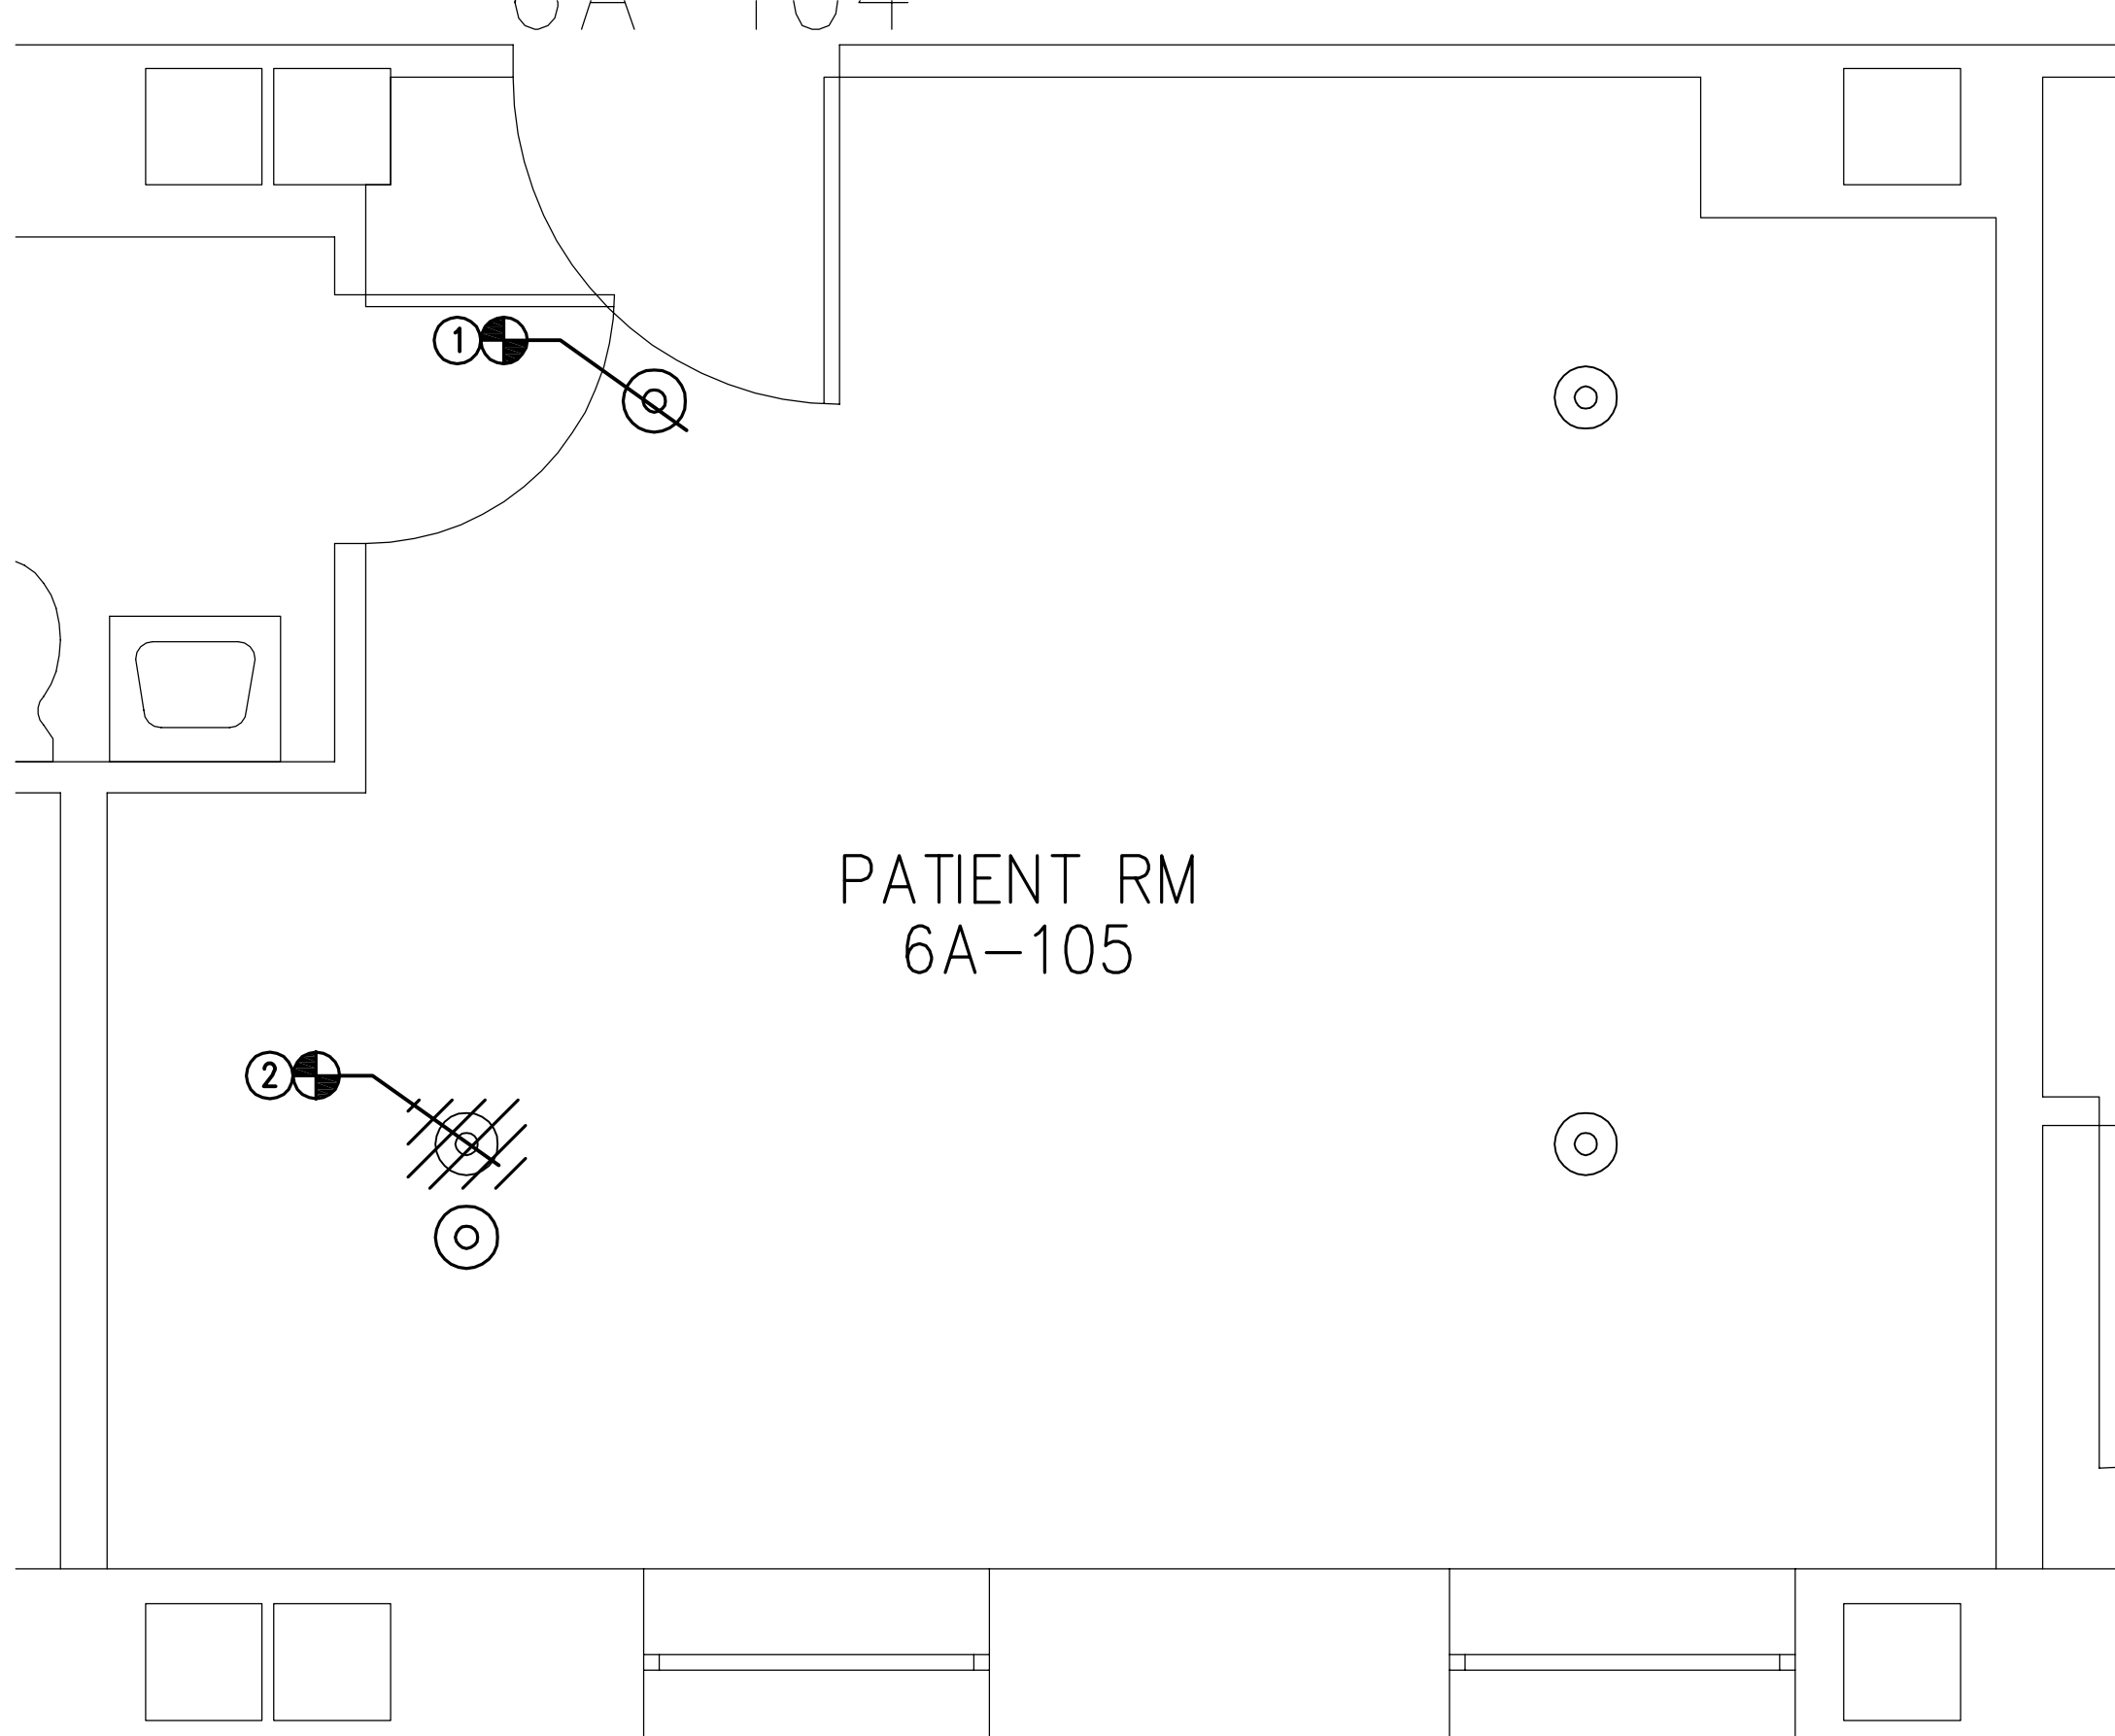

ROOM 6A-105 - FIRE PROTECTION
SCALE: 1/2" = 1'-0"

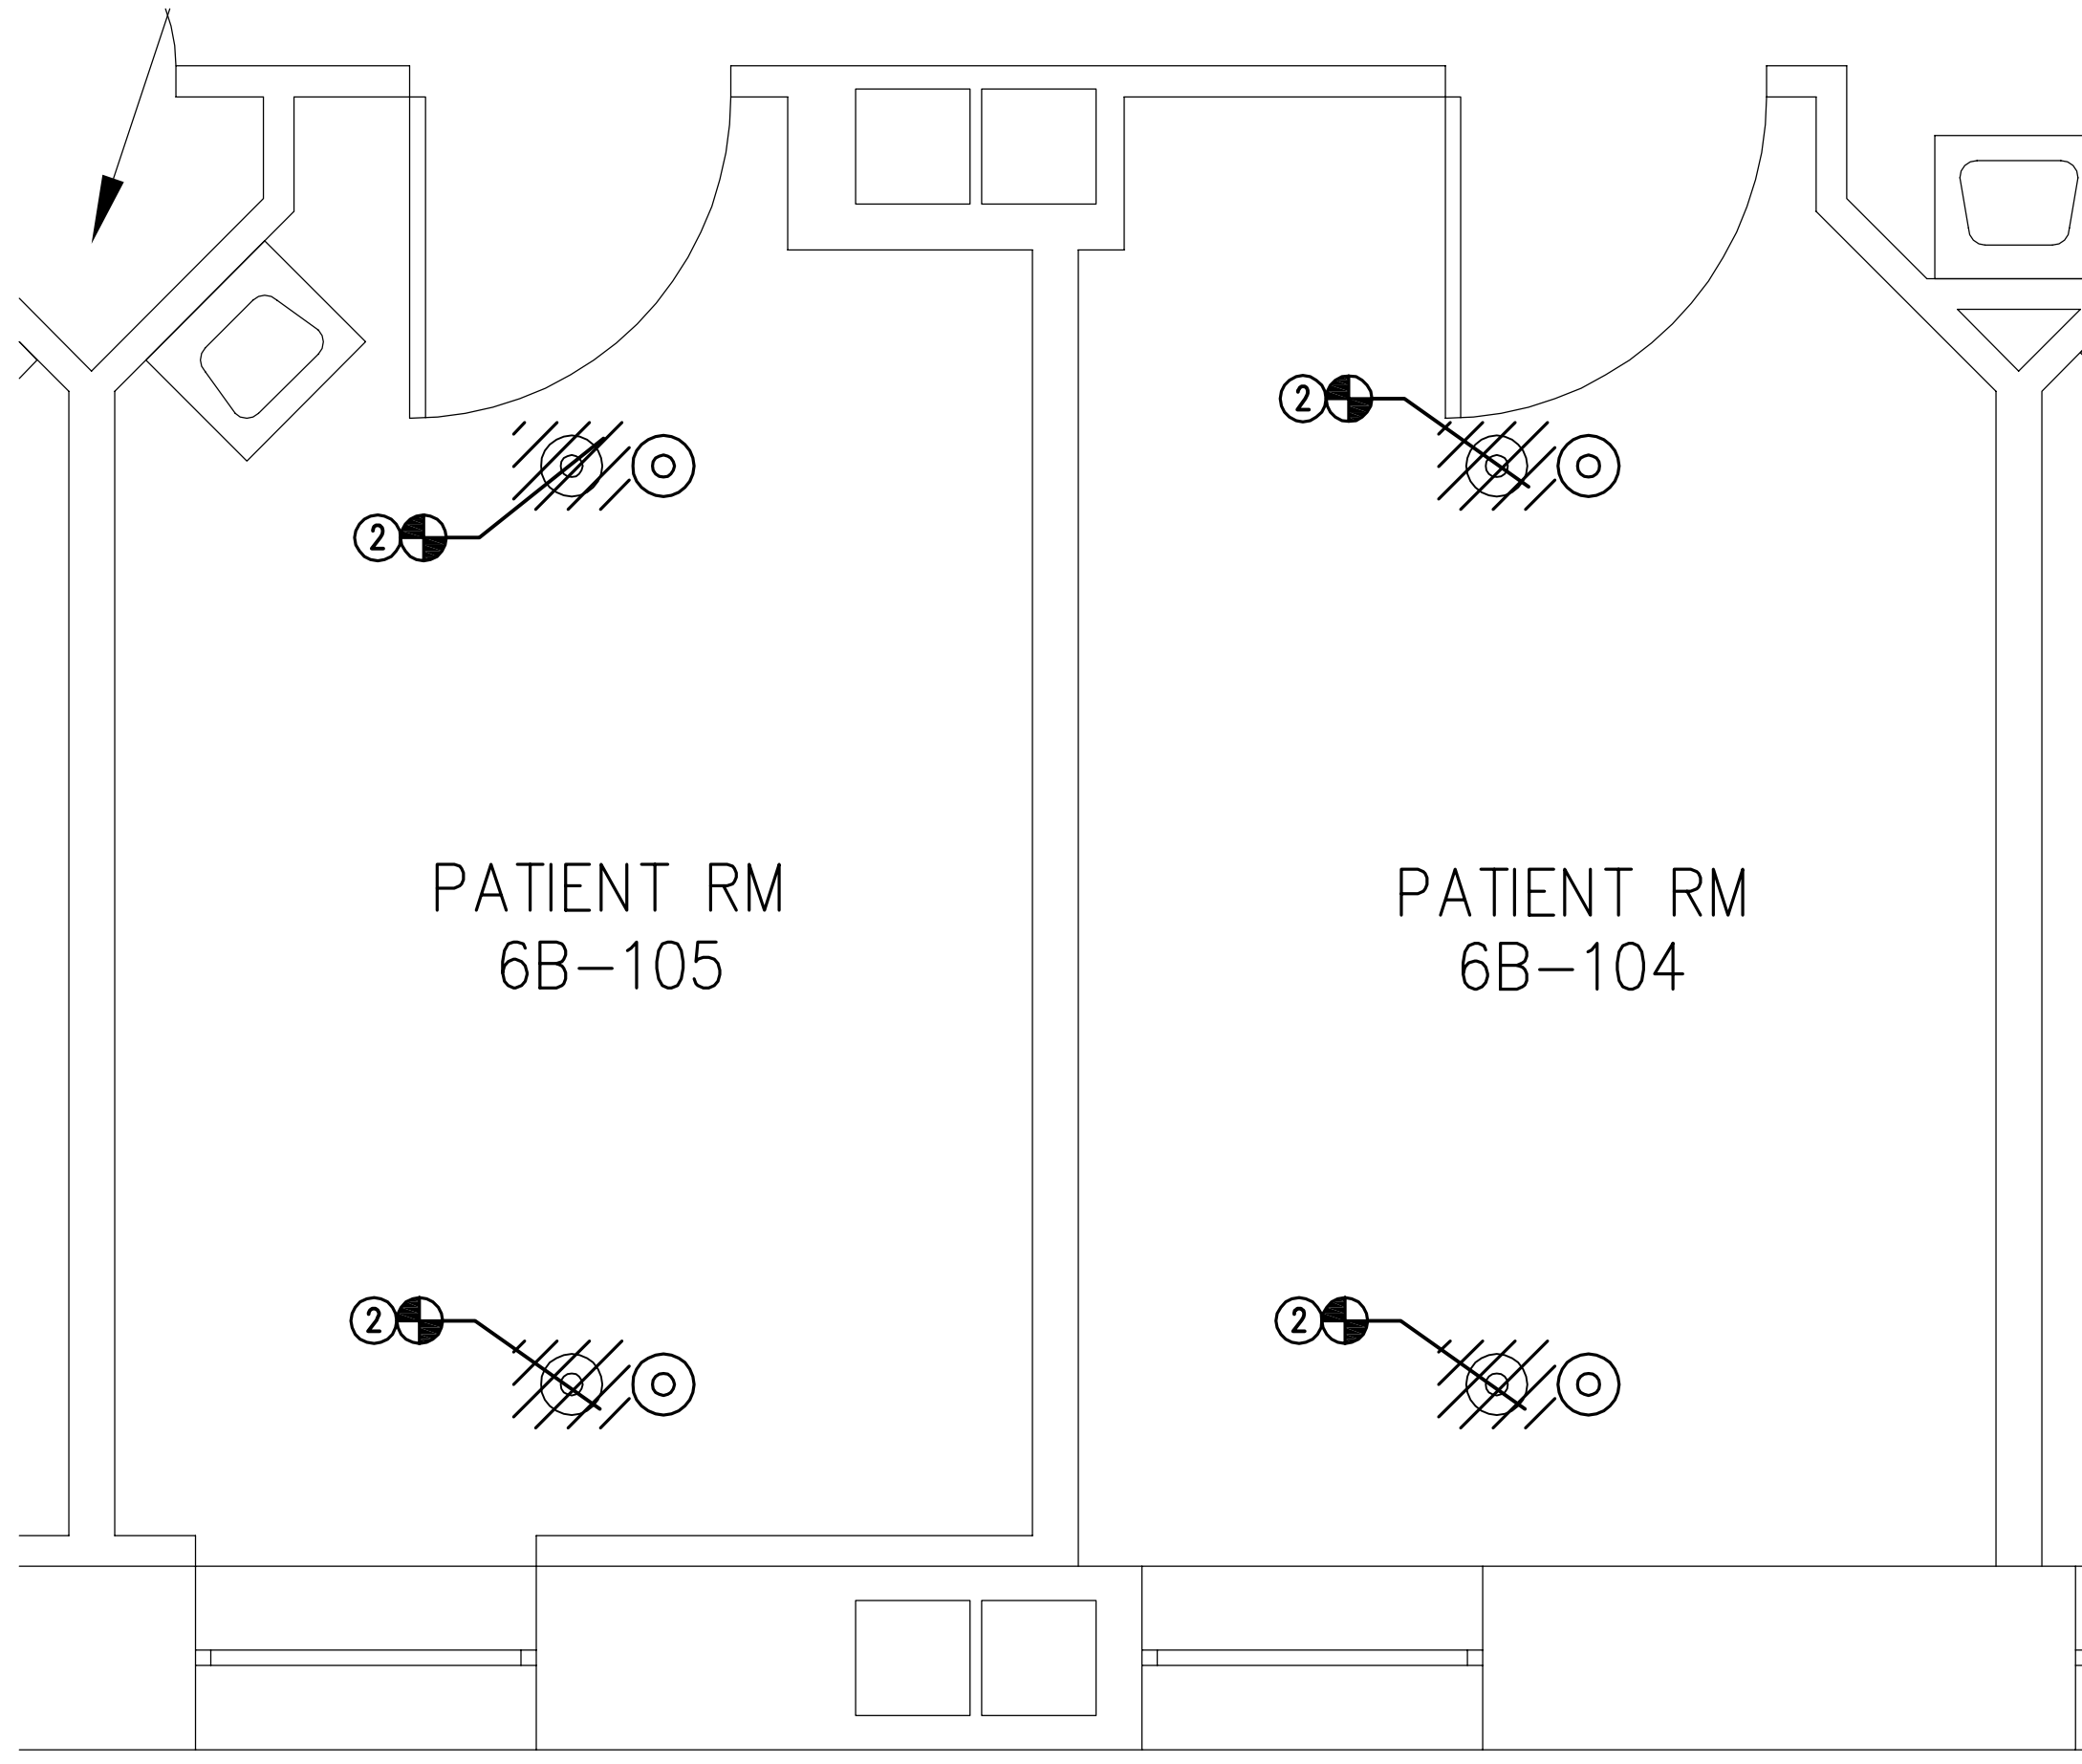


ROOMS 6B-104 & 6B-105 - FIRE PROTECTION
SCALE: 1/2" = 1'-0"

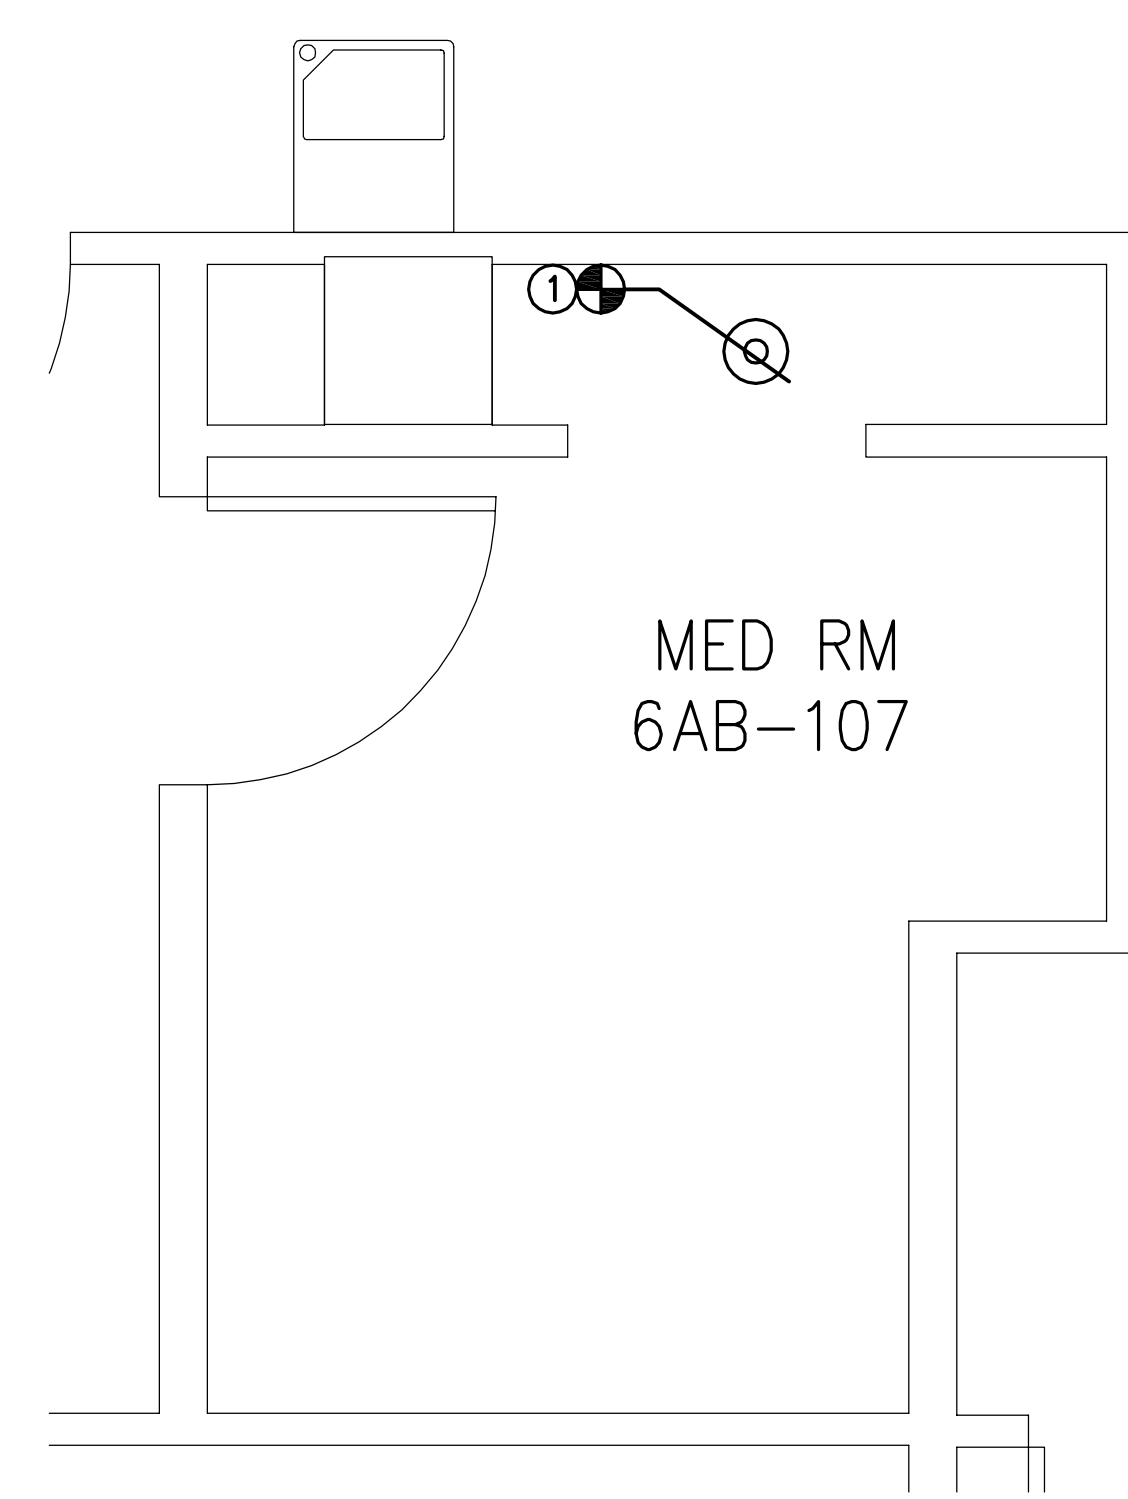


ROOM 6AB-107 - FIRE PROTECTION
SCALE: 1/2" = 1'-0"

- NOTES:**
(THIS SHEET ONLY)
- CONNECT TO NEAREST EXISTING SPRINKLER PIPING AND ADD A PENDENT SPRINKLER HEAD TO PROVIDE COVERAGE IN ACCORDANCE WITH NFPA 13.
 - REMOVE EXISTING PENDENT SPRINKLER HEAD AND RELOCATE APPROXIMATELY 12 INCHES FROM ADJACENT EQUIPMENT TRACK MOUNTED IN CEILING
 - REMOVE EXISTING PENDENT SPRINKLER HEAD AND ROUTE PIPE TO NEW HEAD LOCATIONS. HEADS SHALL BE INSTALLED IN ACCORDANCE WITH NFPA 13.

- GENERAL NOTES:**
(THIS SHEET ONLY)
- ALL MATERIALS AND EQUIPMENT USED ON THIS PROJECT SHALL BE UL LISTED AND FM APPROVED.
 - EXISTING PIPING IS THREADED SCHEDULE 40 BLACK STEEL PIPE. NEW PIPING SHALL MATCH EXISTING.
 - EXISTING PIPING WILL BE PERMITTED TO BE REUSED BUT FITTINGS AND HEADS SHALL BE NEW.
 - ALL PIPING AND EQUIPMENT INSTALLED ON THIS PROJECT SHALL BE INSTALLED IN ACCORDANCE WITH NFPA 13 AND VA FIRE PROTECTION DESIGN GUIDE.
 - ALL NEW PENDENT HEADS INSTALLED SHALL BE ON A RETURN BEND CONFIGURATION.

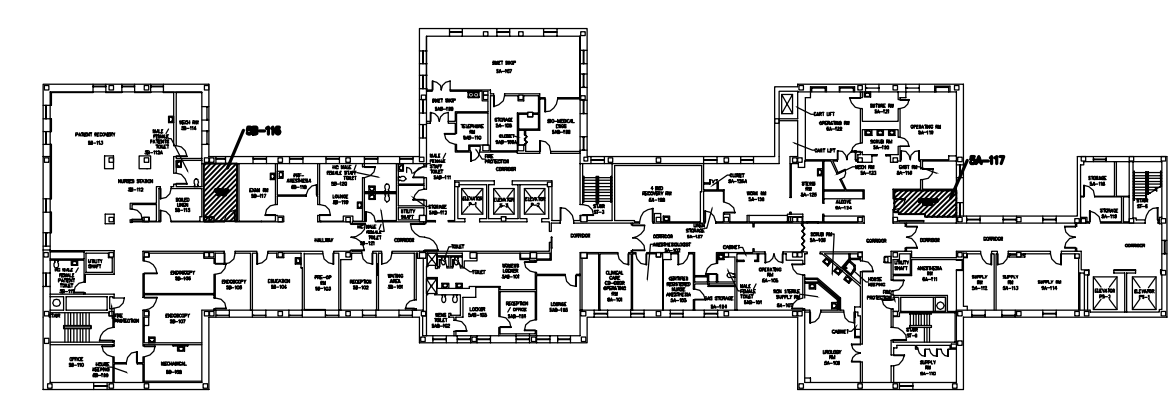

FIFTH FLOOR KEY PLAN
SCALE: NTS

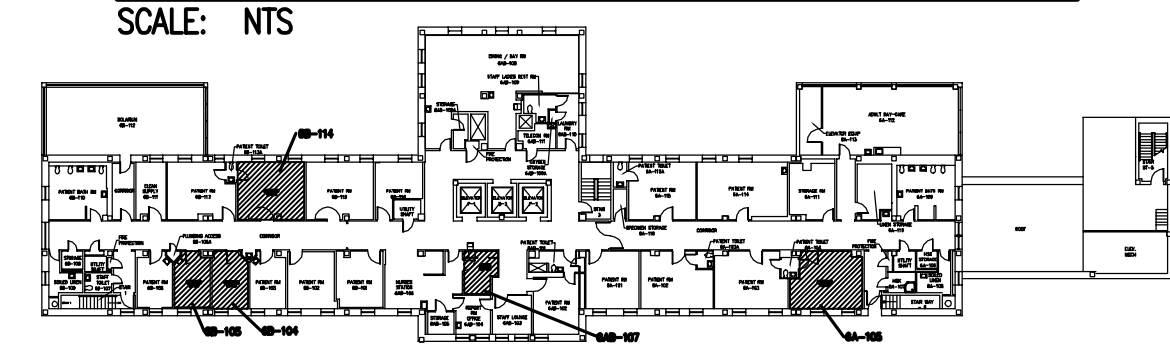


SIXTH FLOOR KEY PLAN
SCALE: NTS

Revisions	Date



CORPORATE OFFICE
590 Means St. NW, Ste. 200
Atlanta, GA 30318
404.214.9774

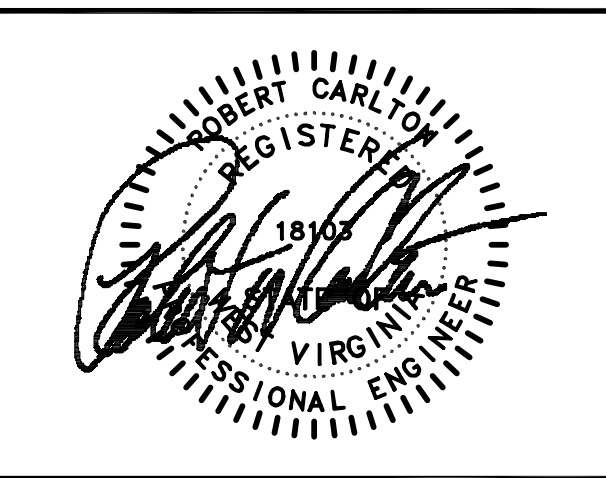

CLARK•NEXSEN

440 MARTIN LUTHER KING, JR. BLVD
MACON, GEORGIA 31201
478-743-8415 FAX 478-743-8239
WWW.CLARKNEXSEN.COM

Drawing Title PARTIAL SIXTH FLOOR PLAN FIRE PROTECTION
Approved Project Engineer

Project Title CORRECT LIFE SAFETY DEFICIENCIES BECKLEY VAMC FINAL SUBMITTAL
Building Number -
Location BECKLEY, W.V.

Date 09-05-2014
Project No. 517-14-106
Drawing No. FP107
Dwg. XX Of XX

**Veterans
Administration**