


■ Light Pole Locations

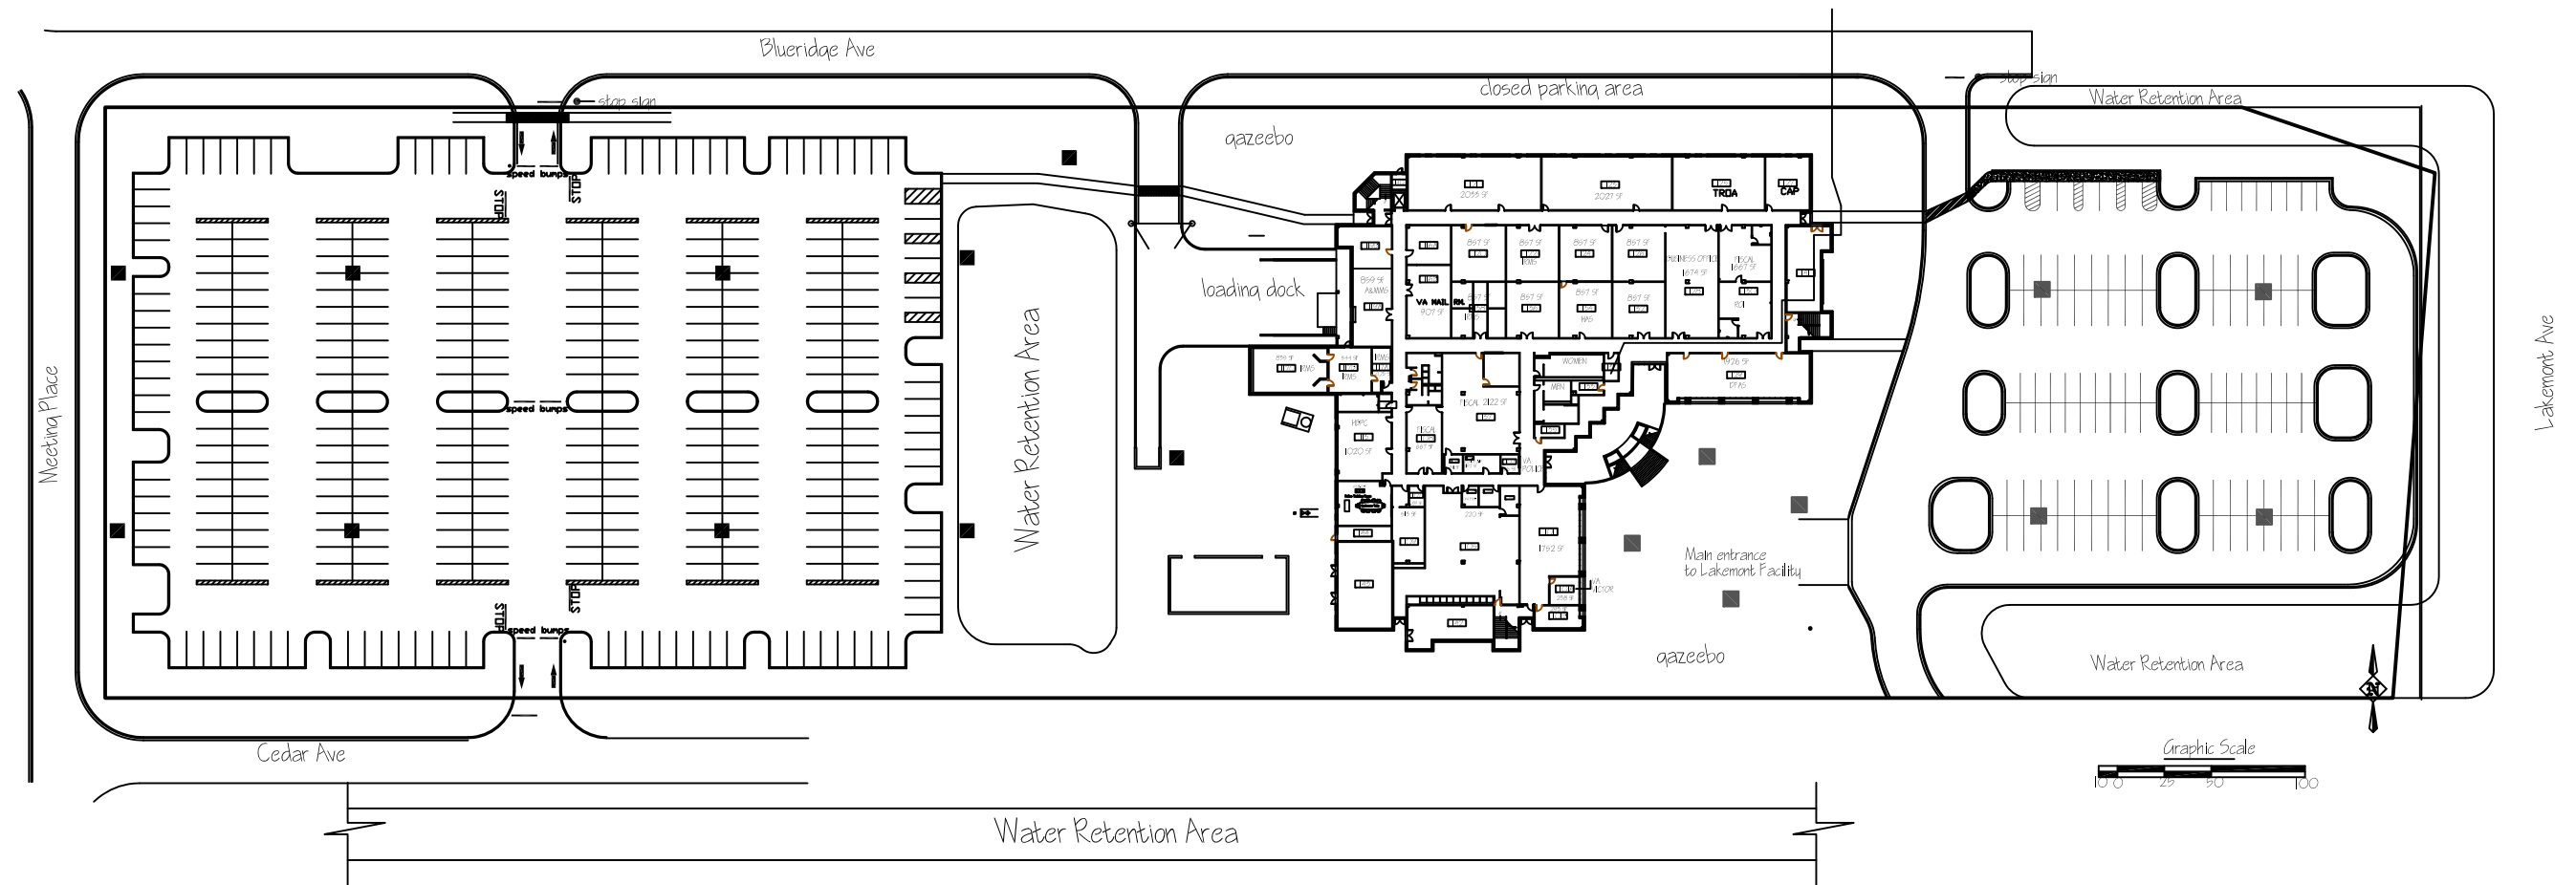

Attachment 5 _Site Map (Lakmont)

VA248-15-R-2122

VA MEDICAL CENTER ORLANDO, FLORIDA
CORRECT ELECTRICAL DEFICIENCIES FCA-D
VHA NRM 675-16-603

LAKEMONT SITE PLAN: ELECTRICAL DEFICIENCIES



Scale: N.T.S.

**Office of Construction &
Facilities Management**



Department of
Veterans Affairs