


three inches = one foot
one and one-half inch = one foot
one inch = one foot
three-quarters inch = one foot
one-half inch = one foot
three-eighths inch = one foot
one-quarter inch = one foot
one-eighth inch = one foot

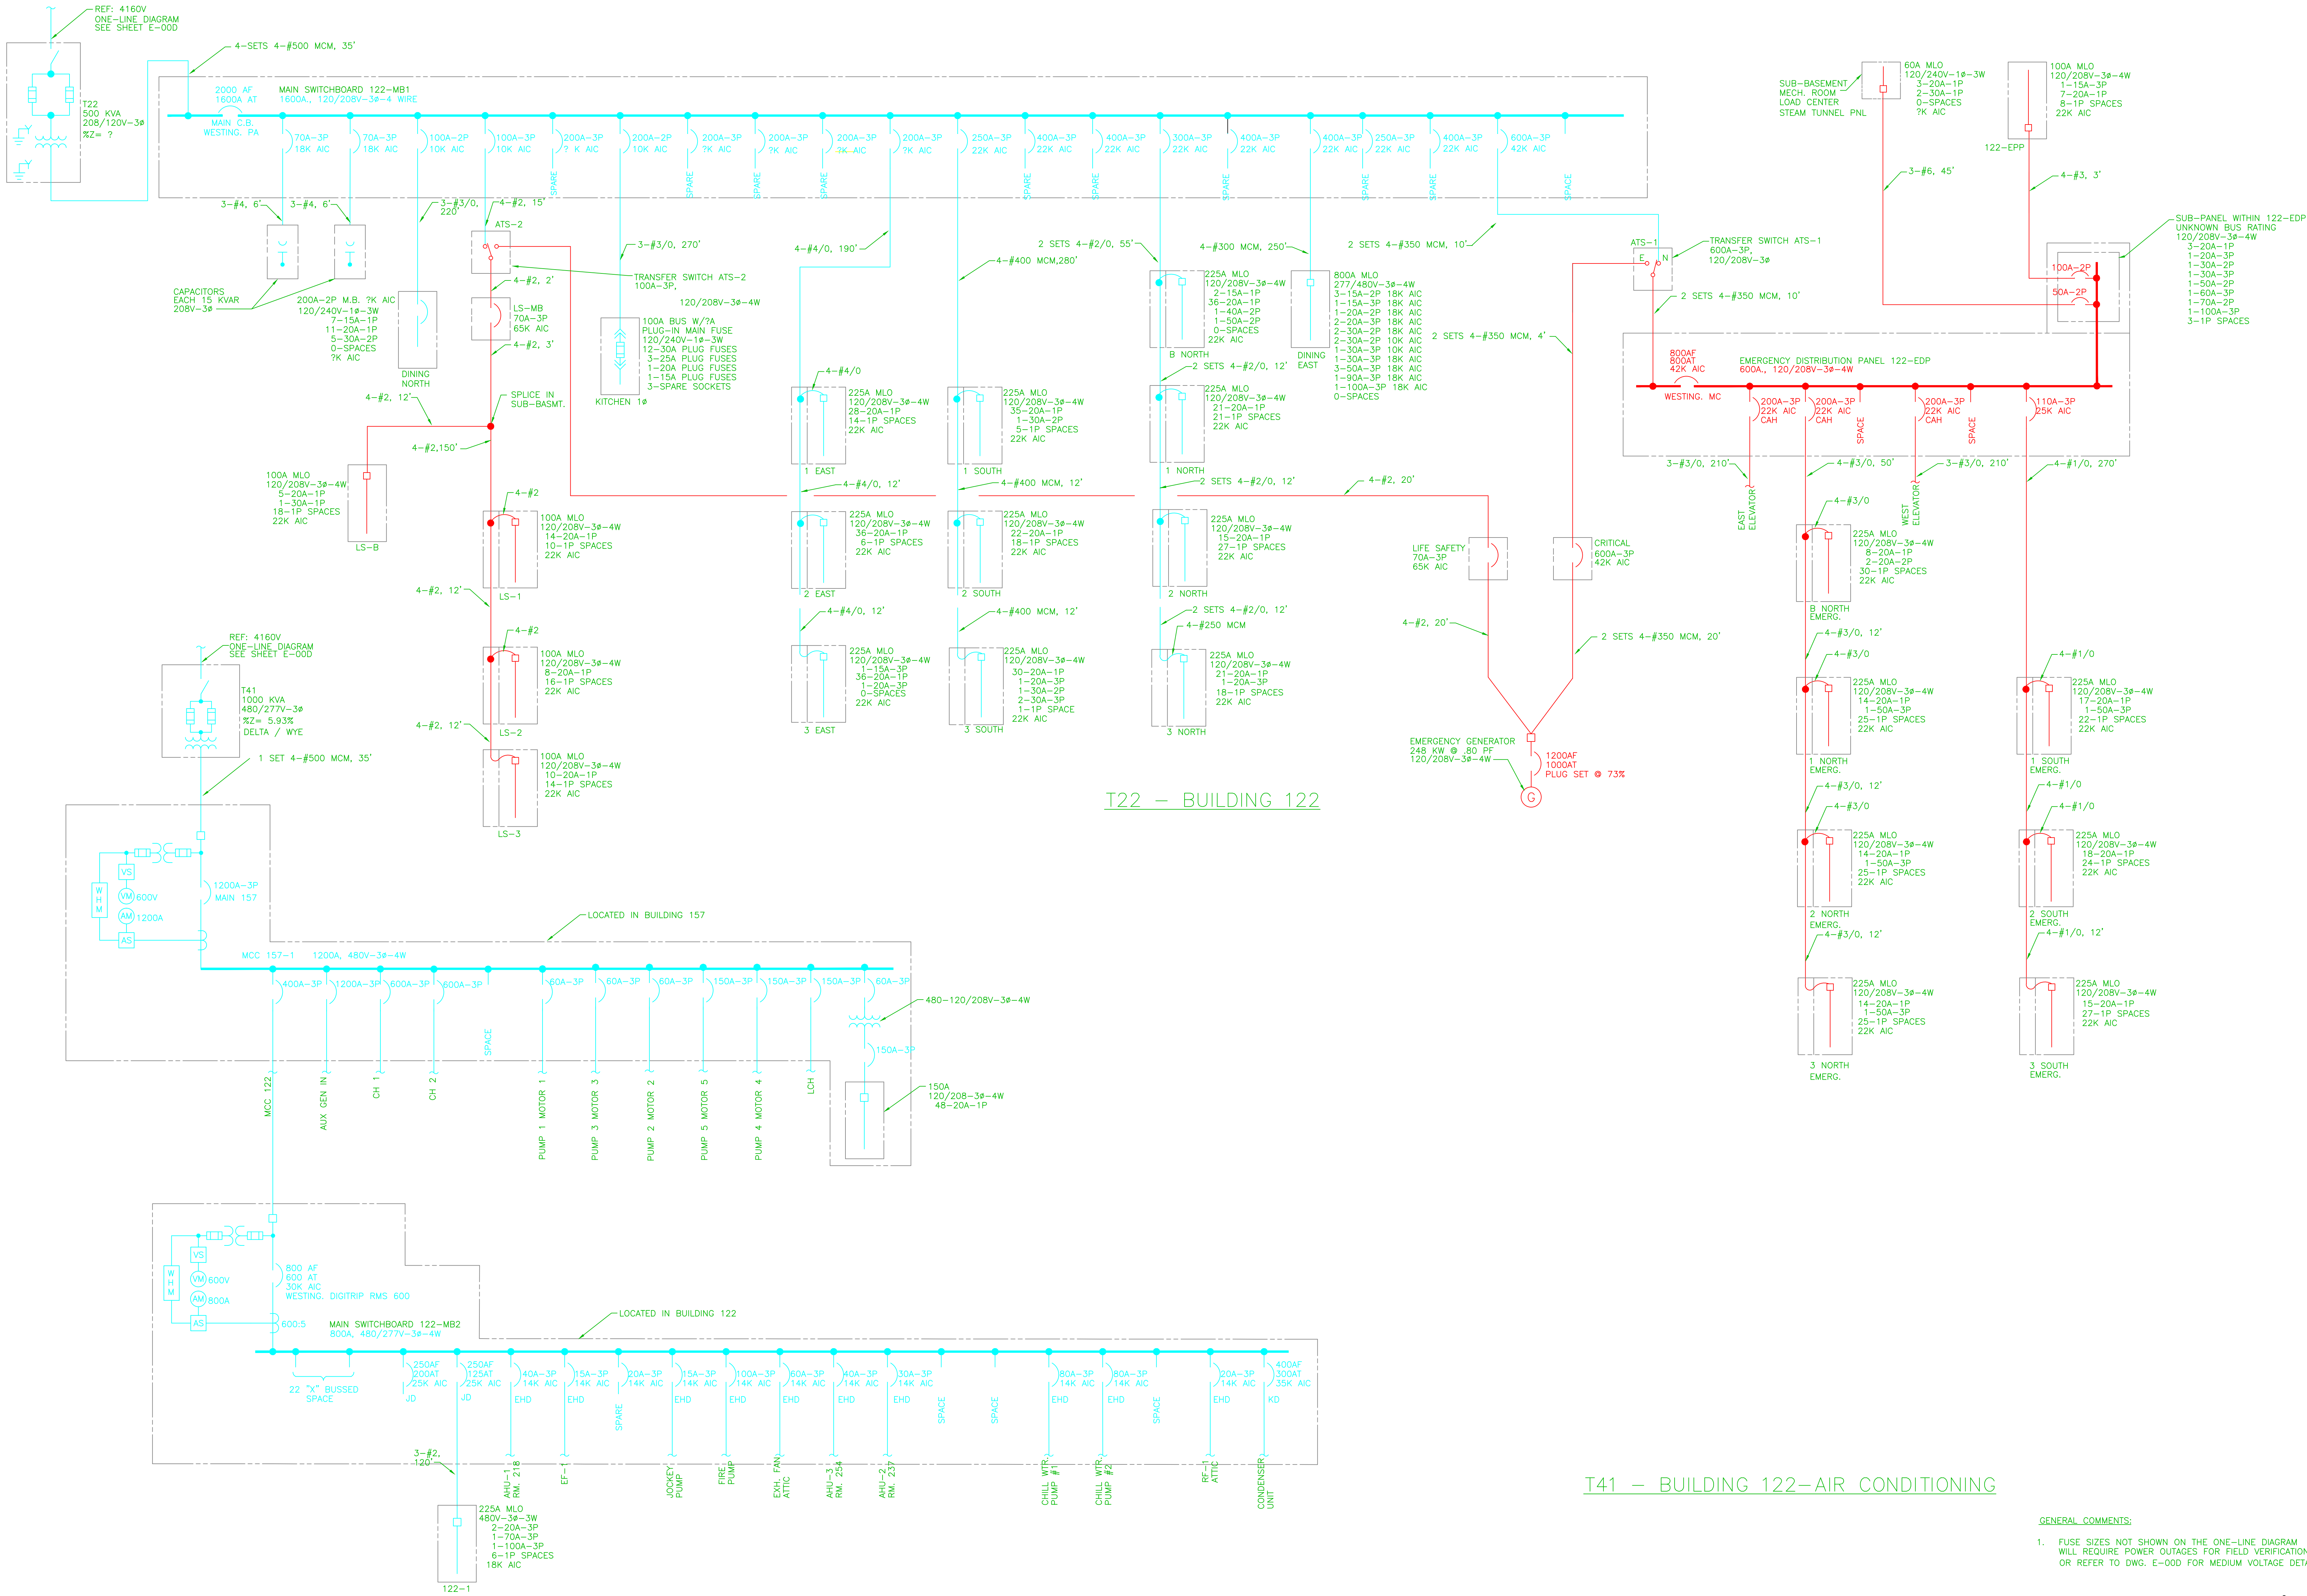

GENERAL COMMENTS:
1. FUSE SIZES NOT SHOWN ON THE ONE-LINE DIAGRAM WILL REQUIRE POWER OUTAGES FOR FIELD VERIFICATION, OR REFER TO DWG. E-00D FOR MEDIUM VOLTAGE DETAIL.

Revisions	Date

Drawing Title
XFMR T22-BLDG 122 XFMR T41-BLDG 122,157 ELECTRICAL ONE-LINE
Approved: Division Chief
Approved: Service Director

Project Title
VA LEAVENWORTH ELECTRICAL STUDY
Building Number
122,157
Location
DDE VAMC LEAVENWORTH, KANSAS

Date
01/30/09
Project No.
4611.0150
DRAWING NO.
E-122,157
Dwg. 27 of 39

