



GENERAL COMMENTS:
1. FUSE SIZES NOT SHOWN ON THE ONE-LINE DIAGRAM OR REFER TO DWG. E-000 FOR MEDIUM VOLTAGE DETAIL.

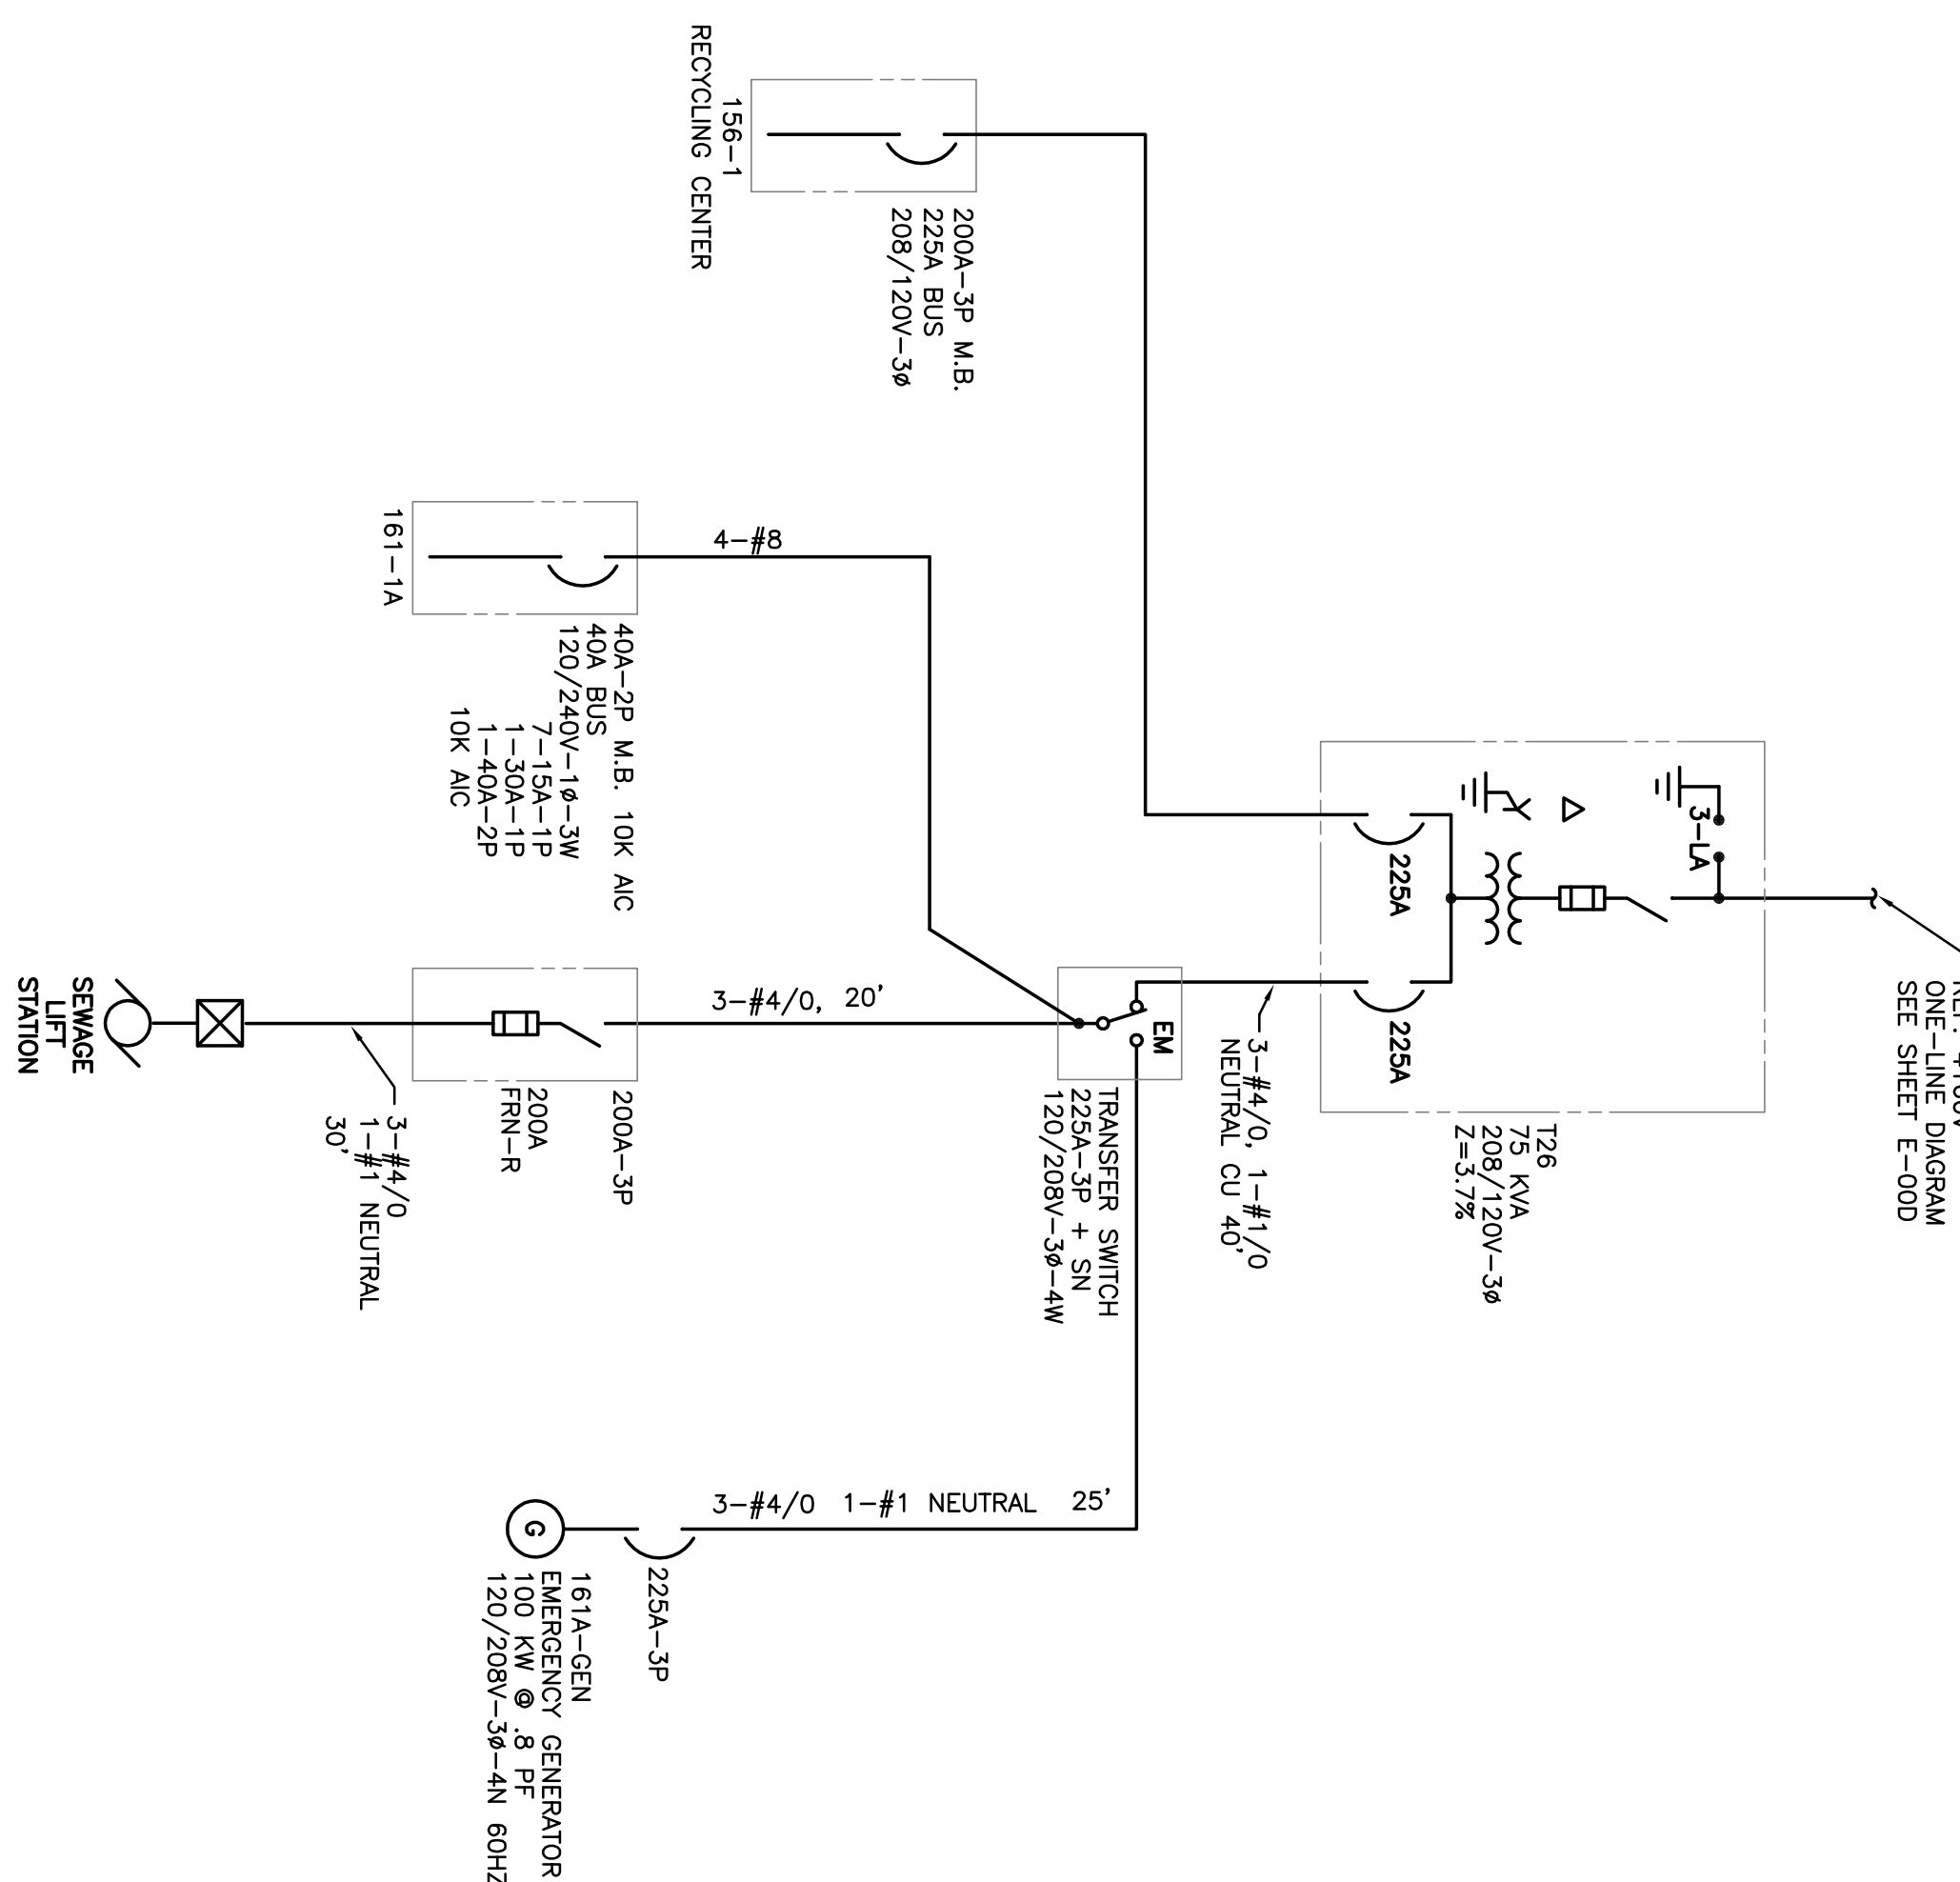

T26-BLDG. 161A

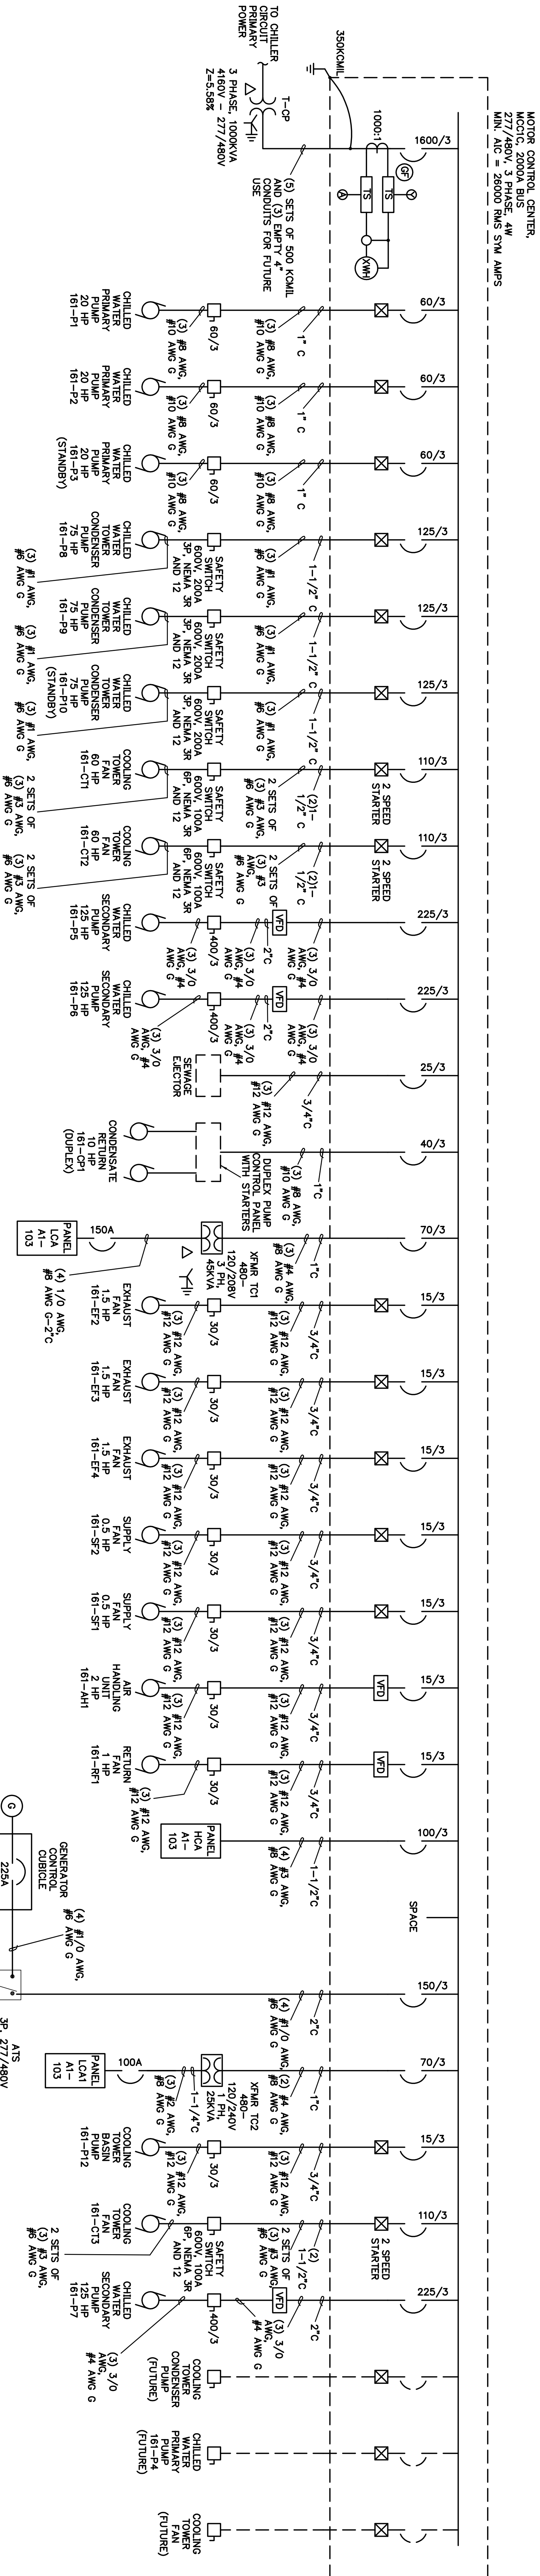

TCP-BUILDING 161

Revisions		Date	
1			
2			
3			
4			
5			
6			
7			
8			
9			

Drawing Title		Project Title	
XFMR T26-BLDG. 156,161A XFMR TCP-BLDG. 161 ELECTRICAL ONE-LINE		VA LEAVENWORTH ELECTRICAL STUDY	
Approved: Division Chief		Building Number	
Approved: Service Director		156,161,161A	
		PG	
		JG	
		Location	
		LEAVENWORTH, KANSAS	
Drawing No.		Project No.	
E-156,161,161A		4611.0150	
Page 30 of 39			