

FLOOR PLAN LEGEND

- WALL PARTITIONS
- UNRATED WALL
  - SMOKE PARTITION
  - 1-HR OCCUPANCY SEPERATION
  - 1-HR FIRE BARRIER
  - 2-HR FIRE BARRIER
  - 2-HR FIRE WALL
  - DEMOLITION BUILDING WALL
  - CLERESTORY WINDOW ABOVE

- SYMBOLS
- FIRE EXTINGUISHER CABINET
  - PORTABLE FIRE EXTINGUISHER
  - PUSH PLATE
  - WALL TYPE INDICATOR (SEE A9.01 FOR WALL TYPE DETAILS)
  - STUD SIZE
  - RECESSED SLAB

- ROOM IDENTIFICATION
- ROOM NAME
  - ROOM NUMBER
  - ROOM SQUARE FOOT

CONSULTANTS:

ARCHITECT/ENGINEERS:

Lee, Burkhardt, Liu, Inc.  
Architecture, Planning, Interiors  
149 New Montgomery Street, 5th Floor  
San Francisco, California 94105  
Phone (415) 671-4342 Fax (415) 671-4610

Drawing Title  
FLOOR PLAN  
1/8" = 1'-0"

Approved Project Director

Date:

Project Title  
VA Palo Alto Healthcare System  
Spinal Cord Injury Replacement  
Unit

Location  
3801 Miranda Avenue, Palo Alto

Date  
07-10-2015

Checked

Drawn

Project Number  
640-380

Building Number  
007

Drawing Number  
007 AS 2.01


Dwg. of.

Office of  
Facilities  
Management

Department of  
Veterans Affairs

3	As Built	7/10/15
2	Addendum 1	7/28/11
Revisions:		Date

three inches = one foot  
one and one half inches = one foot  
one inch = one foot  
three quarters inch = one foot  
one half inch = one foot  
three eighths inch = one foot  
one quarter inch = one foot  
one eighth inch = one foot

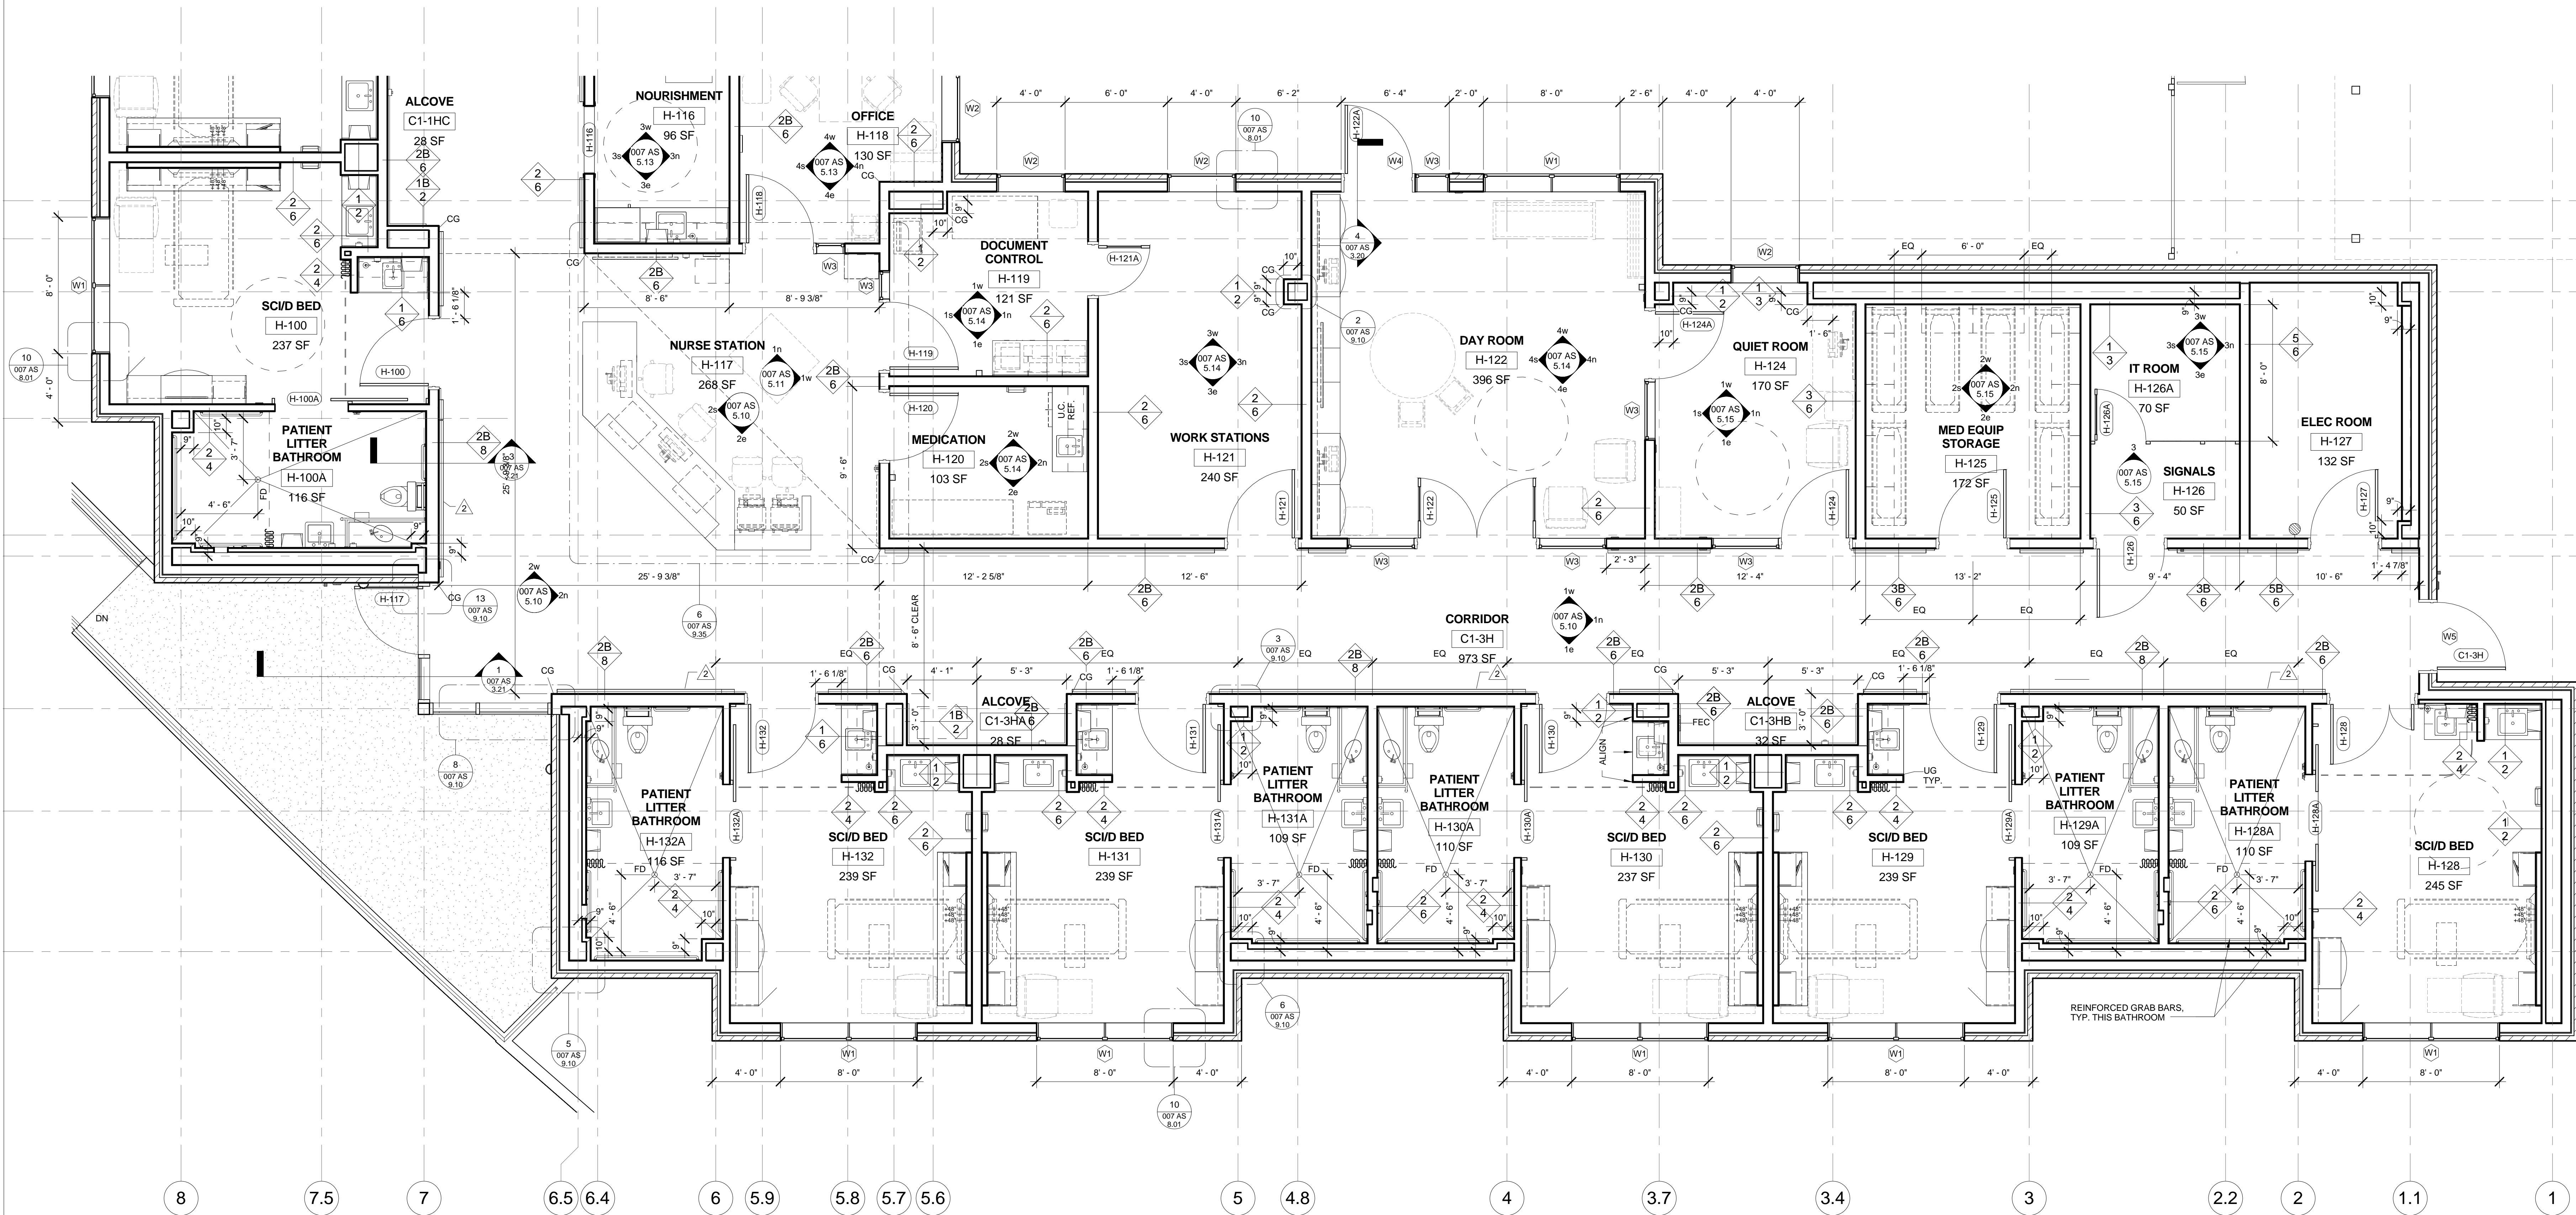

### FLOOR PLAN LEGEND

WALL PARTITIONS	
	UNRATED WALL
	SMOKE PARTITION
	1-HR OCCUPANCY SEPERATION
	1-HR FIRE BARRIER

SYMBOLS	
	FIRE EXTINGUISHER CABINET
	PORTABLE FIRE EXTINGUISHER
	PUSH PLATE
	CORNER GUARD
	WING WALL CORNER GUARD
	FIRE RATED CORNER GUARD

#### ROOM IDENTIFICATION

**EXAM** — ROOM NAME  
**G 123** — ROOM NUMBER  
**46 SF** — ROOM SQUARE FOOT

CONSULTANTS:		

ARCHITECT/ENGINEERS:	
Lee, Burkhardt, Liu, Inc. Architecture, Planning, Interiors	
149 New Montgomery Street, 5th Floor San Francisco, California 94105 Phone (415) 671-4342 Fax (415) 671-4610	

Drawing Title ENLARGED PARTIAL PLAN LEVEL 1 - NORTH 1/4" = 1'-0"
Approved Project Director
Date:


Project Title VA Palo Alto Healthcare System Spinal Cord Injury Replacement Unit		Project Number 640-380
Location 3801 Miranda Avenue, Palo Alto		Building Number 007
Date 07-10-2015	Checked MB	Drawn LBL TEAM
Dwg. of.		007 AS 2.23

Office of Facilities Management  
Department of Veterans Affairs





COATHOK1 IS LOCATED IN ALL PUBLIC TOILETS MOUNTED TO THE INSIDE OF THE DOOR AT 48" AFF. MAX  
VV INDICATED VA FURNISHED, VA INSTALLED  
VC INDICATES VA FURNISHED, CONTRACTOR INSTALLED  
CC INDICATES CONTRACTOR FURNISHED, CONTRACTOR INSTALLED  
SEE SHEET AS 11.00 FOR ADDITIONAL SCHEDULES

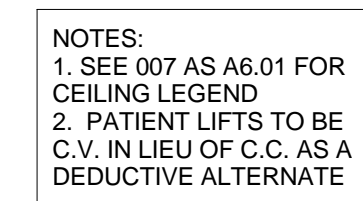VA FORM 08-6231, OCT 1978[illegible]

Lee, Burkhardt, Liu, Inc.  
Architecture, Planning, Interiors

149 New Montgomery Street, 5th Floor  
San Francisco, California 94105  
Phone (415) 671-4342 Fax (415) 671-4610


Date:

 Department of  
Veterans Affairs

one eighth inch = one foot

2w COURTYARD BED - W  
1/4" = 1'-0"



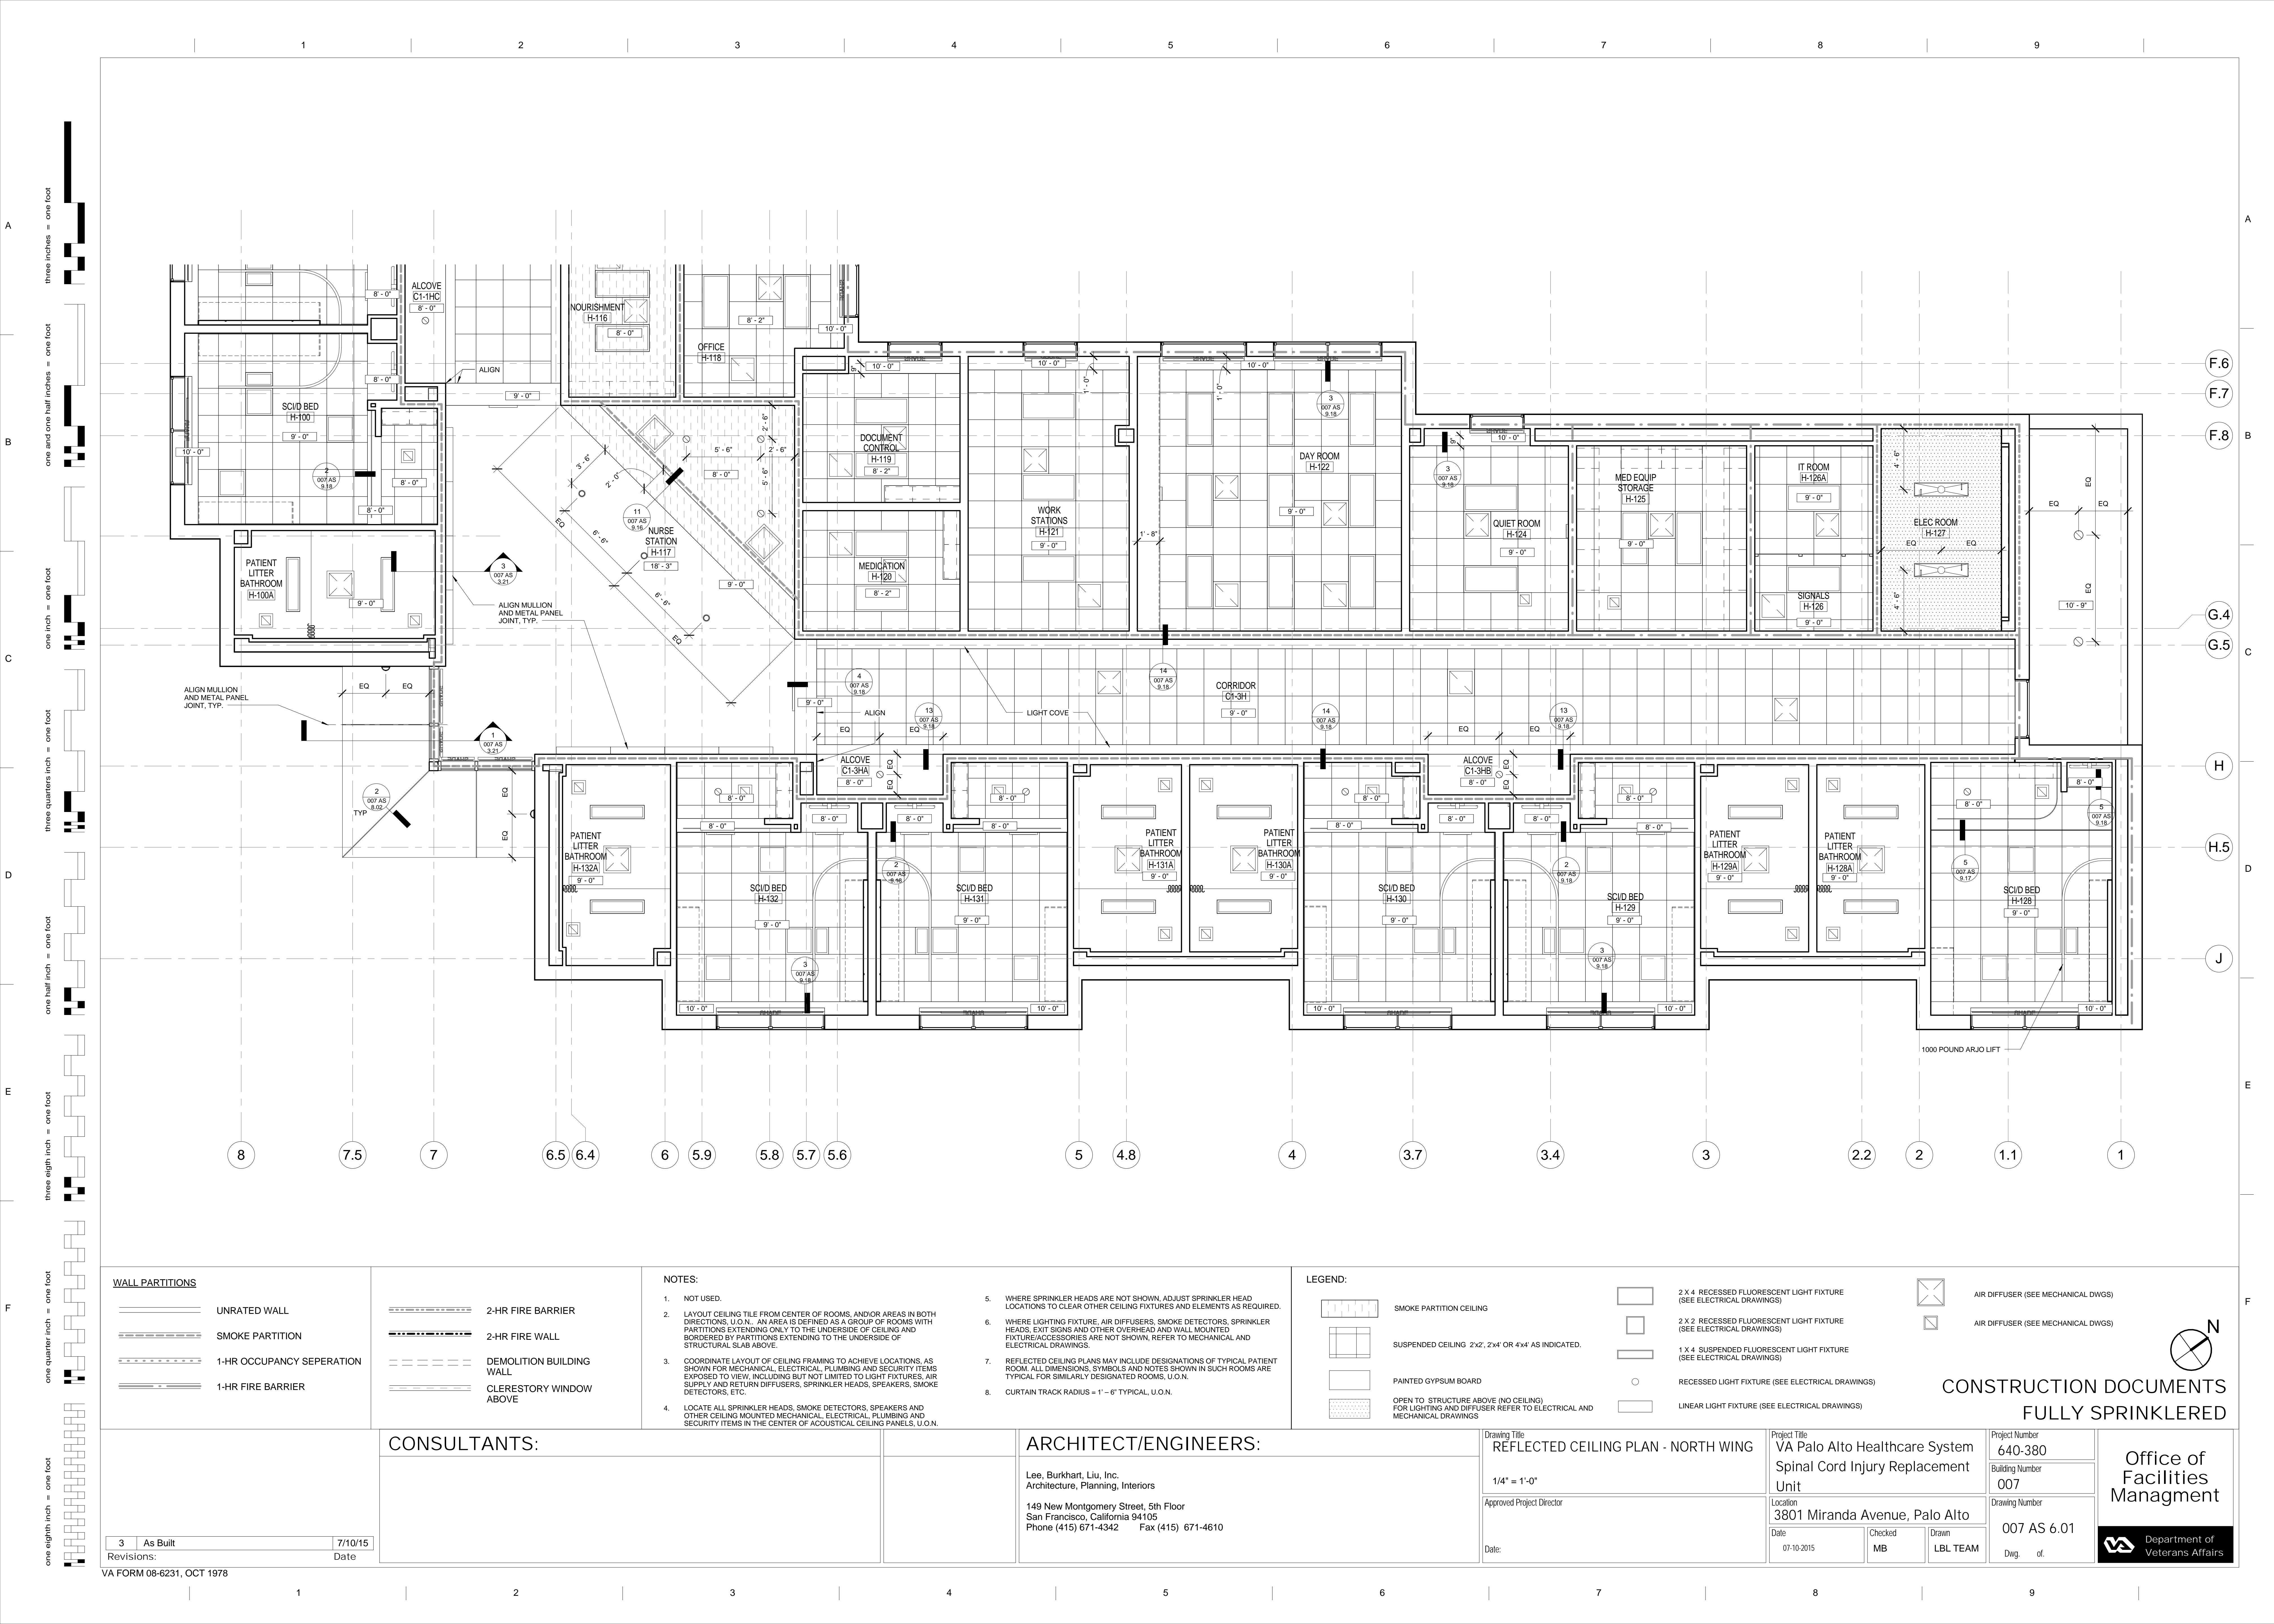



A

B

C

D

E

F

A

B

C

D

E

F

EQUIPMENT SCHEDULE																
EQ #	DESCRIPTION	MANUFACTURER	MODEL	RESP	MOUNTING	WIDTH	DEPTH	HEIGHT	WEIGHT	CONNECTION				REMARKS	ANCHORAGE DETAILS	
										ELECTRICAL	MECHANICAL	PLUMBING	DATA			
3626-002	ARM, PIVOT	PDI	508C-12	VV	WALL											
3417-018	BED, ELECTRIC	STRYKER MEDICAL	ACUTE CARE BED	VV	MOBILE	3' - 6"	7' - 10"	2' - 10 1/2"	N/A	Yes						
3417-019	BED, ELECTRIC, MOBILE	STRYKER MEDICAL	ACUTE CARE BED	VV	MOBILE	2' - 0"	6' - 0"	2' - 10 1/2"	N/A	Yes						
3446-010	BRACKET, MONITOR, WALL	GCX CORPORATION	STANDARD VHM W/19" CHANNEL	CC	WALL				8 LB	Yes	No	No	Yes	ANCHORAGE PER MANUFACTURER STANDARDS		
3711-001	CABINET, WOUND	HOWARD INDUSTRIES	MEDBOX	CC	WALL	1' - 2"	0' - 1"	1' - 4"	N/A	No	No	No	No			
4207-002	CART, CLINICAL CHART			VV	MOBILE	1' - 5"	2' - 0"	4' - 1"	N/A							
5846-015	CART, HOUSEKEEPING, POLYMER	RUBBERMAID	9T75	VV	MOBILE	1' - 10"	4' - 1"	4' - 5"	60 LB							
4331-003	CART, MEDICATION			VV	MOBILE	1' - 5"	2' - 0"	4' - 1"	N/A							
4346-002	CART, RESUSCITATION	INTERMETRO INDUSTRIES, INC.	LIFELINE LEC51	VV	MOBILE	2' - 11"	1' - 10 1/2"	2' - 11 3/4"	N/A							
5832-014	CART, SOILED LINEN	INTERMETRO INDUSTRIES, INC.	SUPER ERECTA CUSTOM	VV	MOBILE	2' - 4"	5' - 8"	5' - 10"	N/A							
6015-051	CART, SUPPLY, CHROME, 48-INCH	INTERMETRO INDUSTRIES, INC.	SUPER ERECTA 5A556BC	VV	MOBILE	4' - 0"	2' - 0"	5' - 9"	N/A							
6016-015	DISPENSER, CHEMICAL	3M	TWIST 'N FILL	VV	WALL	0' - 4"	0' - 5"	0' - 6"								
6364-003	DISPENSER, GLOVE, TRIPLE BOX	BOWMAN DISPENSERS	GB-003	VC	WALL	0' - 10"	0' - 3 3/4"	1' - 6"	4 LB							
3708-004	DISPENSER, MEDICATION	OMNICELL		CC	FLOOR	2' - 0"	2' - 0"	6' - 5"		Yes			Yes			
3708-008	DISPENSER, MEDICATION LARGE	OMNICELL		VV	FLOOR	7' - 1"	2' - 0"	6' - 5"		Yes			Yes			
3708-111	DISPENSER, MEDICATION, HOST (MAIN)	MCKESSON AUTOMATION	ACUDOSE RX	VV	FLOOR	2' - 3"	1' - 11"	4' - 7"	1000 LB	Yes			Yes			
3723-002	DISPOSAL, SHARPS, WALL MOUNT	BD MEDICAL	305602	VV	WALL	1' - 1 1/2"	0' - 3 3/4"	1' - 1 3/4"	2 LB	No			No			
5725-001	DRYER, FRONT LOADING	MAYTAG	MDE/MDG22PR	VV	FLOOR	2' - 3"	2' - 5"	3' - 2"	150 LB	Yes						
3724-015	HEADWALL	HILL-ROM	UNIFLEX 1000	CC	WALL	4' - 0"	0' - 4"	1' - 3"		Yes	Yes	Yes	Yes			
5736-002	ICE MACHINE, COUNTER	FOLLET	SYMPHONY	VV	FLOOR	1' - 9 1/2"	2' - 0"	3' - 3"	230 LB	Yes		Yes				
4802-001	LIFT J TRACK, BARIATRIC, PATIENT	ARJO	MAXISKY 1000	CC	CEILING	9' - 0"	3' - 8"		1000 LB	Yes				38" TURN RADIUS		
4803-001	LIFT J TRACK, PATIENT	ARJO	MAXISKY 600	CC	CEILING		4' - 0"		600 LB					23" TURN RADIUS		
3416-001	LOCATOR, BED, WALL	HILL-ROM		CC	WALL	4' - 2"	0' - 4 1/2"	1' - 10 1/2"	65 LB							
6025-001	LOCKER, 'VANGAURD 2 TIER'	Penco	6235V	CC	FLOOR	1' - 0"	1' - 6"	6' - 0"		No	No	No	No	COLOR 073 CHAMPAGNE		
4105-007	MICROWAVE			VV	COUNTER	2' - 6"	2' - 0"	1' - 6"		Yes						
4105-010	OVEN, MICROWAVE, COUNTERTOP	SEARS COMMERCIAL	KENMORE 20-66462	VV	UNDERCAB	2' - 6"	1' - 4"	1' - 6"	35 LB	Yes						
4193-001	RACK, COAT AND HAT	SAMMONS PRESTON		CC	WALL	3' - 0"	0' - 4"	0' - 4"	22 LB							
4198-007	RACK, MOPS / BROOMS	RUBBERMAID	1992	CC	WALL	2' - 6"	0' - 8"	1' - 1"	1 LB							
4836-006	REFRIDGERATOR, SIDE BY SIDE	GE APPLIANCES	GTH21KCXWW	VV	FLOOR	2' - 8 3/4"	2' - 6 1/2"	5' - 6 3/4"	200 LB	Yes						
4942-109	REFRIGERATOR, DOMESTIC W/FREEZER	KENMORE	46-78972	VV	FLOOR	2' - 5 3/4"	2' - 8"	5' - 6"	200 LB	Yes						
4238-005	REFRIGERATOR, UNDERCOUNTER	FOLLETT	REF4-ADA	VV	FLOOR	2' - 0"	2' - 2"	2' - 8"	116 LB	Yes						
6015-054	SHELVES, SOLID LARGE	INTERMETRO INDUSTRIES, INC.	SUPER ERECTA	CC	FLOOR	3' - 6"	2' - 0"	7' - 0"	5 LB							
6015-051	SHELVES, SOLID SMALL	INTERMETRO INDUSTRIES, INC.	SUPER ERECTA	VC	FLOOR	3' - 0"	1' - 6"	6' - 5"	5 LB							
5934-004	TABLE, OVERBED, GENERAL	HILL-ROM	OBT-220	VV	MOBILE	1' - 2"	2' - 9"	3' - 6"	58 LB		No	No				
3478-004	TV, ARM-MOUNTED	PDI	P15X	VV	MOBILE	1' - 3"	1' - 6 1/4"	0' - 5 5/8"		Yes			Yes	AV EQUIPMENT (SEE T SERIES)		
5732-102	WASHER, FRONT LOADING	MAYTAG	MAH22PR	VV	FLOOR	2' - 3"	2' - 5"	3' - 2"	250 LB	Yes		Yes				

IT EQUIPMENT SCHEDULE																
Item No.	DESCRIPTION	MANUFACTURER	MODEL	RESP	MOUNTING	WIDTH	DEPTH	HEIGHT	WEIGHT	CONNECTION				REMARKS	ANCHORAGE DETAILS	
										ELECTRICAL	MECHANICAL	PLUMBING	DATA			
IT-BULLETIN	BOARD, BULLETIN	QUARTET GBC OFFICE PRODUCTS	304	CC	WALL	4' - 0"	0' - 1 1/4"	3' - 0"	9 LB							
IT-DRYER	BOARD, WHITE, DRY ERASE	QUARTET GBC OFFICE PRODUCTS	S574	CC	WALL	4' - 0"	0' - 1 3/4"	3' - 0"	4 LB							
IT-EK01X	COMPUTER ON WHEELS, CHARTING W/ DRAWER UNIT	INTERMETRO INDUSTRIES, INC.	FLO 1750 W/DRAWER UNIT	VV	MOBILE	1' - 11 1/2"	0' - 0"	2' - 10 1/8"		Yes			Yes			
IT-DESKTOP	COMPUTER, DESKTOP	DELL, INC.	TBD	VV	MOBILE					Yes			Yes			
IT-COPYMUL	COPIER/PRINTER/SCANNER	TBD	TBD	VV	MOBILE	1' - 6 1/2"	1' - 5 1/4"	1' - 6"		Yes			Yes			
IT-COPFLCL	COPIER/PRINTER/SCANNER, FLOOR	RICOH CORPORATION	MP C3000 SPF	VV	FLOOR	5' - 0"	2' - 6"	3' - 4"		Yes			Yes			
IT-MONITR	FLAT PANEL DISPLAY	TBD	TBD	VV	WALL		0' - 4"	2' - 10"		Yes			Yes			
IT-INFOBD	INFORMATION BOARD, WITH CLOCK	PETER PEPPER PRODUCTS, INC.	IB3024	CC	WALL	2' - 6"		2' - 0"		Yes						
IT-PRNTINK	PRINTER, INKJET	HAWLETT-PACKARD	OFFICEJET PRO - A809a	VV	MOBILE	1' - 8"	1' - 7"	0' - 7"		Yes			Yes			
IT-SHEDDER	SHREDDER, PAPER, HEAVY DUTY	FELLOWES INC	C-480C	VV	FLOOR	2' - 1"	1' - 8"	3' - 2"	100 LB	Yes						

VV INDICATES VA FURNISHED, VA INSTALLED  
VC INDICATES VA FURNISHED, CONTRACTOR INSTALLED  
CC INDICATES CONTRACTOR FURNISHED, CONTRACTOR INSTALLED

CONSTRUCTION DOCUMENTS  
FULLY SPRINKLERED

CONSULTANTS:

ARCHITECT/ENGINEERS:

Lee, Burkhart, Liu, Inc.  
Architecture, Planning, Interiors  
  
149 New Montgomery Street, 5th Floor  
San Francisco, California 94105  
Phone (415) 671-4342      Fax (415) 671-4610

Drawing Title  
EQUIPMENT SCHEDULES

Approved Project Director

Date:

Project Title  
VA Palo Alto Healthcare System  
Spinal Cord Injury Replacement  
Unit

Location  
3801 Miranda Avenue, Palo Alto

Date  
07-10-2015

Checked

Drawn

Project Number  
640-380

Building Number  
007

Drawing Number  
007 AS 11.00

Dwg. of.

Office of  
Facilities  
Management

 Department of  
Veterans Affairs

3 | As Built | 7/10/15

Revisions: | Date