


ROOM LEGEND

No.	ROOM NAME
B1213	OFFICE SOCIAL WORKER
B1214	WAITING
B1215	OFFICE SOCIAL WORKER
B1217	OFFICE SOCIAL WORKER
B1218	VESTIBULE
B1219	TOILET - VISITOR/PATIENT - M.
B1220	TOILET - VISITOR/PATIENT - F.
B1221	OFFICE SOCIAL WORKER
B1222	OFFICE CHIEF
B1223	OFFICE PSYCHIATRIST
B1224	OFFICE PSYCHIATRIST
B1225	OFFICE PSYCHIATRIST
B1226	OFFICE PSYCHIATRIST
B1227	OFFICE PSYCHIATRIST
B1228	SUBSTATION
B1229	ELECTRICAL ROOM
B1230	VESTIBULE
B1231	LOCKERS TOILET - STAFF F.
B1232	H.A.C.
B1233	TOILET - STAFF M.
B1234	OFFICE PSYCHOLOGIST
B1235	LOUNGE - STAFF
B1236	OFFICE PSYCHOLOGIST
B1237	OFFICE PSYCHOLOGIST
B1238	OFFICE PSYCHOLOGIST
B1239	OFFICE CHIEF - SERVICE
B1240	CONFERENCE
B1241	OFFICE CLERK
B1242	OFFICE ADMIN.
B1243	OFFICE ASSISTANT CHIEF
B1244	EXAM/INTERVIEW
B1245	OFFICE STAFF PHYSICIAN
B1246	OFFICE STAFF PHYSICIAN
B1247	OFFICE STAFF PHYSICIAN
B1248	OFFICE STAFF PHYSICIAN
B1249	OFFICE STAFF PHYSICIAN
B1250	OFFICE CHIEF - RESIDENT
B1251	GROUP TESTING
B1252	OFFICE PSYCHOLOGIST
B1253	OFFICE PSYCHOLOGIST
B1254	OFFICE
B1255	MULTIPURPOSE ROOM
B1256	CLOSET
B1257	OFFICE TRAINER
B1258	EVIS WORK AREA
B1259	OFFICE SECRETARY/STENOGRAPHER
B1260	OFFICE CHIEF
B1261	WAITING
B1262	GROUP THERAPY
B1263	OFFICE TRAINER
B1264	OFFICE TRAINER
B1265	OFFICE TRAINER
B1266	OFFICE PSYCHOLOGIST
B1267	OFFICE PSYCHOLOGIST
B1268	OFFICE PSYCHOLOGIST
B1269	OFFICE PSYCHOLOGIST
B1270	OFFICE PSYCHOLOGIST
B1271	OFFICE PSYCHOLOGIST
B1272	OFFICE PSYCHOLOGIST
B1273	OFFICE TRAINER
B1274	OFFICE TRAINER
B1275	OFFICE TRAINER
B1276	OFFICE TRAINER
B1277	OFFICE HOUSE STAFF
B1278	OFFICE TRAINER
B1279	OFFICE PHYSICIAN ASSIST.
B1280	ACTIVITY - BILLIARDS
B1281	VESTIBULE
B1282	SHOWER - STAFF F.
B1283	LOCKERS TOILET - STAFF F.
B1284	TOILET - STAFF F.
B1285	VESTIBULE
B1286	SHOWER - STAFF M.
B1287	LOCKERS TOILET - STAFF M.
B1288	ACTIVITIES
B1289	MECHANICAL ROOM
B1290	ELECTRICAL ROOM
B1291	VESTIBULE
B1292	VESTIBULE
B1293	ENTRANCE
B1294	ENTRANCE VESTIBULE
B1295	CORRIDOR
B1296	CORRIDOR
B1297	CORRIDOR
B1298	CORRIDOR
B1299	CORRIDOR
B1300	CORRIDOR
B1301	CORRIDOR
B1302	CORRIDOR
B1303	STAIR NO. 3
B1304	STAIR NO. 5

GENERAL NOTES:
ALL HANGING DRAPERS ON SUPPLY
DUCTWORK LOCATED IN DISTRIBUTION
ZONE S-4 HAVE NOT BEEN INSTALLED

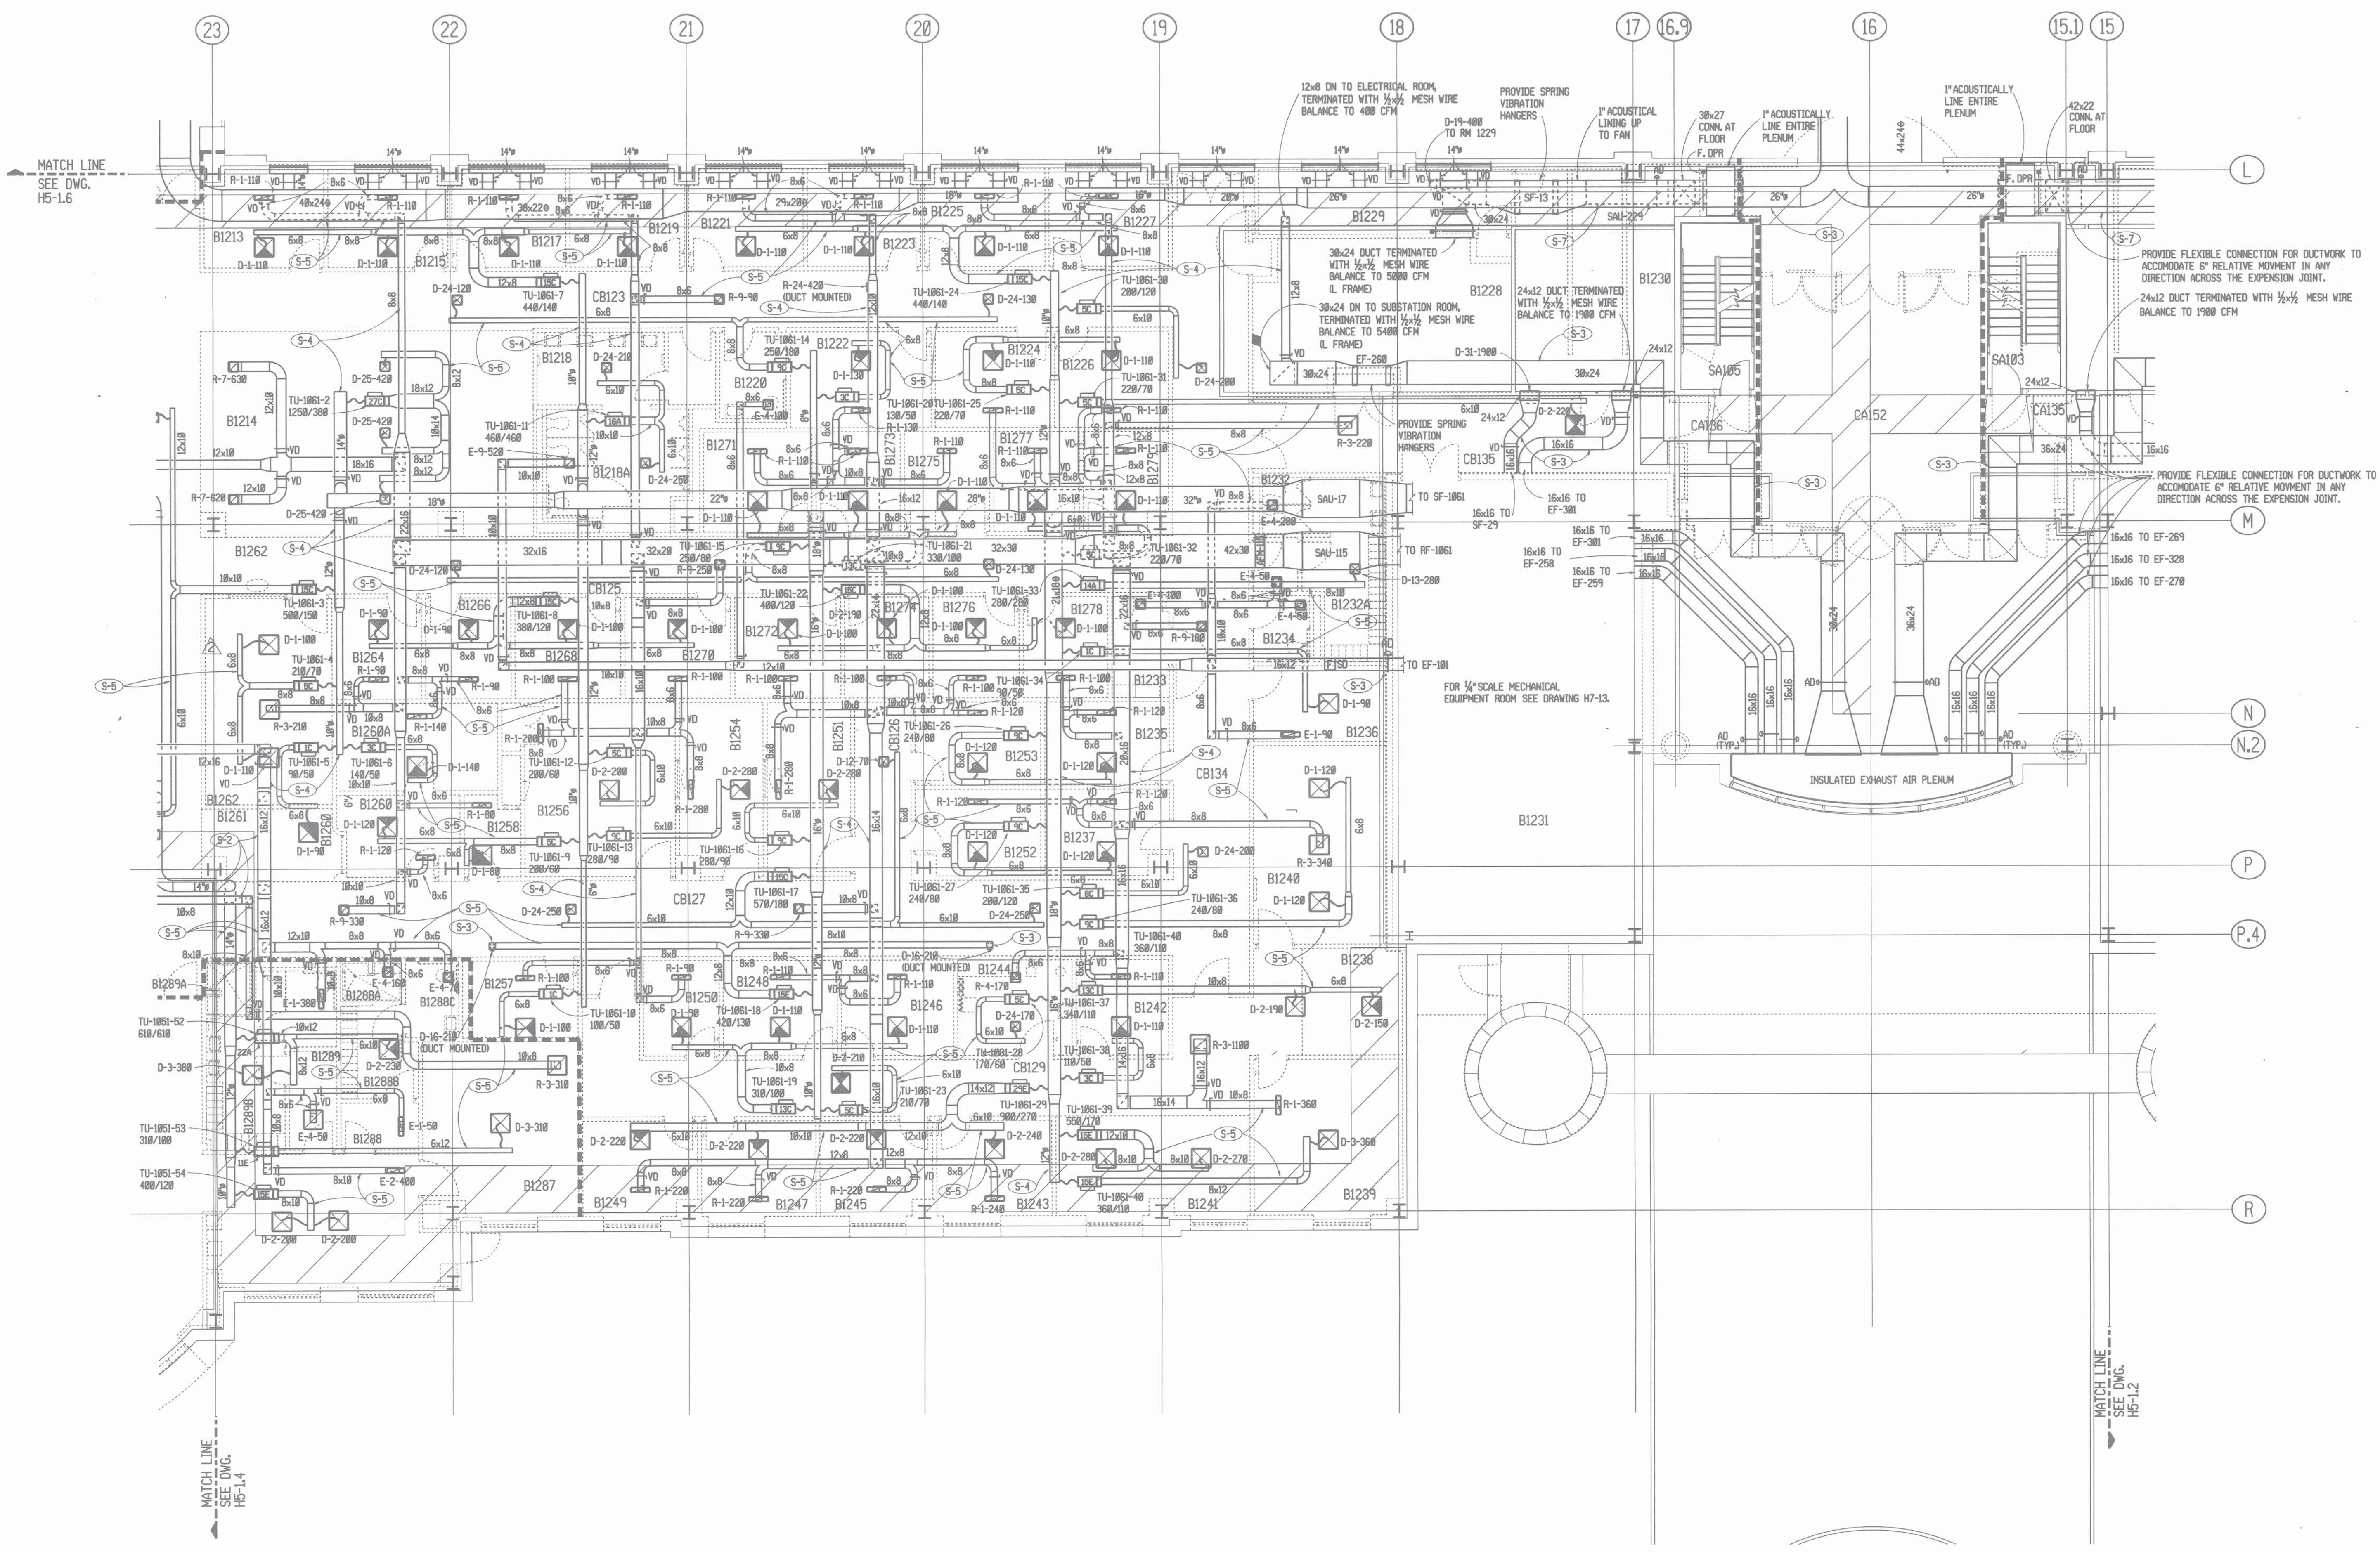

RECORD DRAWINGS RECORD DRAWINGS	09-15-97 10-11-96	FULLY PROTECTED BY AUTOMATIC SPRINKLER SYSTEM	SH&G Smith, Hinchman & Grylls Associates, Inc. Architects Engineers Planners 150 West Jefferson, Suite 100 Detroit, Michigan 48226 313/983-3600		Key Plan 	Drawing Title FIRST FLOOR PLAN ZONE 3 - HVAC Scale: 1/8" = 1'-0" Approved Area Project Manager 	Project Title 503 BED REPLACEMENT HOSPITAL Building Number 100 Location Detroit, Michigan	Date 7-1-91 Project No. 553-080 Drawing No. H5-1.3 Dwg. of	Veterans Administration