

ROOM LEGEND

| No. | ROOM NAME |
|--------|--------------------------------|
| B1210 | VENDING |
| B1212 | SPD TERMINAL - CLEAN |
| B1240 | RECREATION - MULTIPURPOSE |
| B1291 | STORAGE - MULTIPURPOSE |
| B1292 | KITCHEN - SERVING PREP |
| B1293 | ACTIVITY/GAME ROOM |
| B1294 | OFFICE, CLINICAL DIETITIAN |
| B1295 | STORAGE |
| B1296 | TOILET - PATIENT M. |
| B1303 | CONFERENCE - PROFESSIONAL |
| B1304 | SPD TERMINAL - SOILED |
| B1311 | OFFICE, SECRETARY/WAITING |
| B1312 | GROUP THERAPY |
| B1313 | EXAM/TREAT/CONSULT |
| B1314 | ACTIVITY/DINING SPACE |
| B1344 | STORAGE - ACTIVITIES PROGRAM |
| B1355 | OFFICE, PSYCHIATRIST |
| B1317 | OFFICE, PSYCHOLOGIST |
| B1319 | QUIET ROOM - PATIENT |
| B1320 | OFFICE, OCCUPATIONAL THERAPIST |
| B1321 | OFFICE, PSYCHOLOGIST |
| B1322 | OFFICE, OCCUPATIONAL THERAPIST |
| B1323 | RECEPTION |
| B1324 | ACTIVITY - SOCIAL |
| B1324A | CLOSET |
| B1324B | CLOSET |
| B1324C | STORAGE - ACTIVITY PROGRAM |
| B1324D | ACTIVITY - KITCHEN |
| B1325 | OFFICE, EDUCATIONAL THERAPIST |
| B1326 | ACTIVITY - EDUCATIONAL THERAPY |
| B1327 | GROUP THERAPY |
| B1328 | OFFICE, PHYSICIAN ASSIST. |
| B1329 | OFFICE, NURSE |
| B1330 | ACTIVITY - QUIET AREA |
| B1331 | TOILET - PATIENT |
| B1332 | OFFICE, PSYCHOLOGIST |
| B1334 | OFFICE, SOCIAL WORKER |
| B1336 | RECEPTIONIST |
| B1338 | MECHANICAL ROOM |
| B1340 | ELECTRICAL ROOM |
| B1342 | ELECTRICAL ROOM |
| B1343 | SUBSTATION |
| B1343A | ELECTRICAL ROOM |
| B1344 | OFFICE, COUNSELOR - REHAB. |
| B1345 | OFFICE, COUNSELOR - REHAB. |
| B1346 | OFFICE, COUNSELOR - REHAB. |
| B1347 | H.A.C. |
| B1348 | OFFICE, COUNSELOR - REHAB. |
| B1350 | OFFICE, CLECK - STATISTICAL |
| B1352 | OFFICE, COUNSELOR - REHAB. |
| B1353 | WAITING |
| B1354 | CONFERENCE - GROUP THERAPY |
| B1355 | RECEPTION |
| B1356 | TOILET-PATIENT URINE SPECIMEN |
| B1357 | OFFICE, PSYCHOLOGIST |
| B1358 | EXAM/TREAT/CONSULT |
| B1359 | OFFICE, PHYSICIAN |
| B1360 | TOILET - PATIENT |
| B1362 | OFFICE, SECRETARY |
| B1363 | PHARMACY - PREPACKAGING |
| B1364 | OFFICE, CORO. |
| B1366 | STORAGE/UTILITY |
| B1368 | OFFICE, SOCIAL WORKER |
| B1369 | OFFICE, CHIEF - EXAM/TREATMENT |
| B1370 | WAITING |
| B1371 | OFFICE, TECHNICIAN - REHAB. |
| B1372 | OFFICE, TECHNICIAN - REHAB. |
| B1373 | RECEPTION |
| B1374 | EXAM/TREAT/CONSULT |
| B1375 | CONFERENCE - GROUP THERAPY |
| B1387 | CORRIDOR |
| B1388 | CORRIDOR |
| B1389 | CORRIDOR |
| B1391 | CORRIDOR |
| B1392 | CORRIDOR |
| B1393 | CORRIDOR |
| B1394 | CORRIDOR |
| B1395 | CORRIDOR |
| B1396 | CORRIDOR |
| B1397 | CORRIDOR |
| B1398 | CORRIDOR |
| B1399 | CORRIDOR |
| B1400 | STAIR NO. 6 |

NOTES:

- POWER ALL 277V EMERGENCY/CRITICAL BRANCH LIGHT FIXTURES INDICATED ON THIS DRAWING FROM CIRCUIT LP-C15-1.
- POWER ALL 277V EMERGENCY/LIFE SAFETY BRANCH LIGHT FIXTURES INDICATED ON THIS DRAWING FROM CIRCUIT LP-E15-1, U.O.N.
- TIME CLOCK FOR CONTROL OF CANOPY LIGHT FIXTURES. POWER FROM CIRCUIT LP-15-20.

FULLY PROTECTED BY AUTOMATIC SPRINKLER SYSTEM
FINAL SUBMISSION
NOT FOR CONSTRUCTION

DEPARTMENTS - THIS DRAWING:


00202 DRUG DEPENDENCE TREATMENT CLINIC/ALCOHOL DEPENDENCE TREATMENT CLINIC
00260 OUTPATIENT PSYCHIATRIC - DAY TREATMENT
00263 PHARMACY SERVICE
00264 RECREATION SERVICE
00300 DAY HOSPITAL

SH&G Project No. 4999L

SH&G

Smith, Hinchman & Grylls Associates, Inc.
Architects Engineers Planners

455 West Fort Street, Detroit, Michigan 48226
313/964-3000

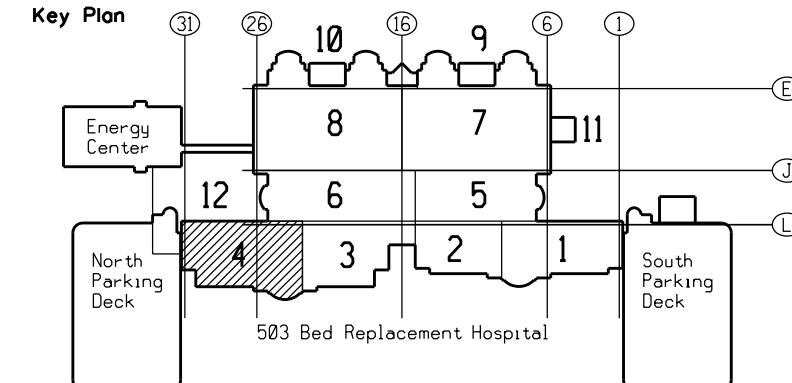

Drawing Title
FIRST FLOOR PLAN
ZONE 4 - LIGHTING

Scale: 1/8" = 1'-0"

Approved: Area Project Manager

Project Title
503 BED REPLACEMENT
HOSPITAL

Building Number
100

Location
Detroit, Michigan

Date
4/29-91

Project No.
553-080

DRAWING NO.
E2-1.4

Dwg. of

Veterans
Administration