
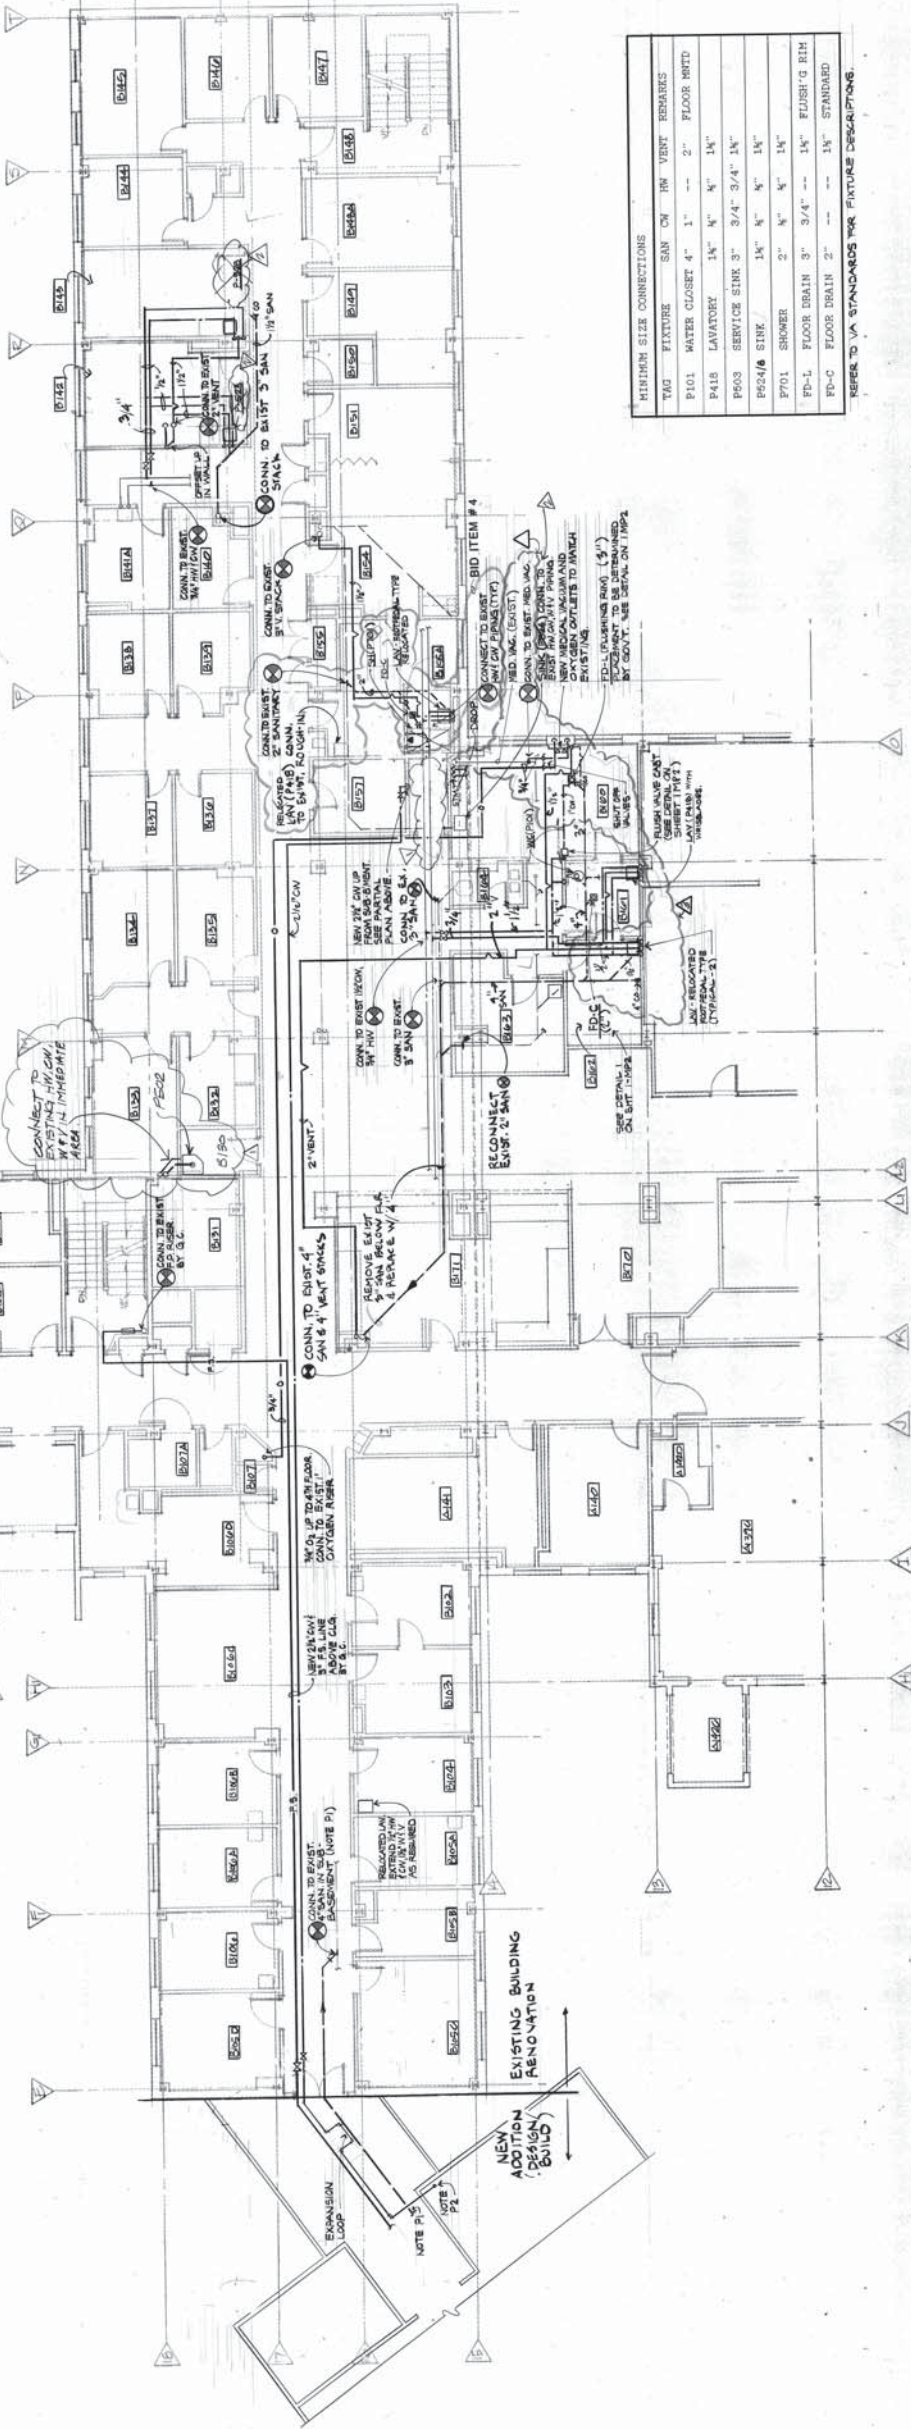


REFER TO DWG. 1-A3 FOR PHASING OF WORK

PHASING IS CONSECUTIVE
-EACH PHASE SHALL BE COMPLETED AND
ACCEPTED BY THE GOVERNMENT BEFORE
THE NEXT PHASE BEGINS. A MAXIMUM
-ALLOW 1 WEEK BETWEEN PHASES FOR
RELOCATION OF FURNISHINGS AND
EQUIPMENT. SPECIFICATION SECTION
1010 AND REFERENCE DRAWING 1-A3
FOR PHASING LIMITS.

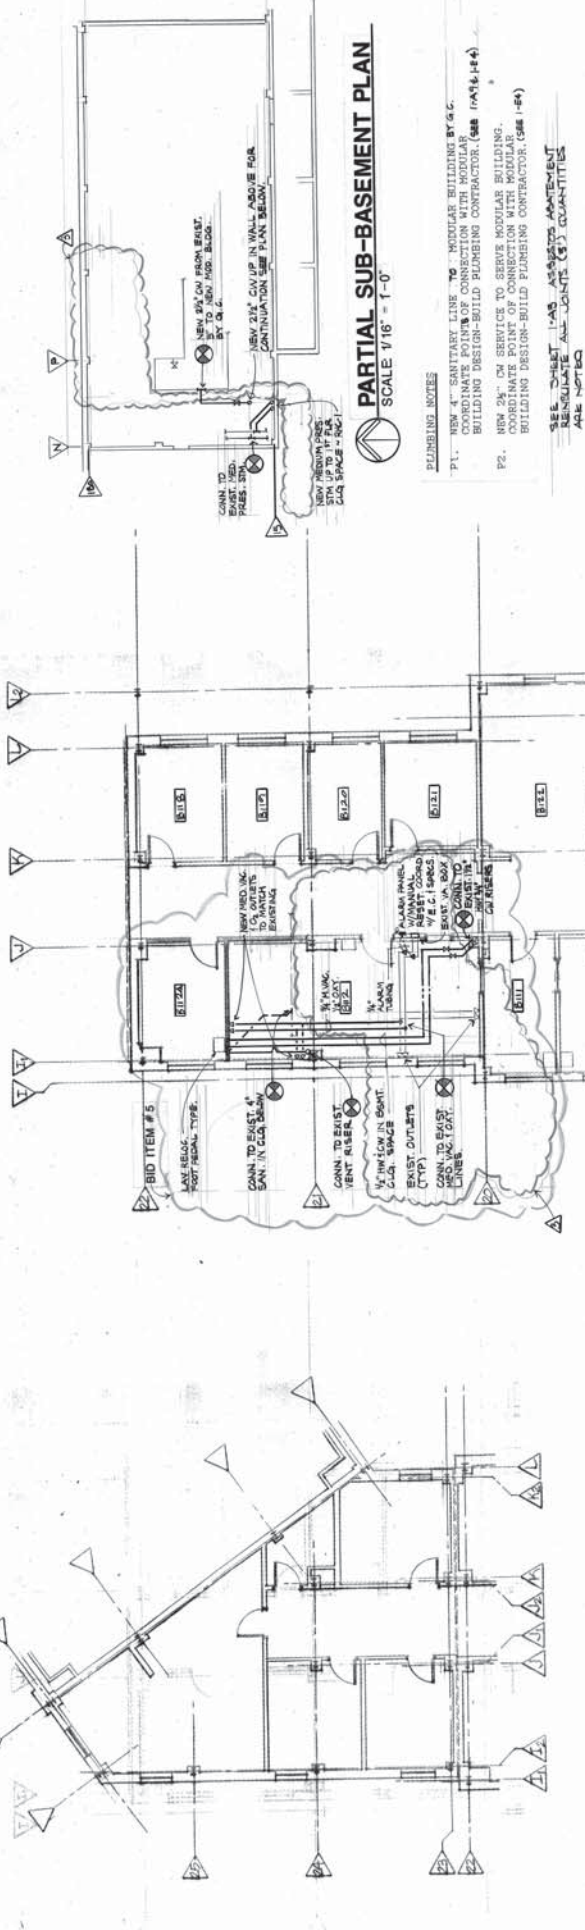

H-B PROJECT NO. 90-4

Project Title		Project No.		Drawing No.	
OUTPATIENT EXPANSION		506080		1-P-1	
Drawing Title		Building Number		Location	
UNIT B FIRST LEVEL REVISED PLUMBING PLAN		1		ANN ARBOR, MICHIGAN	
Scale: 1/8" = 1'-0"		Checked		Approved: Service Director	
Approved: Division Chief		Checked		Approved: Service Director	

HOBBS +BLACK ASSOCIATES INC
Architects, Planners & Interior Designers
100 N. State Street
Ann Arbor, Michigan 48104
(313) 663-4189
215 S. Washington
Lansing, Michigan 48933
(517) 484-4870

AMENDMENT NO. 3
1A REV'S 1
1A REV'S 2

Revisions
Date

