


three inches = one foot  
one and one half inch = one foot  
one inch = one foot  
three quarters inch = one foot  
one half inch = one foot  
three eighths inch = one foot  
one quarter inch = one foot  
one eighth inch = one foot

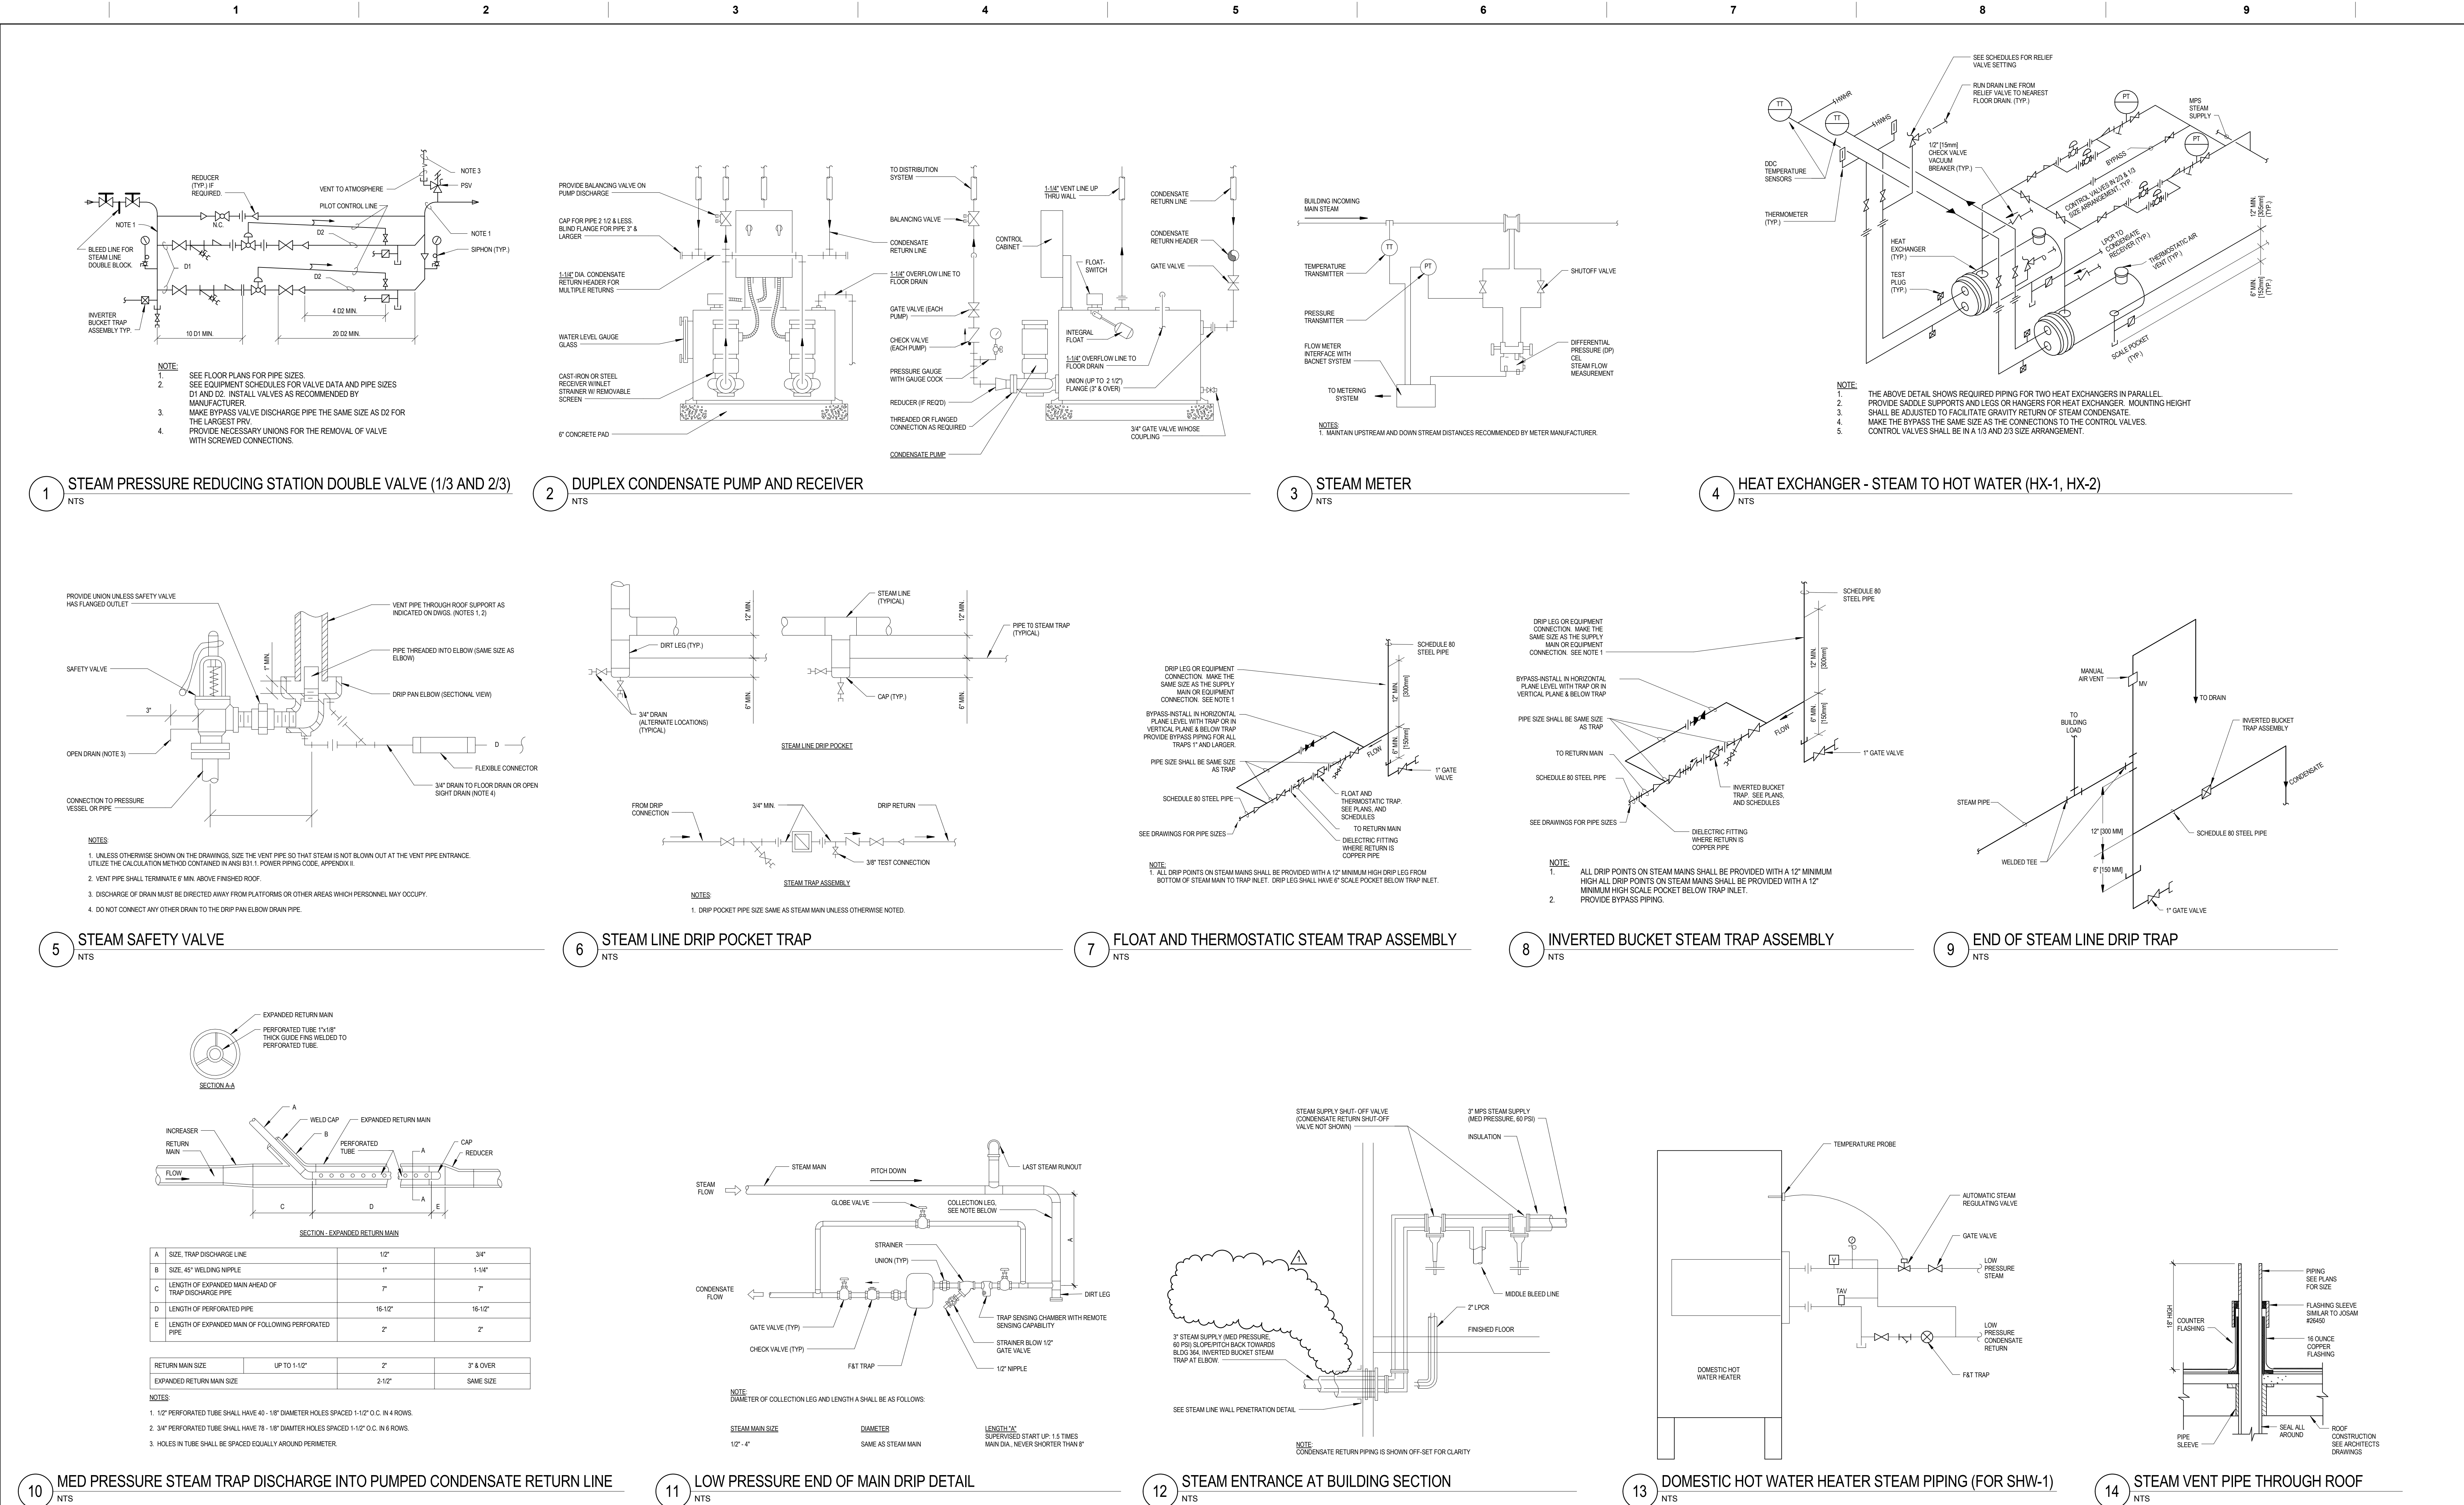

<b>CONSULTANTS:</b>  HOPE FURRER Associates, Inc.		<b>SEAL</b>  STATE OF MARYLAND PROFESSIONAL ENGINEER 43293 MECHANICAL ENGINEERING		<b>ARCHITECTS/ENGINEERS:</b>  AE WORKS 6587 Hamilton Avenue Pittsburgh, Pennsylvania 15206 Ph: 412.287.7333 Fax: 412.287.7334 www.ae-works.com AE Works Project Number: 12028		<b>Drawing Title</b> HVAC DETAILS		<b>Project Title:</b> Construct a New Residential Rehabilitation Treatment Program (RTP) Building		<b>Project Number</b> 512-531		<b>Office of Construction and Facilities Management</b> 	
<b>Approved: Project Director</b>		<b>Location:</b> Perry Point VA Medical Center Perry Point, MD 21902		<b>Date:</b> 06 - 11 - 15		<b>Checked:</b> J/KG		<b>Drawn:</b> C/JC		<b>Building Number</b>			
<b># Revision</b>		<b>Date</b>		<b>1</b> ADDENDUM 5		<b>2-2-16</b>		<b>Drawing Number</b> H505					

FULLY SPRINKLERED  
BID DOCUMENTS