
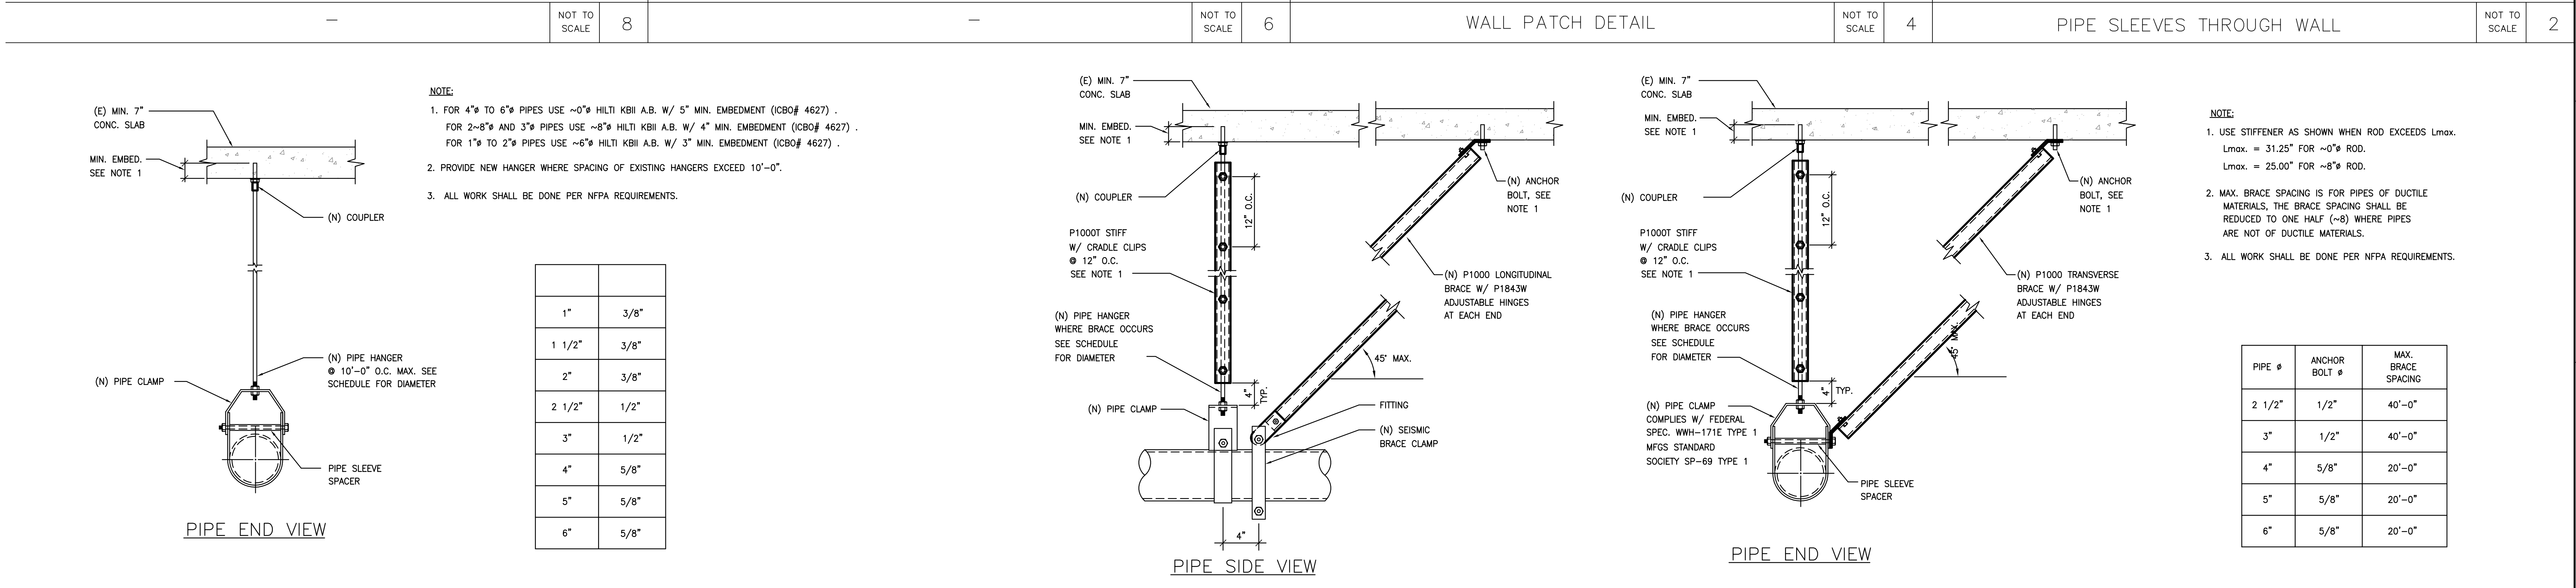
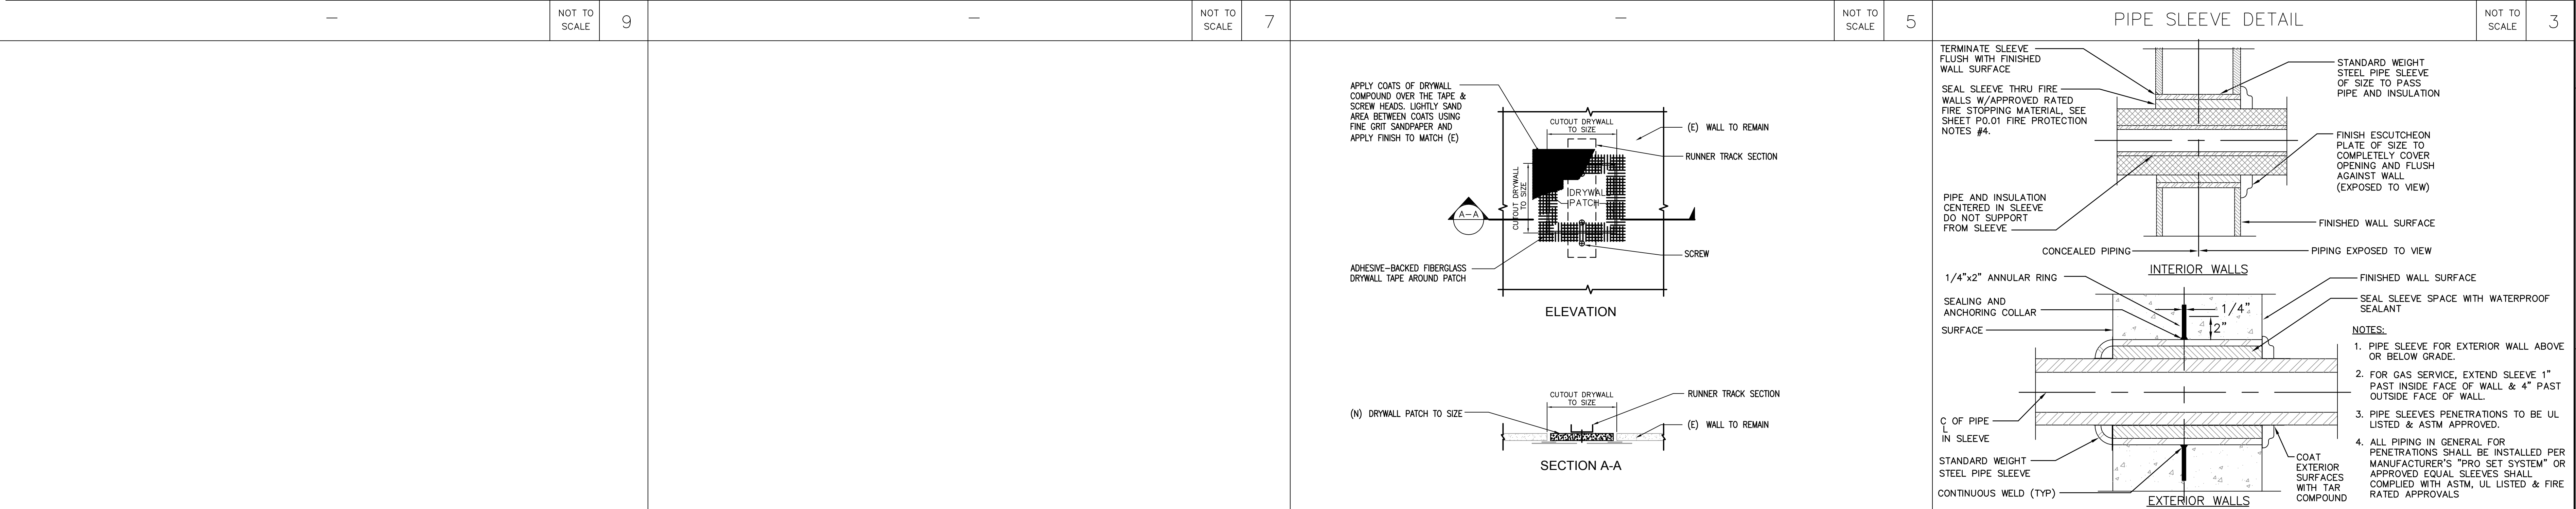


three inches = one foot  
one and one half inches = one foot  
one inch = one foot  
three quarters inch = one foot  
three eighths inch = one foot  
one half inch = one foot  
one quarter inch = one foot  
one eighth inch = one foot  
one eighth inch = one foot

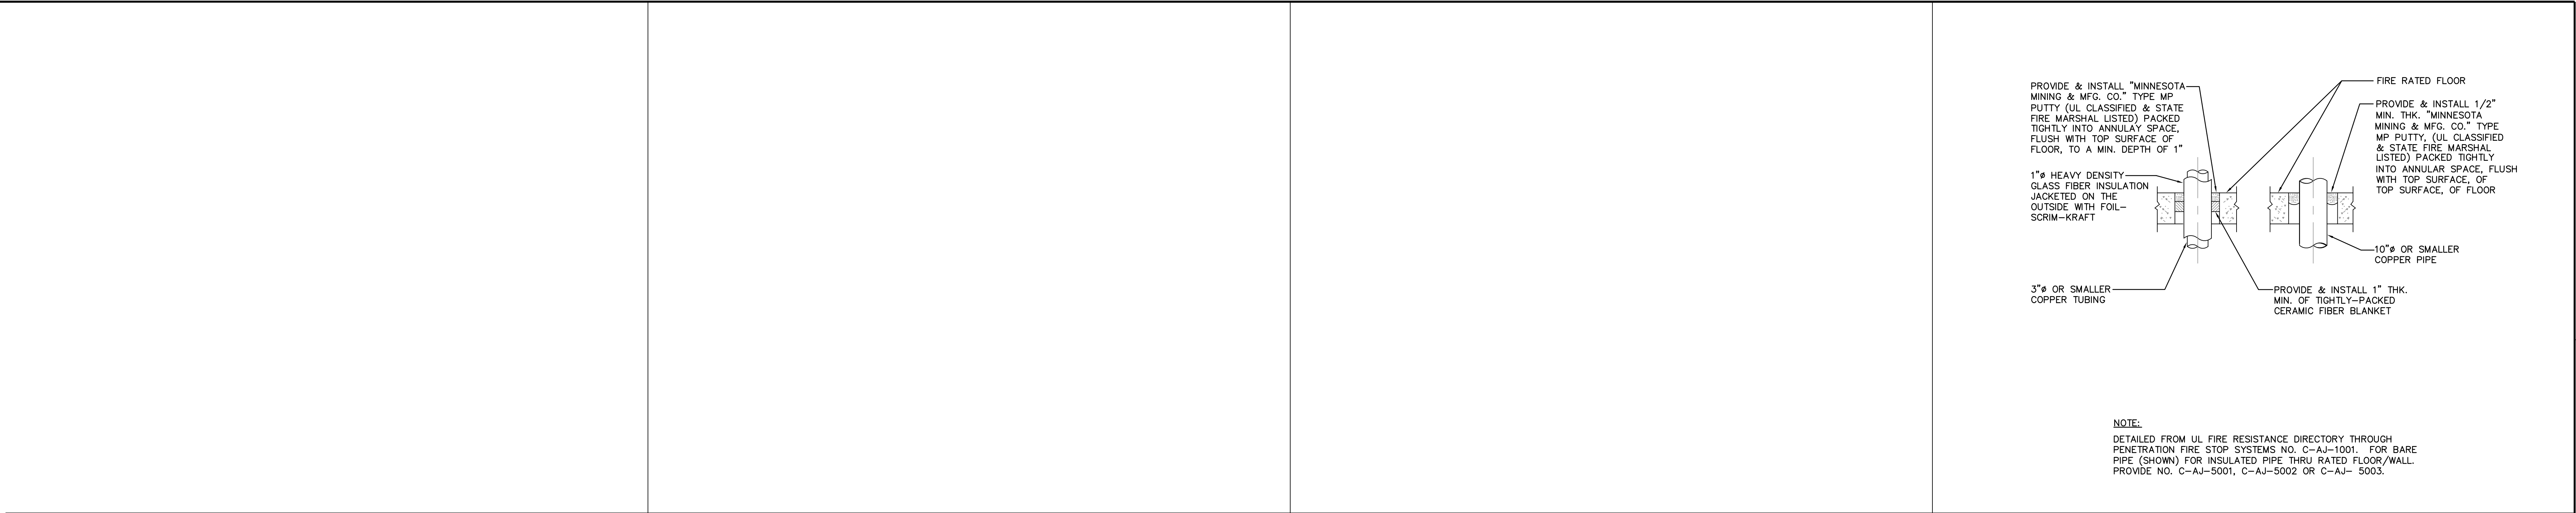

100% CD SUBMITTAL

08/05/15

ARCHITECT/ENGINEERS/CONSULTANTS:

Schwab

Engineering & Management

A Certified SB/DVBE Firm

1000 E. Walnut Street, Suite 227, Pasadena, CA 91106

t: 888.900.3823 f: 626.463.2739 www.schwabeng.com

Project No.: 0215.182.00

PROFESSIONAL ENGINEER

NO. 4025446

Exp. 06/30/17

MECHANICAL

STATE OF CALIFORNIA

VA PROJECT ENGINEER (138E)

CHIEF, OCCUPATIONAL SAFETY AND HEALTH (130)

CHIEF, PROJECT SECTION (138E)

CHIEF, ENV. MANAGEMENT DEPT. (137)

CHIEF, MAINT. & OPERATIONS OFFICE (138F)

DIR., FACILITIES MANAGEMENT (10A4)

CHIEF, ENGINEERING DEPT. (138)

CHIEF OF STAFF (11)

Drawing Title

PLUMBING DETAILS

Associate Director, Administration & Support Services (10A)

DIRECTOR (00)

Project Title

CORRECT POTABLE WATER DEFICIENCIES - BUILDING 256/257

Location

VA MEDICAL CENTER WEST LOS ANGELES, CA 90073

Date

APRIL 14, 2015

Checked

WM

Drawn

LC

Project Number

691-15-115-WL

Building Number

256/257

Drawing Number

P501

Dwg. 20 of 20

Office of Facilities Management

Department of Veterans Affairs

VA FORM 08-6231, OCT 1978

100% CD SUBMITTAL