


three inches = one foot  
one and one half inches = one foot  
one inch = one foot  
three quarters inch = one foot  
one half inch = one foot  
three eighths inch = one foot  
one quarter inch = one foot  
one eighth inch = one foot

FOR CONTINUATION SEE CG103


FOR CONTINUATION SEE CG102

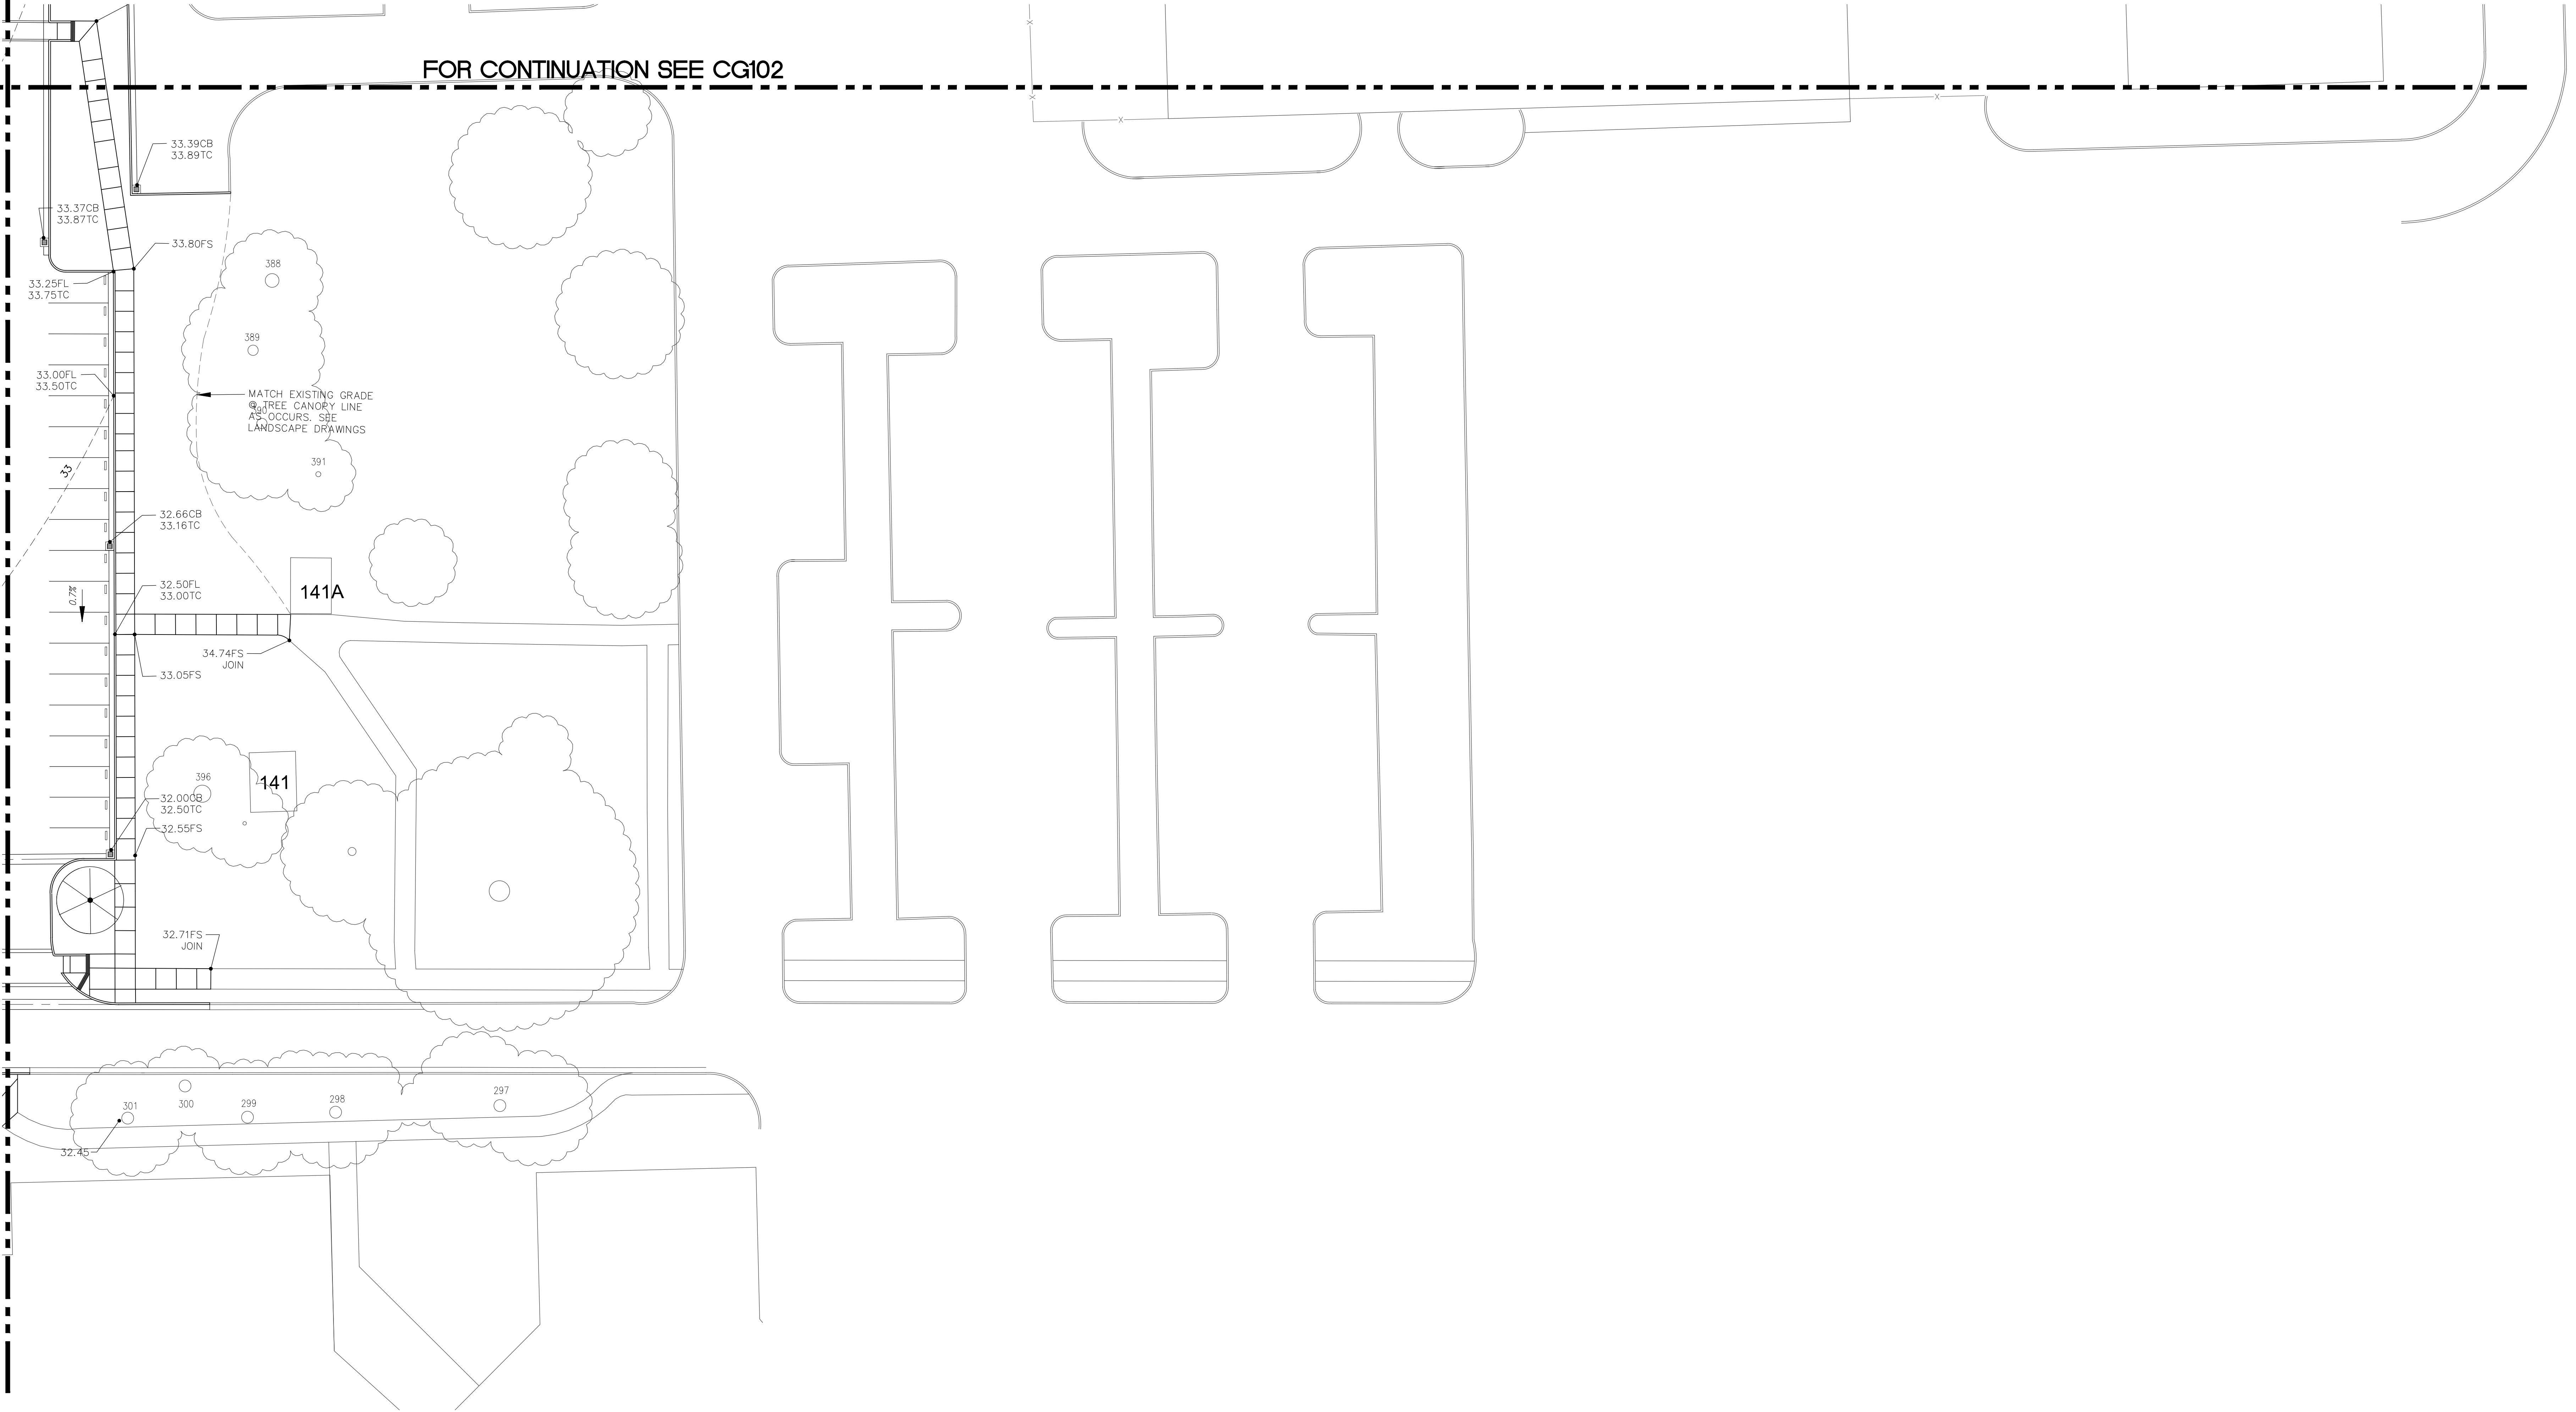

SHEET NOTES

1. ALL CONFORM GRADES ARE BASED ON TOPOGRAPHIC SURVEY. CONTRACTOR SHALL VERIFY CONFORM ELEVATIONS PRIOR TO CONSTRUCTION & NOTIFY COR OF ANY DISCREPANCY.
2. SEE SHEET LT200 FOR TREE PROTECTION AND DEMOLITION

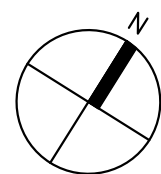


1 GRADING AND DRAINAGE PLAN AREA 4  
1" = 20'-0"



AREA 1	AREA 2
AREA 3	AREA 4

KEY PLAN

100% CONSTRUCTION DOCUMENTS-NOT FOR CONSTRUCTION

<b>CONSULTANTS:</b>  <b>CARDUCCI &amp; ASSOCIATES, INC.</b> LANDSCAPE ARCHITECTURE PLANNING IRRIGATION DESIGN URBAN DESIGN 555 BEACH STREET, 4TH FLOOR SAN FRANCISCO, CALIFORNIA 94133 PHONE (415) 674-0990 FAX (415) 674-0999 © 2015 CARDUCCI & ASSOCIATES, INC.		<b>Stamp and Signature</b>  <b>ARSENIO ORTEGA, P.E.</b> <b>CONSULTING ENGINEER</b> 5 Third Street, Suite 716 San Francisco, CA 94103 (415) 546-0490 tel -0491 fax		<b>ARCHITECT/ENGINEERS:</b>  <b>ENGINEERS ARCHITECTS</b> ONE KAISER PLAZA SUITE 445 OAKLAND CALIFORNIA 94612 TEL 510.271.6701 FAX 510.271.6707 ©THE KPA GROUP 2015 KPA Project No. 593.00		<b>Drawing Title</b> GRADING AND DRAINAGE PLAN AREA 4 <b>Approved Project Director</b> - VAPAHCS PLANNING AND ENGINEERING		<b>Project Title</b> UPGRADE CAMPUS PARKING/CIRCULATION <b>Location</b> VAPAHCS, MPD MENLO PARK, CA <b>Date</b> 04/17/2015 <b>Checked</b> PWP <b>Drawn</b> KPA TEAM		<b>Project Number</b> 640AO-15-102 <b>Building Number</b>  <b>Drawing Number</b> CG104 Dwg. of		<b>Office of Construction and Facilities Management</b> 	
--	--	---	--	--	--	--	--	---	--	--	--	--	--