



**DUCTWORK FLOOR PLAN - 9th FLOOR**  
SCALE: 1 / 8" = 1'-0"

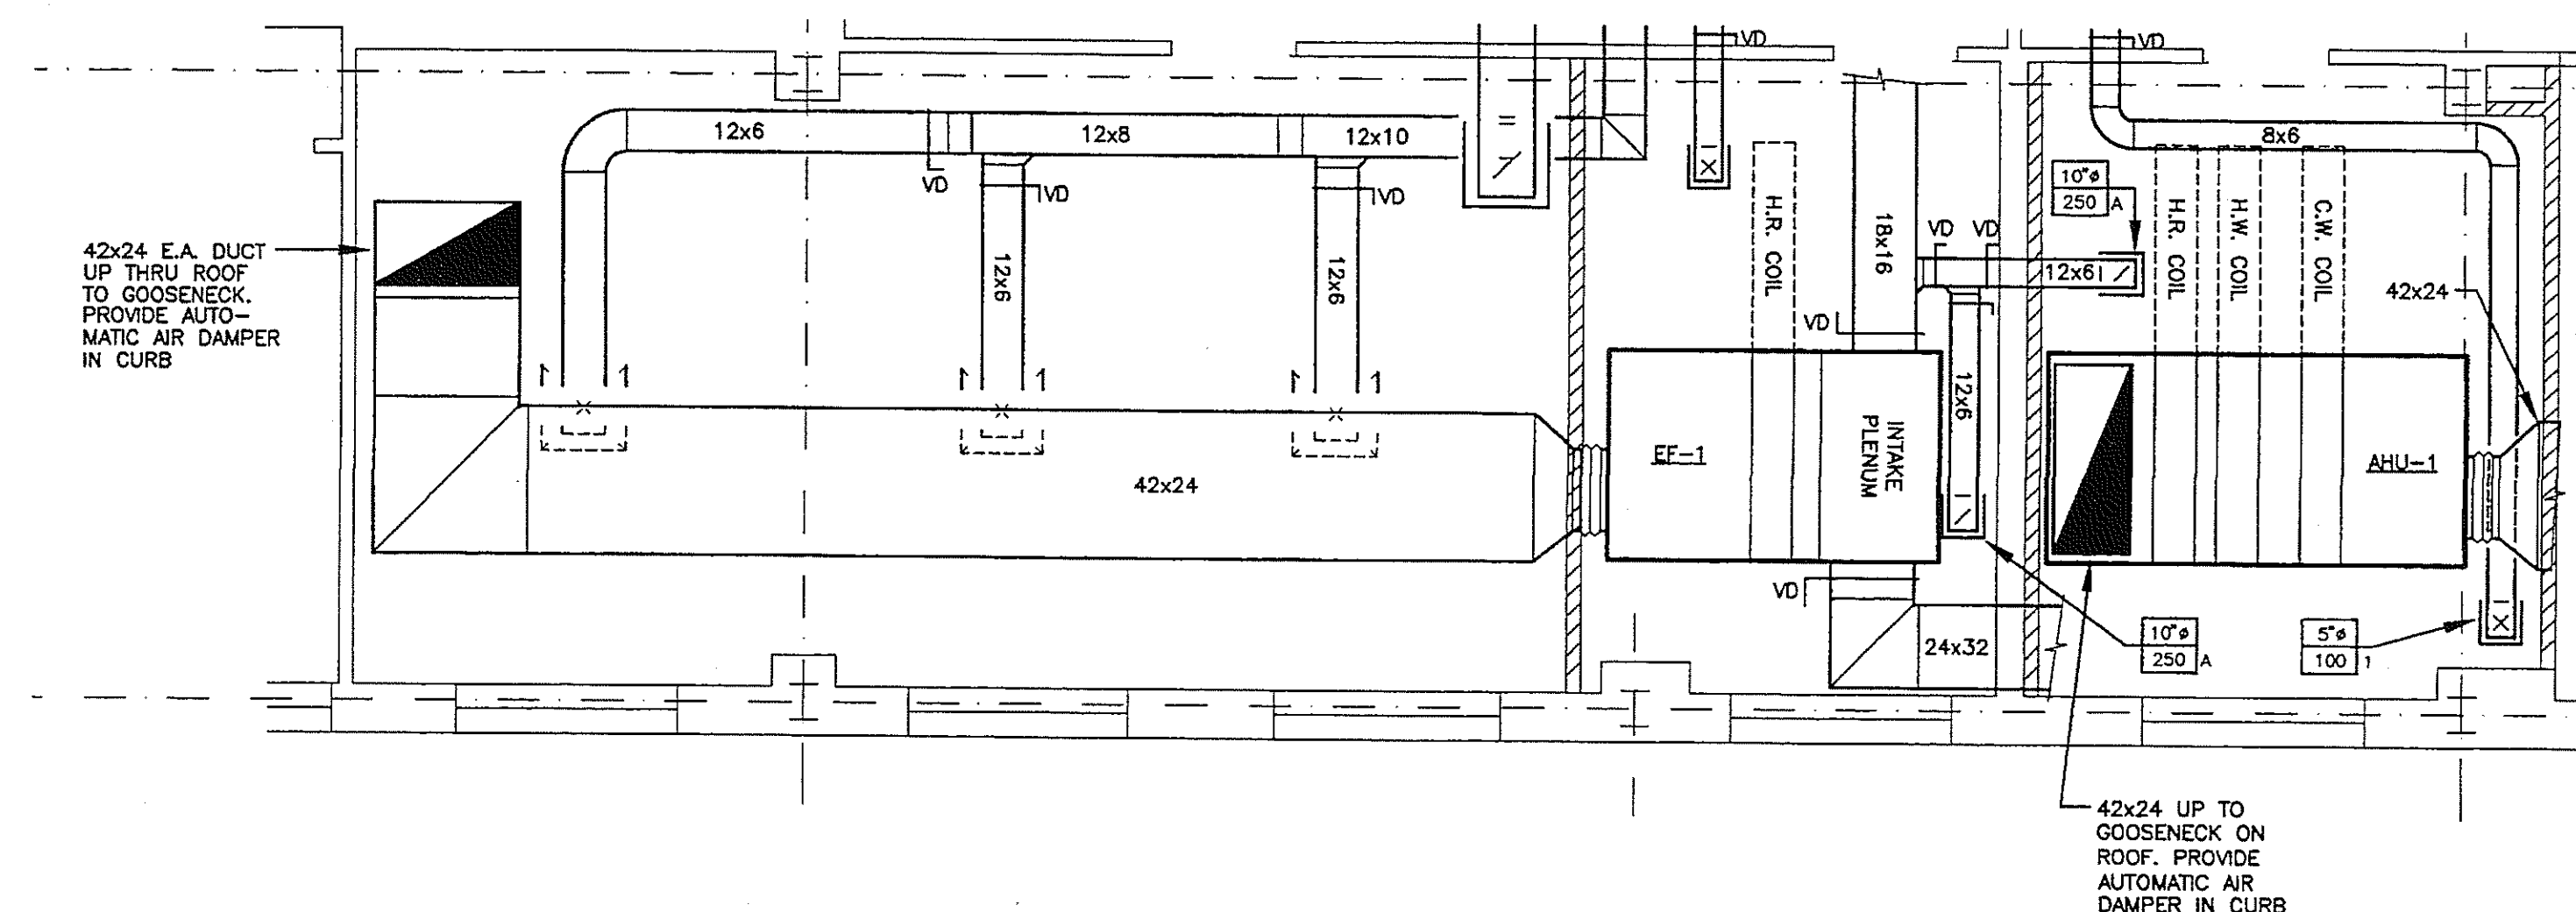


**PARTIAL DUCTWORK FLOOR PLAN - 9th FLOOR**  
SCALE: 1 / 4" = 1'-0"

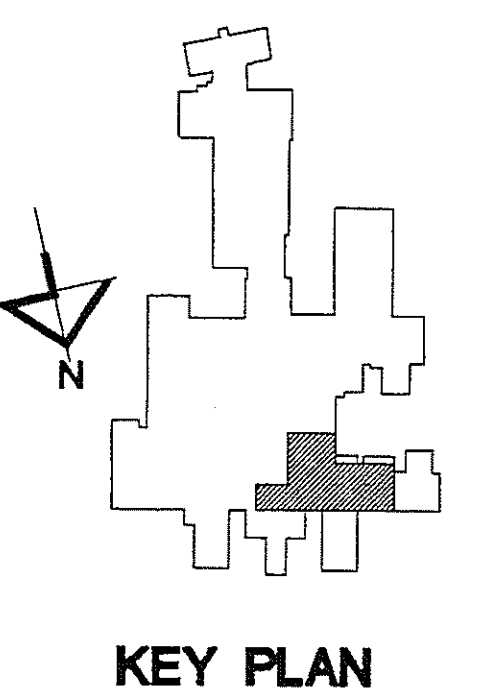


Revisions Date	State of New York Department of Veterans Affairs Professional Seal	JCM ARCHITECTURAL ASSOCIATES 300 Hawley Avenue, Syracuse, NY 13203 315.424.0141 Fax 478.2053 E-Mail: JCM300@AOL.COM	RAM-TECH Engineers, P.C. Ramon & Borick Technical Services, Inc. 6100 Fairway Drive P.O. Box 10 Syracuse New York 13211-0010 Tel: (315) 463-7716 Fax: (315) 463-7758	Drawing Title <b>9th FLOOR - WEST FLOOR PLAN - DUCTWORK</b>		Project Title <b>PHASE V : RENOVATE FOR MANAGED CARE</b>		Date <b>APRIL 7, 1998</b>			
				Approved Medical Center Director		Building Number <b>1</b>		Checked <b>RR</b>		Drawn <b>CTL</b>	
				Approved Chief Engineering Service		Location <b>VAMC SYRACUSE, N.Y.</b>		Drawing No. <b>1-H-2</b>		SHEET 8 OF 17	
				Approved Service Chief		Location <b>VAMC SYRACUSE, N.Y.</b>		Drawing No. <b>1-H-2</b>		SHEET 8 OF 17	

Department of Veterans Affairs

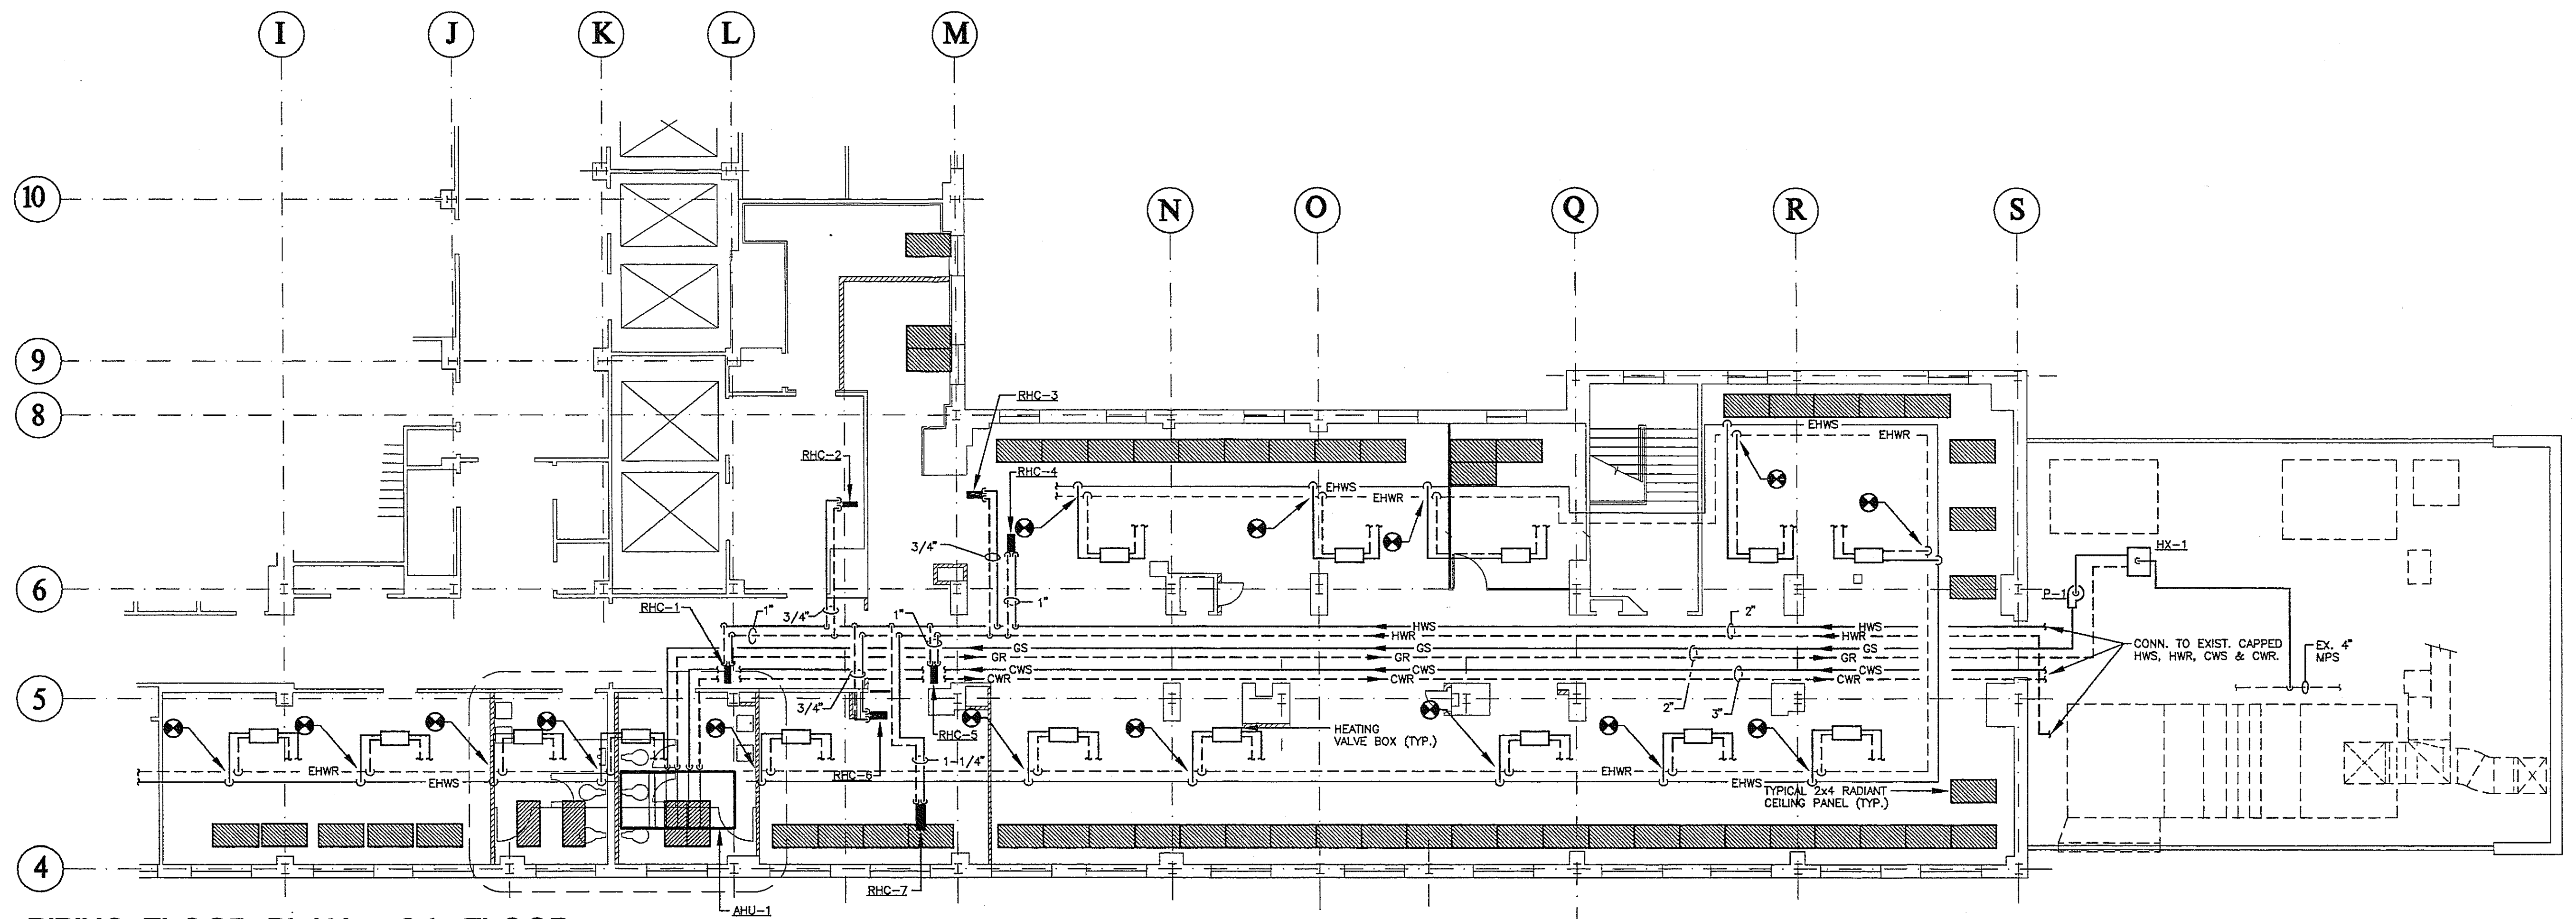


**PIPING FLOOR PLAN - 9th FLOOR**

SCALE: 1 / 8" = 1'-0"

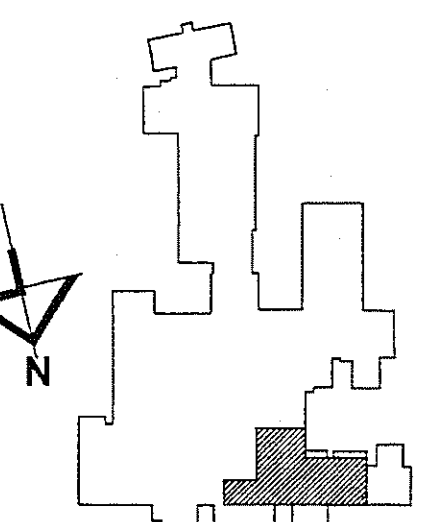

**KEY PLAN**

Revisions	Date

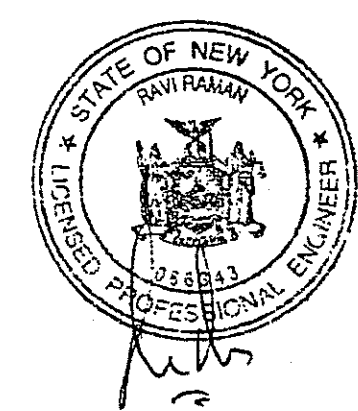

**JCM ARCHITECTURAL ASSOCIATES**  
 300 Hawley Avenue, Syracuse, NY 13203  
 315.424.0141 Fax: 478.8053  
 E-Mail: JCM300@AOL.COM

**RAM-TECH Engineers, P.C.**  
 Ramon & Borick Technical Services, Inc.  
 6100 Fairway Drive P.O. Box 10 Syracuse New York 13211-0010  
 Tel: (315) 463-7716 Fax: (315) 463-7738

Drawing Title	9th FLOOR - WEST FLOOR PLAN - PIPING
Approved Medical Center Director	
Approved Chief Engineering Service	
Approved Service Chief	

Project Title	PHASE V : RENOVATE FOR MANAGED CARE
Building Number	1
Location	VAMC SYRACUSE, N.Y.

Date	APRIL 7, 1998
Project No.	670-365
Drawing No.	1-H-3
SHEET	9 OF 17

Department of Veterans Affairs





