

BUILDING DIRECTORY

- 1 OUTPATIENT CLINICS, ADMINISTRATION OFFICES AND RESEARCH

2 FMS, FISCAL, SAFETY OFFICES

3 ENGINEERING SHOPS

4 VACANT

5 POWER HOUSE

7 STRUCTURES SHOP

8 ENGINEERING, ORTHOPEDIC SHOPS and RECREATION CENTER

9 RECREATION, VOLUNTARY AND PROSTHETICS SERVICES

12 VACANT

13 VACANT

14 CATHOLIC CHARITIES

15 UNDERGROUND WATER RESERVOIR (700,000 GALLON)

16 I. G. OFFICE OF AUDIT

17 HUMAN RESOURCES

18 VISN 12 OFFICES
- 19 BASEBALL FIELD and SEATING STAND

20 MOTOR POOL

21 MAINTENANCE STORAGE

23 HOUSEKEEPING QUARTERS

24 HOUSEKEEPING QUARTERS

25 HOUSEKEEPING QUARTERS

26 HOUSEKEEPING QUARTERS

27 HOUSEKEEPING QUARTERS

28 HOUSEKEEPING QUARTERS

29 HOUSEKEEPING QUARTERS

30 STORAGE

31 PERSONNEL GARAGE

32 PERSONNEL GARAGE

33 RADIATION LABORATORY

34 GEORGE DILBOY MEMORIAL STATUE

35 MAIN GATE HOUSE
- 37 V. A. SUPPLY DEPOT

~~39 INCINERATOR~~

42 FLAG POLE

45 CANTEEN & POST OFFICE

46 FORMER GOLF COURSE RECREATION BUILDING

47 GAS METER HOUSE

48 LAUNDRY DISTRIBUTION AND JESSE BROWN SRORAGE

51 VACANT

53 CATHOLIC CHARITIES

100 FISHER HOUSE FOUNDATION

113 BLIND REHABILITATION CENTER

128 SPINAL CORD INJURY AND DISORDERS CENTER

195 WATER STORAGE TANK (1,000,000 GALLON)

197 VALVE HOUSE

200 MAIN HOSPITAL

201 OXYGEN STORAGE
- 202 ELECTRICAL SUBSTATION

203 PATIENT RECREATION PAVILION

204 GREENHOUSE

215 DATA PROCESSING CENTER

217 EXTENDED CARE

218 EMERGENCY GENERATOR FOR BUILDING 217

219 COOLING TOWER FOR BUILDING 217

220 WAREHOUSE/SERVICE BUILDING

221 RCF LONG TERM SPINAL CORD INJURY UNIT

222 EMERGENCY GENERATOR BUILDING

223 EMERGENCY GENERATOR BUILDING

224 EMERGENCY GENERATOR BUILDING

225 EMERGENCY GENERATOR BUILDING

226 EMERGENCY GENERATOR BUILDING
- 227 EMERGENCY GENERATOR BUILDING

228 PSYCHIATRY BLDG.

229 RESEARCH BLDG.


230 OLD MRI BUILDING (OCCUPIED BY JOC CONTRACTORS.)

231 SALT STORAGE

232 RONALD McDONALD HOUSE

300 TRAILER (OCCUPIED BY JOC CONTRACTORS.)

* INDICATES STRUCTURE NOT MAINTAINED BY HINES FACILITY MANAGEMENT. OR ITS ASSOCIATES.

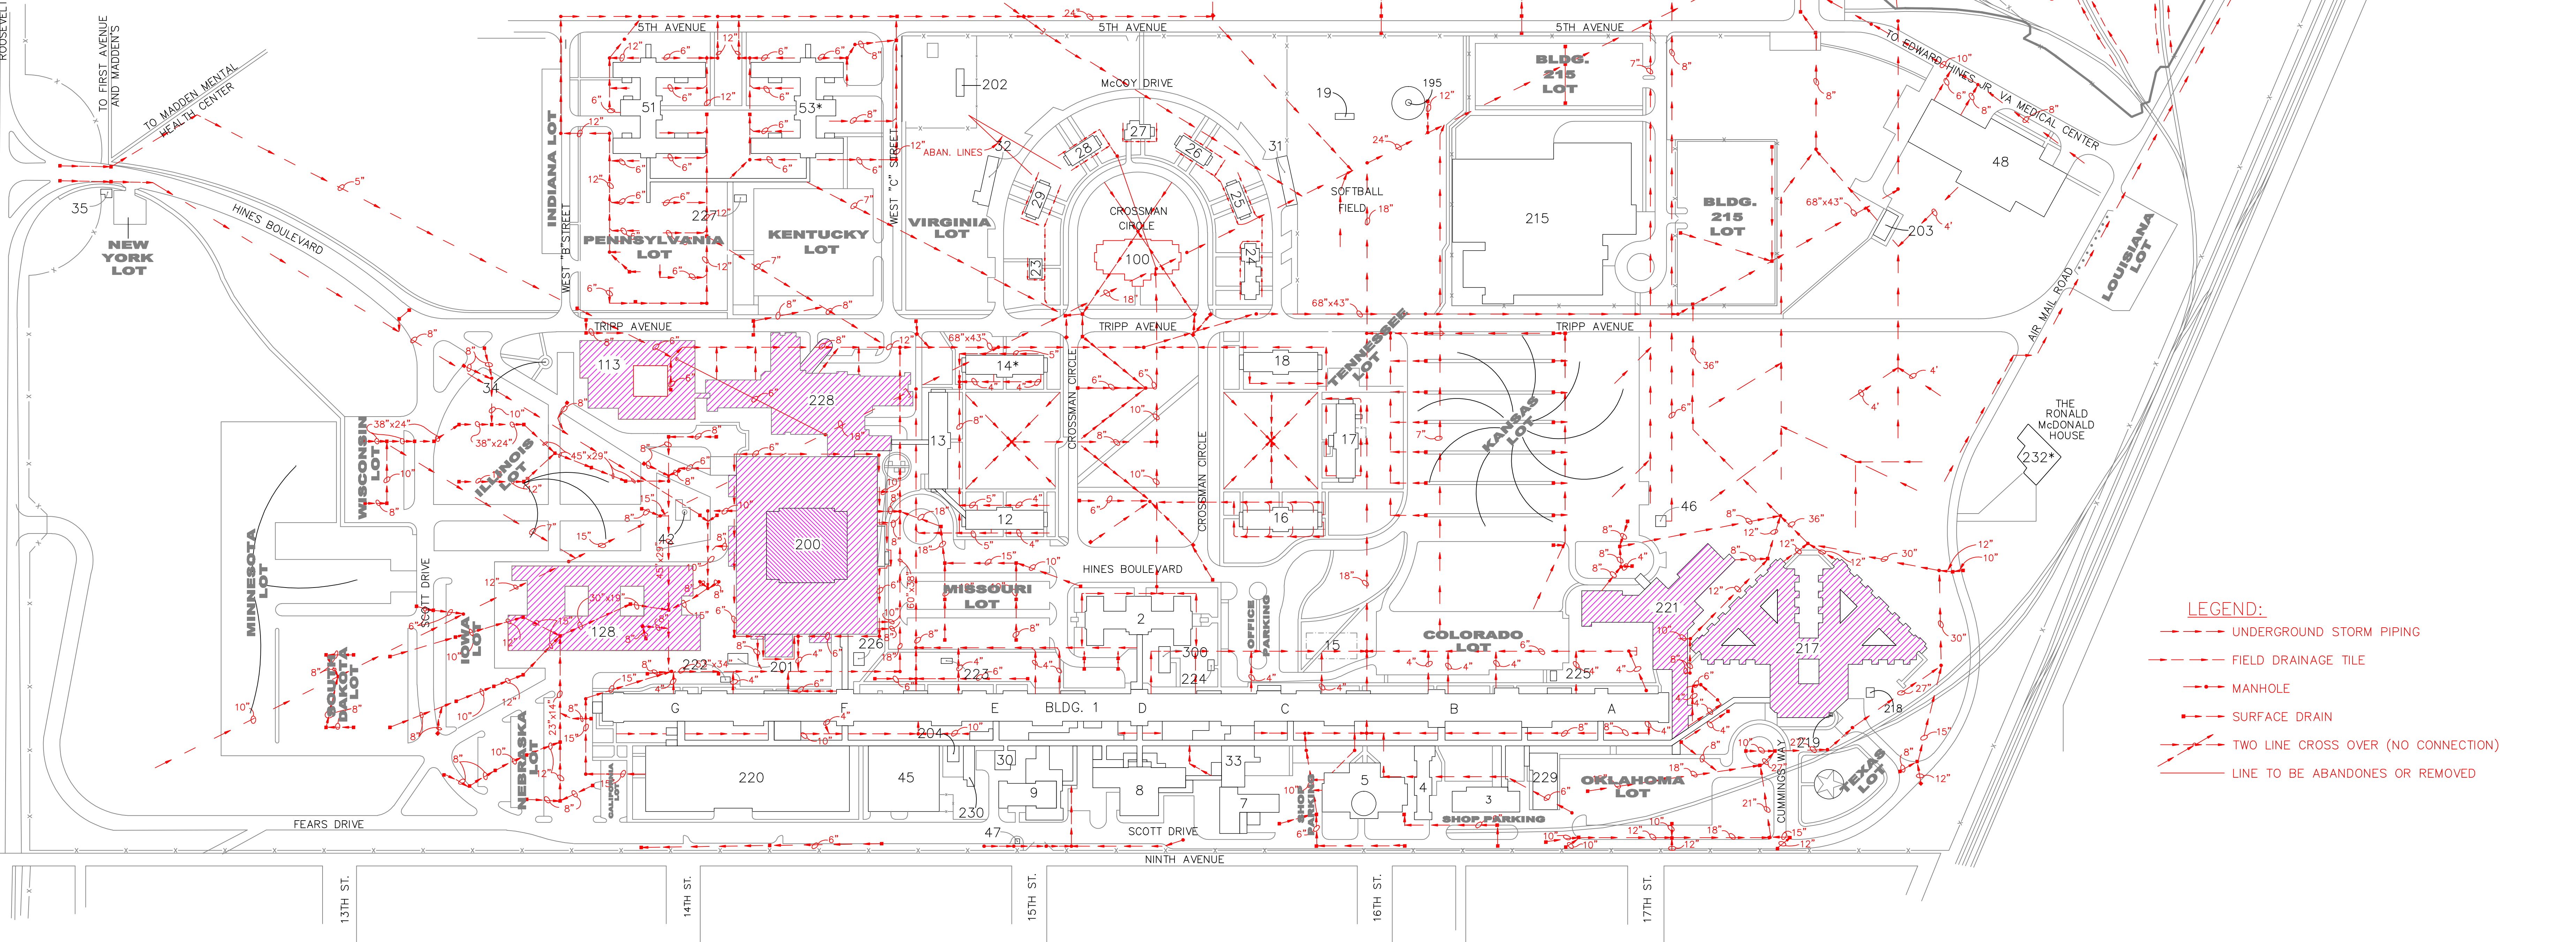

- LEGEND:
- UNDERGROUND STORM PIPING
 - FIELD DRAINAGE TILE
 - MANHOLE
 - SURFACE DRAIN
 - TWO LINE CROSS OVER (NO CONNECTION)
 - LINE TO BE ABANDONES OR REMOVED

PARKING SUPPLY AND LOT DESIGNATIONS • HNES VAMC: OVERALL TOTAL OF 2,734

CALIFORNIA	31	MINNESOTA	381	TEXAS	37	BLDG 5/7	32
COLORADO	118	MISSOURI	163	VIRGINIA	100	BLDG 8/9	9
ILLINOIS	147	NEBRASKA	133	WISCONSIN	70	BLDG 12	16
INDIANA	74	OKLAHOMA	101	9TH AVENUE	86	BLDG 16	6
IOWA	112	PENNSYLVANIA	150	BLDG 1 (OFC.)	25	BLDG 113	10
KANSAS	317	SOUTH DAKOTA	224	BLDG 2	47	BLDG 221	150
KENTUCKY	162	TENNESSEE	12	BLDG 3/4	18	BLDG 228	3

ADDED EXISTING PARKING SUPPLY INFORMATION BASED ON SURVEY.	6/30/10
BLDG. 39-INCINERATOR DEMOLISHED. NOT USED. INCINERATOR OBSOLETE.	7/14/08
SITE PLAN UPDATED FOR CLARITY.	2/6/08
Revisions	Date

STORM DRAIN

SITE PLAN

Approved: Division Chief

Building No.
GROUNDS

Checked
JC

Drawn
CC

DRAWING NO.
H-1418

Dwg. Of

Location
V.A. HOSPITAL, HINES, IL

Approved: Chief Maintenance & Repair

Approved: Service Director

Date
03/10/93

Project No.
578-

