


Outer Oval Road

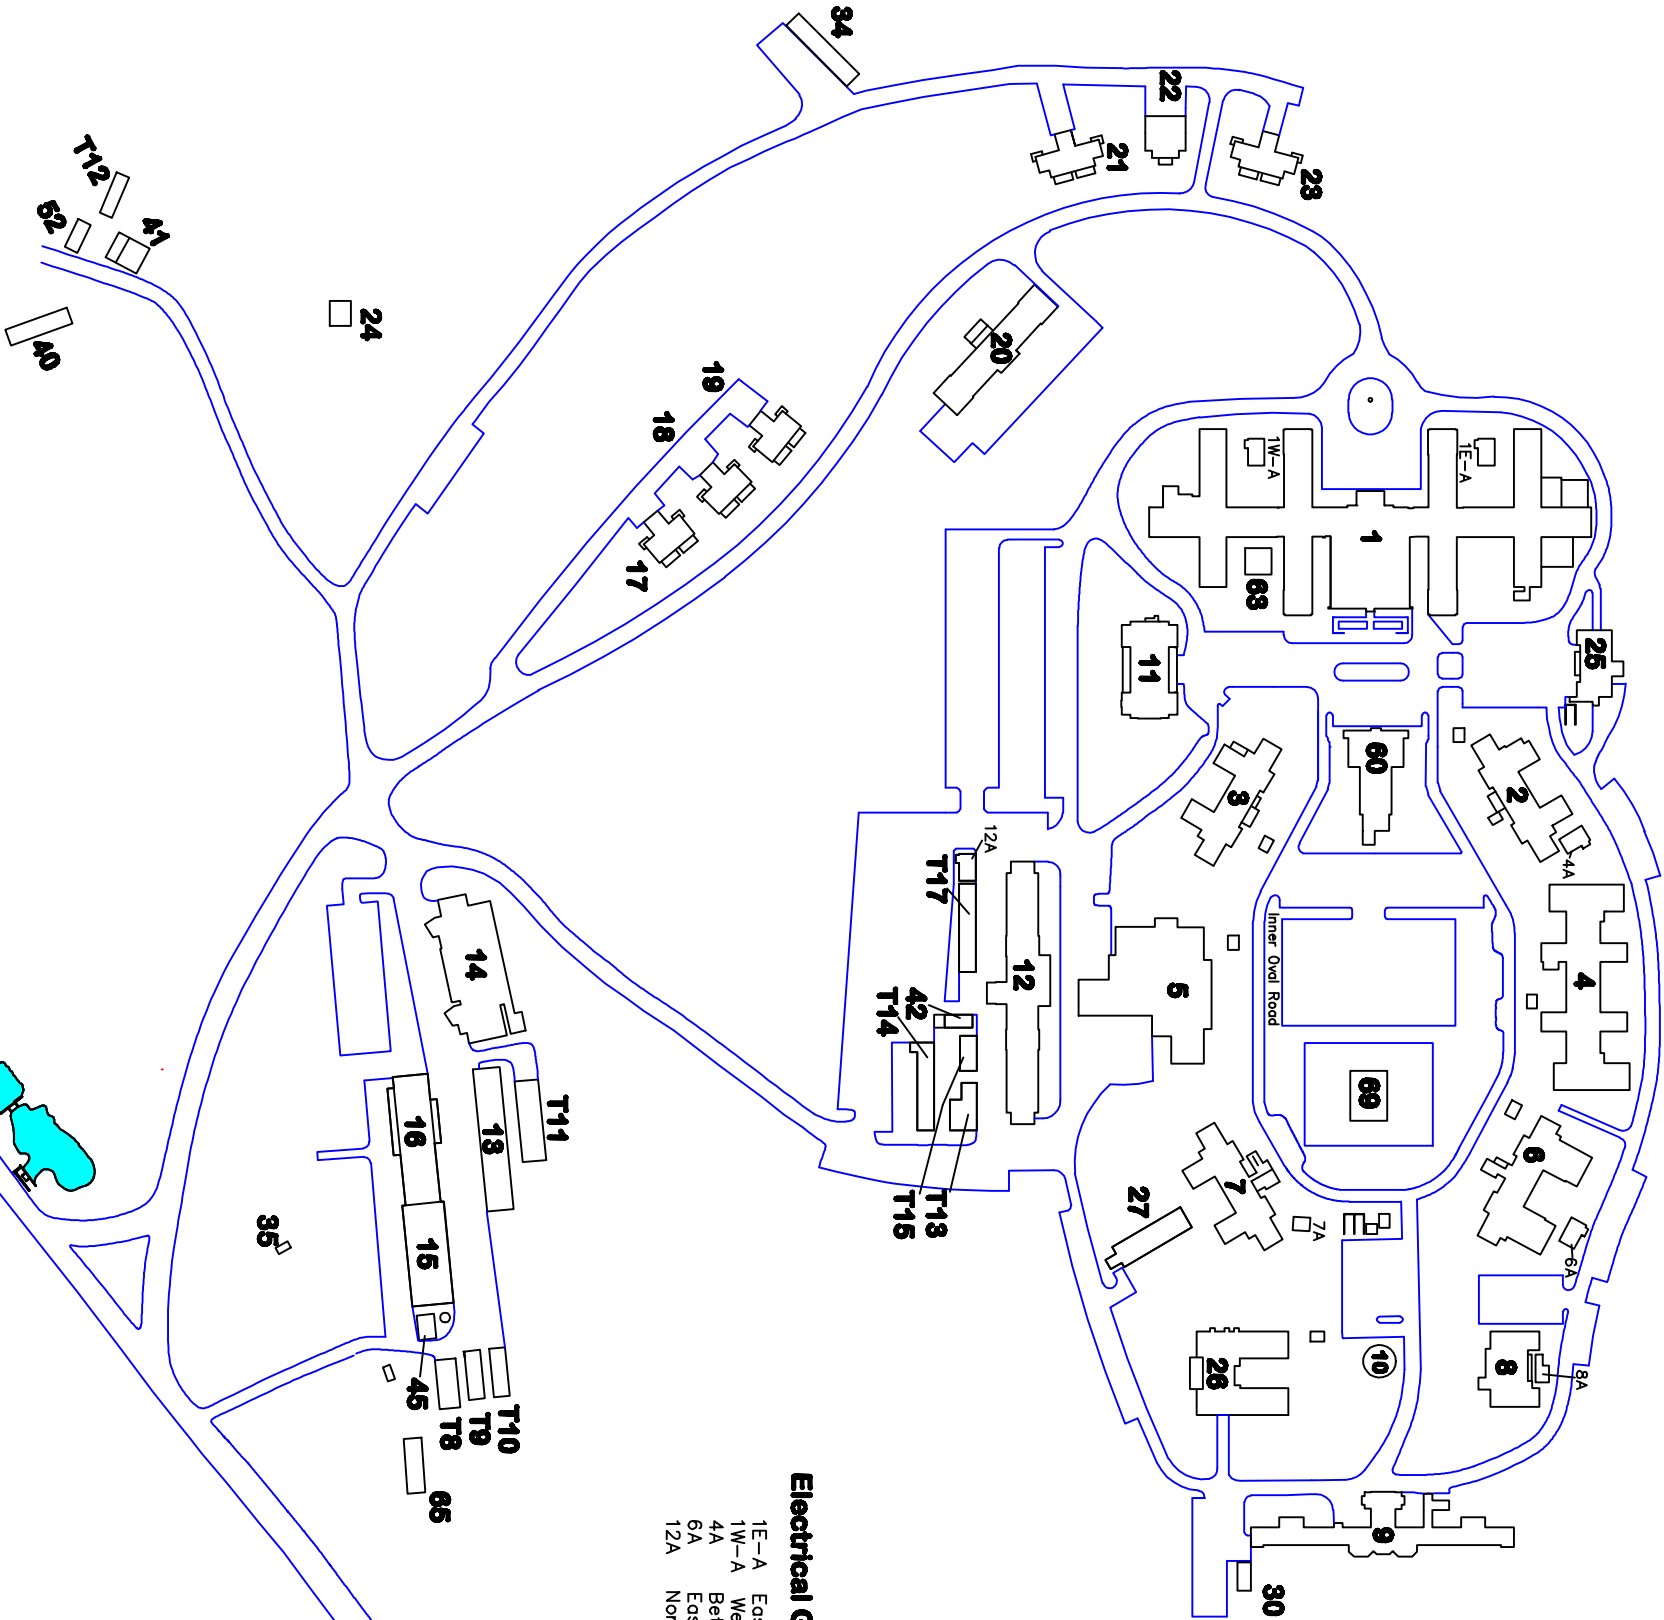

MAIN LEGEND - Building Numbers

1. Main Hospital: Admissions, Discharge, Police, and Security,
2. Information resource Mgmt and Switchboard
3. Engineering and Personnel
4. Substance Abuse
5. Kitchen
6. United Veterans Shelter
7. Ward 7
8. Ward 8 (PTSD Unit)
9. Long Term Care & Incentive Therapy
10. Water Tower
11. Recreation/Auditorium
12. Director's Office, Fiscal, Public Affairs
13. Motor Pool – Transportation
14. Laundry
15. Boiler Plant
16. Warehouse
- 17–19. Quarters
20. Social Work, Day Care, Temp. Quarters. NDMS
- 21–23. Quarters
24. Picnic Shelter
25. Education
26. United Veterans of America
27. Horticulture/Green House
30. Greenhouse
34. Garage/Storage
35. Meter House
40. Storage
41. Storage
42. Point Storage
45. Steam Sterilizer and Generator
48. Flagpole North side of Bldg 1
52. Storage
60. Chapel
63. Greenhouse (Bldg 1)
65. Main Electrical Switchgear
69. Open Air Chapel/Pavilion

T - Buildings

 
- T7 Storage
- T8 Storage
- T9 Storage
- T10 Storage
- T11 Storage
- T12 Storage
- T13 Storage
- T14 Storage
- T15 Storage

Electrical Generator Bldg

- 1E–A East end of Bldg 1
- 1W–A West end of Bldg 1
- 4A Between Bldg 2 and 4
- 6A East side of Bldg 6
- 12A Northwest end of Bldg 12

Switch House

- 7A East side of Bldg 7
- 8A East side of Bldg 8



North Arrow
Call on East Side of Map to locate area.
Direction 000.77

VAMC
SITE PLAN
NORTHAMPTON, MA

Drawing Title			Date	
General Building Layout & Site Plan			08/2006	
Building Number	Checked	Drawn GT	Proj No.	
			Drawing No.	
Location				
Northampton VA Medical Center 421 North Main St, Leeds, MA 01053				

