



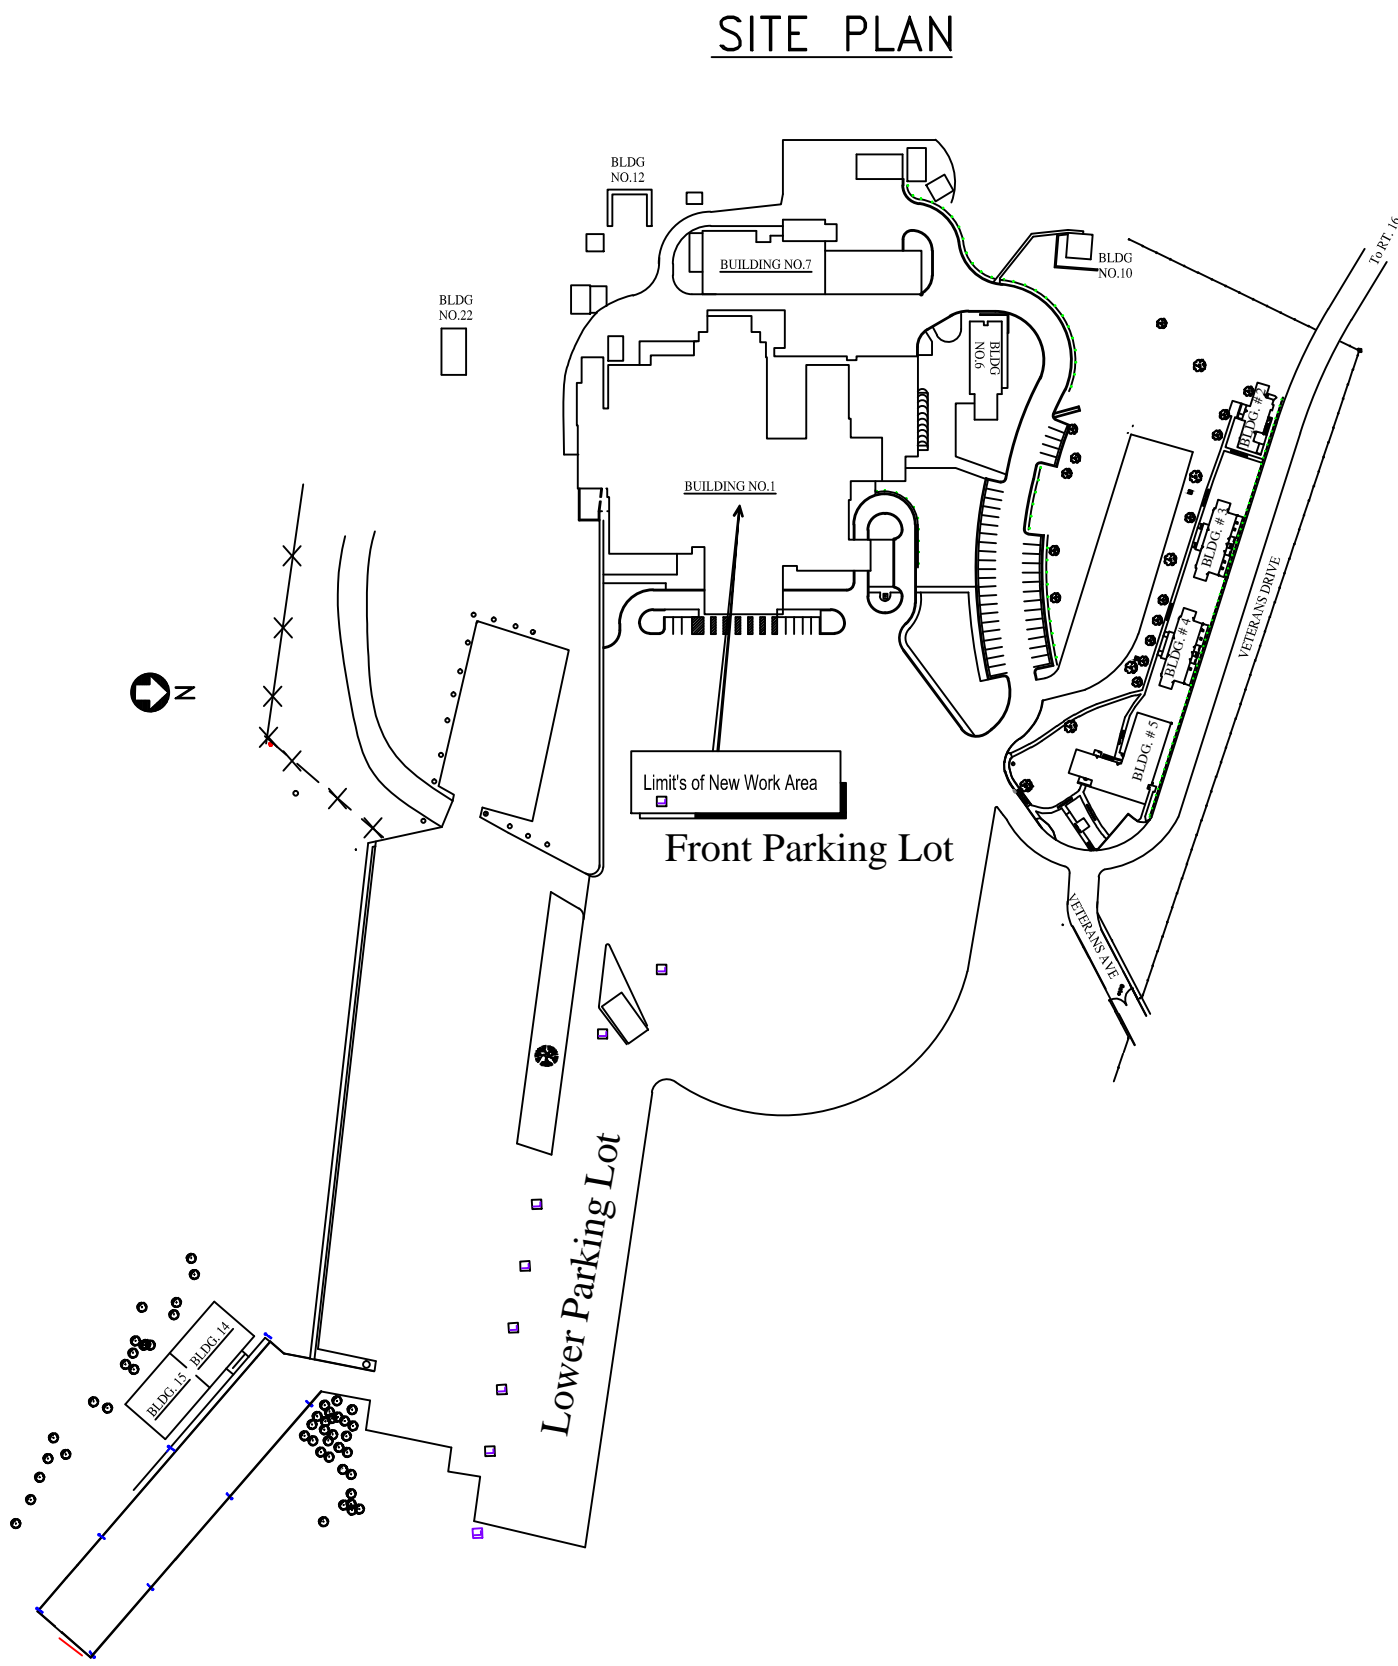

DEPARTMENT OF VETERANS AFFAIRS MEDICAL CENTER
200 VETERANS AVENUE
BECKLEY, WV 25801
PROJECT NO. 517-16-112
Legionella Prevention Corrections

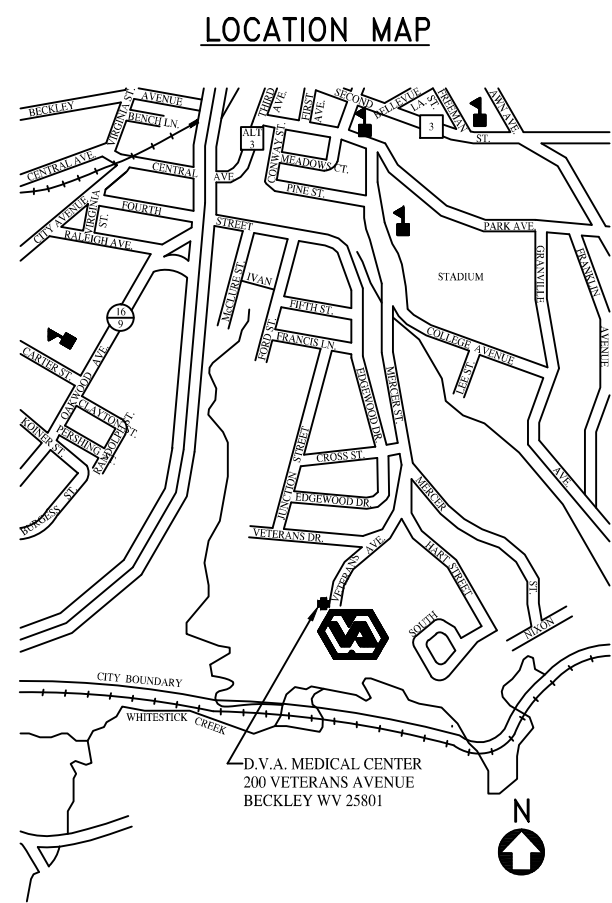


PROJECT DRAWING INDEX

DRAWING NUMBER	DRAWING TITLE
GI-001	Site Plan & Title Sheet
(Alt. Deduct #2) PL-100	Basement - Mixing Valve Locations
PL-101	Third Floor - Mixing Valve Locations
PL-102	Fourth Floor - Mixing Valve Locations
(Alt. Deduct #1) PL-103	Fifth Floor - Mixing Valve Locations
PL-104	Sixth Floor - Ball Valve Locations
PL-105	Details

GENERAL NOTES

- ALL WORK SHALL COMPLY WITH ANY & ALL BUILDING CODES, REGULATIONS AND REQUIREMENTS ADOPTED BY THE AUTHORITIES HAVING JURISDICTION. IT IS THE RESPONSIBILITY OF THE CONTRACTORS TO COMPLY WITH THE APPROPRIATE SECTION OF THE CODE DURING EACH PHASE OF THE WORK.
- THE INFORMATION SHOWN REGARDING EXISTING CONDITIONS ON ALL DRAWINGS AND AS NOTED ELSEWHERE WERE BASED ON FIELD OBSERVATIONS AS OF MARCH 2015. THE CONTRACTOR IS RESPONSIBLE TO FIELD VERIFY ANY AND ALL DIMENSIONS AND CONDITIONS PRIOR TO SUBMITTING A BID. DRAWINGS ARE NOT TO BE SCALED FOR LOCATIONS OR NEW WORK ITEMS.
- CONTRACTOR MUST HAVE PRIOR APPROVAL OF COR FOR ALL MATERIAL STORAGE, EQUIPMENT SETUP, AND STAGING FOR ALL DEMOLITION AND/OR NEW WORK.
- NORMAL MEDICAL CENTER WORK HOURS ARE 8:00AM TO 4:30PM M-F. CONTRACTORS WORK IS TO BE PERFORMED DURING OFF-NORMAL HOURS AS DIRECTED BY COR. ALL AND OR ANY UTILITY SHUT DOWNS MUST BE KEPT TO A MINIMUM AND COORDINATED WITH THE COR PRIOR TO AND IN ACCORDANCE WITH THE SPECIFICATIONS.
- CONTRACTORS ARE TO KEEP ALL ROADWAYS AND ENTRANCES TO THE MEDICAL CENTER OPEN AND/OR ACCESSIBLE AT ALL TIMES, UNLESS APPROVED BY THE COR.
- CONTRACT DRAWINGS AND SPECIFICATIONS REPRESENT A FINISHED PROJECT. THEY DO NOT INDICATE METHODS OF CONSTRUCTION. THE CONTRACTORS SHALL PROVIDE ALL MEASURES NECESSARY TO PROTECT THE STRUCTURE AND PERSONNEL DURING CONSTRUCTION. CONTRACTORS ARE TO KEEP THE MEDICAL CENTER CLEAN AND FREE FROM DEBRIS AT ALL TIMES.
- THESE DRAWINGS ARE DIAGRAMMATICAL AND SHOW ONLY THE INTENT OF WORK TO BE COMPLETED. THE CONTRACTOR IS RESPONSIBLE FOR PROVIDING ALL LABOR AND/OR MATERIALS FOR A COMPLETE WORKING SYSTEM AS REQUIRED. ANY ERRORS OR OMISSIONS SHOULD BE REPORTED TO THE COR.
- THE GOVERNMENT HAS SALVAGE RIGHTS TO ANY AND OR ALL EQUIPMENT OR MATERIAL BEING REMOVED UNDER THIS CONTRACT AS DIRECTED BY THE COR.
- THIS IS A WORKING HOSPITAL. AREA CONTRACTOR IS WORKING IN MUST BE KEEP CLEAN AT ALL TIMES. STAFF, PATIENTS CONTRACTOR CANNOT CLOSE AREAS DOWN DURING DAYTIME OPERATING HOURS.
- CONTRACTOR IS TO CONDUCT WATER FLUSHING AFTER EACH WATER OUTAGE. CONTRACTOR TO CONDUCT CHLORINE TESTING FOLLOWING EACH FLUSHING. CONTRACT OT PROVIDE COR WITH TEST RESULTS OF EACH CHLORINE TEST.

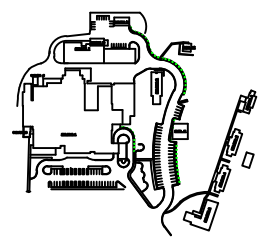

APPROVED: _____
APPROVED: _____
APPROVED: _____

APPROVED: INTERIM SAFETY MANAGER
JUSTIN GREENE
APPROVED: INFECTION CONTROL
CARLA RAYNES
APPROVED: _____

APPROVED: CHIEF, FACILITIES MANAGEMENT SERVICE LINE
JOHN MONTGOMERY
APPROVED: ASSOCIATE DIRECTOR for PATIENT CARE SERVICES/EXECUTIVE NURSE
DEBRA LEGG, RN, MSN
APPROVED: SERVICE LINE CHIEF
APPROVED: _____

APPROVED: MEDICAL CENTER DIRECTOR
KARIN MCGRAW, MSN, FACHE
APPROVED: ASSOCIATE DIRECTOR
ALLEN MOYE
APPROVED: CHIEF OF STAFF
JOHN D. BERRYMAN, M. D.

DRAWING TITLE:
Site Plan & Title Sheet
PROJECT TITLE:
Legionella Prevention Corrections
DATE
11/16/15
REV.
SCALE
NTS
CHECKED BY:

DRAWING No.
GI-001
PROJECT No.
517-16-112
DRAWN BY:
JPP
CHECKED BY:

NOT TO SCALE
Veterans Affairs
Medical Center
200 Veterans Av
Beckley, WV.
25801

