



three inches = one foot
one and one half inches = one foot
one inch = one foot
three quarters inch = one foot
one half inch = one foot
one quarter inch = one foot
three eighths inch = one foot
one eighth inch = one foot
one eighth inch = one foot

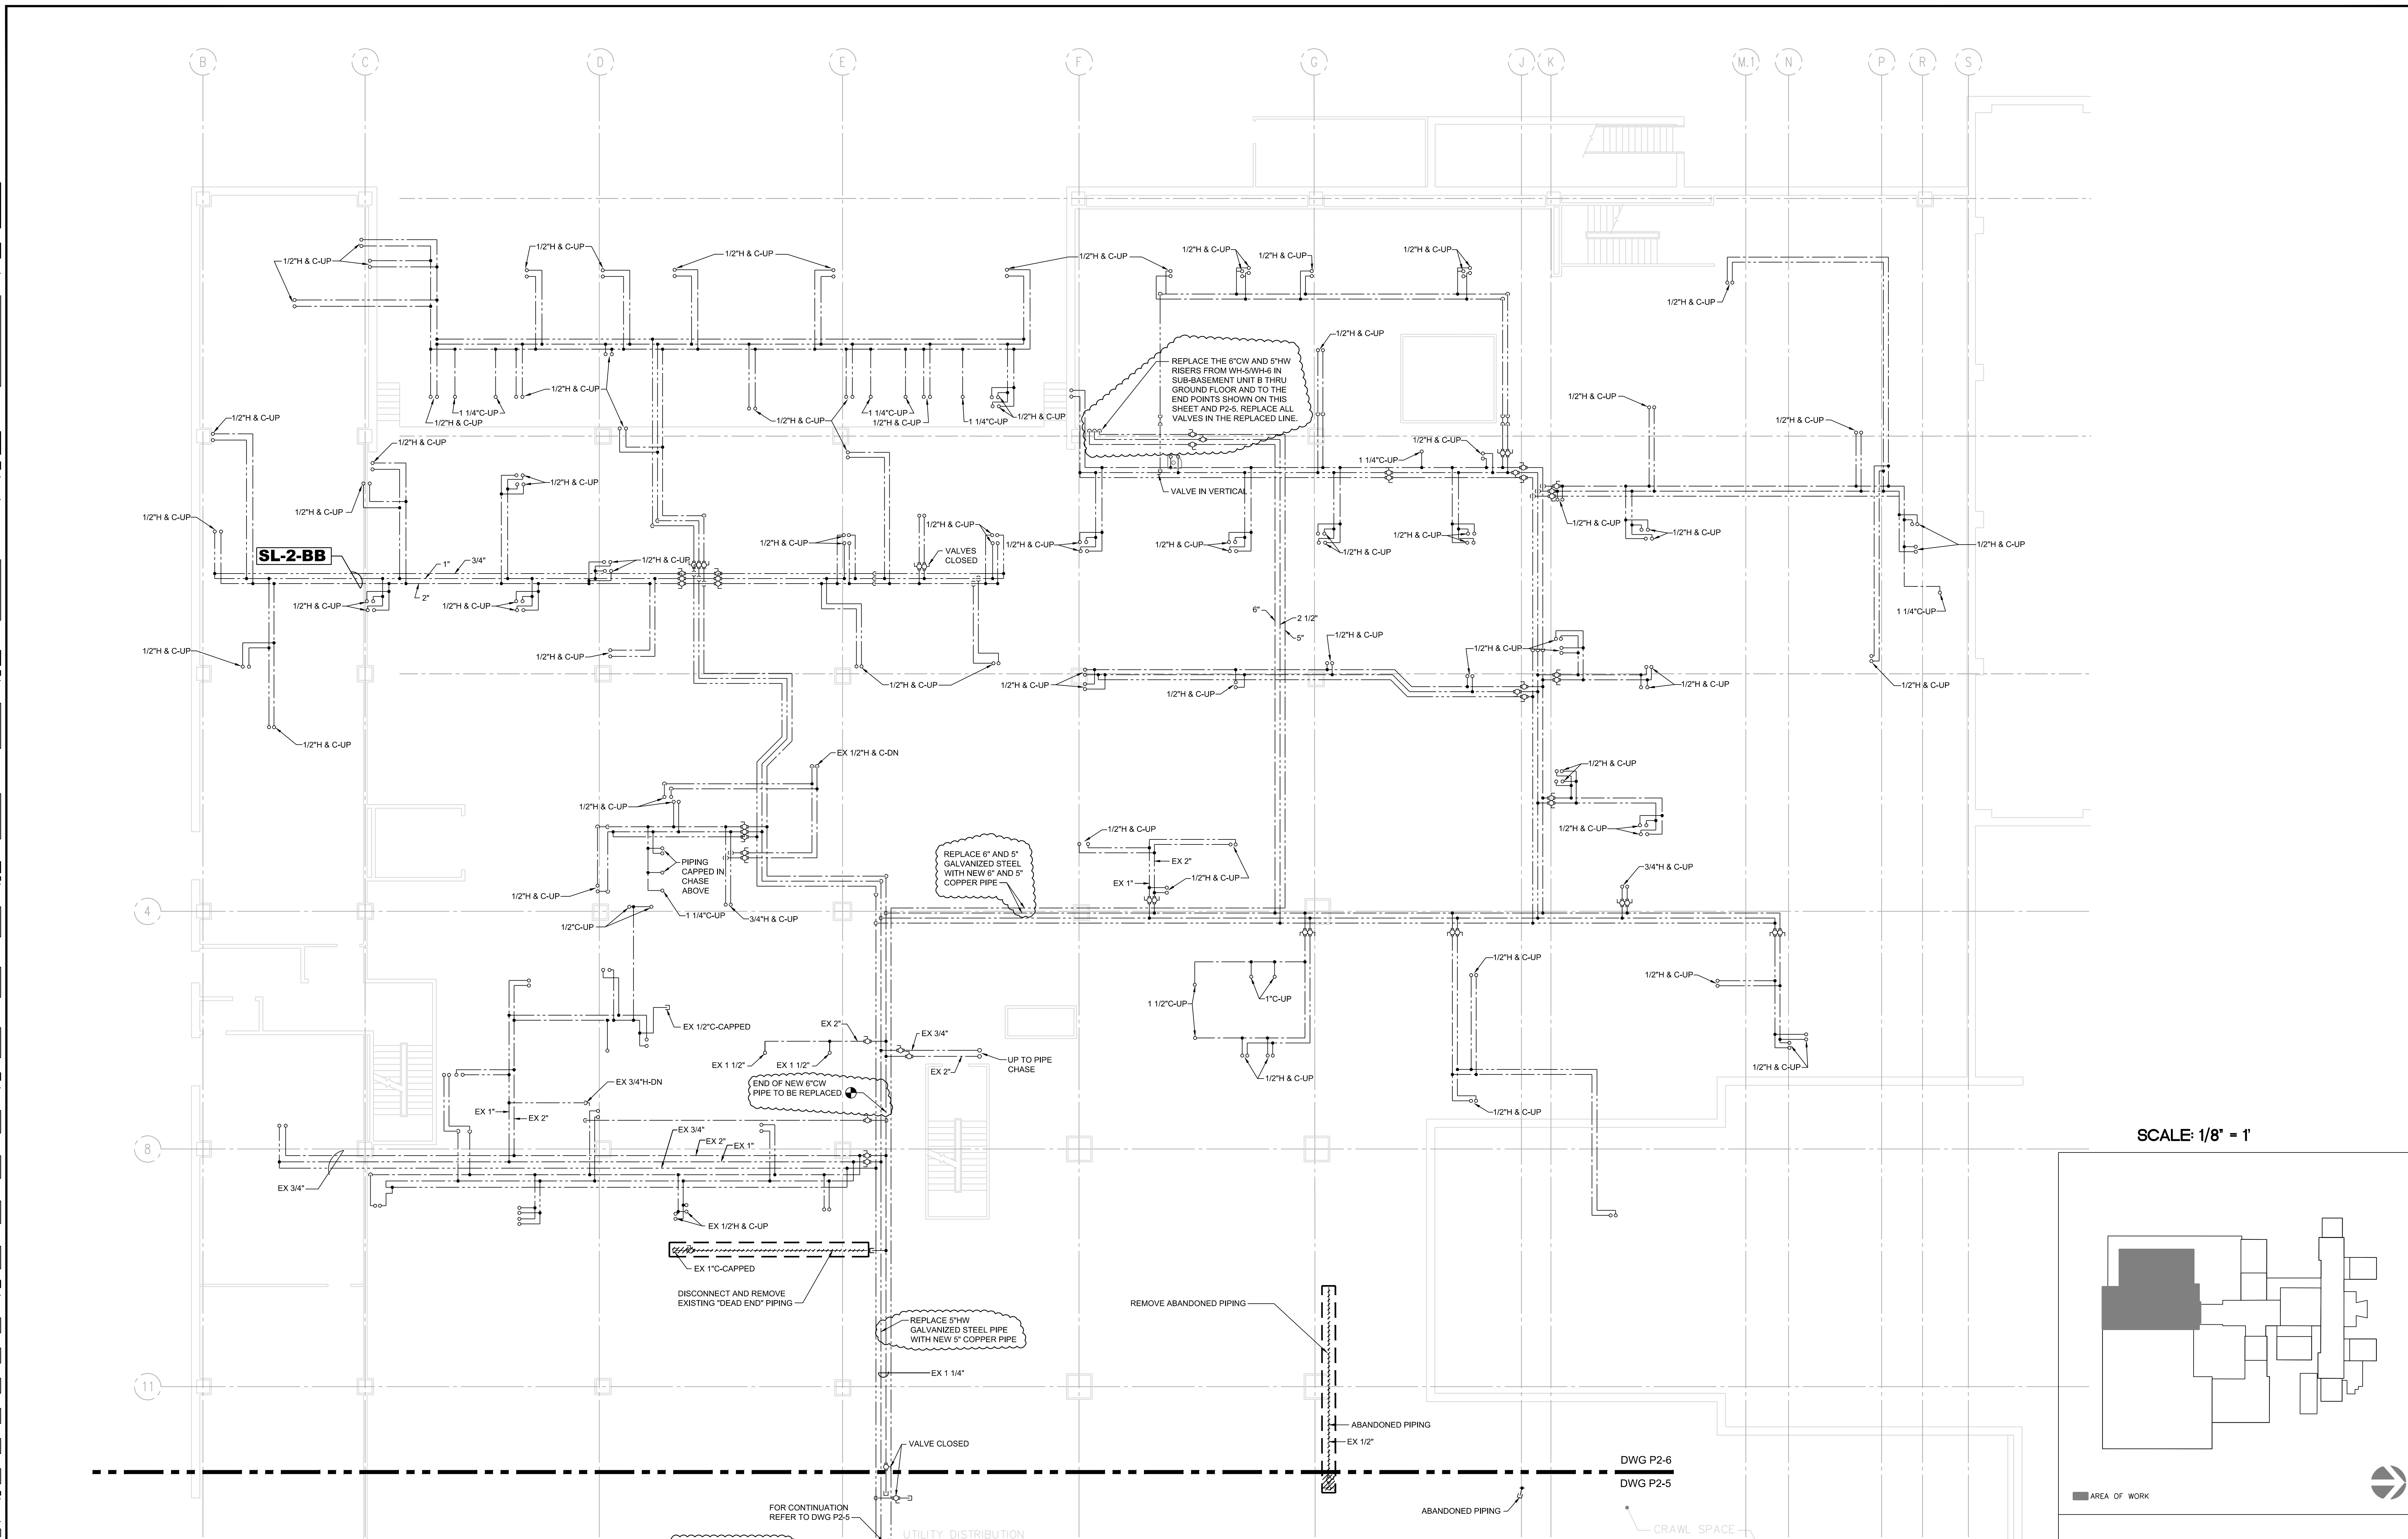

SCALE: 1/8" = 1'

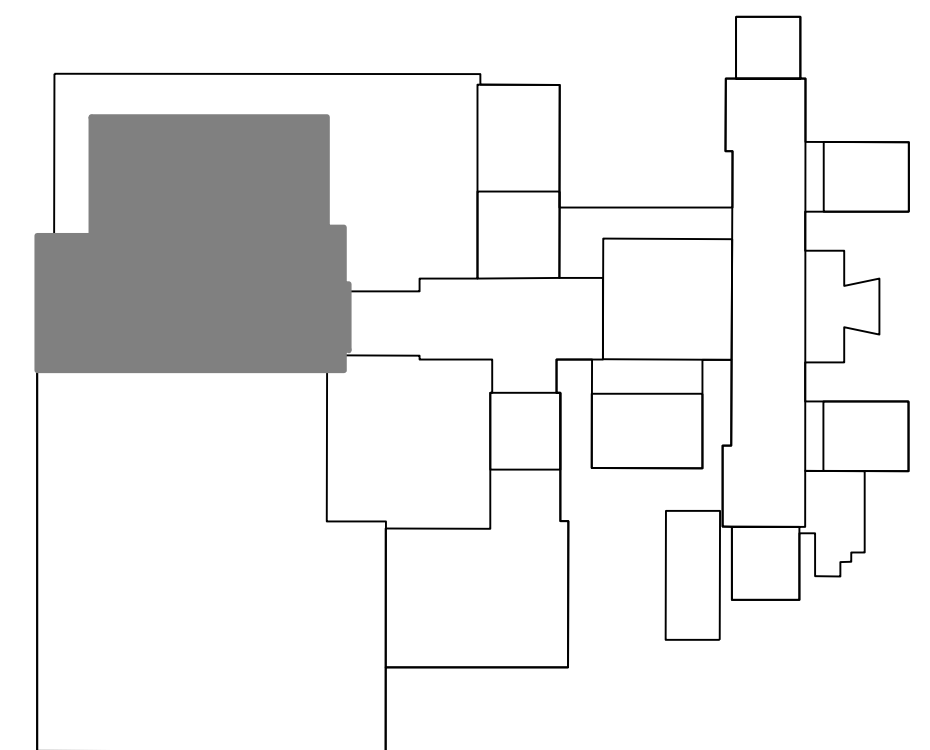

BID DOCUMENTS AMMENDMENT #6 AMMENDMENT #7		6-24-15 3-25-16 3-29-16	CONSULTANTS MEP ENGINEERING H.F. LENZ COMPANY 1407 Scalp Avenue Johnstown, PA 15904 (814) 269-9300		 Environmental Solutions, LLC		ARCHITECT		Drawing Title: BUILDING 2 BASEMENT FLOOR PLUMBING PLAN UNIT 'B'		Project Title: Domestic Water Piping System Repairs		Project Number:	
Revisions:		Date:							Approved:		Location: Philadelphia, Pennsylvania		Building Number: 2	
											Date: 6/24/15		Checked By: TME	
											Drawn By: JLJ		Drawing Number: P2-6	
													Dwg. _____ of _____	

VA FORM 08-6231

