



2	SCALE
1/4" = 1'-0"	H. 10
ELEVATION - SUPPLY FANS "SF-3", "SF-4", "SF-5", "SF-6", "SF-7" & EXHAUST FAN "E-3"	SCALE 1/4" = 1'-0" H. 10
ELEVATION FOR AIR INTAKE "SE-1" & "SF-2"	SCALE 1/4" = 1'-0" H. 10

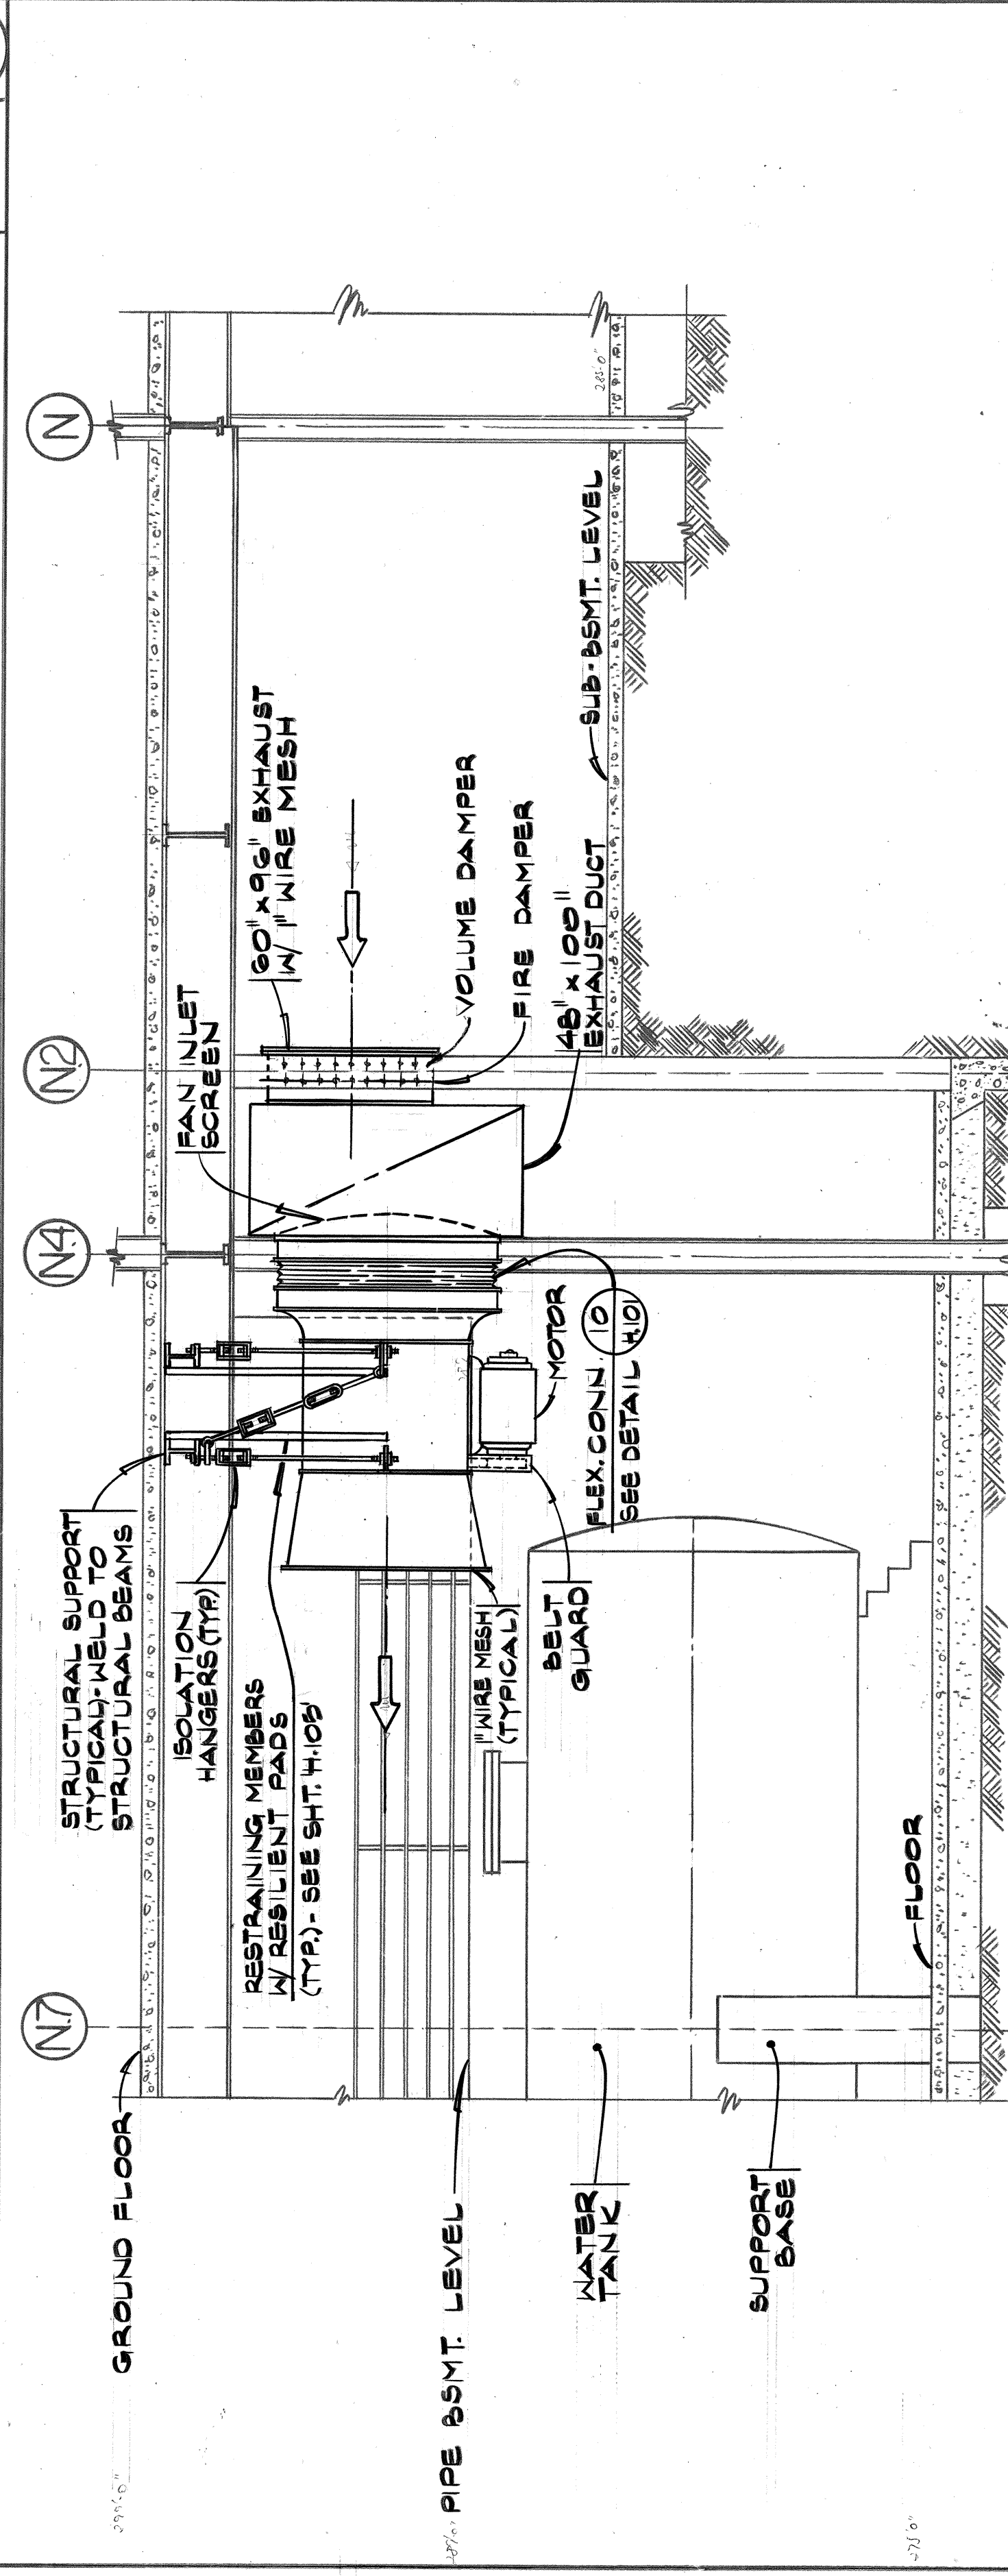


ELEVATION - EXHAUST FANS		SCALE	5
		1/4" = 1'-0"	H-76
		'EF-1' &	'EF-2'

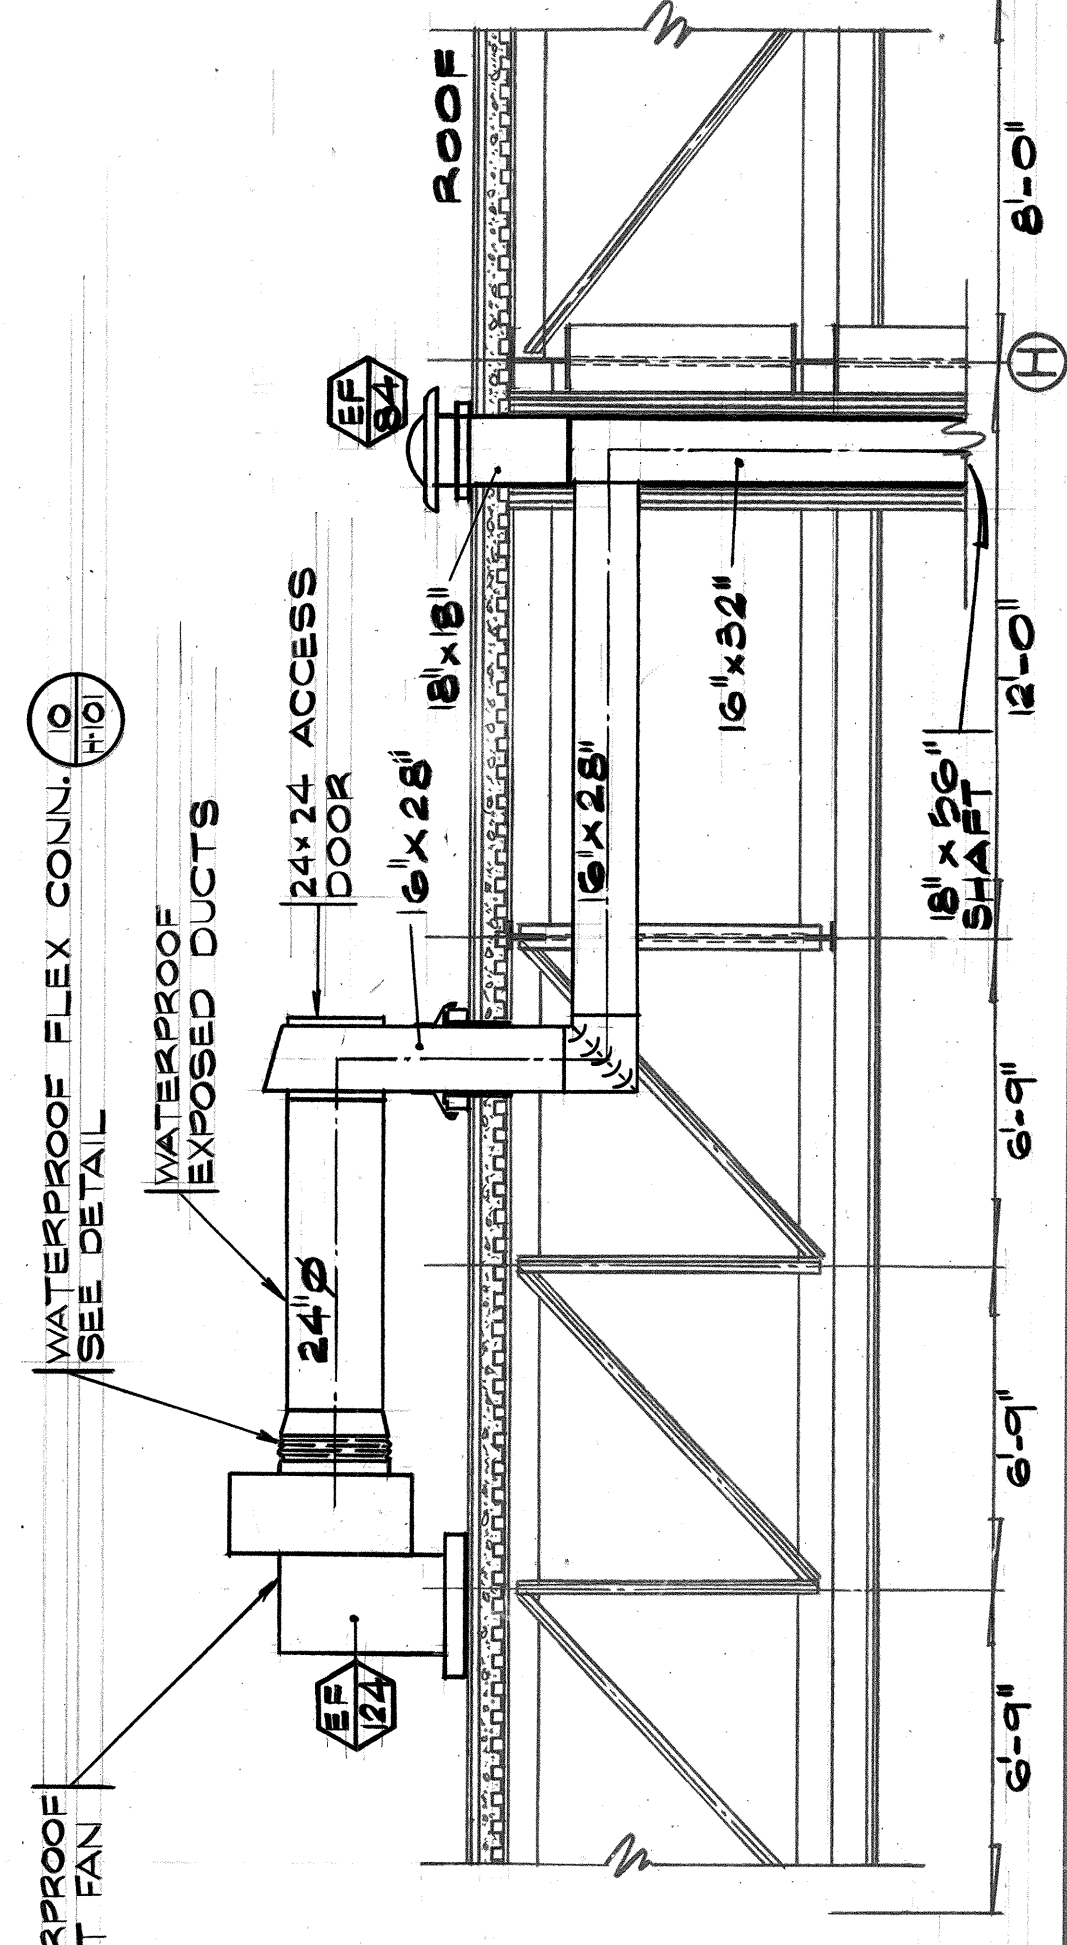

**ROOF PLAN**  
**NOT TO SCALE:**

ELEVATION A  
SCALE: 1/4" = 1'-0"

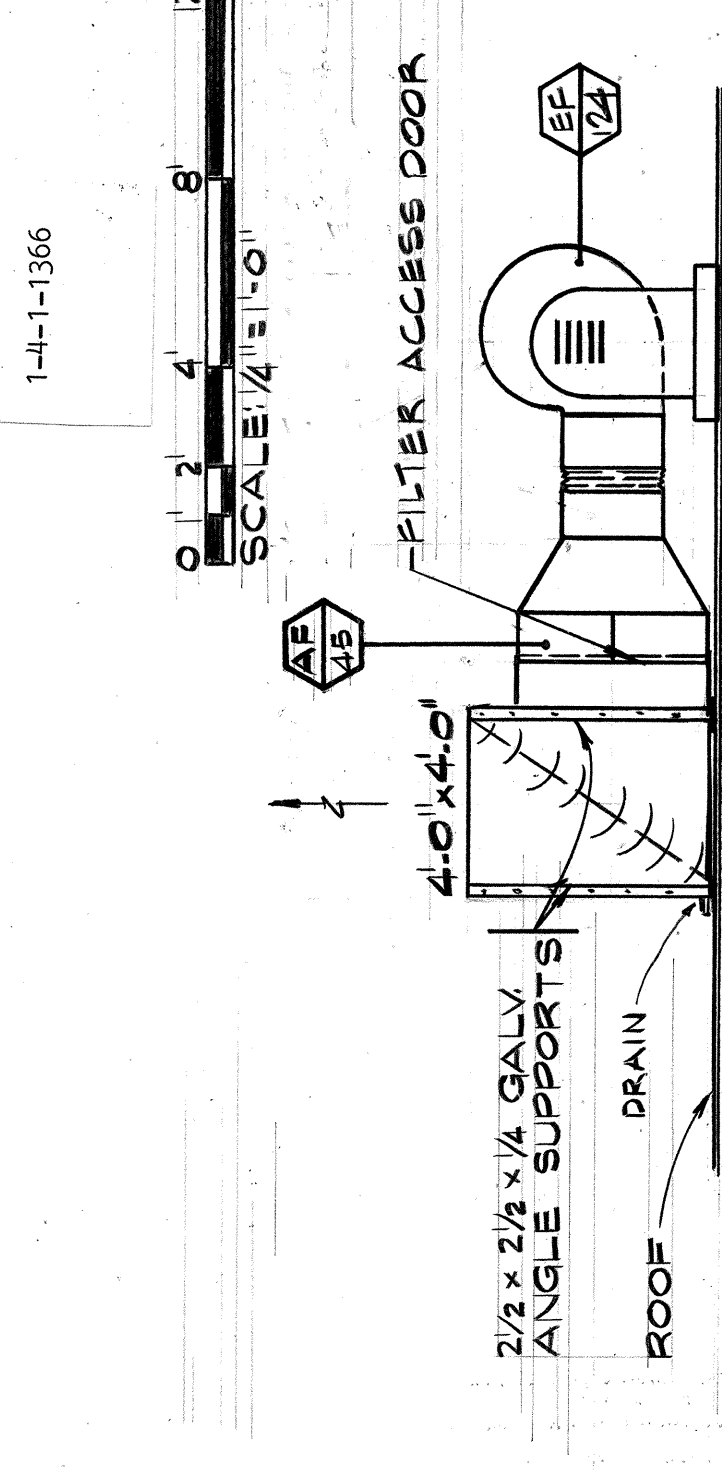

ELEVATION

SCALE:  $1/4" = 1'-0"$

B H.76

<b>R-J-M ASSOCIATES</b> CONSULTING ENGINEERS 909 SUNSET PLZ. LOS ANGELES, CALIF. 90017	ROOF PLAN PHASE 2		820 BED HOSPITAL BUILDING  VETERANS ADMINISTRATION VAH, LOS ANGELES, CALIFORNIA	DRAWING NUMBER 500-H-76	SHEET NO. 689 OF 072
	820 SUNSET BLDG. LOS ANGELES, 90008				
APPROVED: <i>[Signature]</i>		PROJECT: <i>[Signature]</i> DATE: 7-10-74		DRAWING NUMBER 500-H-76	SHEET NO. 689 OF 072
CHARLES LUCKMAN ASSOCIATES PLANNING • ARCHITECTURE • ENGINEERING 820 SUNSET BLDG. LOS ANGELES, 90008		CHECKED: <i>[Signature]</i> DATE: 7-10-74		DRAWING NUMBER 500-H-76	SHEET NO. 689 OF 072