


three inches = one foot
one and one half inches = one foot
one inch = one foot
three quarters inch = one foot
one half inch = one foot
three eighths inch = one foot
one quarter inch = one foot
one eighth inch = one foot

GENERAL NOTES


1. CONTRACTOR TO METER EXISTING PANEL FOR 30 DAYS DN-ZMH-M TO VERIFY CAPACITY FOR ADDITIONAL NEW LOAD. PROVIDE METER DATA TO OWNER.

KEYNOTES

1. PROVIDE NEW 20/3 IN EXISTING SPACE. USE SQUARE D TO MATCH EXISTING I-LINE PANELBOARD AND BREAKERS.

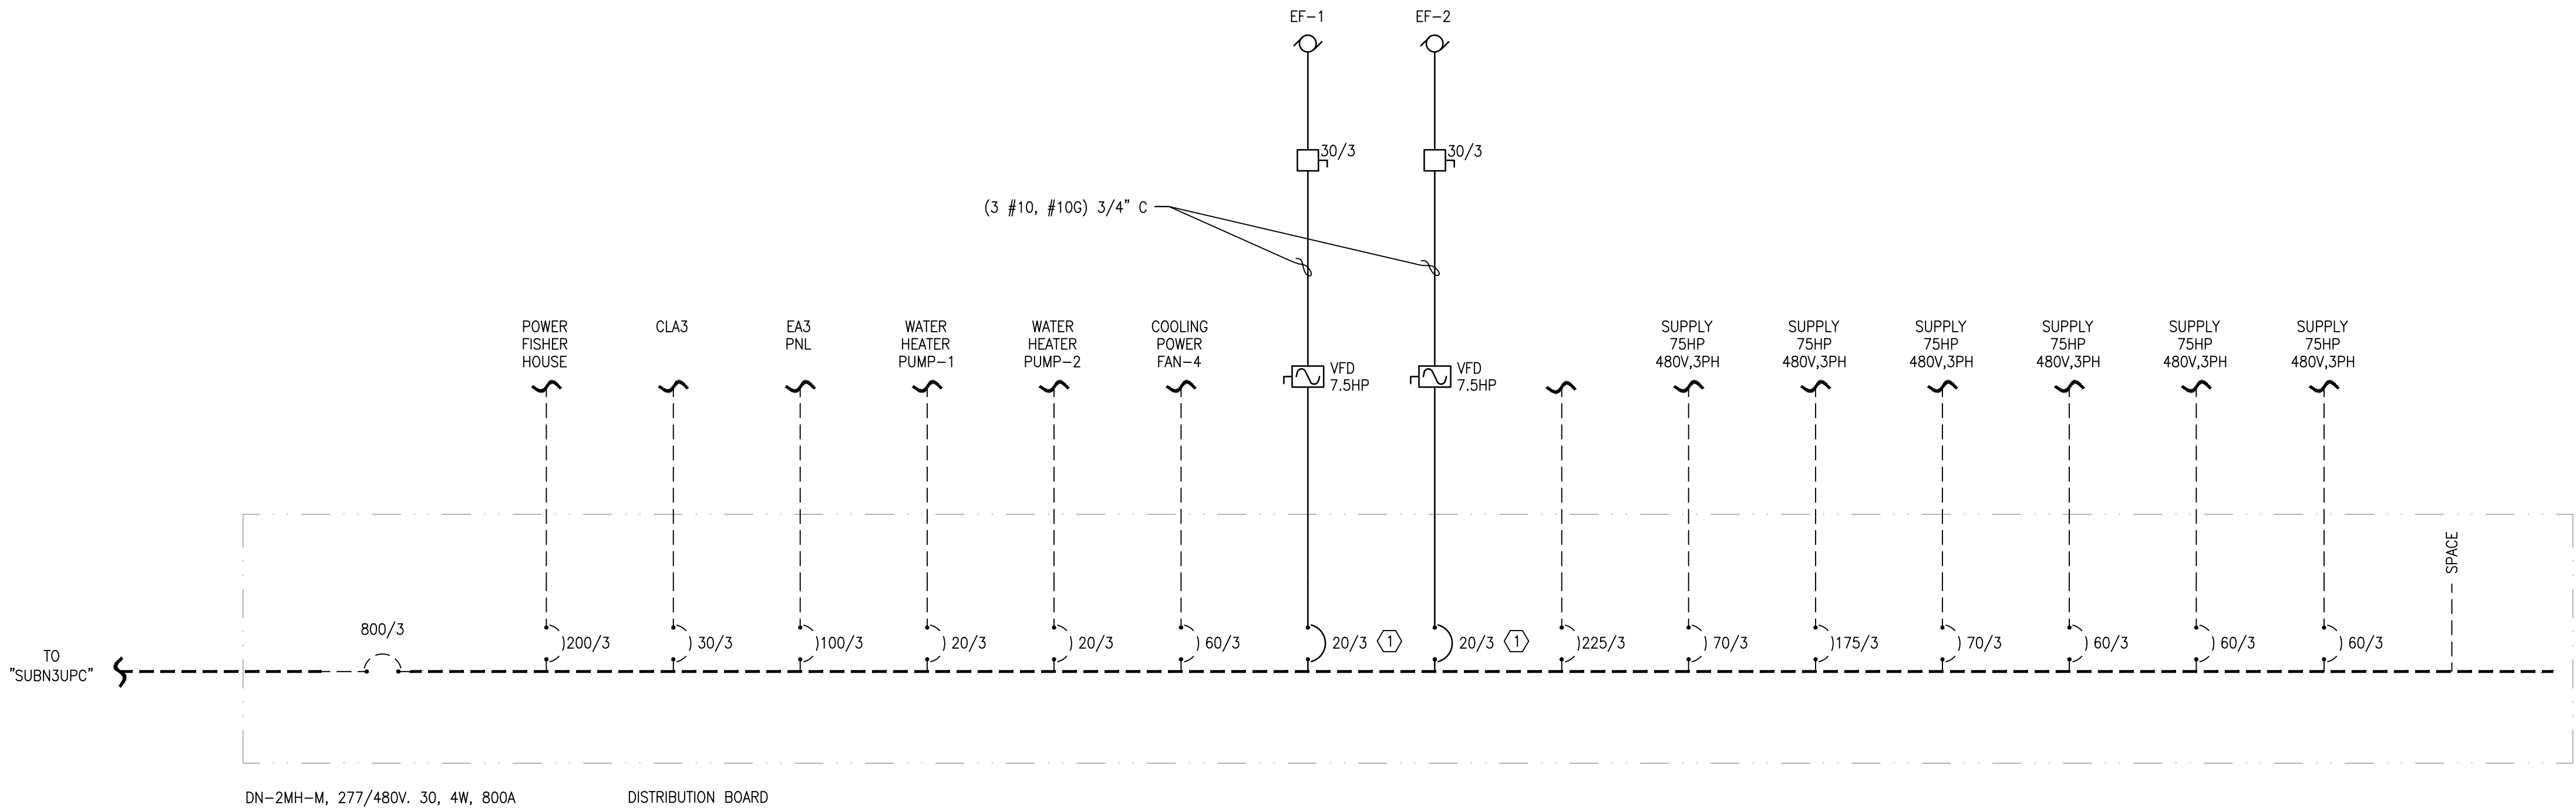

1 PARTIAL ELECTRICAL ONELINE
SCALE: NTS

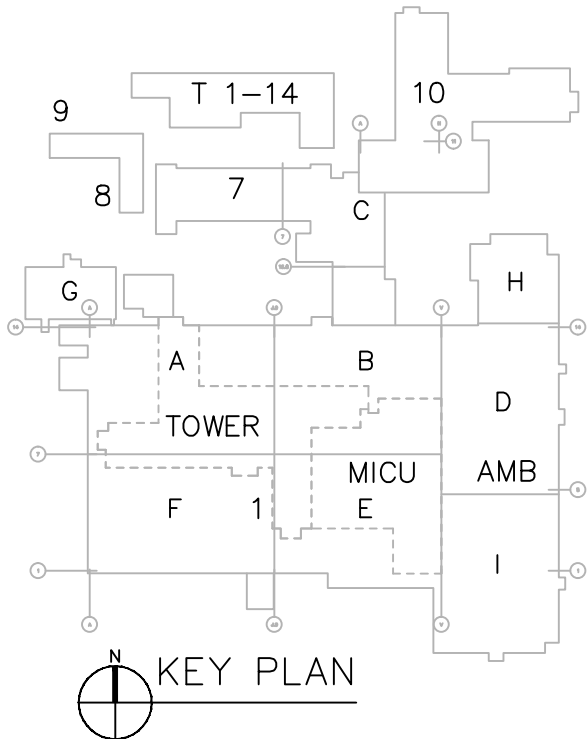

DESIGN DEVELOPMENT - NOT FOR CONSTRUCTION

		CONSULTANTS:		ARCHITECT/ENGINEERS: GLHN ARCHITECTS & ENGINEERS, INC. 2939 E. Broadway Blvd. Tucson, Arizona 85716 PH: 520-881-4546 FAX: 520-795-1822 glhn.com <small>COPYRIGHT 2010 GLHN ARCHITECTS & ENGINEERS, INC. ALL RIGHTS RESERVED.</small>		Drawing Title PARTIAL ELECTRICAL ONE LINE DIAGRAM Approved Project Director		Project Title MIAMI UTILITY PLANT CORRECTIONS Location MIAMI UTILITY PLANT Date 08-05-11		Project Number 0555.118 Building Number G/A Drawing Number EJ601 Dwg. -- of --		Office of Construction and Facilities Management Department of Veterans Affairs	
Revisions:		Date						Checked		Drawn MLC			