



three inches = one foot
one and one half inches = one foot
one inch = one foot
three quarters inch = one foot
one half inch = one foot
three eighths inch = one foot
one quarter inch = one foot
one eighth inch = one foot

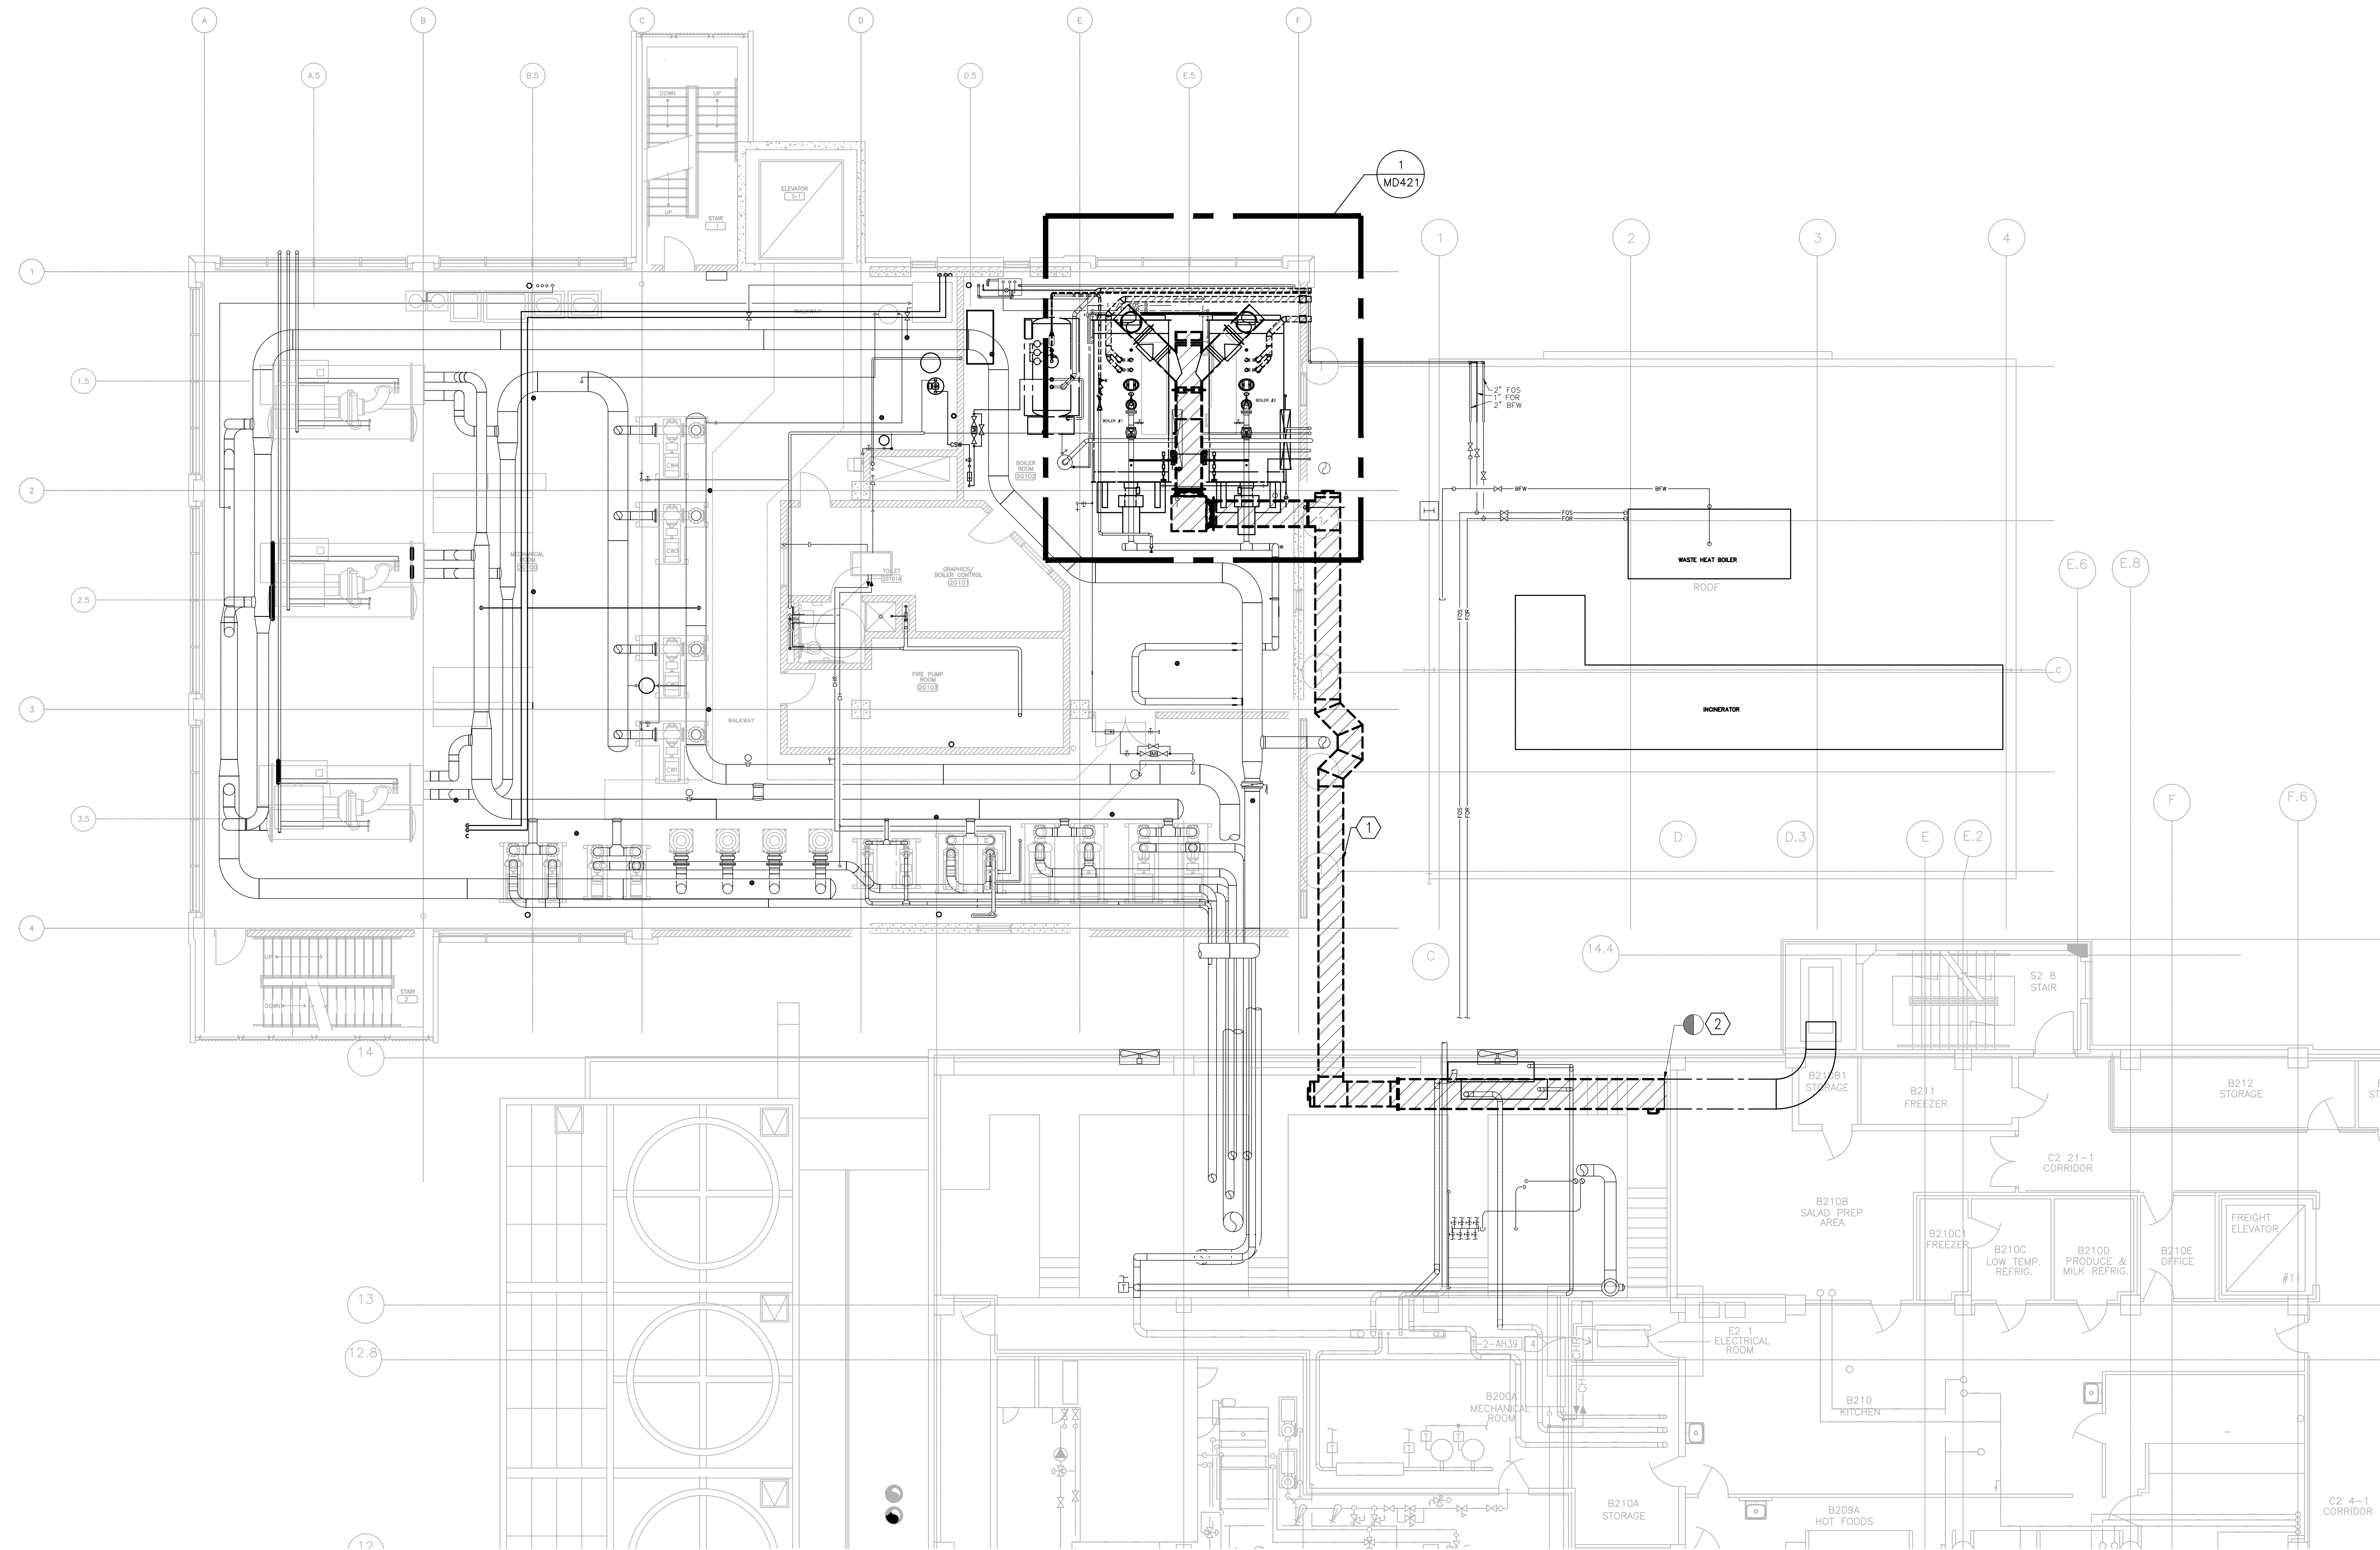


- KEYNOTES** (#)
- DEMOLISH EXISTING 24" DIAMETER BOILER FLUE. PATCH MASONRY WALL. PENETRATION WATER TIGHT.
 - DEMOLISH EXISTING 36/36 FLUE INCLUDING AUTOMATIC DRAFT DAMPER. CAP EXISTING DUCT AT WALL PENETRATION. TEST OLD 3/4" FLUE INSULATION FOR ASBESTOS. ABATE AS REQUIRED.

BASE BID
AREA A/G - MECHANICAL
DEMOLITION PLAN

0 4 8 16 1/8" = 1'-0"

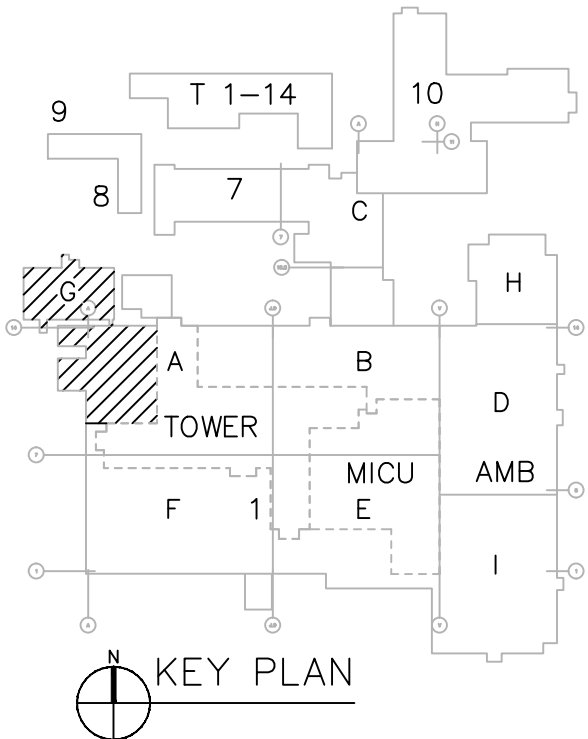

DESIGN DEVELOPMENT - NOT FOR CONSTRUCTION

		<div>CONSULTANTS:</div>		<div>ARCHITECT/ENGINEERS:</div> <div>GLHN</div> <div>ARCHITECTS & ENGINEERS, INC.</div> <div>2939 E. Broadway Blvd. Tucson, Arizona 85716 PH: 520-881-4546 FAX: 520-795-1822 glhn.com</div> <div>COPYRIGHT 2010 GLHN ARCHITECTS & ENGINEERS, INC. ALL RIGHTS RESERVED</div>		<div>Drawing Title</div> <div>BASE BID: LEVEL 2 AREA A/G MECHANICAL DEMOLITION PLAN</div>		<div>Project Title</div> <div>MIAMI UTILITY PLANT CORRECTIONS</div>		<div>Project Number</div> <div>0555.118</div>	<div>Office of Construction and Facilities Management</div> <div> Department of Veterans Affairs</div>	
								<div>Building Number</div> <div>G/A</div>				
						<div>Approved Project Director</div>		<div>Location</div> <div>MIAMI UTILITY PLANT</div>		<div>Drawing Number</div> <div>MD121</div>		
						<div>Date</div> <div>08-05-11</div>	<div>Checked</div> <div>HWJ</div>	<div>Drawn</div> <div>WMK</div>	<div>Dwg. -- of --</div>			
<div>Revisions:</div>						<div>Date</div>						