




three inches = one foot
one and one half inches = one foot
one inch = one foot
three quarters inch = one foot
one half inch = one foot
three eighths inch = one foot
one quarter inch = one foot
one eighth inch = one foot

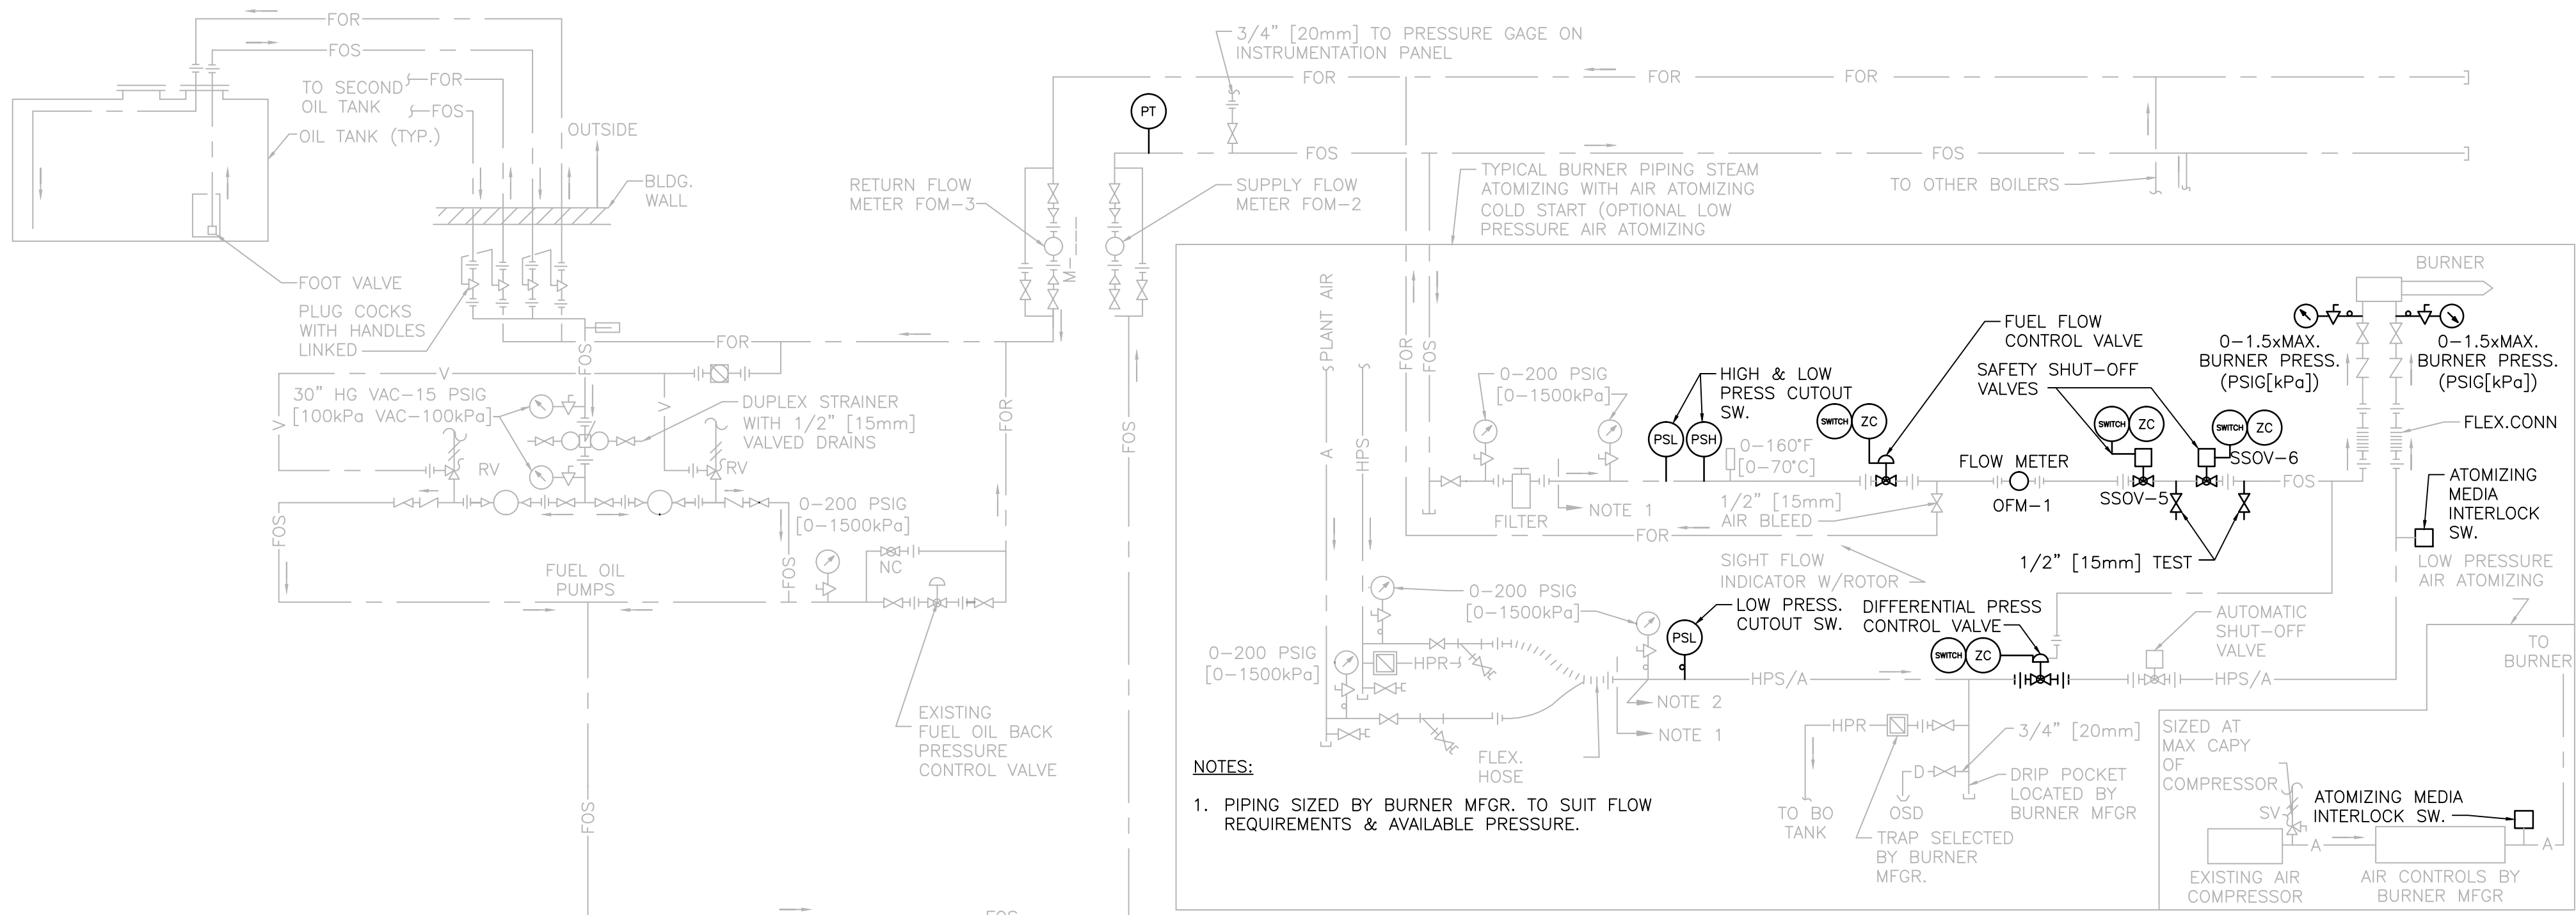


2 NO.2 BURNER FUEL OIL SYSTEMS - STANDARD PIPING DIAGRAM
NTS

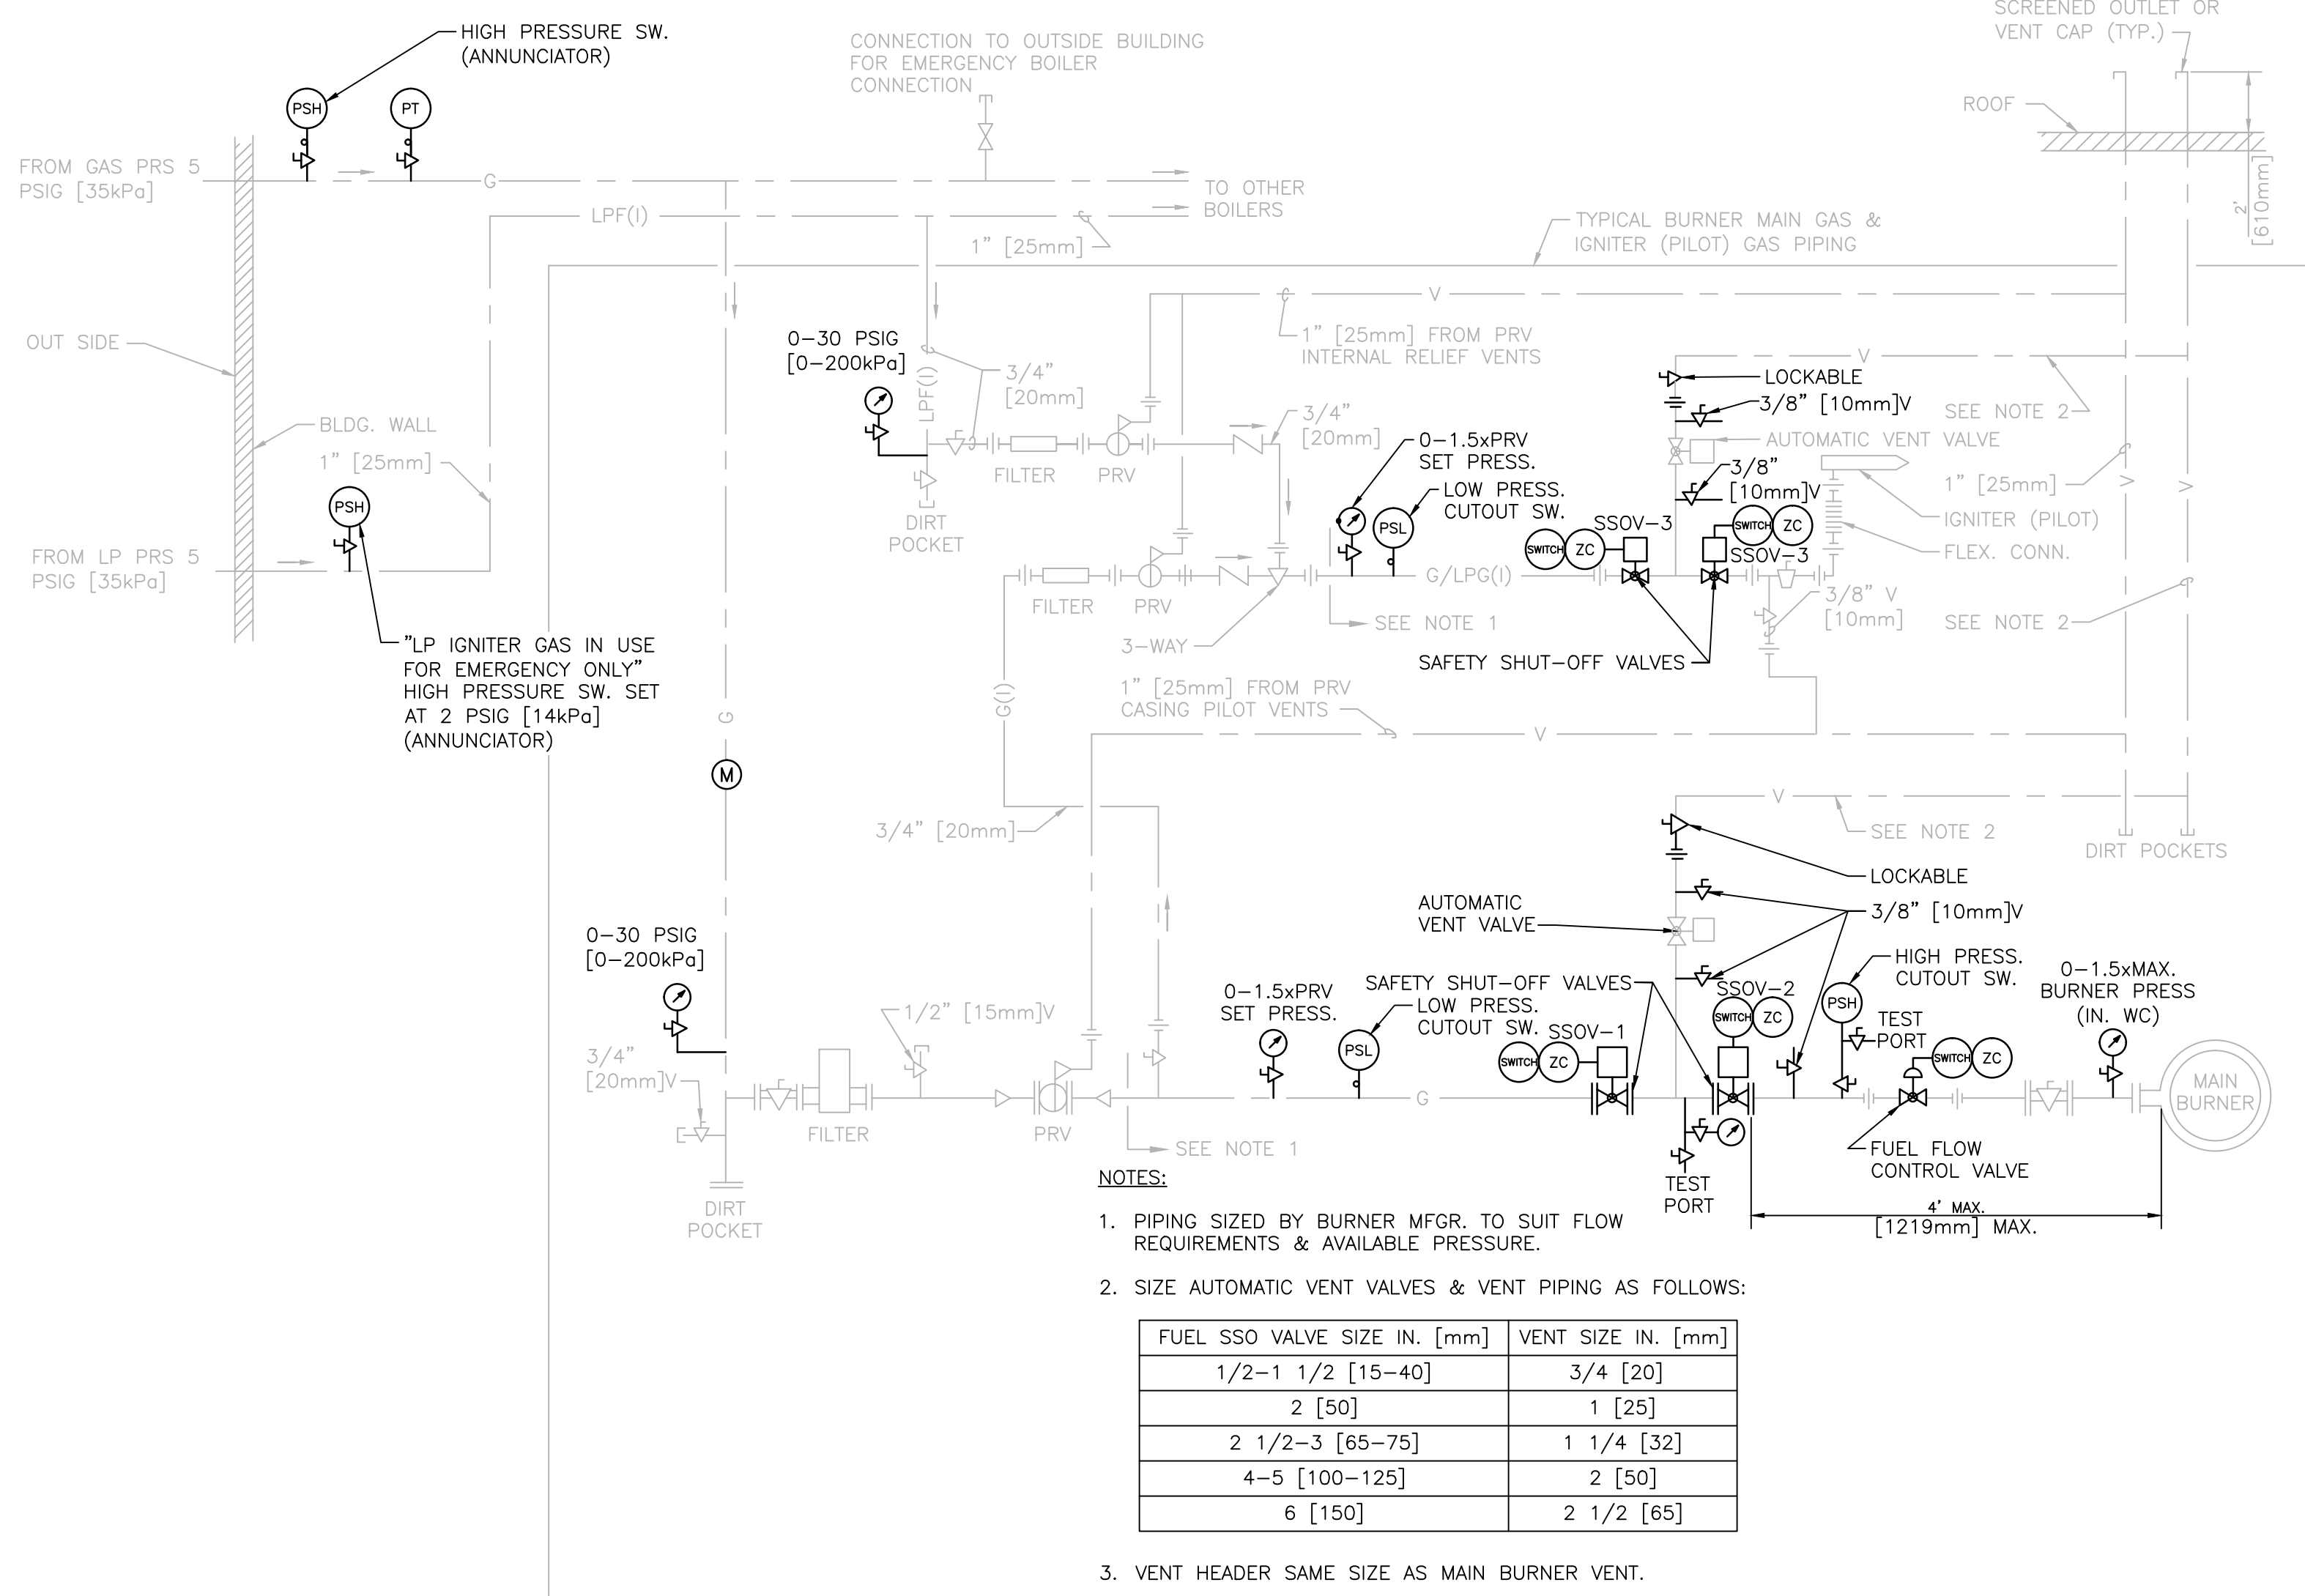

1 NATURAL GAS AND LIQUEFIED PETROLEUM GAS - BURNER AND IGNITER FUEL STANDARD PIPING DIAGRAM
NTS

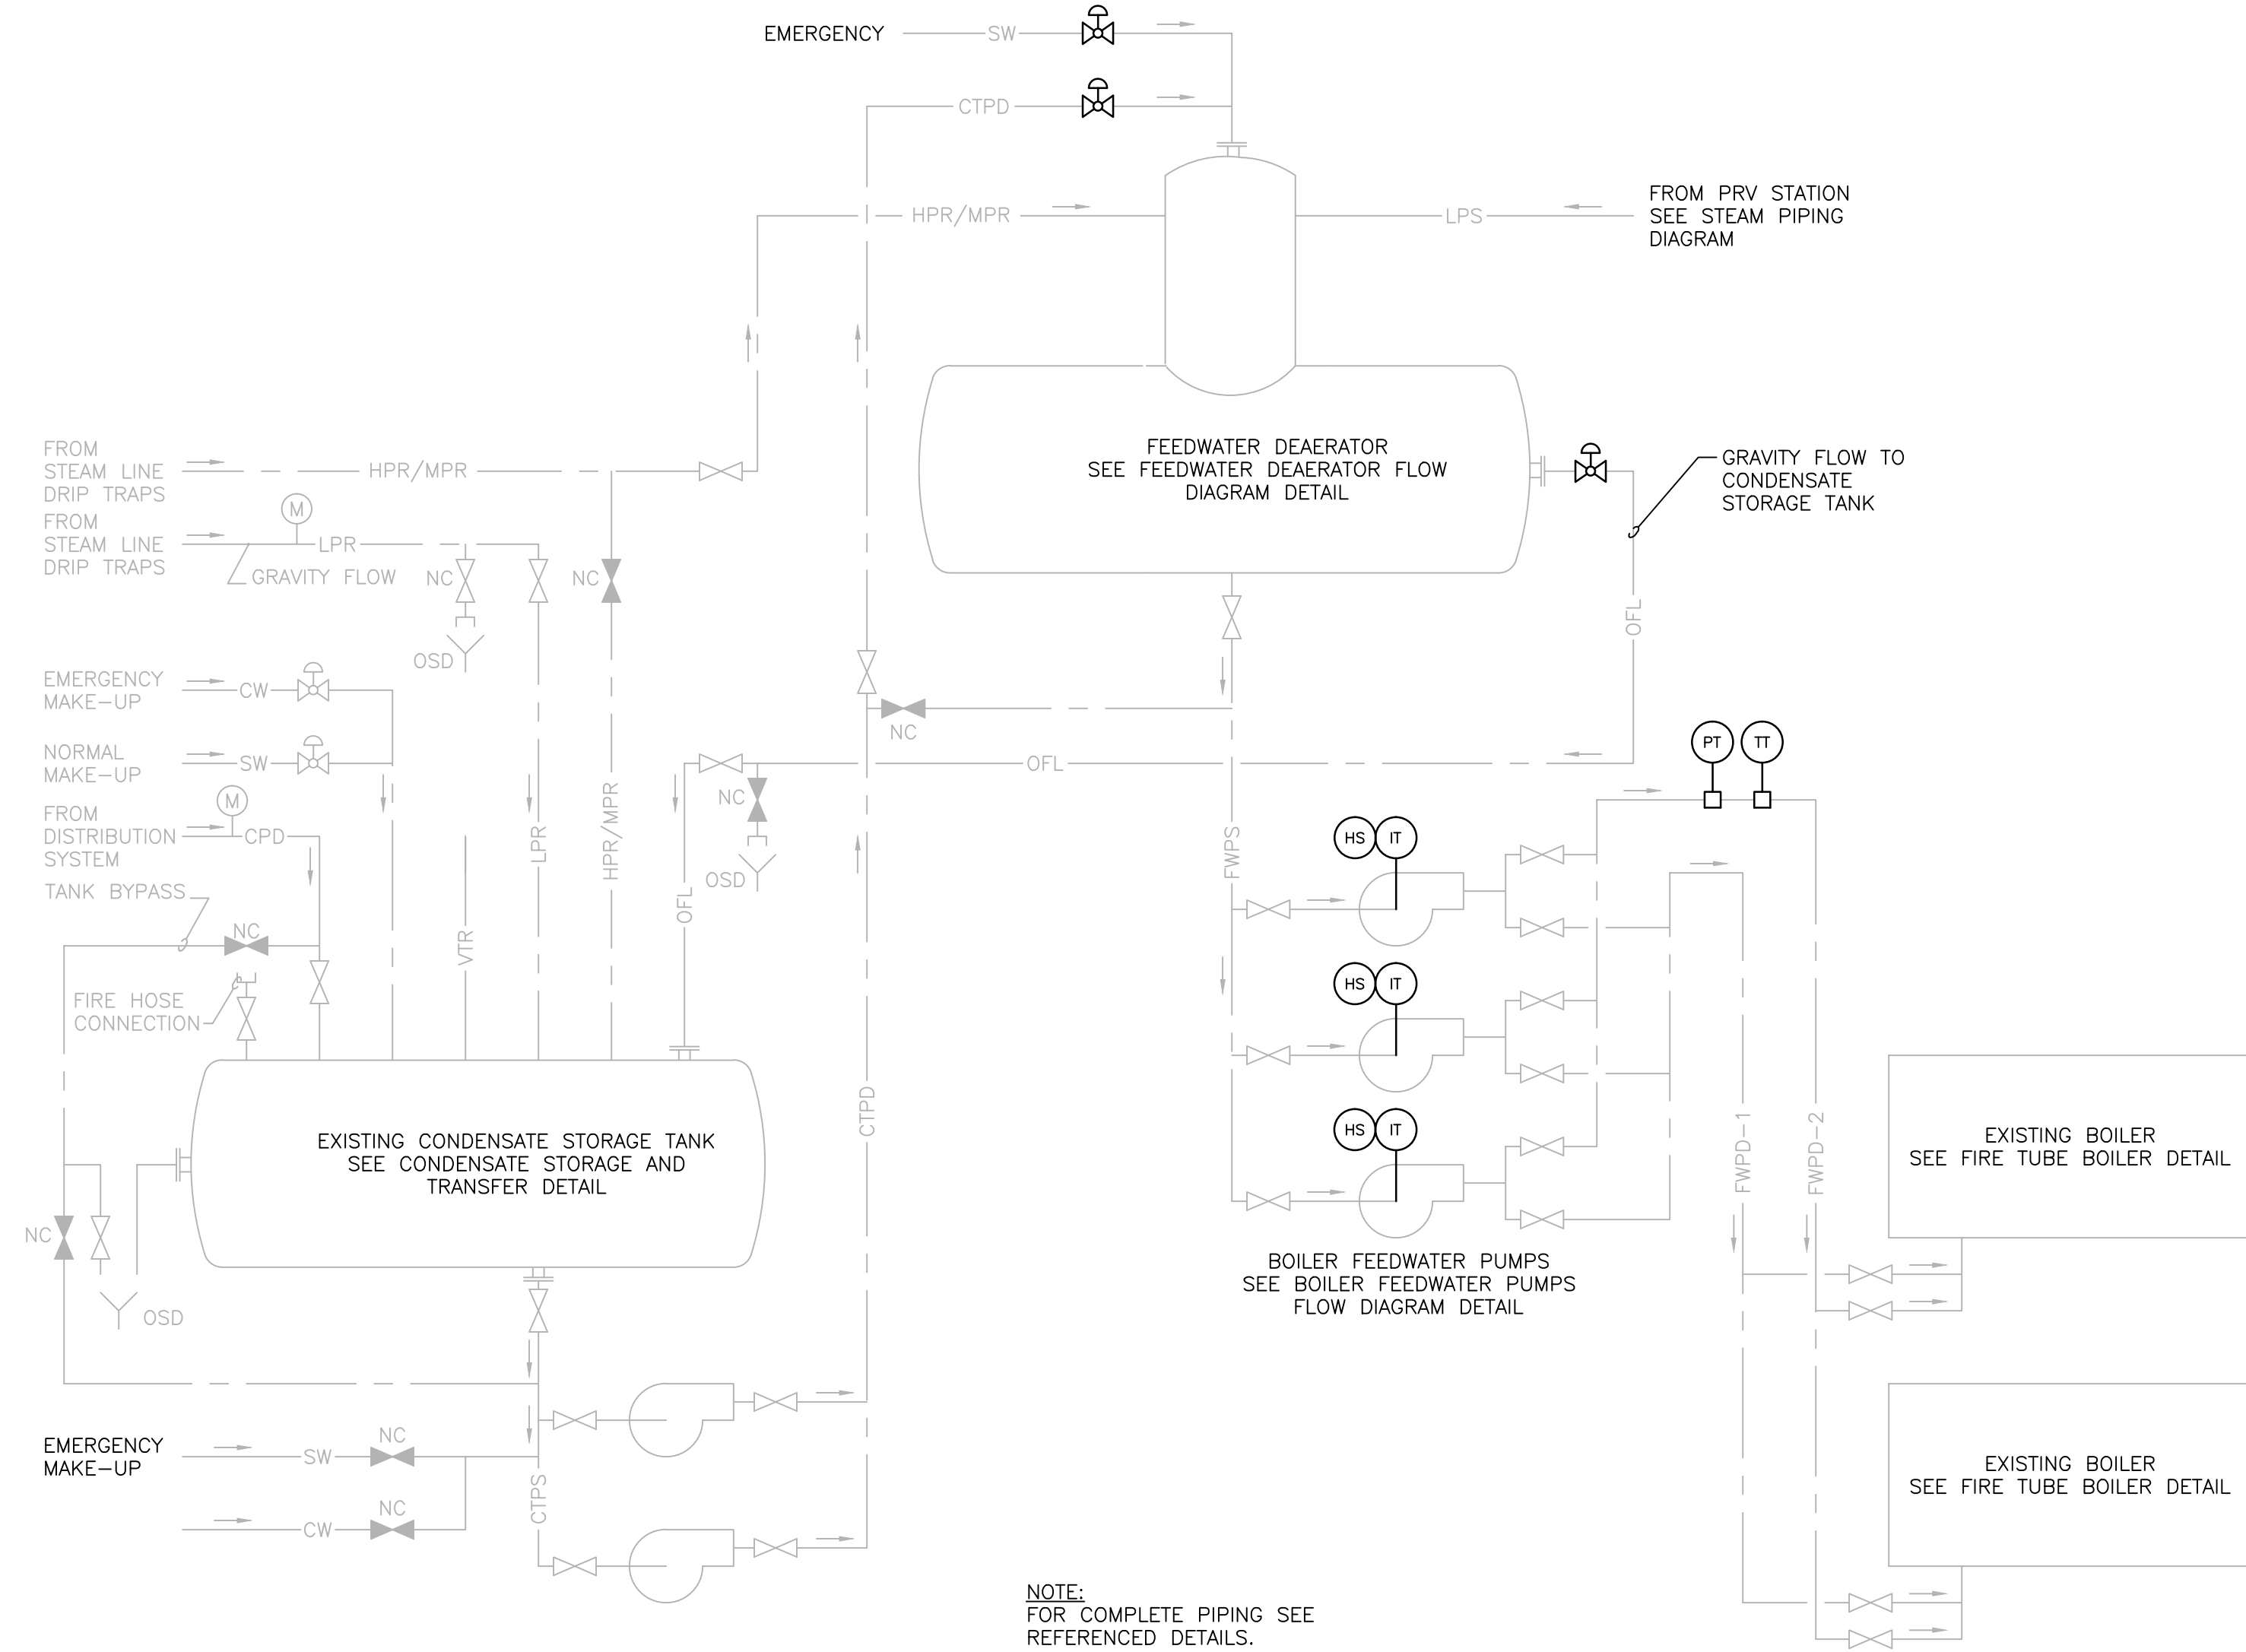

3 BASIC FLOW DIAGRAM - CONDENSATE AND BOILER FEEDWATER
NTS

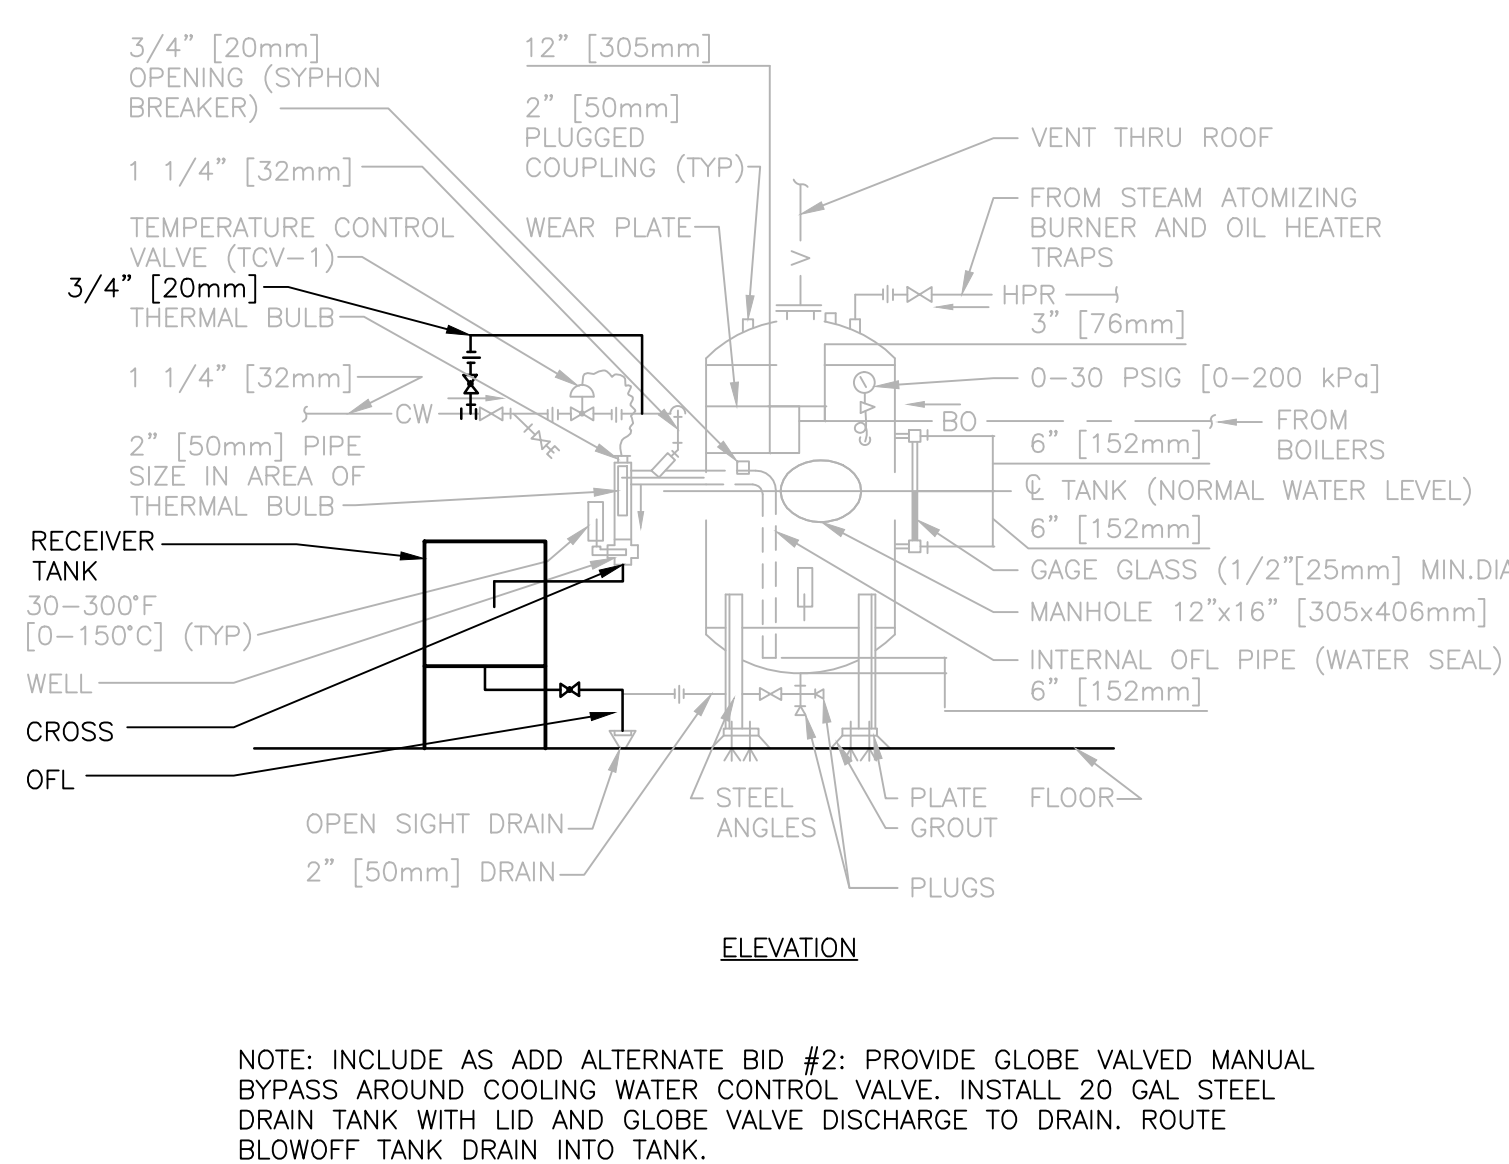

4 BOILER BLOWOFF TANK
NTS

DESIGN DEVELOPMENT - NOT FOR CONSTRUCTION

Revisions:		Date:		CONSULTANTS:		ARCHITECT/ENGINEERS: GLHN ARCHITECTS & ENGINEERS, INC. 2939 E. Broadway Blvd. Tucson, Arizona 85716 PH: 520-881-4546 FAX: 520-795-1822 glhn.com COPYRIGHT 2010 GLHN ARCHITECTS & ENGINEERS, INC. ALL RIGHTS RESERVED		Drawing Title MECHANICAL DETAILS		Project Title MIAMI UTILITY PLANT CORRECTIONS		Project Number 0555.118 Building Number G/A		Office of Construction and Facilities Management			
Approved Project Director				Location MIAMI UTILITY PLANT				Date 08-05-11				Checked HWJ		Drawn WMK		Drawing Number MJ501 Dwg. -- of --	