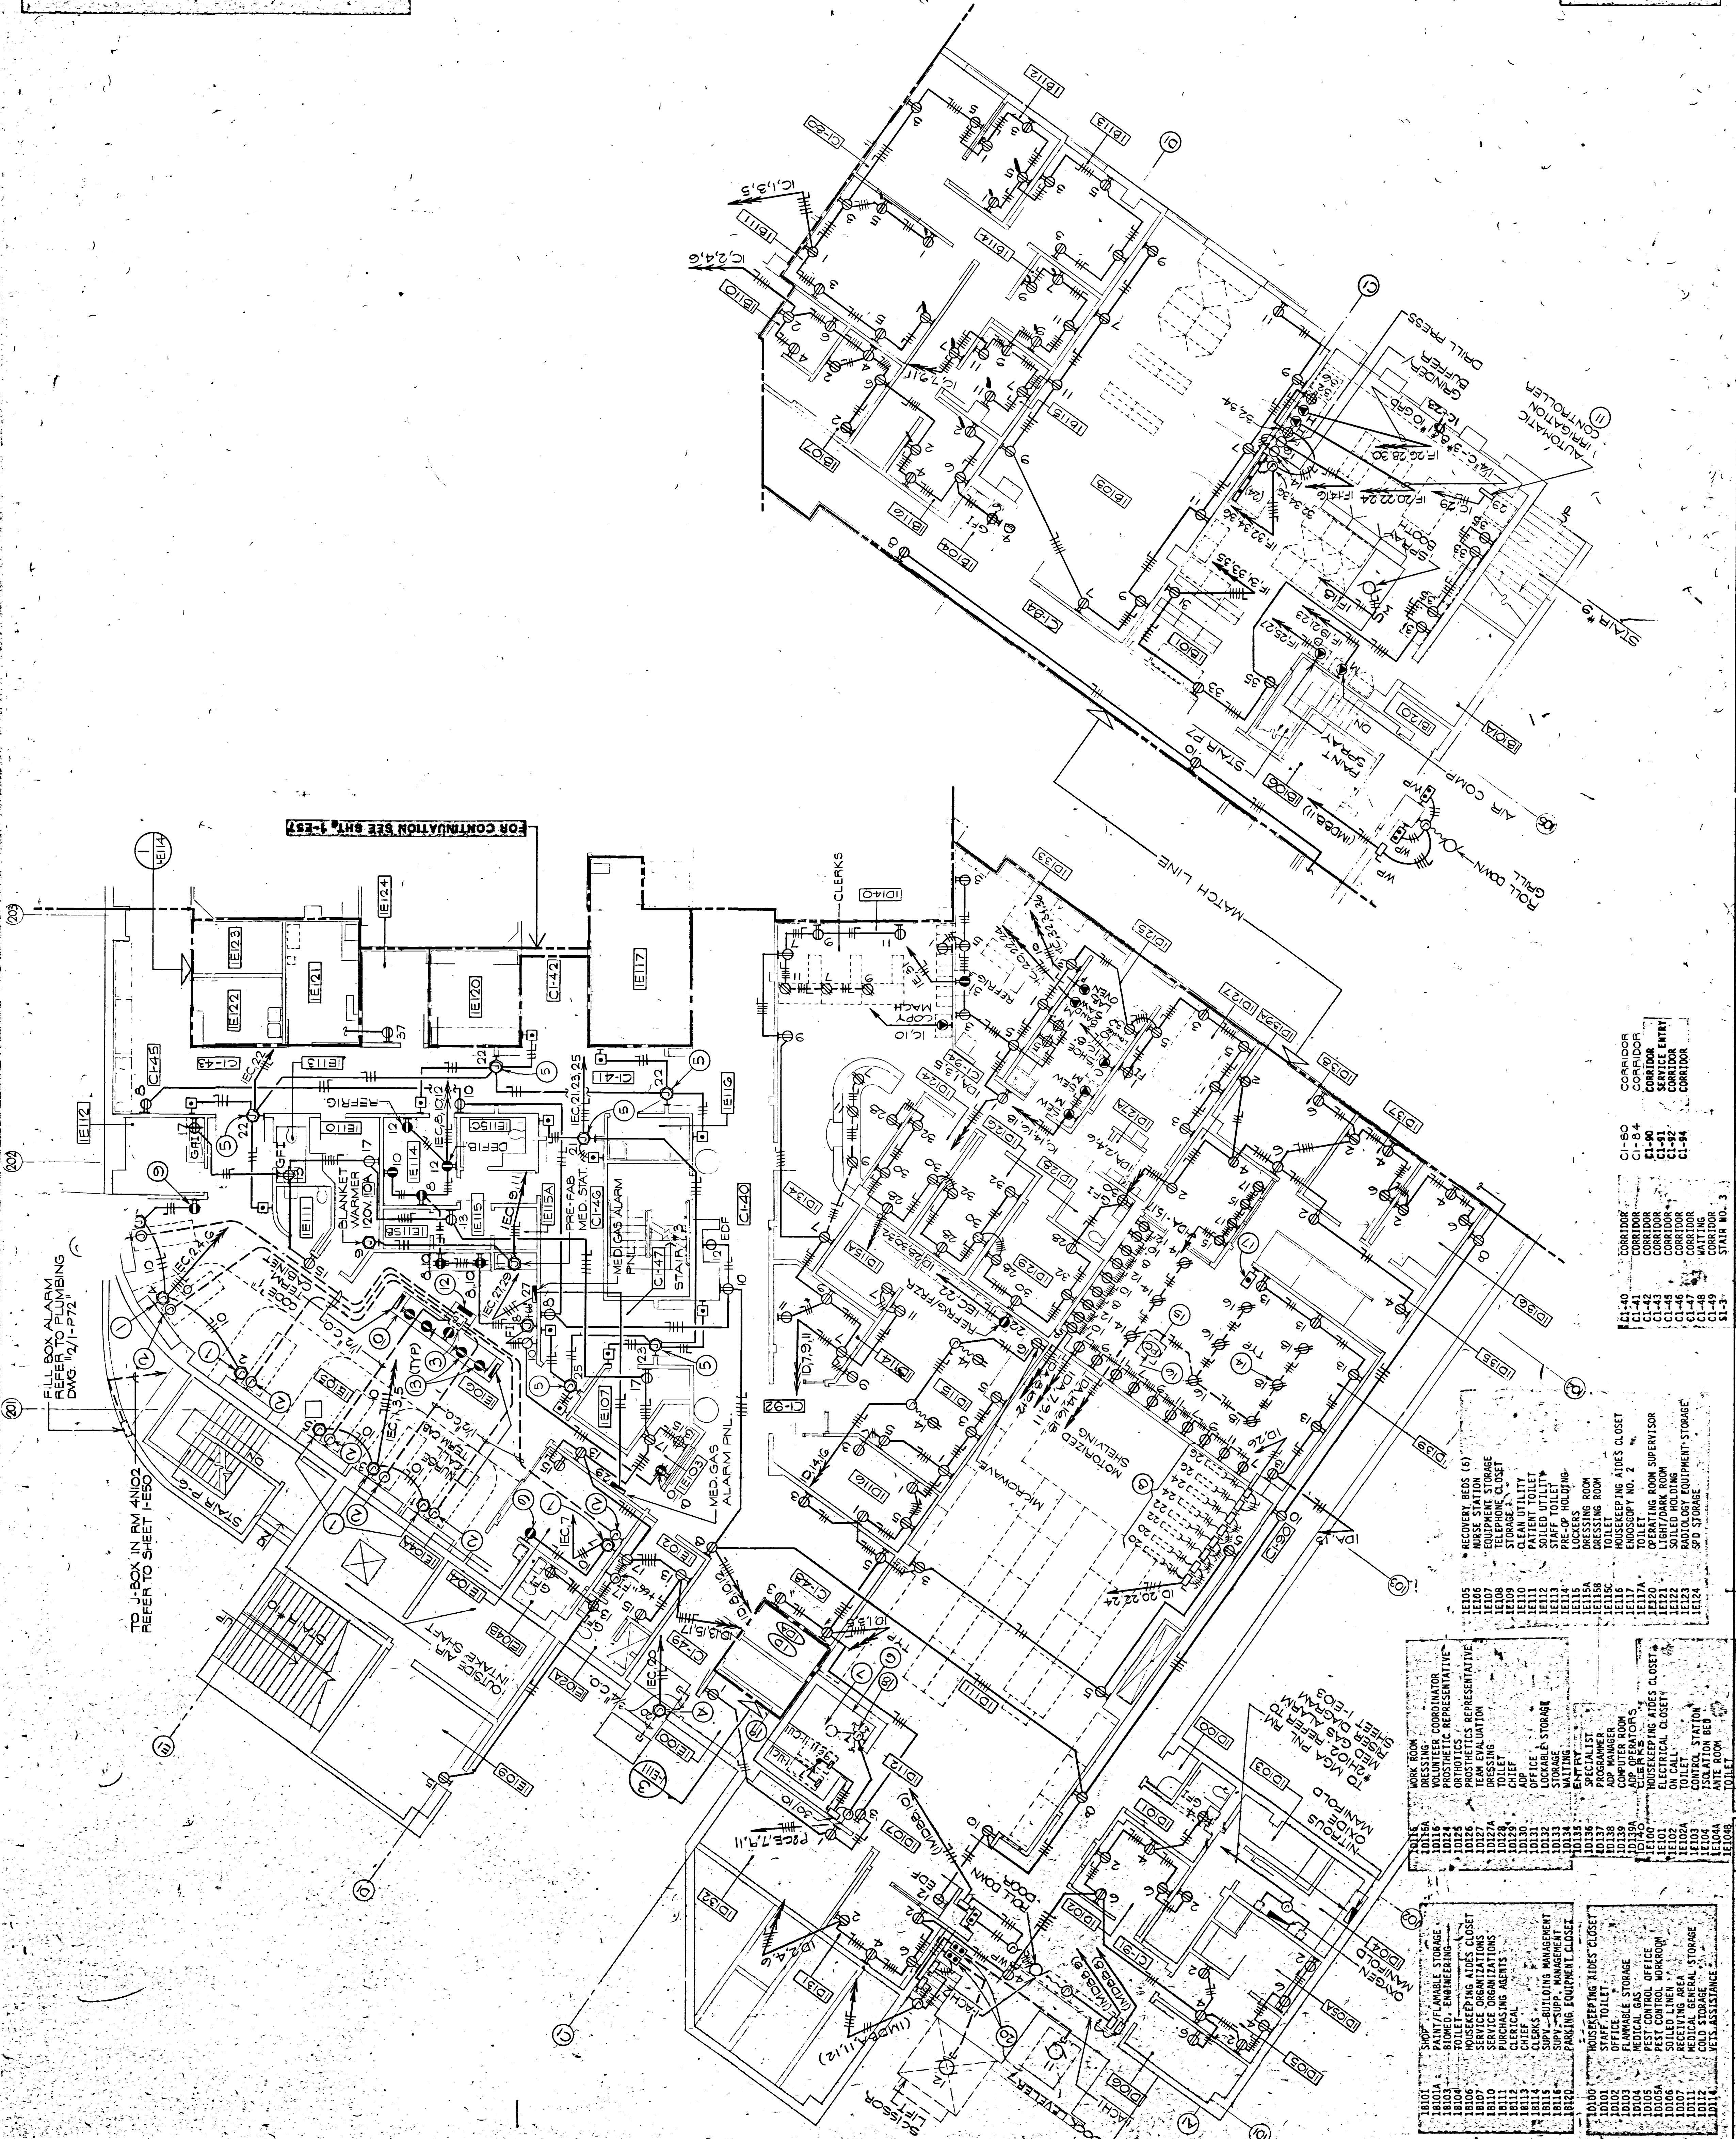
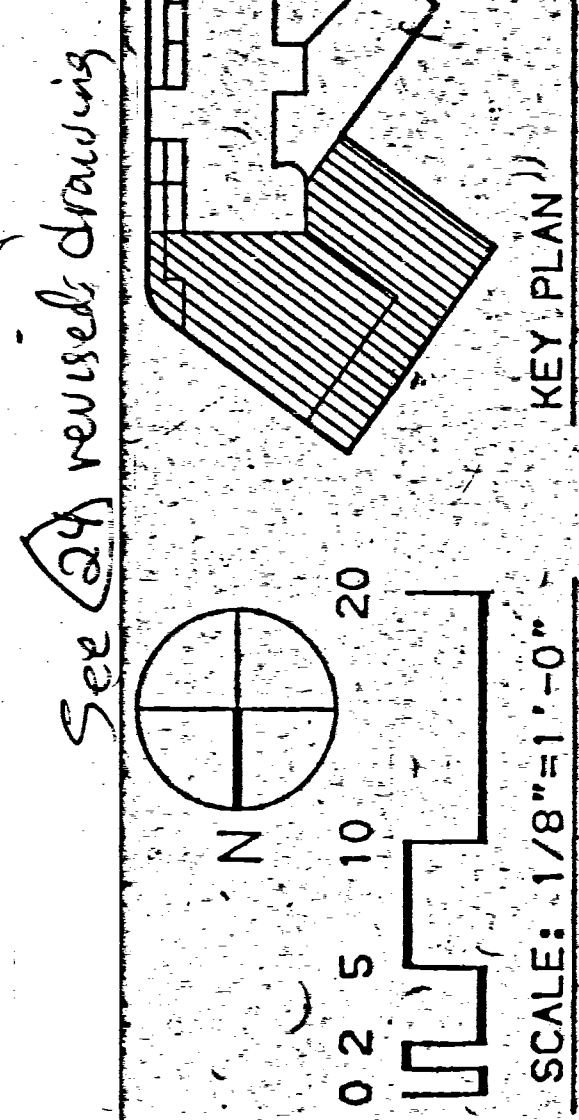

 


- [illegible]



18001	SHOP	10100	HOUSEKEEPING AIDS CLOSET
18002	PAINT/FINISHES STORAGE	10101	STAFF TOILET
18003	ELECTRICAL ENGINEERING	10102	TOILET
18004	TOILET	10103	FLAMMABLE STORAGE
18006	HOUSEKEEPING AIDS CLOSET	10104	MEDICAL GAS
18007	SERVICE ORGANIZATIONS	10105	PEST CONTROL OFFICE
18008	TOILET	10106	POILED LINEN
18011	PURCHASING AGENTS	10107	RECEIVING AREA
18112	CERAMIC	10108	HOUSEKEEPING AIDS CLOSET
18113	CLERICAL	10109	ELECTRICAL CLOSET
18114	CLERKS	10110	TOILET
18115	SUPV.-BUILDING MANAGEMENT	10111	CONTROL STATION
18116	SUPV.-SUPP. MANAGEMENT	10112	COLD STORAGE
18117	PAKING EQUIPMENT CLOSET	10113	PETS ASSISTANCE
18118	CLERICAL	10114	TOILET
10119	TOILET	10120	HOUSEKEEPING AIDS CLOSET
10121	TOILET	10121	ELECTRICAL CLOSET
10122	TOILET	10122	TOILET
10123	TOILET	10123	CONTROL STATION
10124	TOILET	10124	ANTS ROOM
10125	TOILET	10125	TOILET
10126	TOILET	10126	TOILET
10127	TOILET	10127	TOILET
10128	TOILET	10128	TOILET
10129	TOILET	10129	TOILET
10130	TOILET	10130	TOILET
10131	TOILET	10131	TOILET
10132	TOILET	10132	TOILET
10133	TOILET	10133	TOILET
10134	TOILET	10134	TOILET
10135	TOILET	10135	TOILET
10136	TOILET	10136	TOILET
10137	TOILET	10137	TOILET
10138	TOILET	10138	TOILET
10139	TOILET	10139	TOILET
10140	TOILET	10140	TOILET
10141	TOILET	10141	TOILET
10142	TOILET	10142	TOILET
10143	TOILET	10143	TOILET
10144	TOILET	10144	TOILET
10145	TOILET	10145	TOILET
10146	TOILET	10146	TOILET
10147	TOILET	10147	TOILET
10148	TOILET	10148	TOILET
10149	TOILET	10149	TOILET
10150	TOILET	10150	TOILET

BOBBROW/THOMAS AND ASSOCIATES, INC. ARCHITECTS/PLANNERS/CONSULTANTS 1001 WESTWOOD BOULEVARD LOS ANGELES, CALIFORNIA 90024				CYNGA CONSULTING ENGINEERS 33 FLORENCE ENGINEER MECHANICAL AND ELECTRICAL SUITE 309 1180 SOUTH BEVERLY DRIVE MARINA DEL REY, CA 90291 LOS ANGELES, CA 90035		HAYAKAWA ASSOCIATES CONSULTING ENGINEERS 1180 SOUTH BEVERLY DRIVE MARINA DEL REY, CA 90291 LOS ANGELES, CA 90035	
Drawing Title LEVEL 1 NORTH POWER PLAN		Project Title NEW OUTPATIENT CLINIC BUILDING		Date AUG. 9, 1988		Project No. 752-002	
Approved Project Director 		Building Number 1		Checked SKT		Drawn PGB, N.N.	
Drawing No. 1E56		Location LOS ANGELES, CALIFORNIA		Revision 1		Date Aug. 30, 1988	